


# Eldridge Street Synagogue

## Interior Restoration Lighting

Eldridge Street Project  
12 Eldridge Street  
New York, NY 10002

ISSUED FOR BID

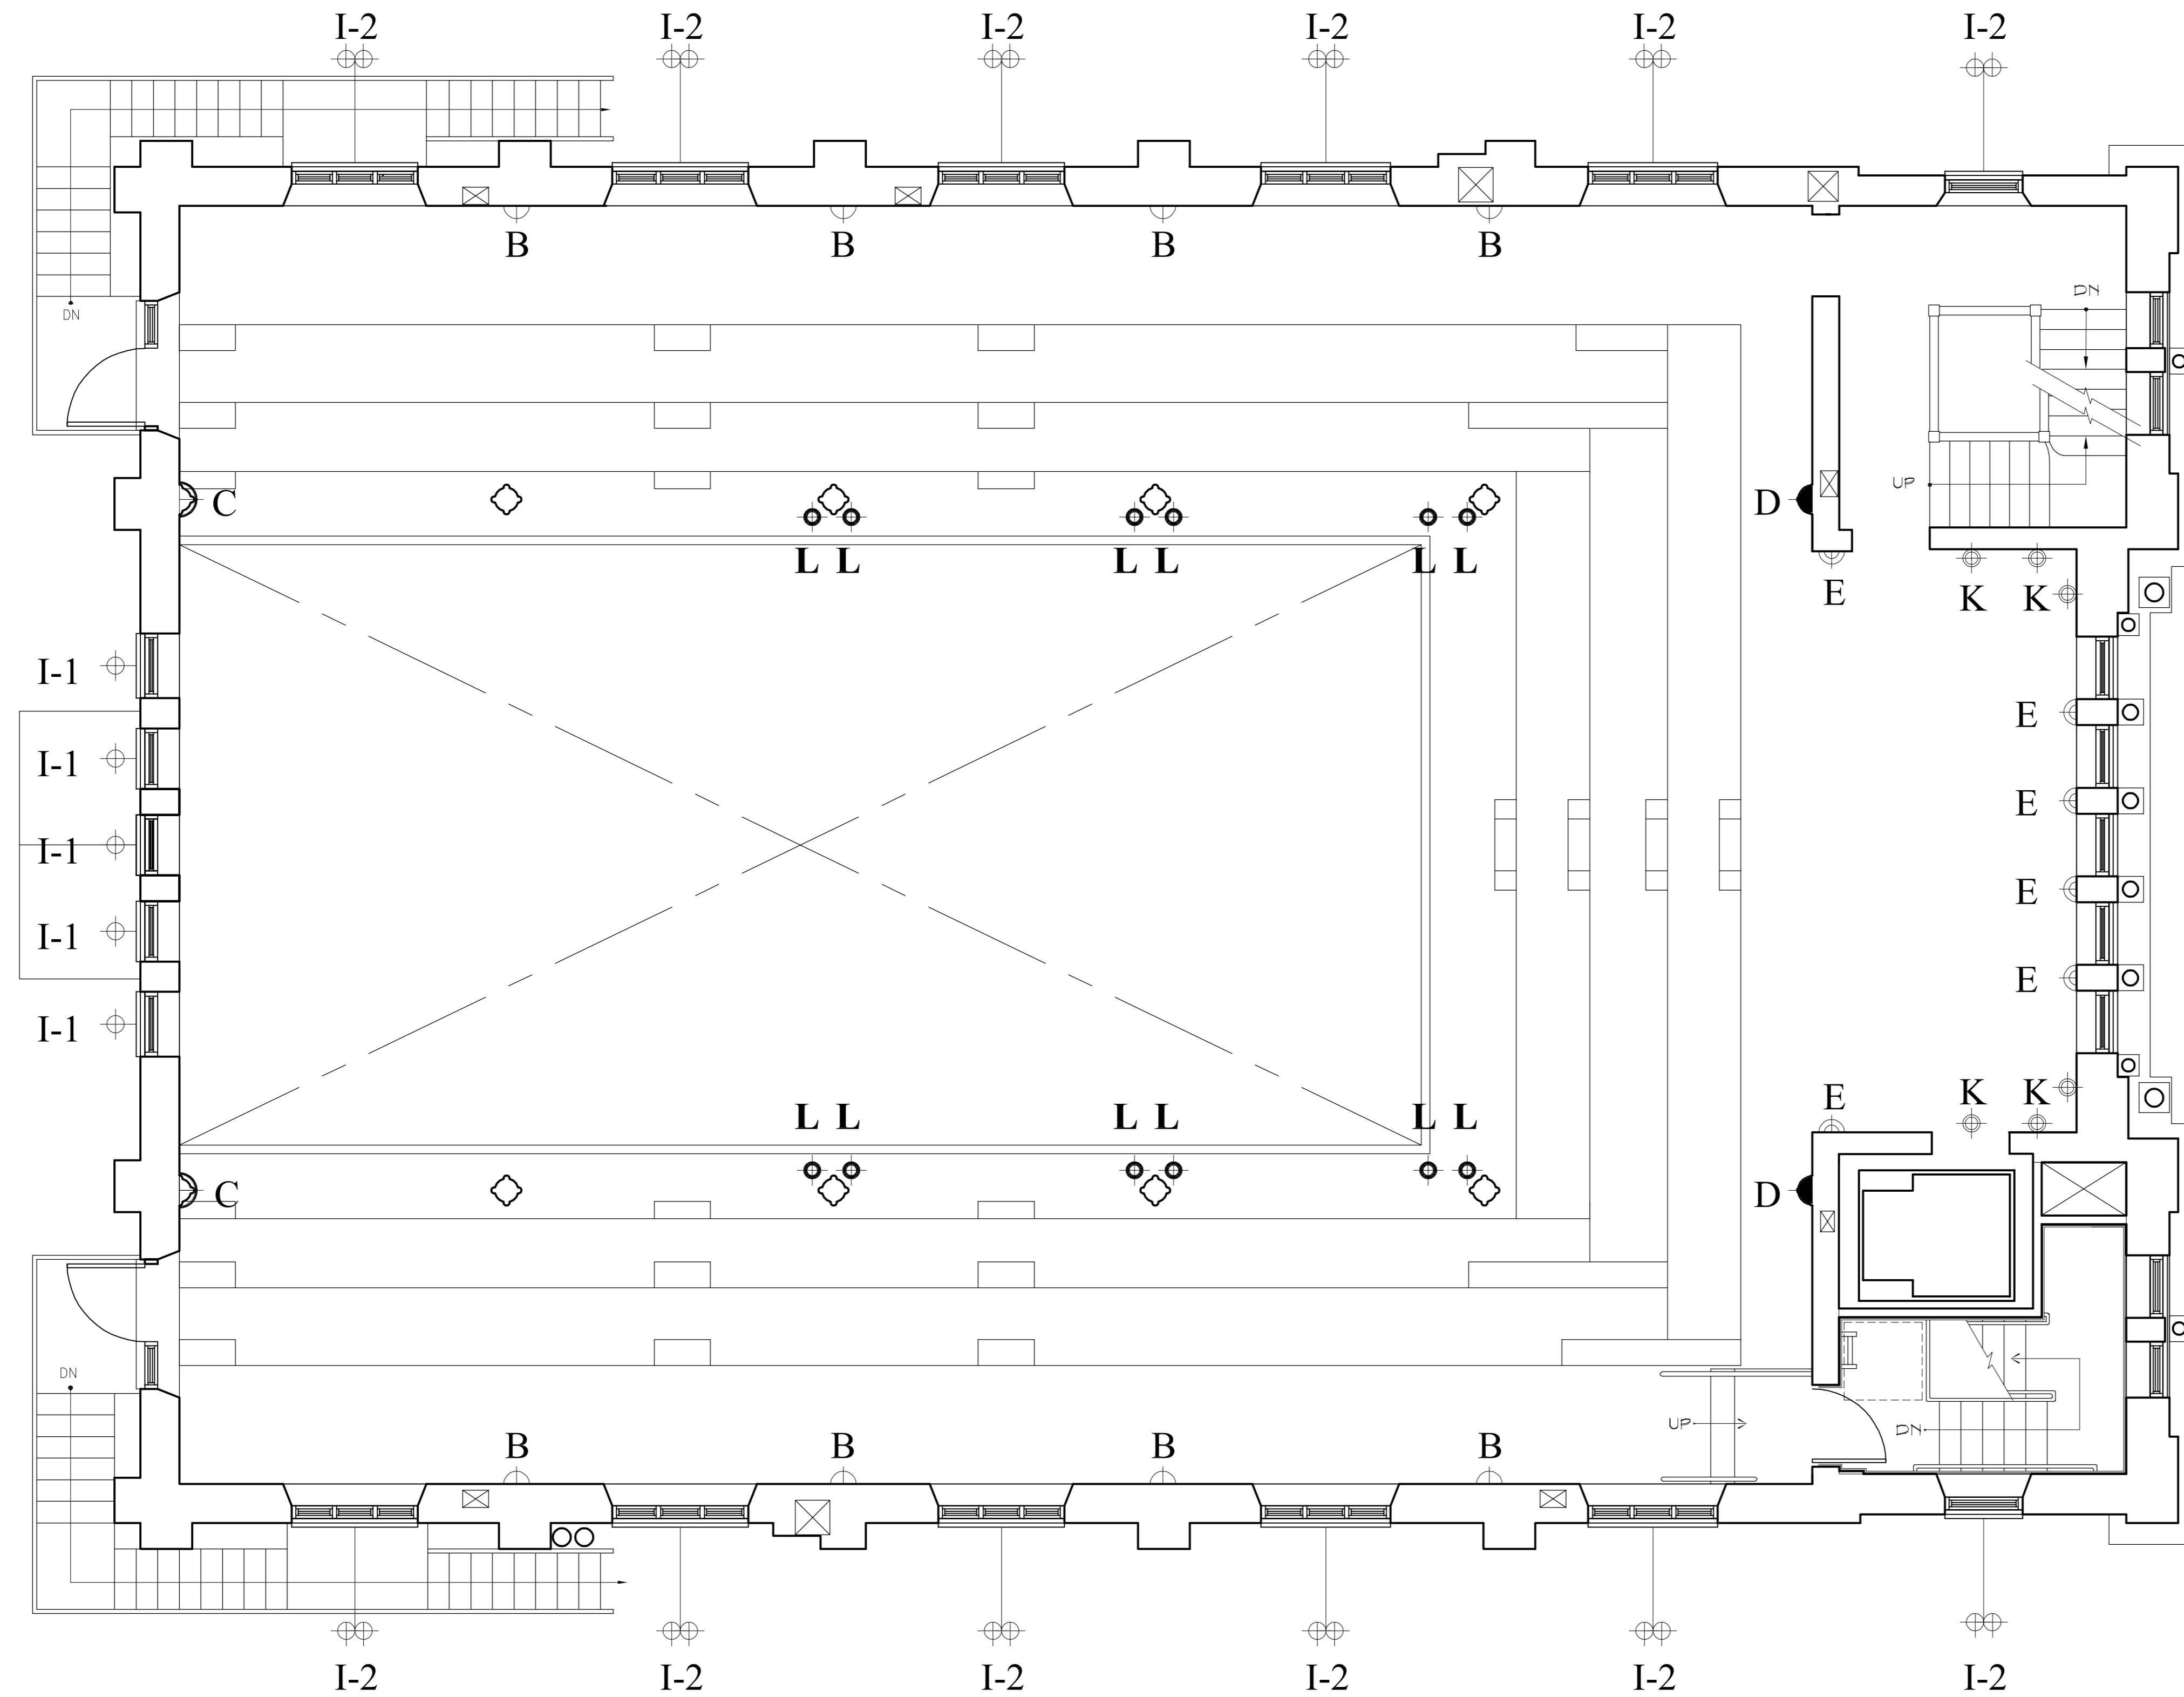

ISSUED FOR LMDC REVIEW 6/15/07  
Issue/Revision Date

Date **June 15, 2007**



Scale 0' 1' 3' 6' 12'

Sheet Title **Balcony Floor Lighting Plan** Drawing No. **A-2**

H:\Eldridge Street - Project\3234\Drawings\Lighting\New Folder\A-2-BALCONY.dwg Jun 15, 2007 - 4:59pm