



RECEIVED
 DEC 19 2001
 GILBANE




3	7/18/98	Updated for Deutsche Credit Survey
1	7/1/98	Project #80001902 - Center Strip
3	6/1/98	Project #80003300 - Emergency Staircases
2	5/19/98	Project #80001400 - Debris Center
1	8/10/94	Project #80002213 - Debris Center
Rev.	Chg.	Approved


Deutsche Bank


130 LIBERTY STREET

1st FLOOR CEILING PLAN

Sheet No.	Project No.
Revision No.	Date
Scale	1/8" = 1'-0"
Drawn	9/1/98
Checked	
Approved	

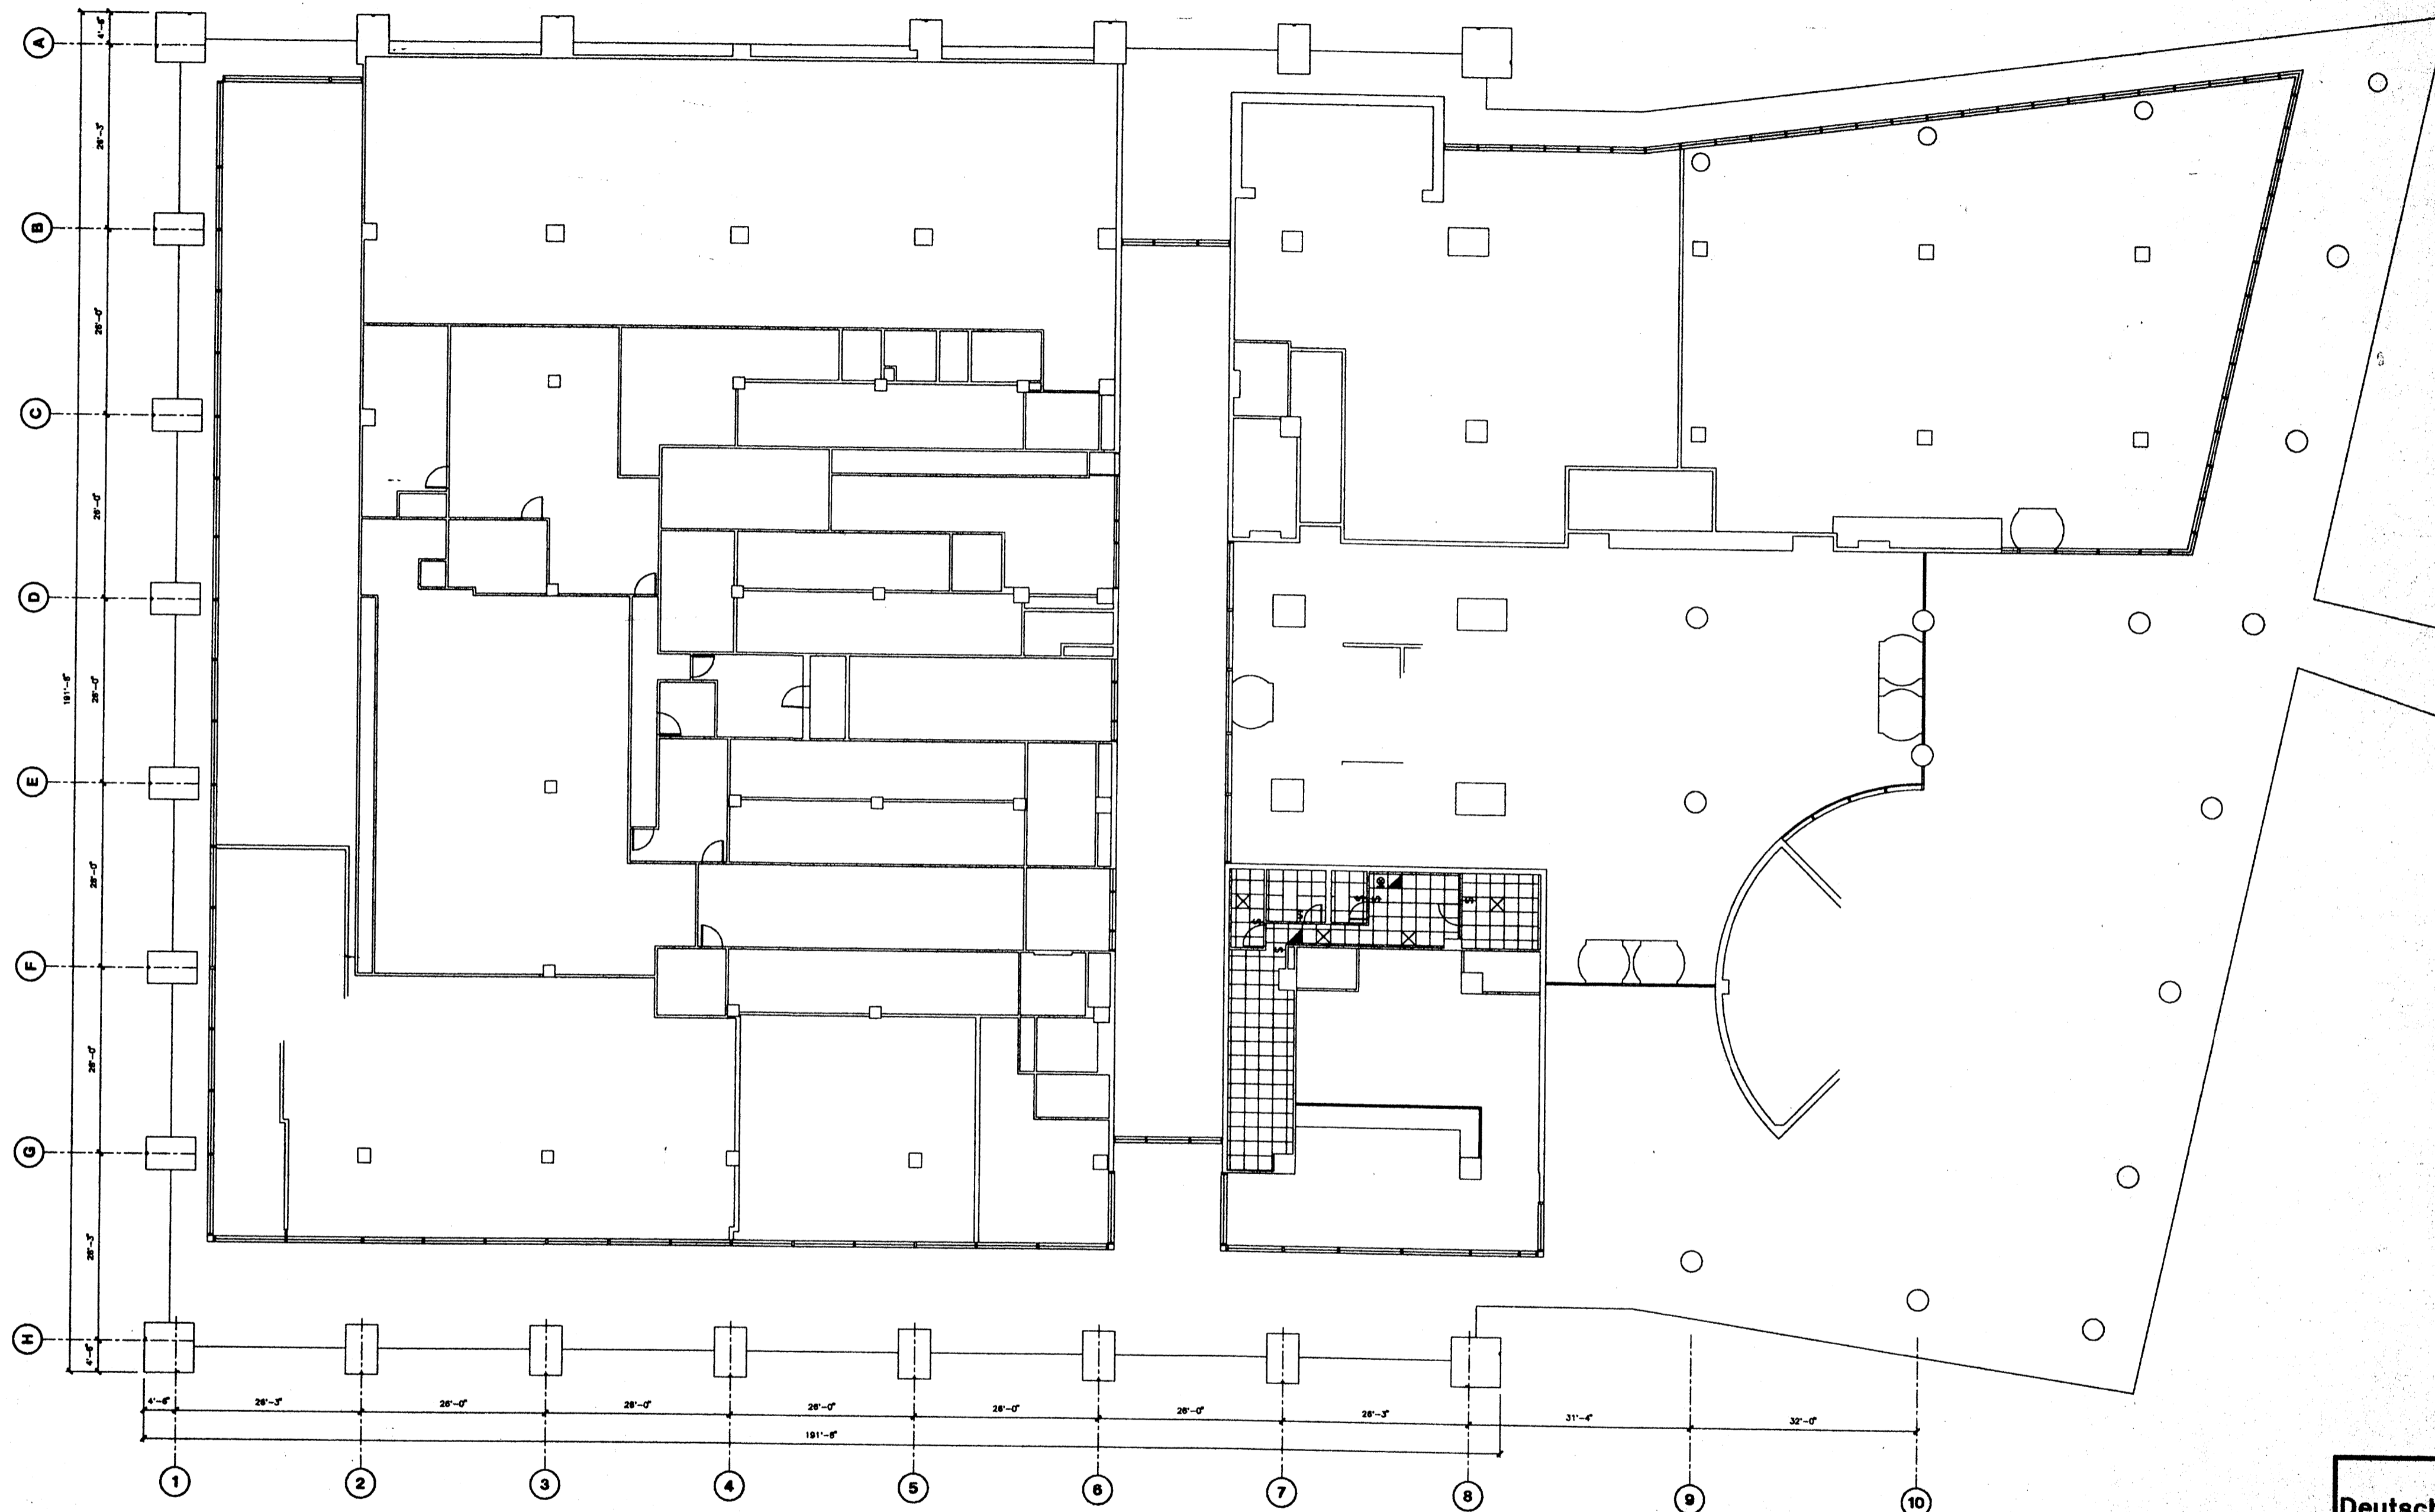

Deutsche Bank 
130 LIBERTY STREET
MEZZANINE CEILING PLAN
 Date: 7/1/98
 Project No.:

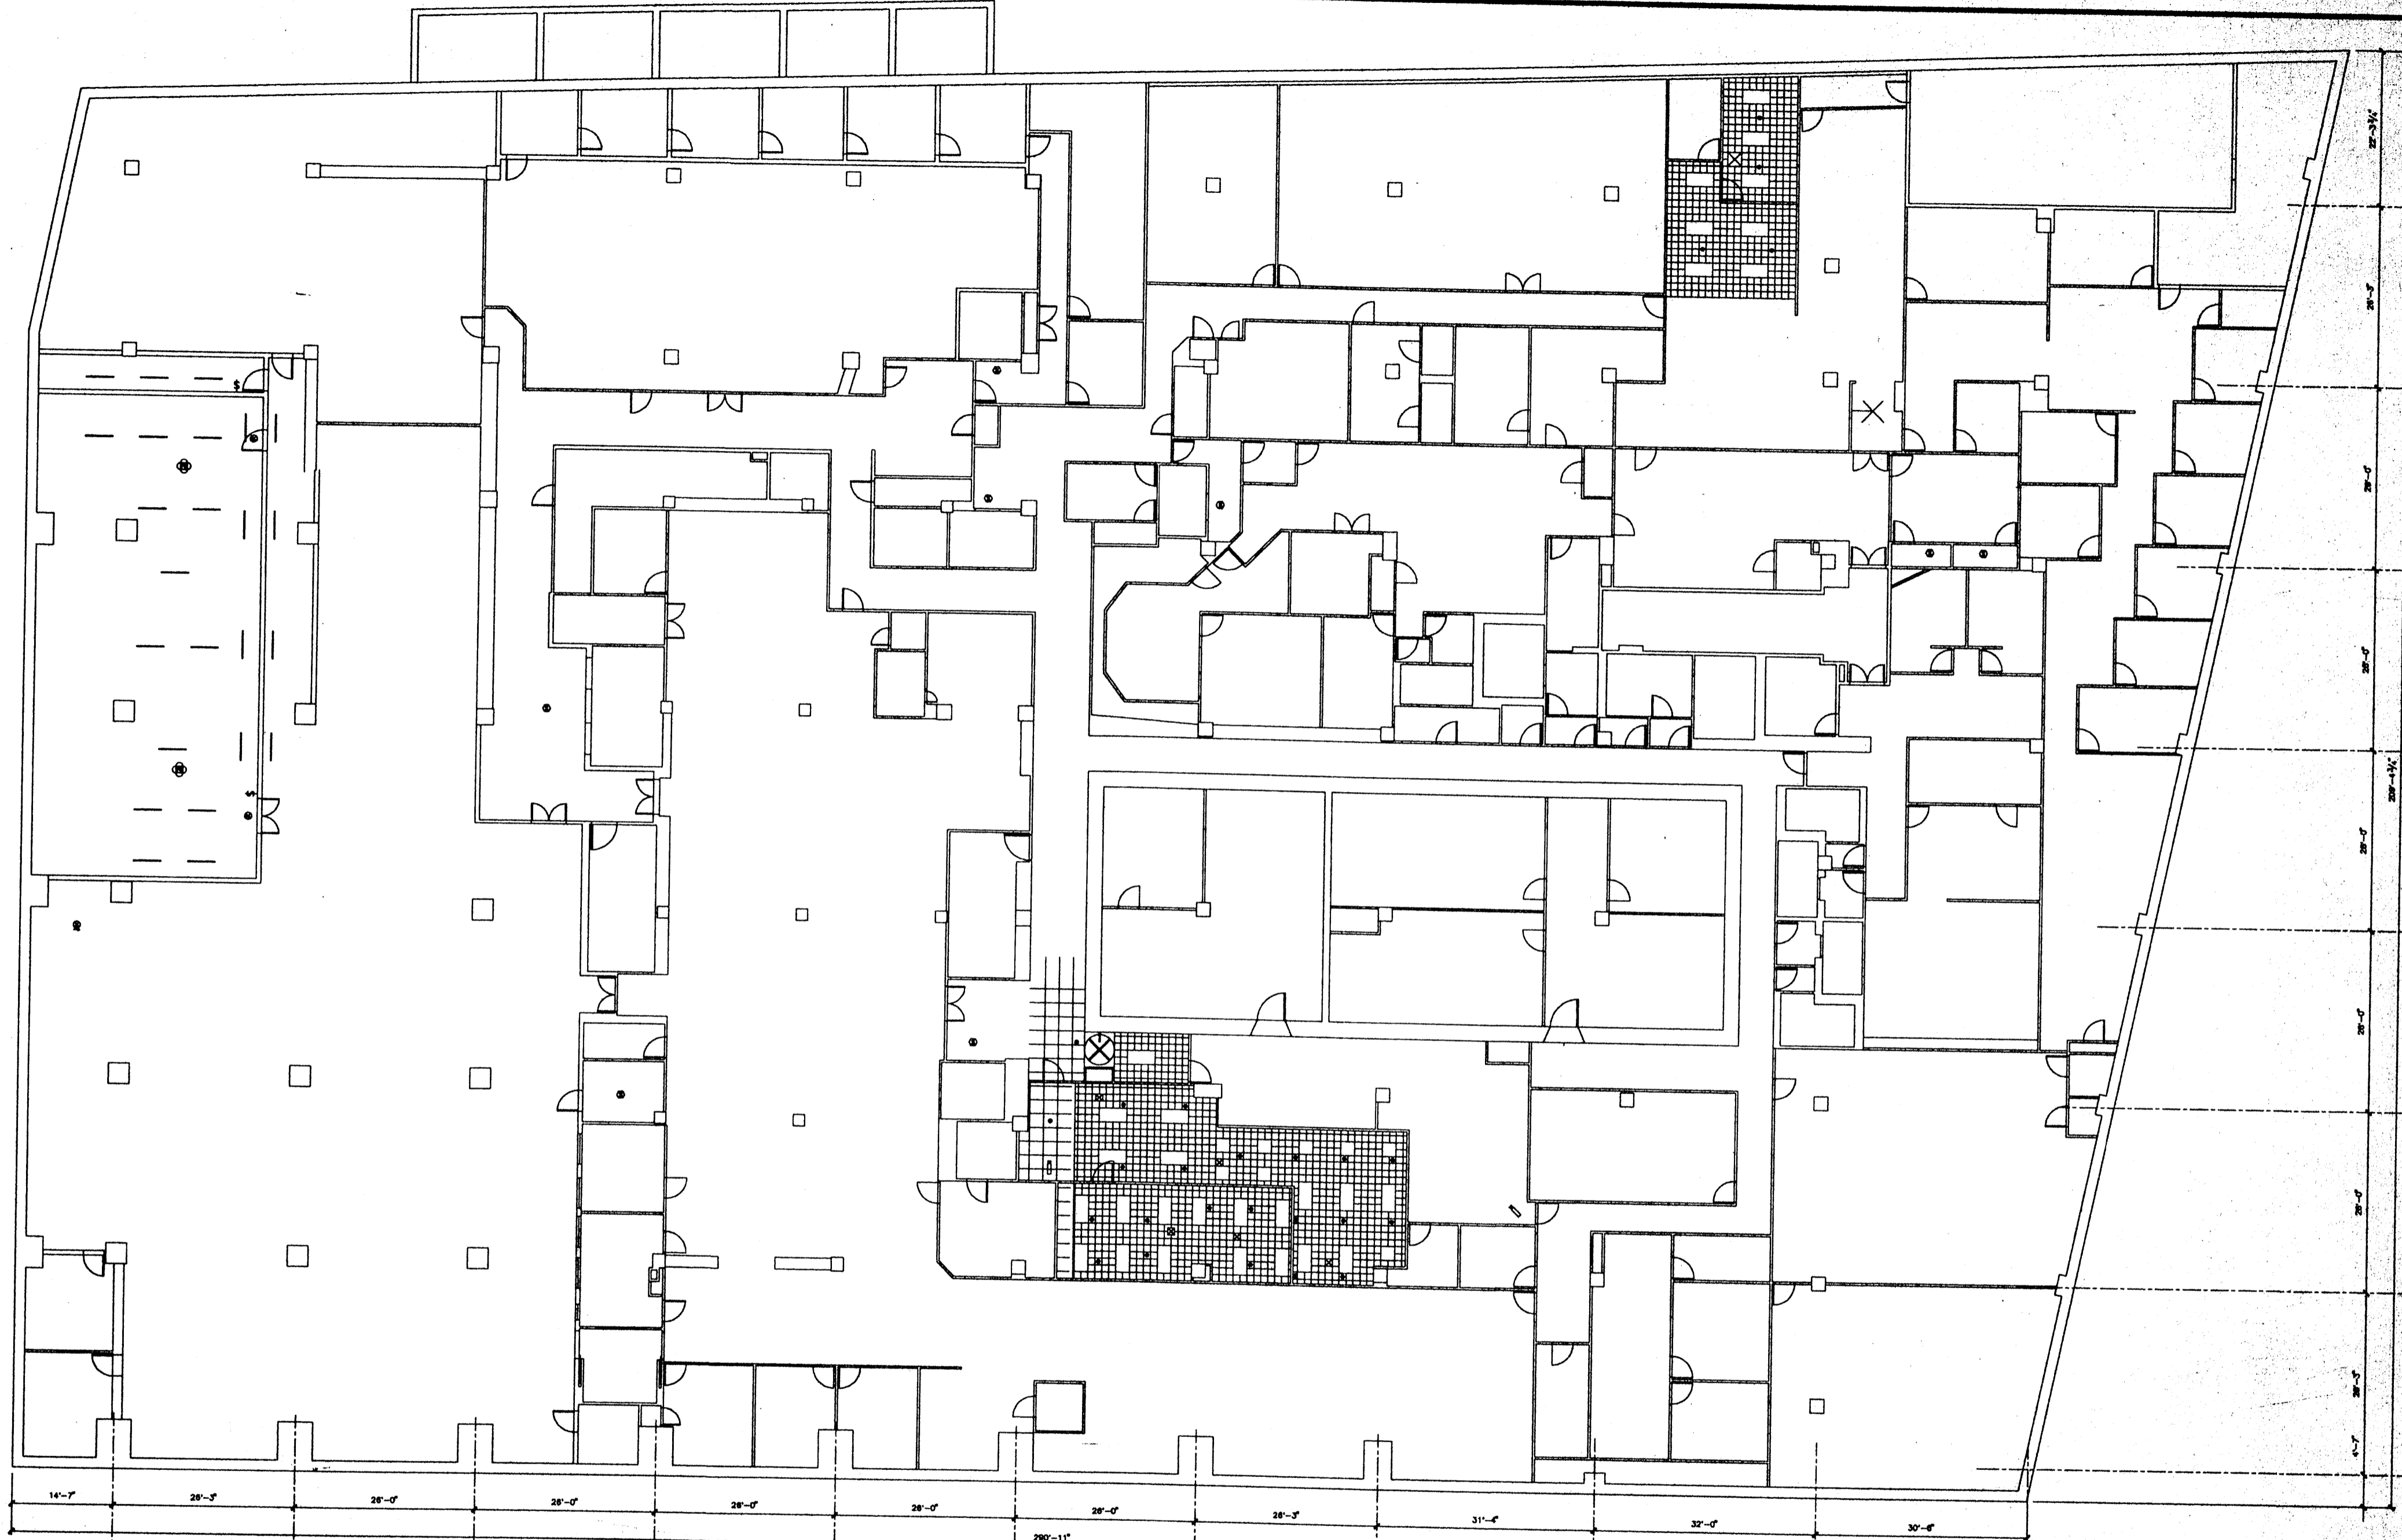


14'-7" 28'-5" 28'-0" 28'-0" 28'-0" 28'-0" 28'-0" 28'-0" 28'-0" 31'-4" 32'-0" 30'-4"

1 2 3 4 5 6 7 8 9 10 11

Deutsche Bank
 130 LIBERTY STREET
 CELLAR A
 CEILING PLAN

3	6/1/01	Updated for Existing Conditions	DATE
2	12/16/99	Updated for Electric Closet Survey	DATE
1	9/17/99	Project #200003000 - Emergency Alterations	DATE 9/1/01
DR	DATE	DESCRIPTION	PROJECT NO.



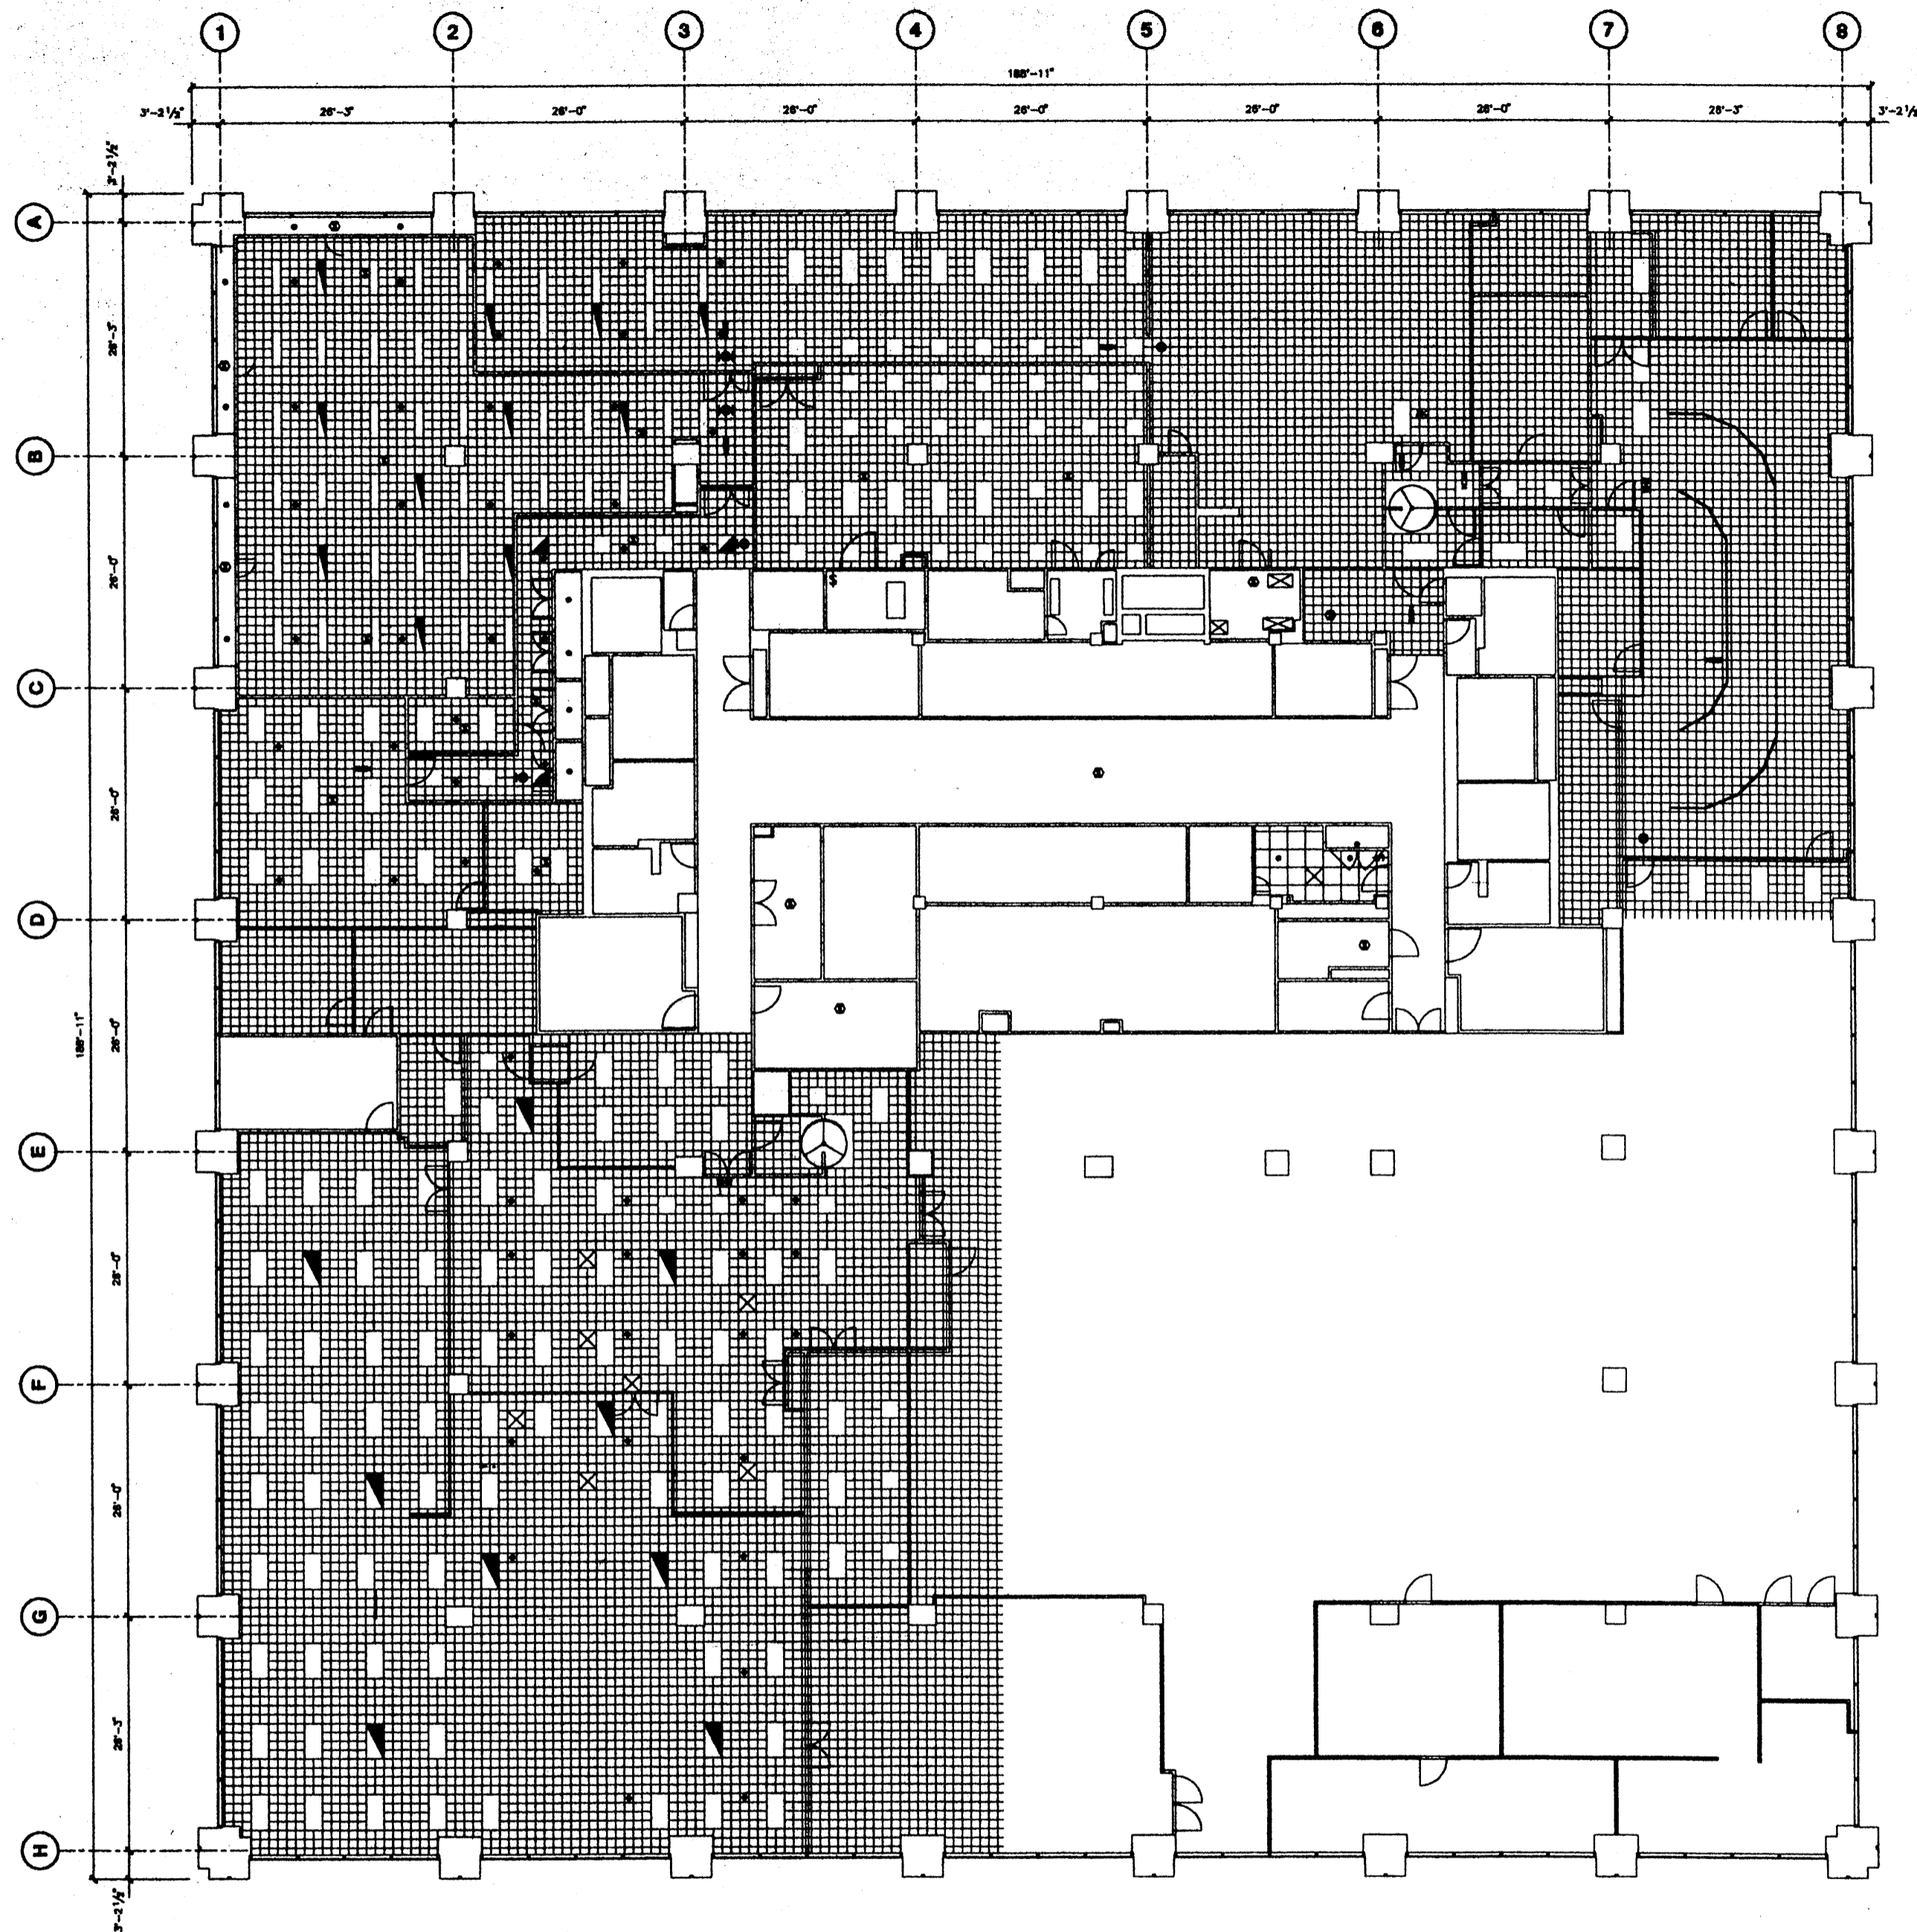

Deutsche Bank


No.	Date	Description
1	8/1/83	Project RECONSTRUCT - 39th Floor Office Area Plan
2	8/1/84	Project RECONSTRUCT - 39th Floor Office Area Plan
3	8/1/86	Updated for Existing Conditions
4	10/28/88	Updated for New Computer Room
5	2/1/89	Project RECONSTRUCT - 39th Floor Office Area Plan
6	7/15/89	Updated for Deutsche Credit Survey
7	12/18/89	Updated for Existing Conditions

No.	Date	Issued To

PROJECT
130 LIBERTY STREET
 39th FLOOR
CEILING PLAN



Drawn By	
Checked By	
Date	12/15/88
Scale	
Project No.	

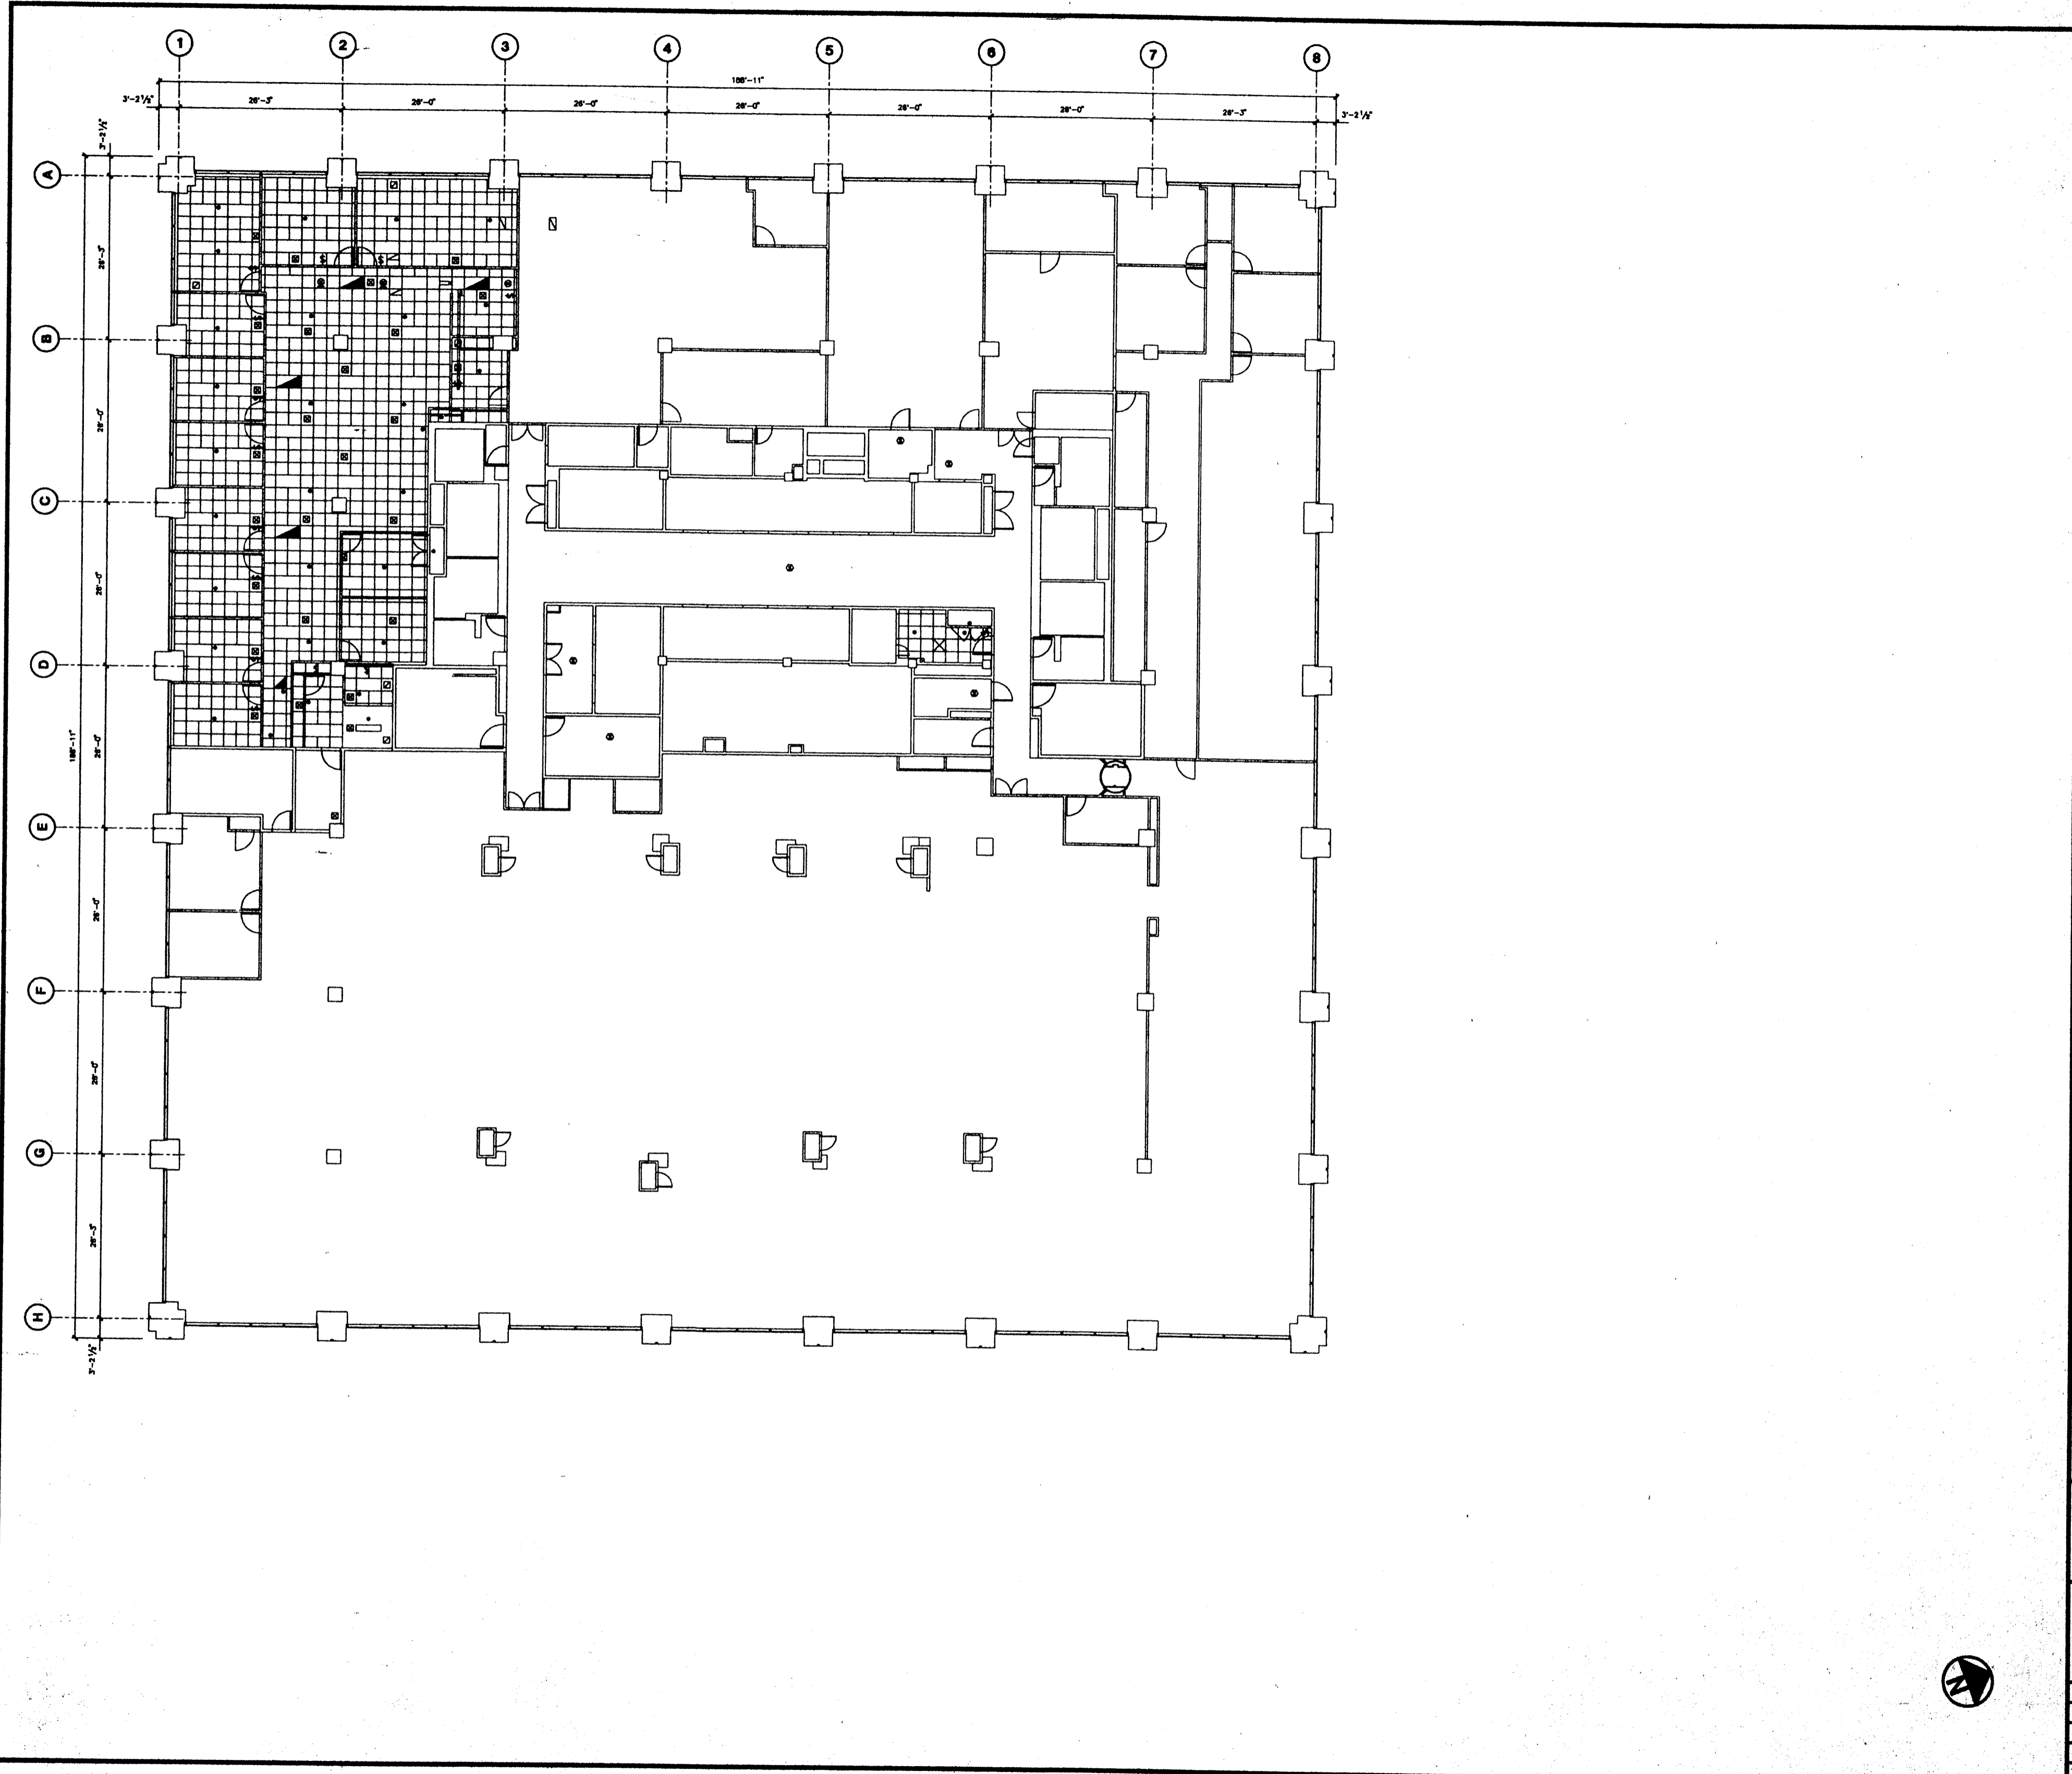

Deutsche Bank


No.	Date	Description
1	2/16/93	Project 82001678 - Addl. Changes
2	8/1/99	Updated for Existing Conditions
3	2/1/97	Project 84000769 - SCDD Redevelop
4	7/15/98	Updated for Electric Circuit Rework
5	12/18/99	Updated for Existing Conditions
6	9/1/01	Project 842864100 - Data Center Changes

No.	Date	Issued To

130 LIBERTY STREET

38th FLOOR CEILING PLAN

Drawn By	
Checked By	
Date	9/1/01
Scale	
Project No.	

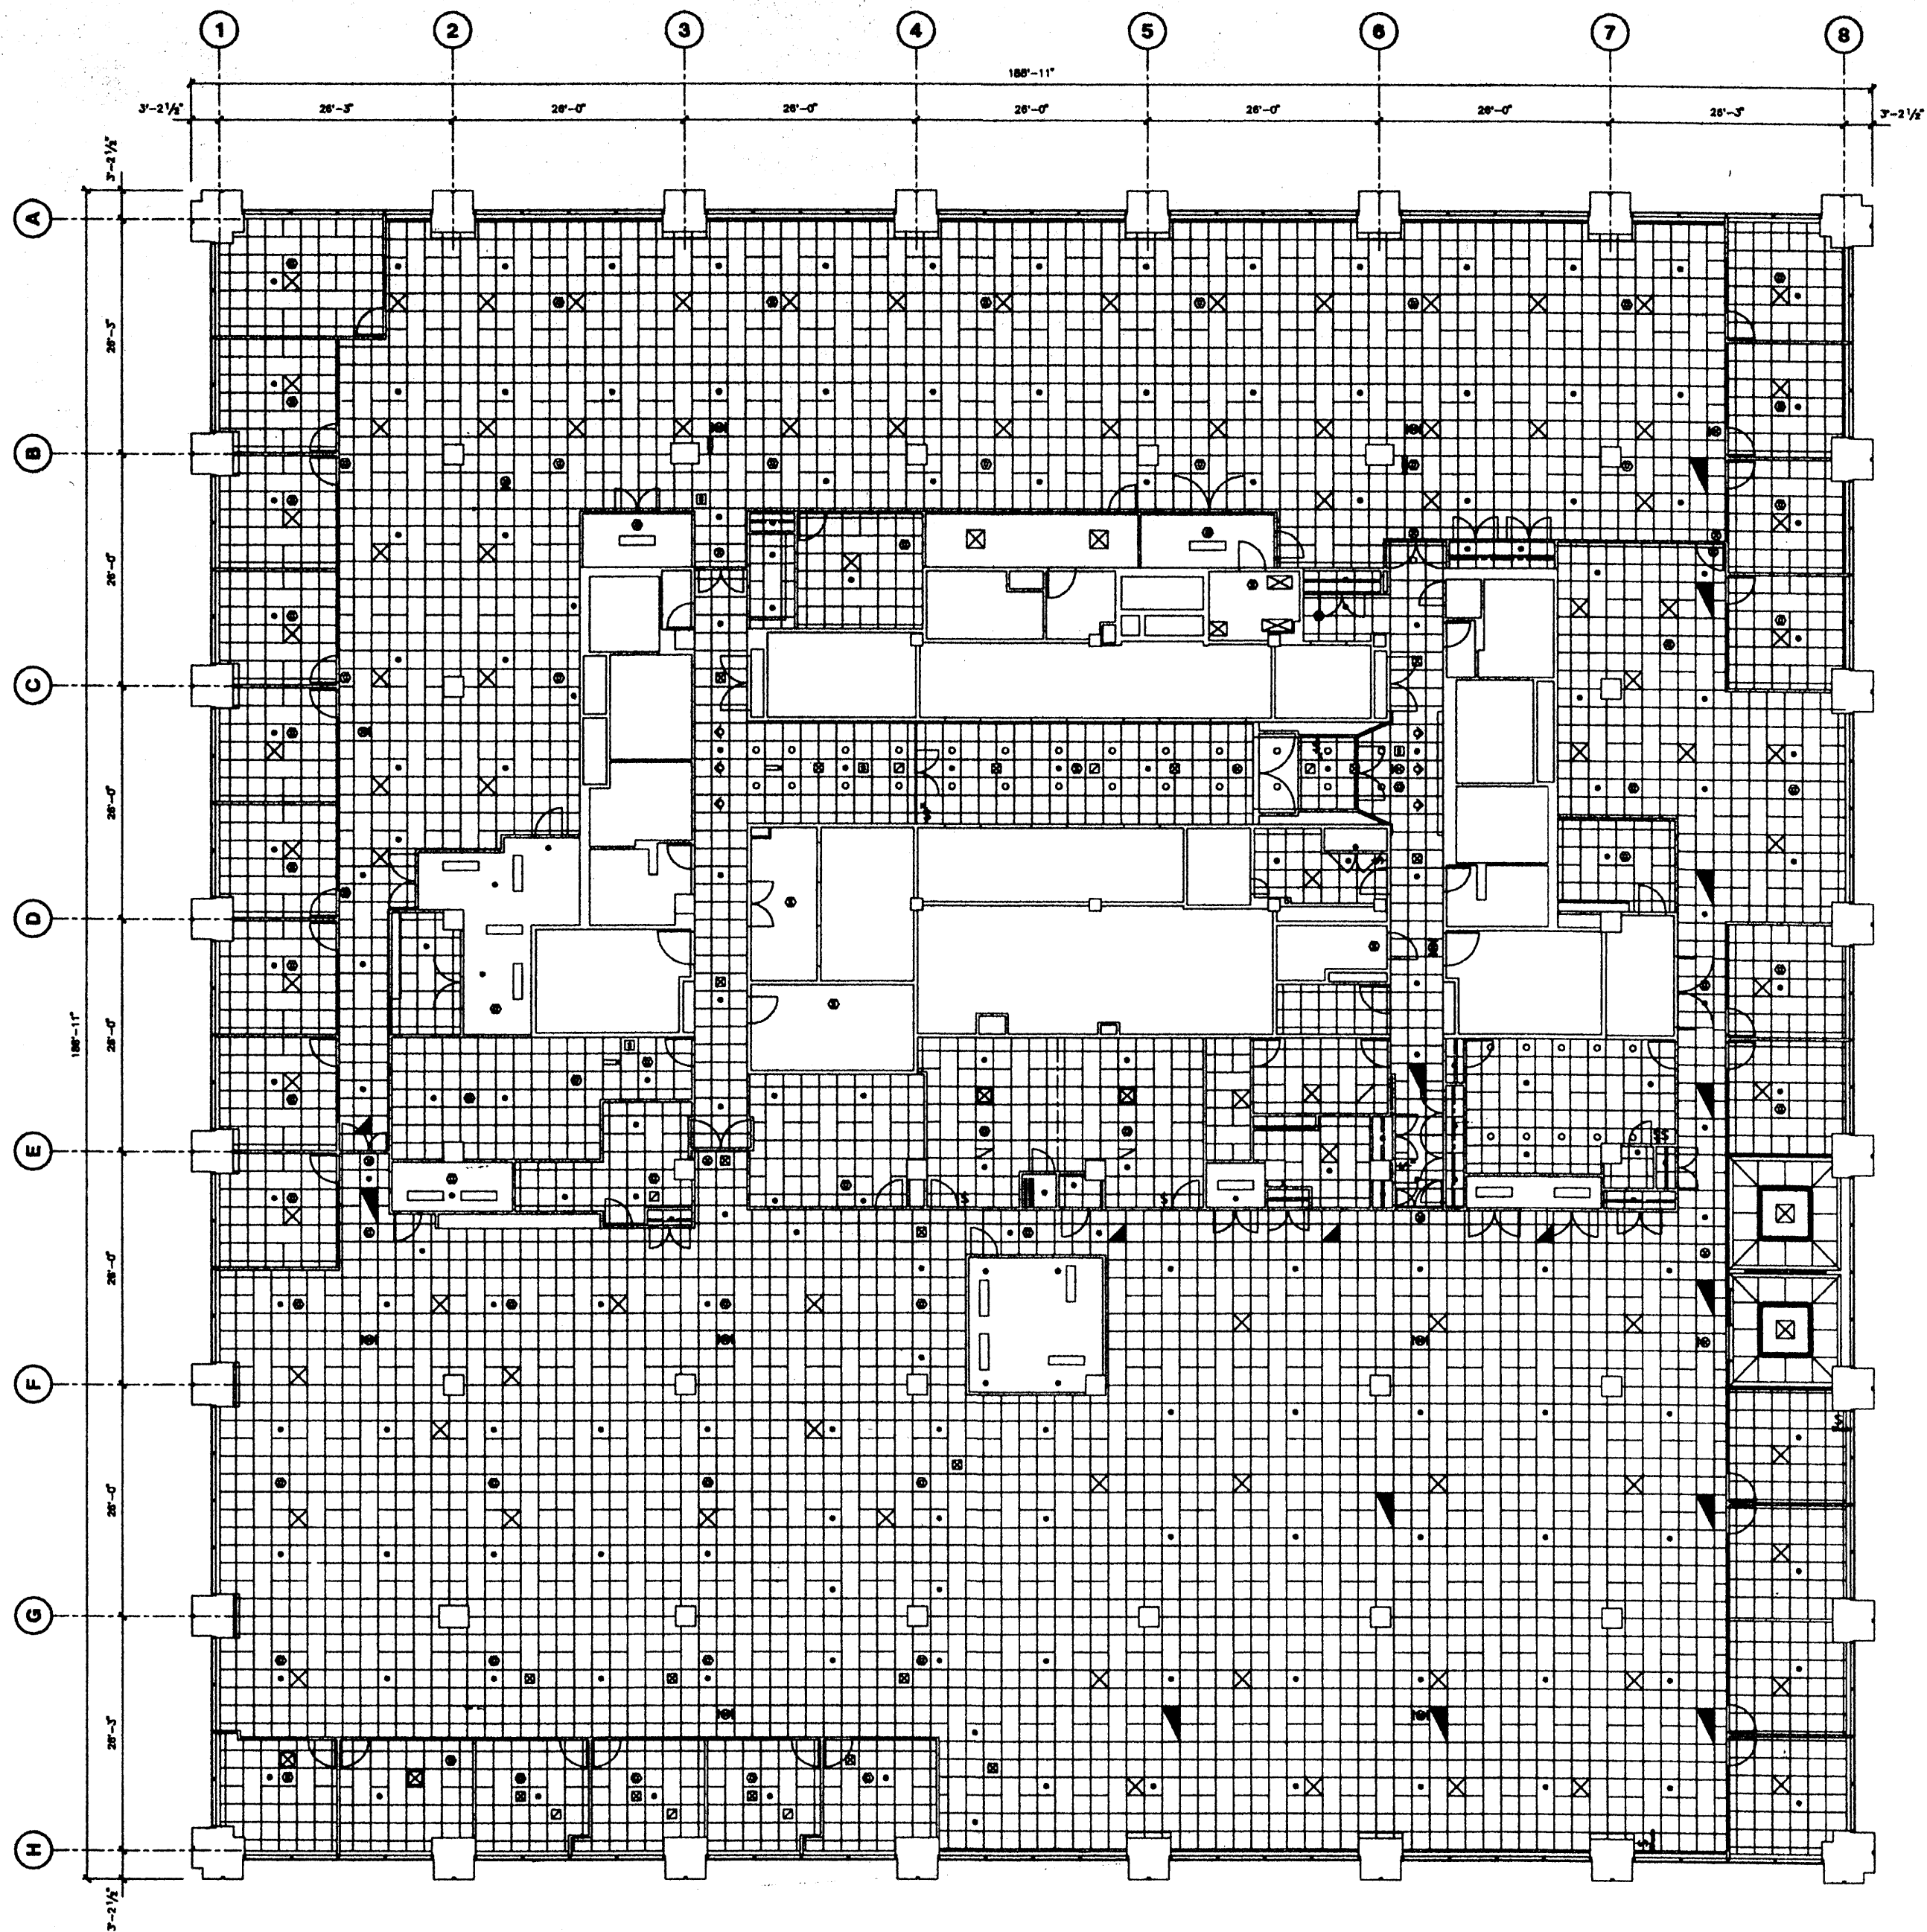


Deutsche Bank

No.	Date	Description
1	10/26/01	Updated for 1024 Worktable and Area Annotations
2	5/7/02	Project #00003715 - 37th Floor Rehabilitation
3	5/9/02	Project #00000008 - Lobby, Atrium, Restrooms
4	5/15/02	Project #00000113 - Trading Floor Expansion
5	2/1/07	Project #00000700 - Trading Floor Expansion & Elevators
6	12/10/07	Project #07001400 - Investment Partners Rehabilitation
7	7/13/08	Updated for Electric Chandeliers
8	8/10/09	Project #00003276 - 37th Rehabilitation

No.	Date	Issued To

PROJECT
130 LIBERTY STREET
 37th FLOOR
CEILING PLAN

Drawn By	
Checked By	
Date	9/20/09
Scale	
Project No.	

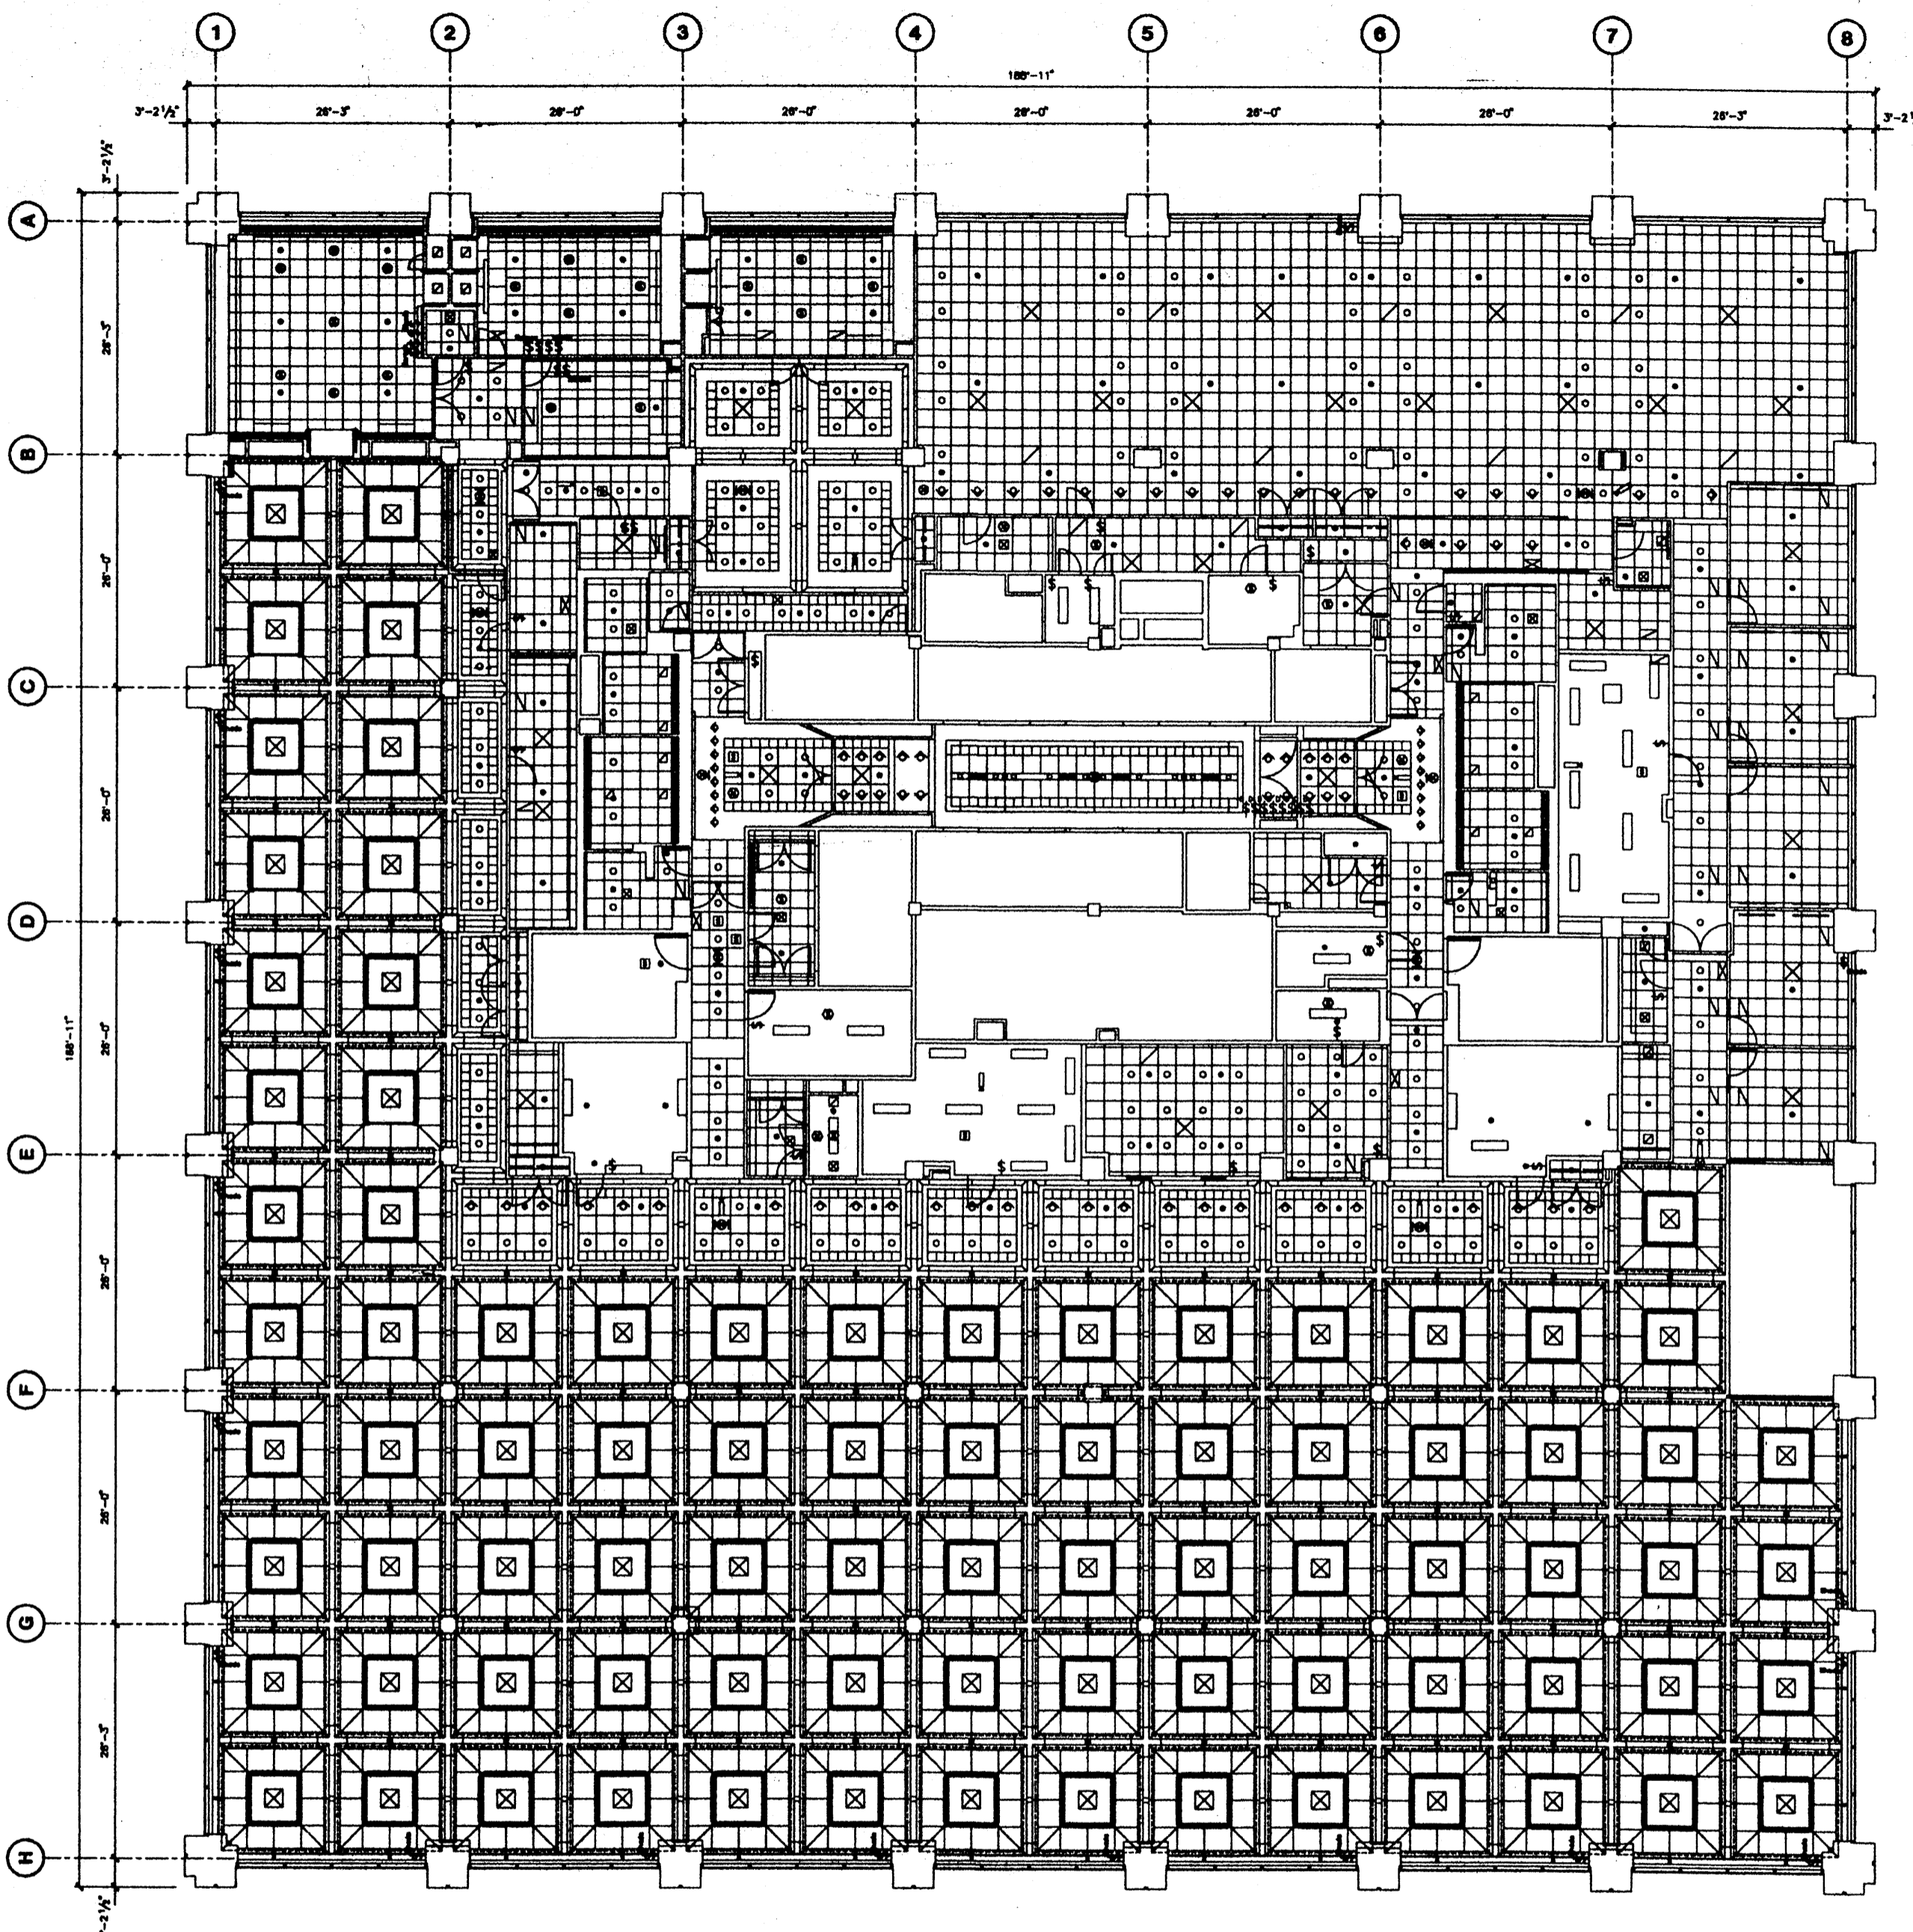

Deutsche Bank


No.	Date	Description
1	4/15/98	Revised Interior Construction
2	1/1/97	Project 50000798 - New Trading Floor - 36th
3	12/9/97	Project 570001582 - 36th Floor
4	7/15/98	Updated for Electric Load Survey
5	6/27/01	Project 102548.001 - Asset Management

No.	Date	Issued To

130 LIBERTY STREET
36th FLOOR CEILING PLAN

Drawn By	
Checked By	
Date	6/27/01
Scale	
Project No.	



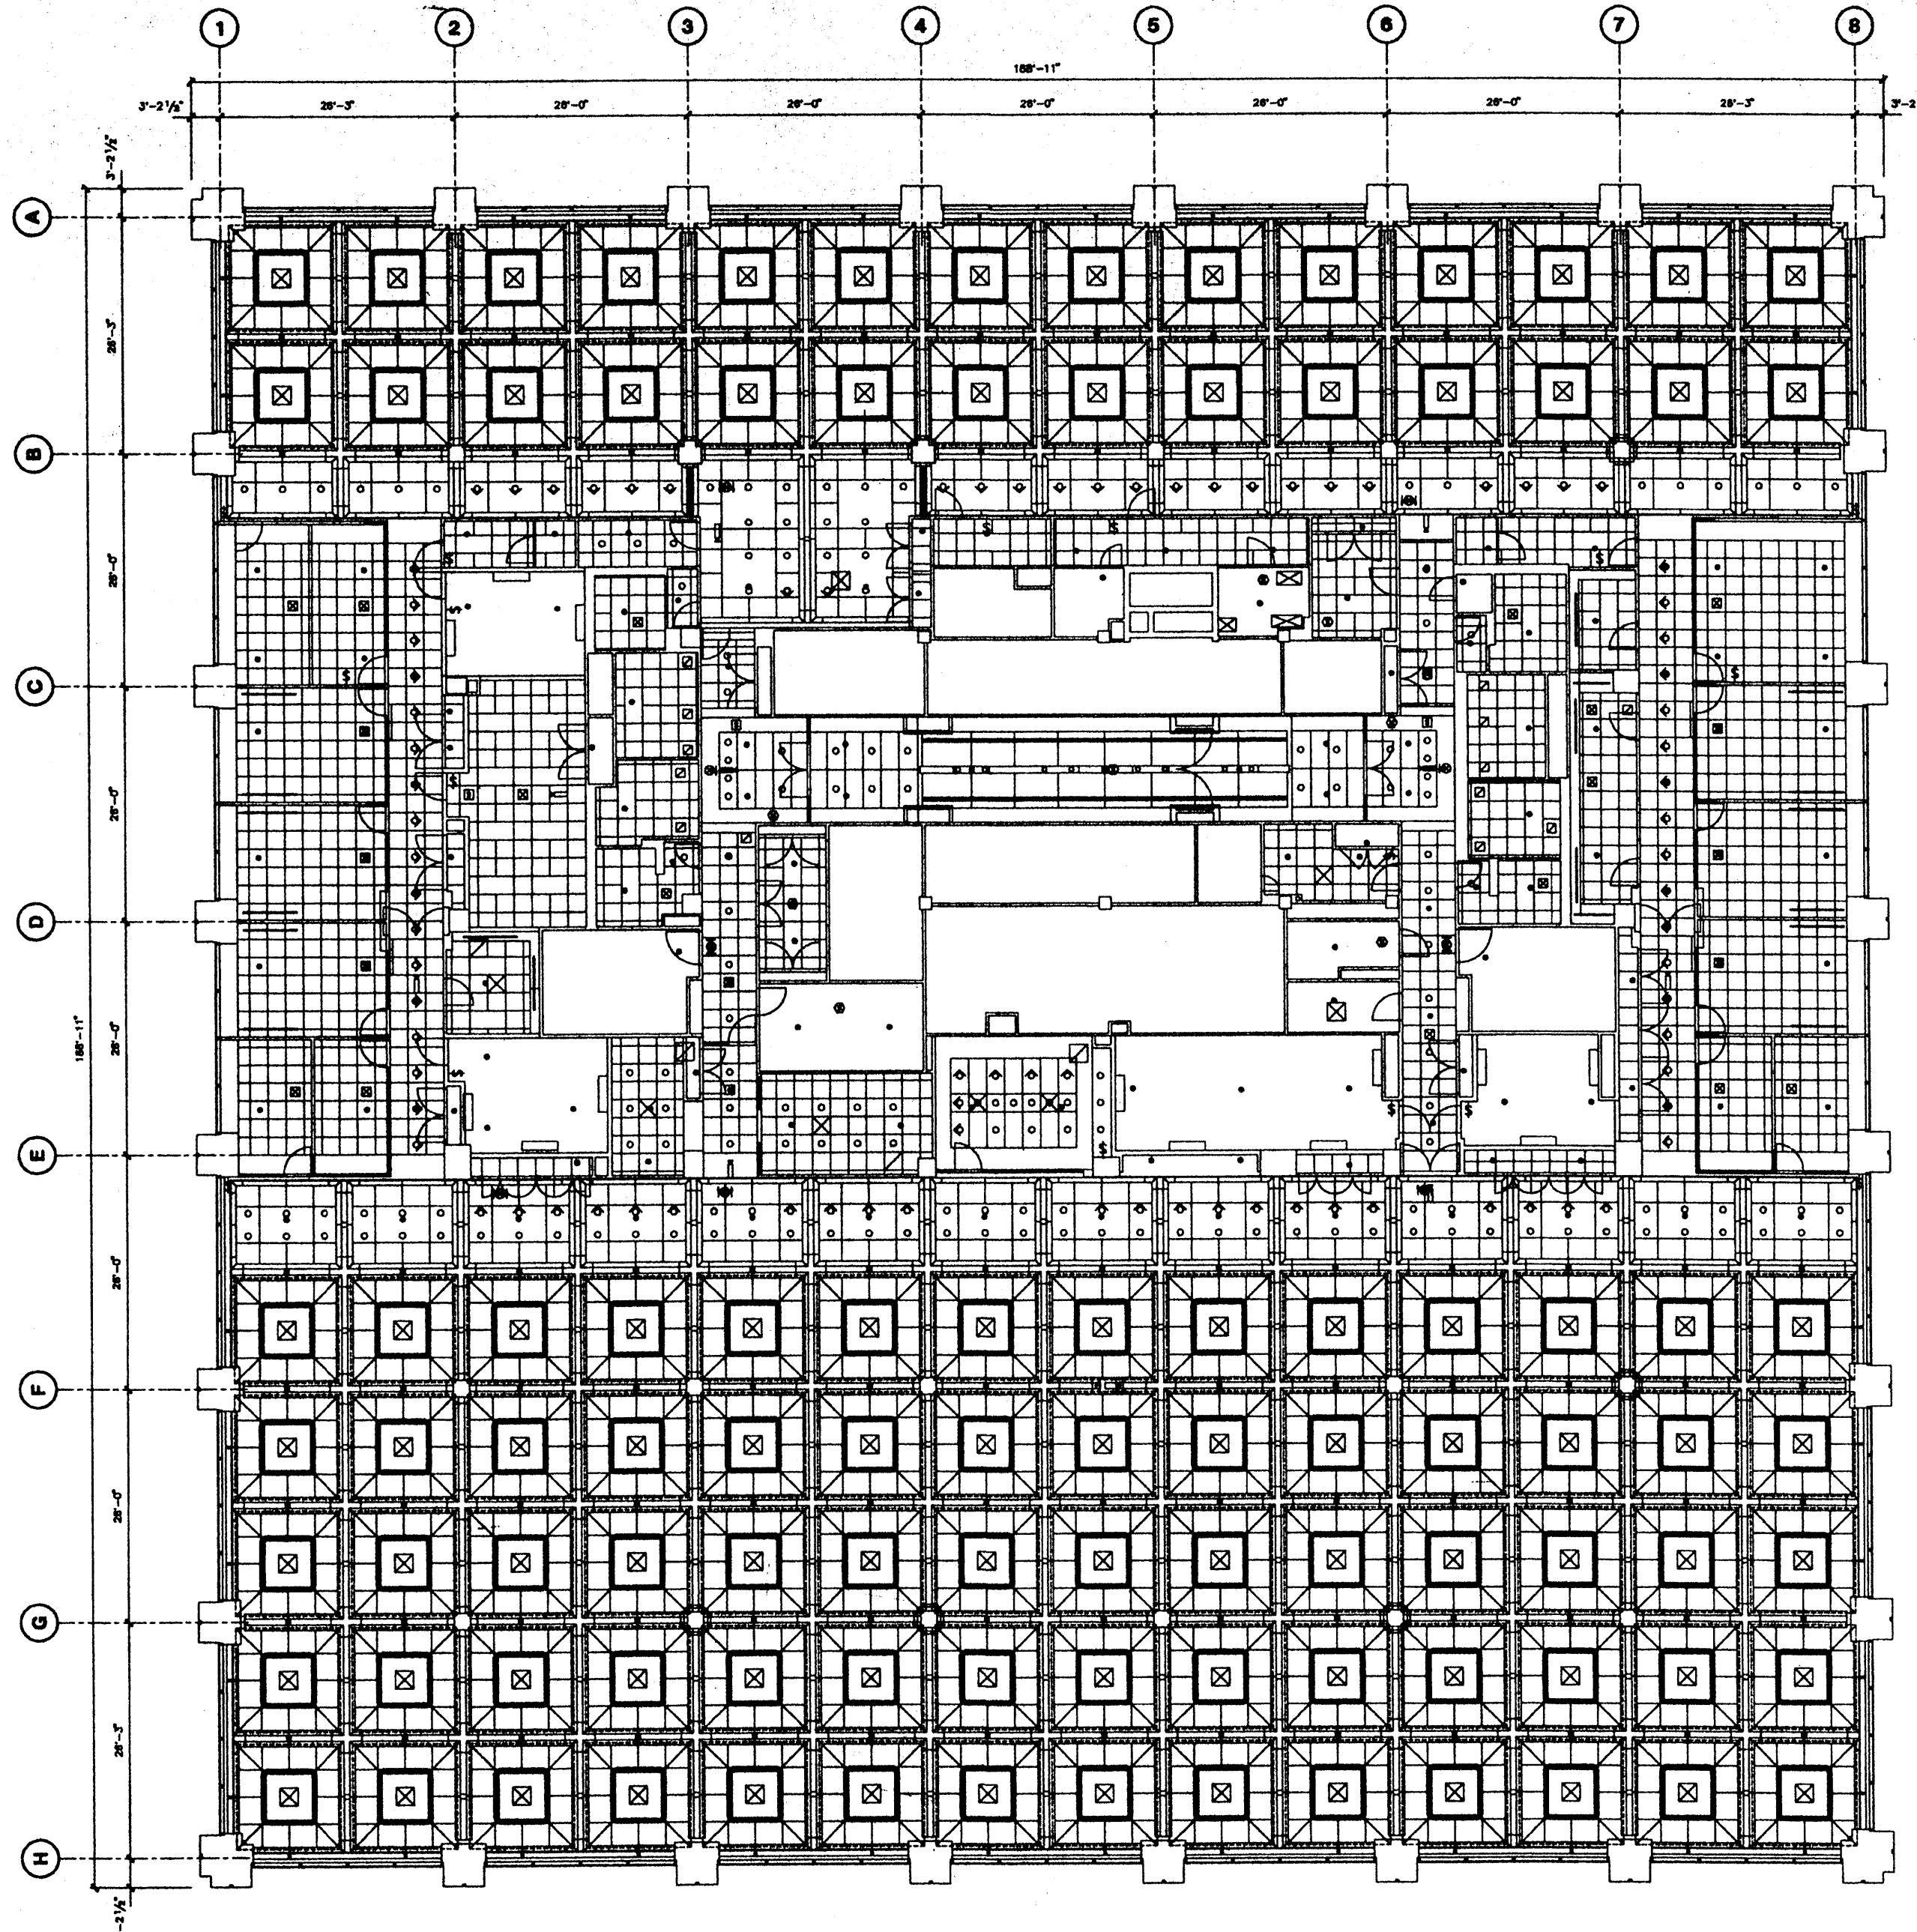

Deutsche Bank


No.	Date	Description
1	6/1/83	Project 100001430 - 100% Design Preparation
2	6/1/84	Project 100001430 - 100% Design Preparation
3	7/15/88	Updated for Deutsche Credit Bureau

No.	Date	Issued To

130 LIBERTY STREET

35th FLOOR CEILING PLAN

Drawn by	Checked by
Date	7/15/88
Scale	
Project No.	

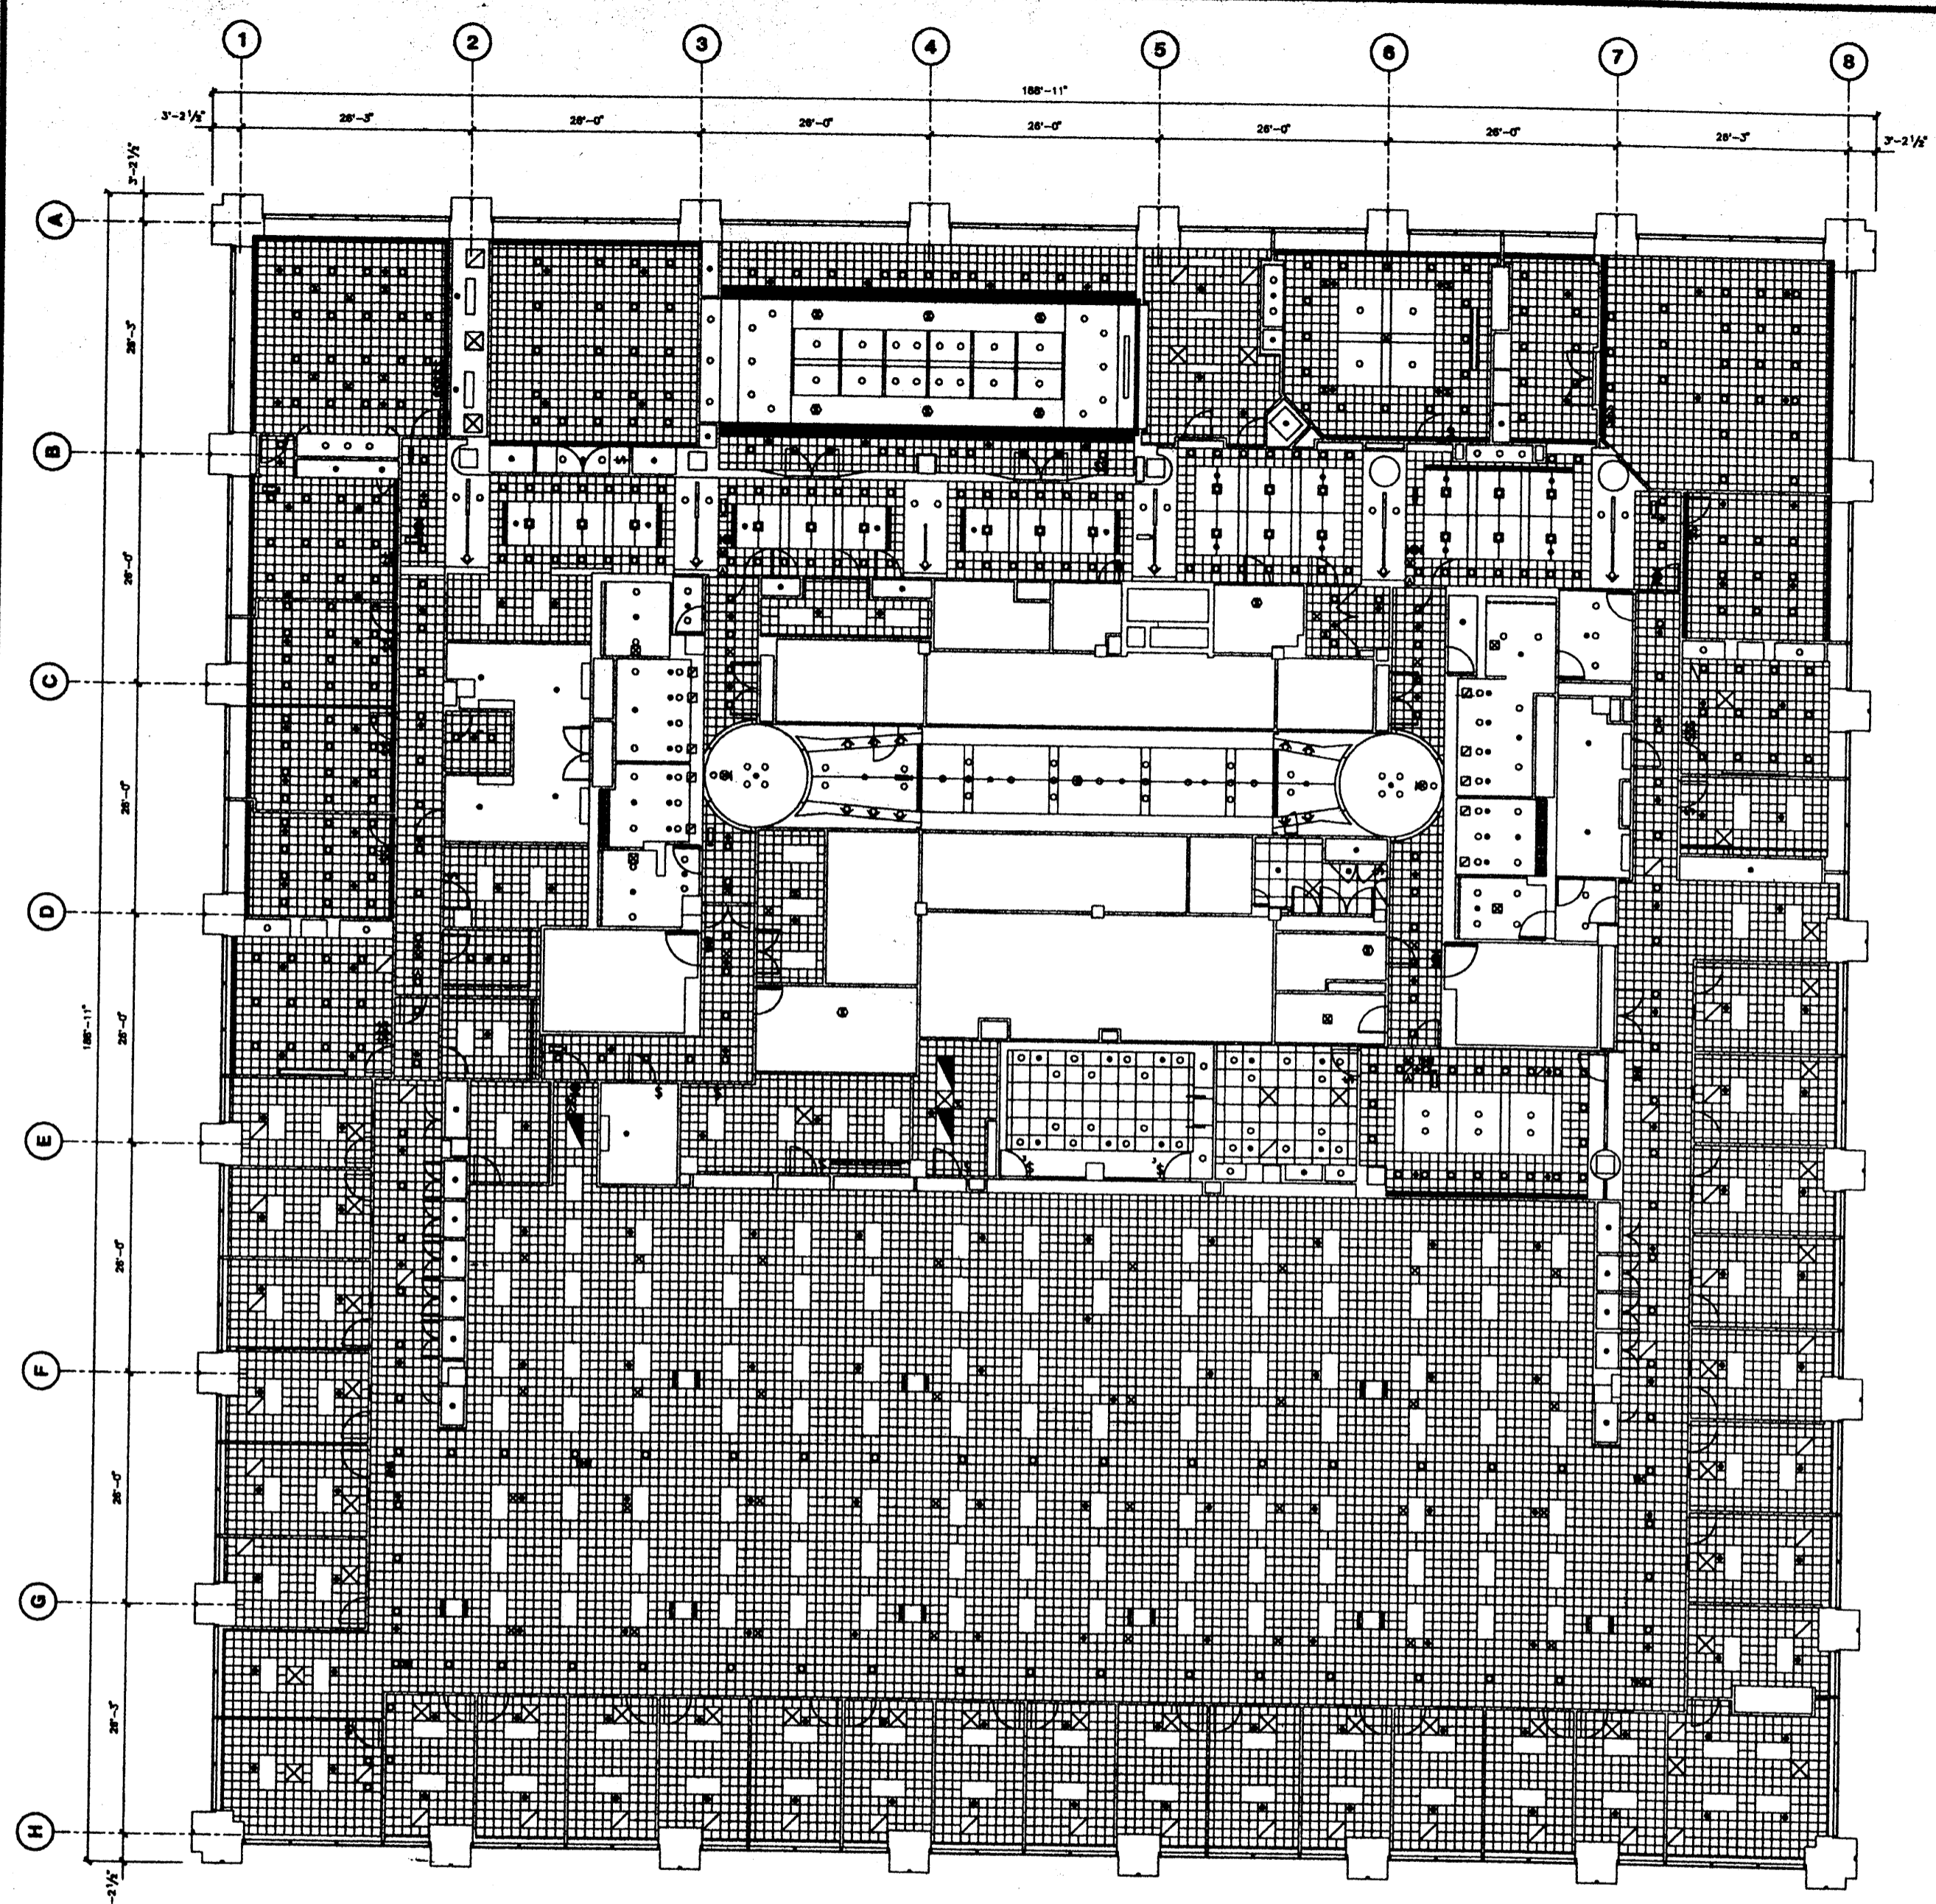

Deutsche Bank


No.	Date	Description
1	8/1/83	Project 00001700 Schematic Development Option
2	12/26/84	Project 00001700 100% Final Working Drawing Approved
3	11/7/98	Project 00001700 / 00000000 Final Working Drawing / 100% Approved Final Working Drawing
4	7/15/98	Updated for Electric Detail Survey
5	8/1/01	Project 100770 DCOP to 5/10 Year

No.	Date	Issued To

130 LIBERTY STREET

34th FLOOR CEILING PLAN

Drawn By	
Checked By	
Date	8/1/01
Scale	
Project No.	

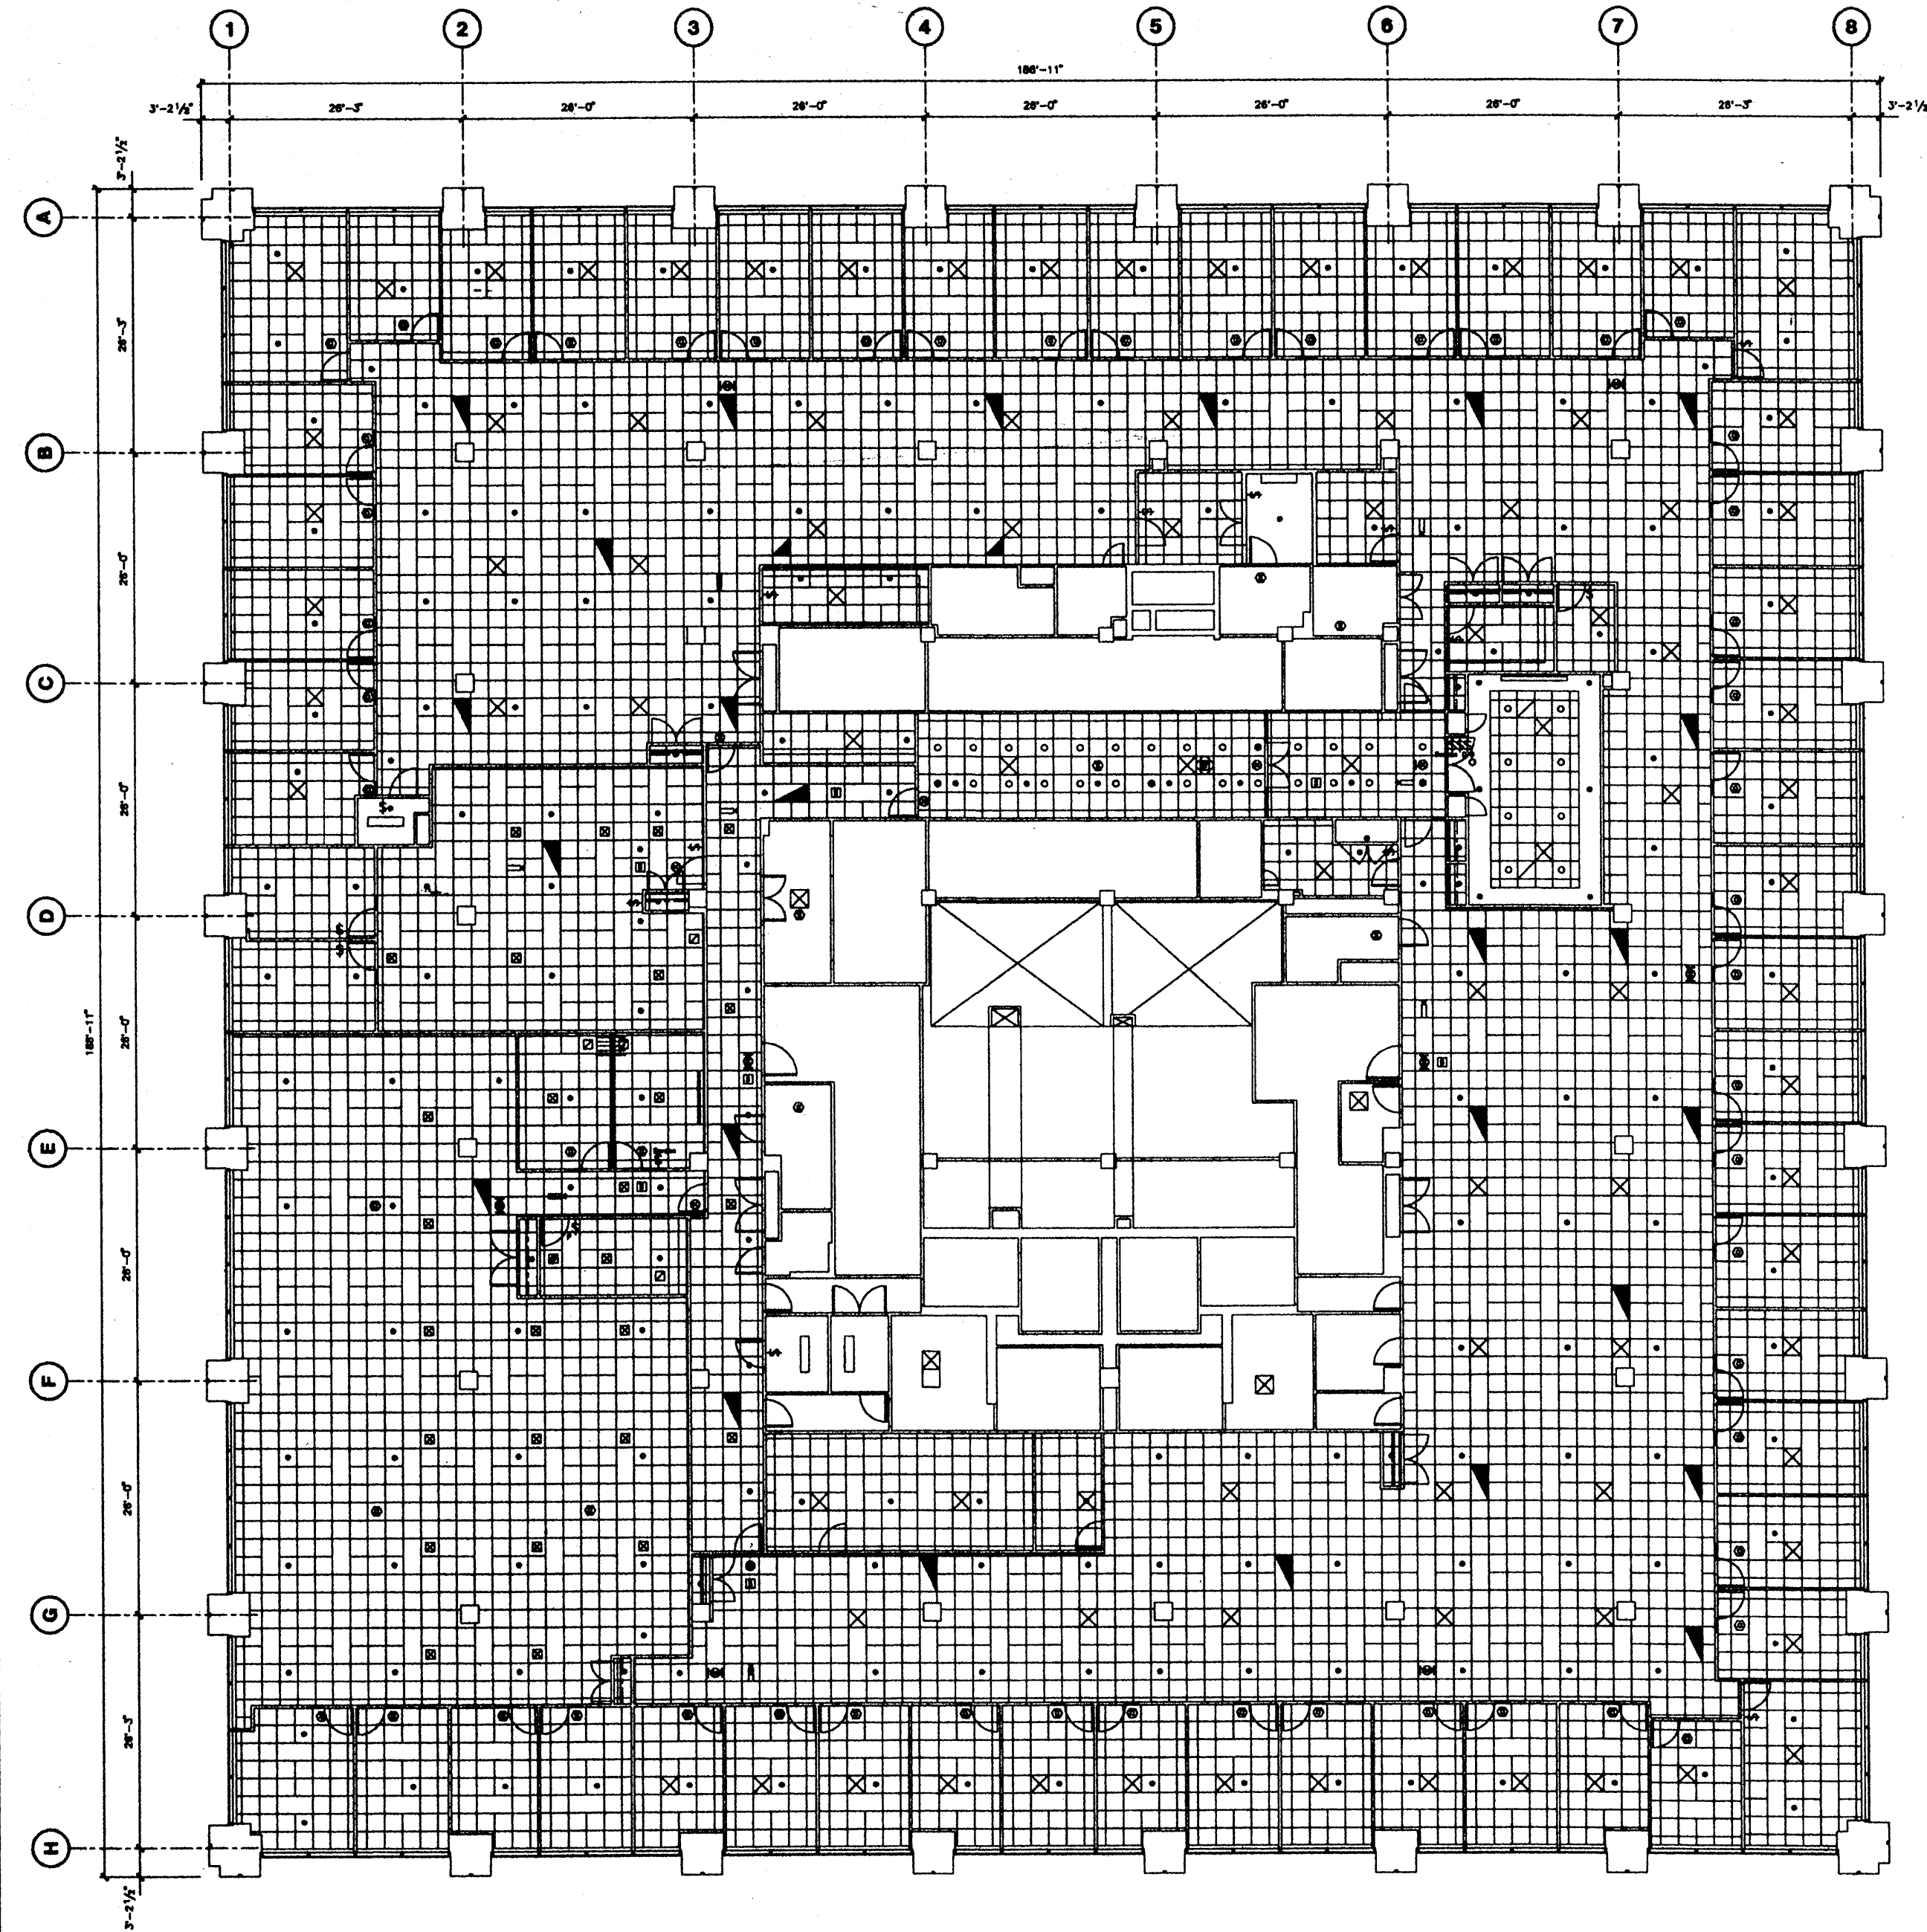

Deutsche Bank


No.	Date	Description
1	3/1/97	Project #80000323 - Global Research Group - Phase 1
2	3/28/98	Project #80001025 - Construction of 3rd Core Team
3	7/16/98	Updated for Electric Closet Service
4	1/14/99	Project #80000323 - Global Research Group
5	4/15/99	Project #80000323 - Global Research Group - Phase 2
6	5/25/01	Updated for Building Conditions

No.	Date	Issued To

PROJECT
130 LIBERTY STREET

DISCIPLINE
32nd FLOOR CEILING PLAN

Drawn by	
Checked by	
Date	5/25/01
Scale	
Project No.	

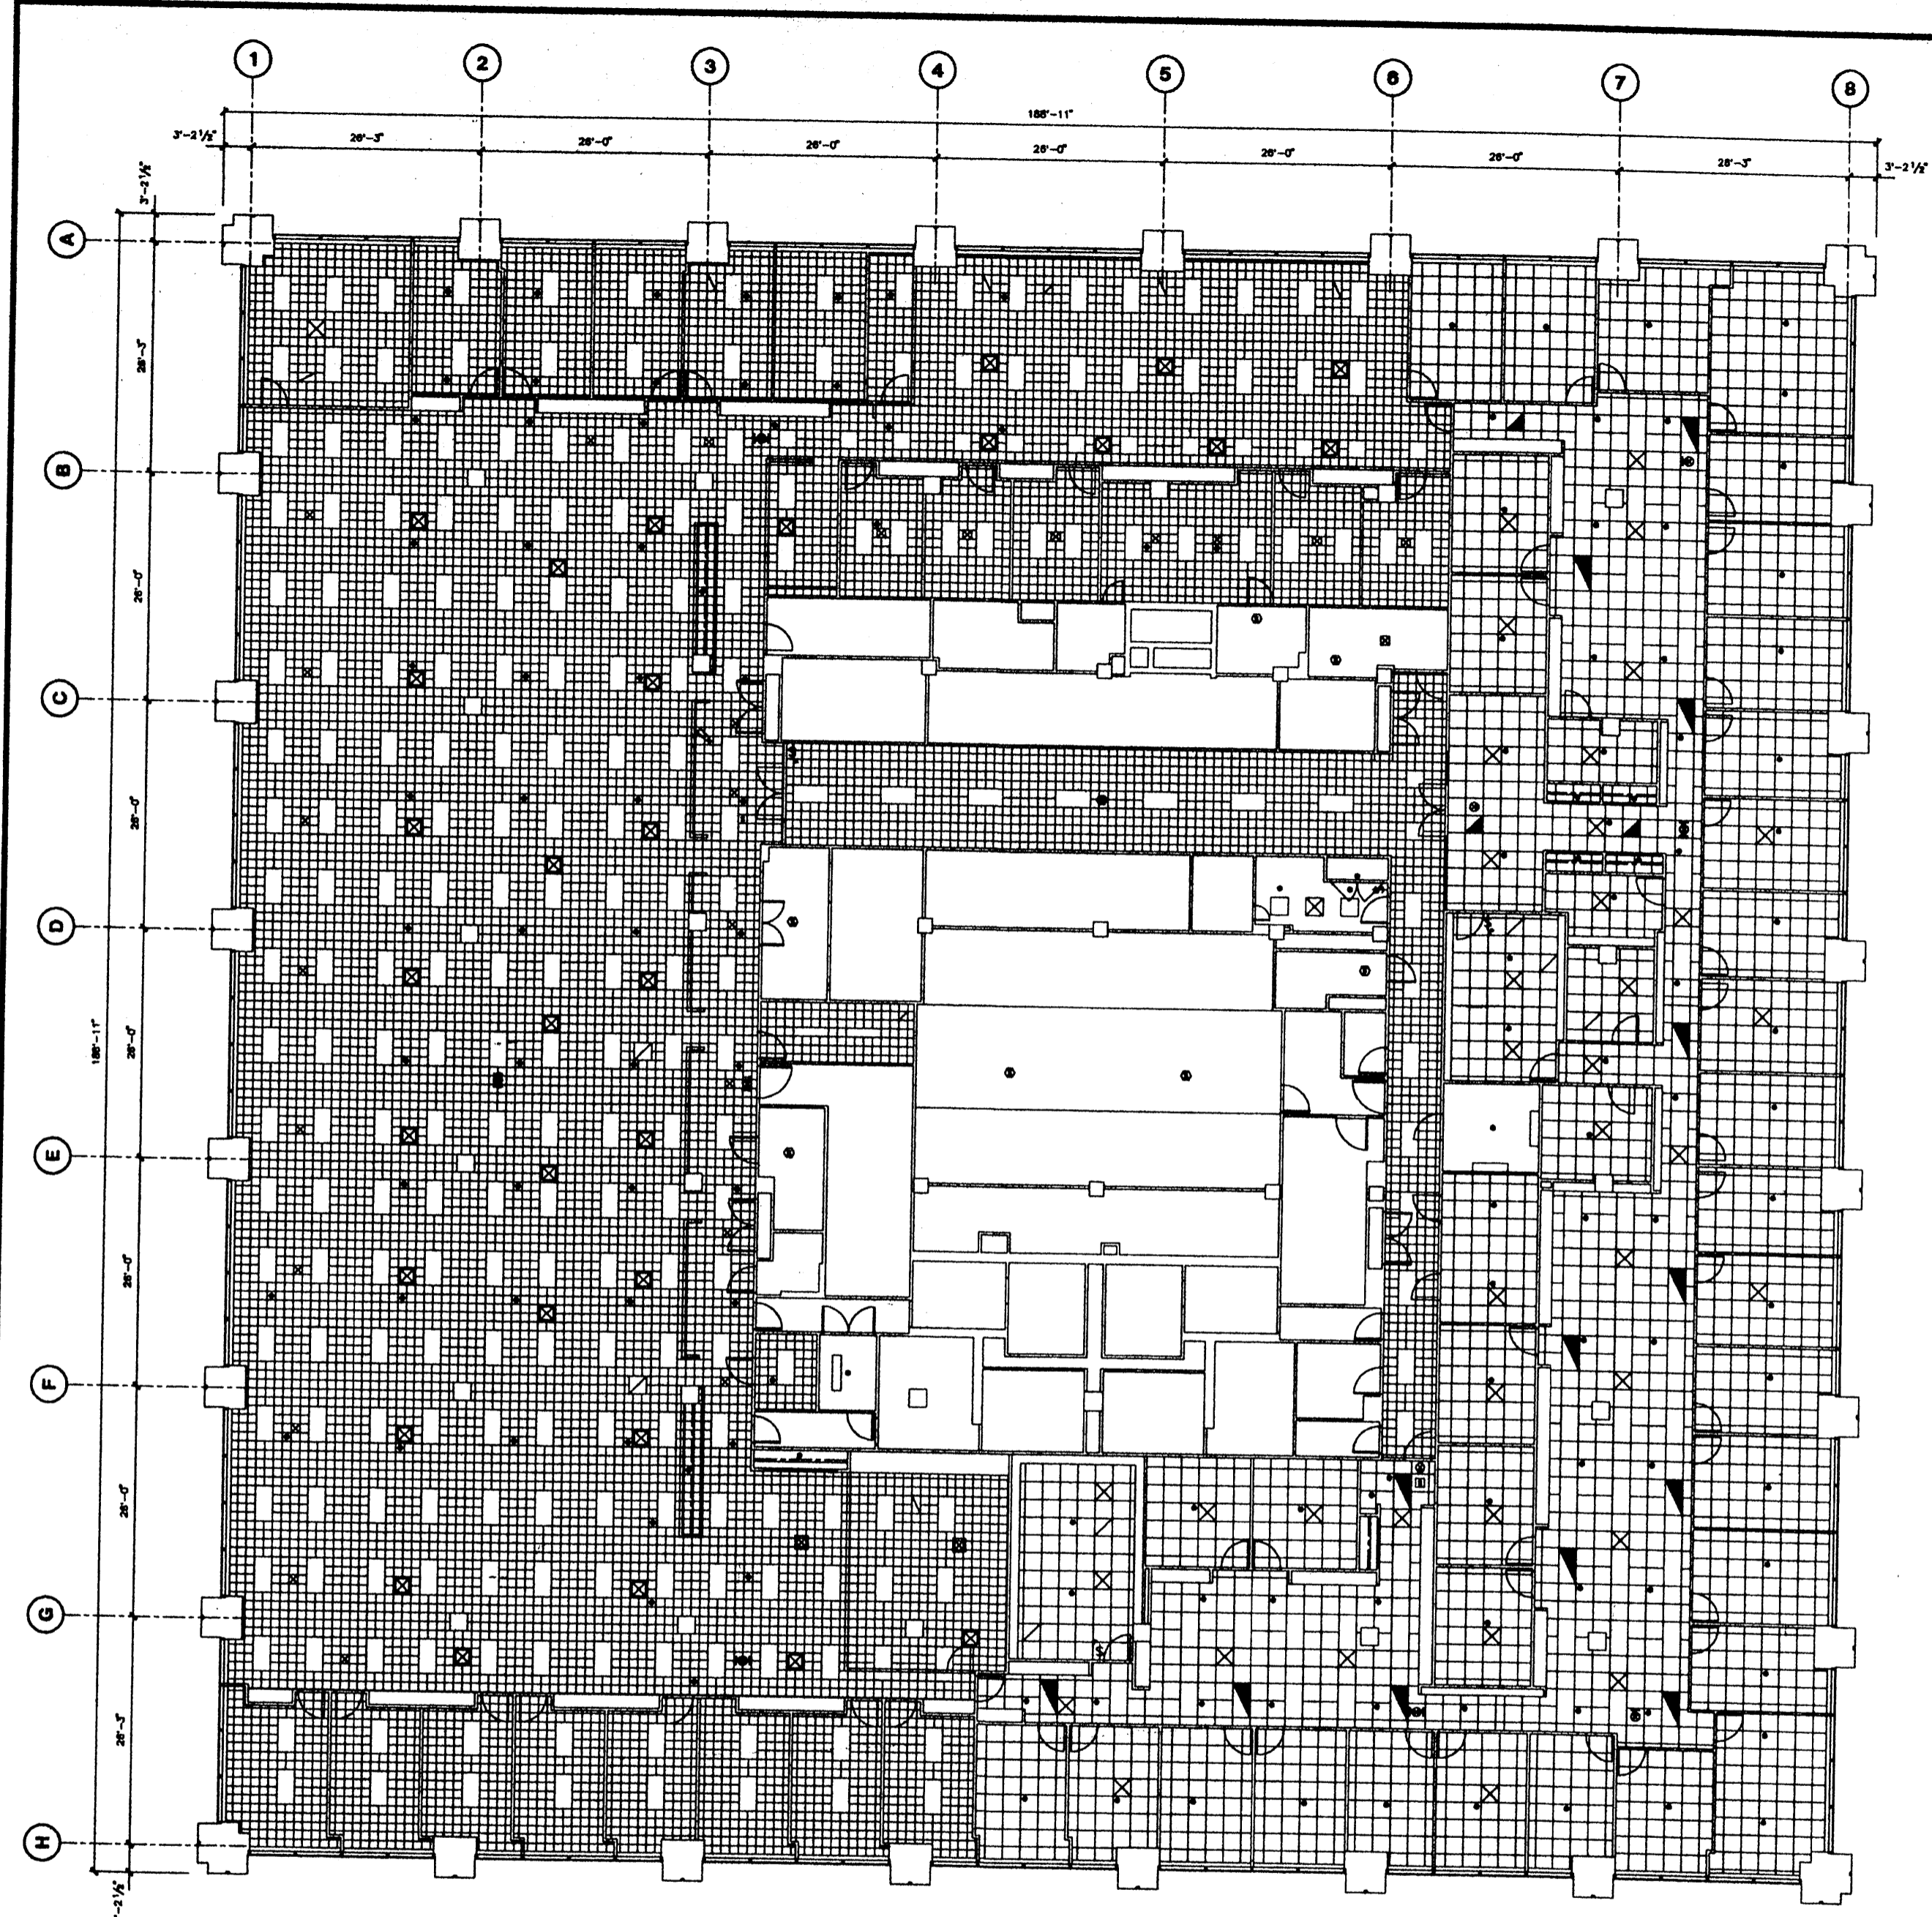

Deutsche Bank

No.	Date	Description
1	7/10/96	Project #00001108 Lease Modification
2	12/1/96	Project #00001131 F&M Construction
3	5/25/97	Updated for Existing Conditions
4	7/15/98	Updated for Existing Ceiling System
5	5/25/01	Updated for Existing Conditions


No.	Date	Issued To

PROJECT:
130 LIBERTY STREET

DESCRIPTION:
**31st FLOOR
CEILING
PLAN**

Drawn By	
Checked By	
Date	5/25/01
Scale	
Project No.	



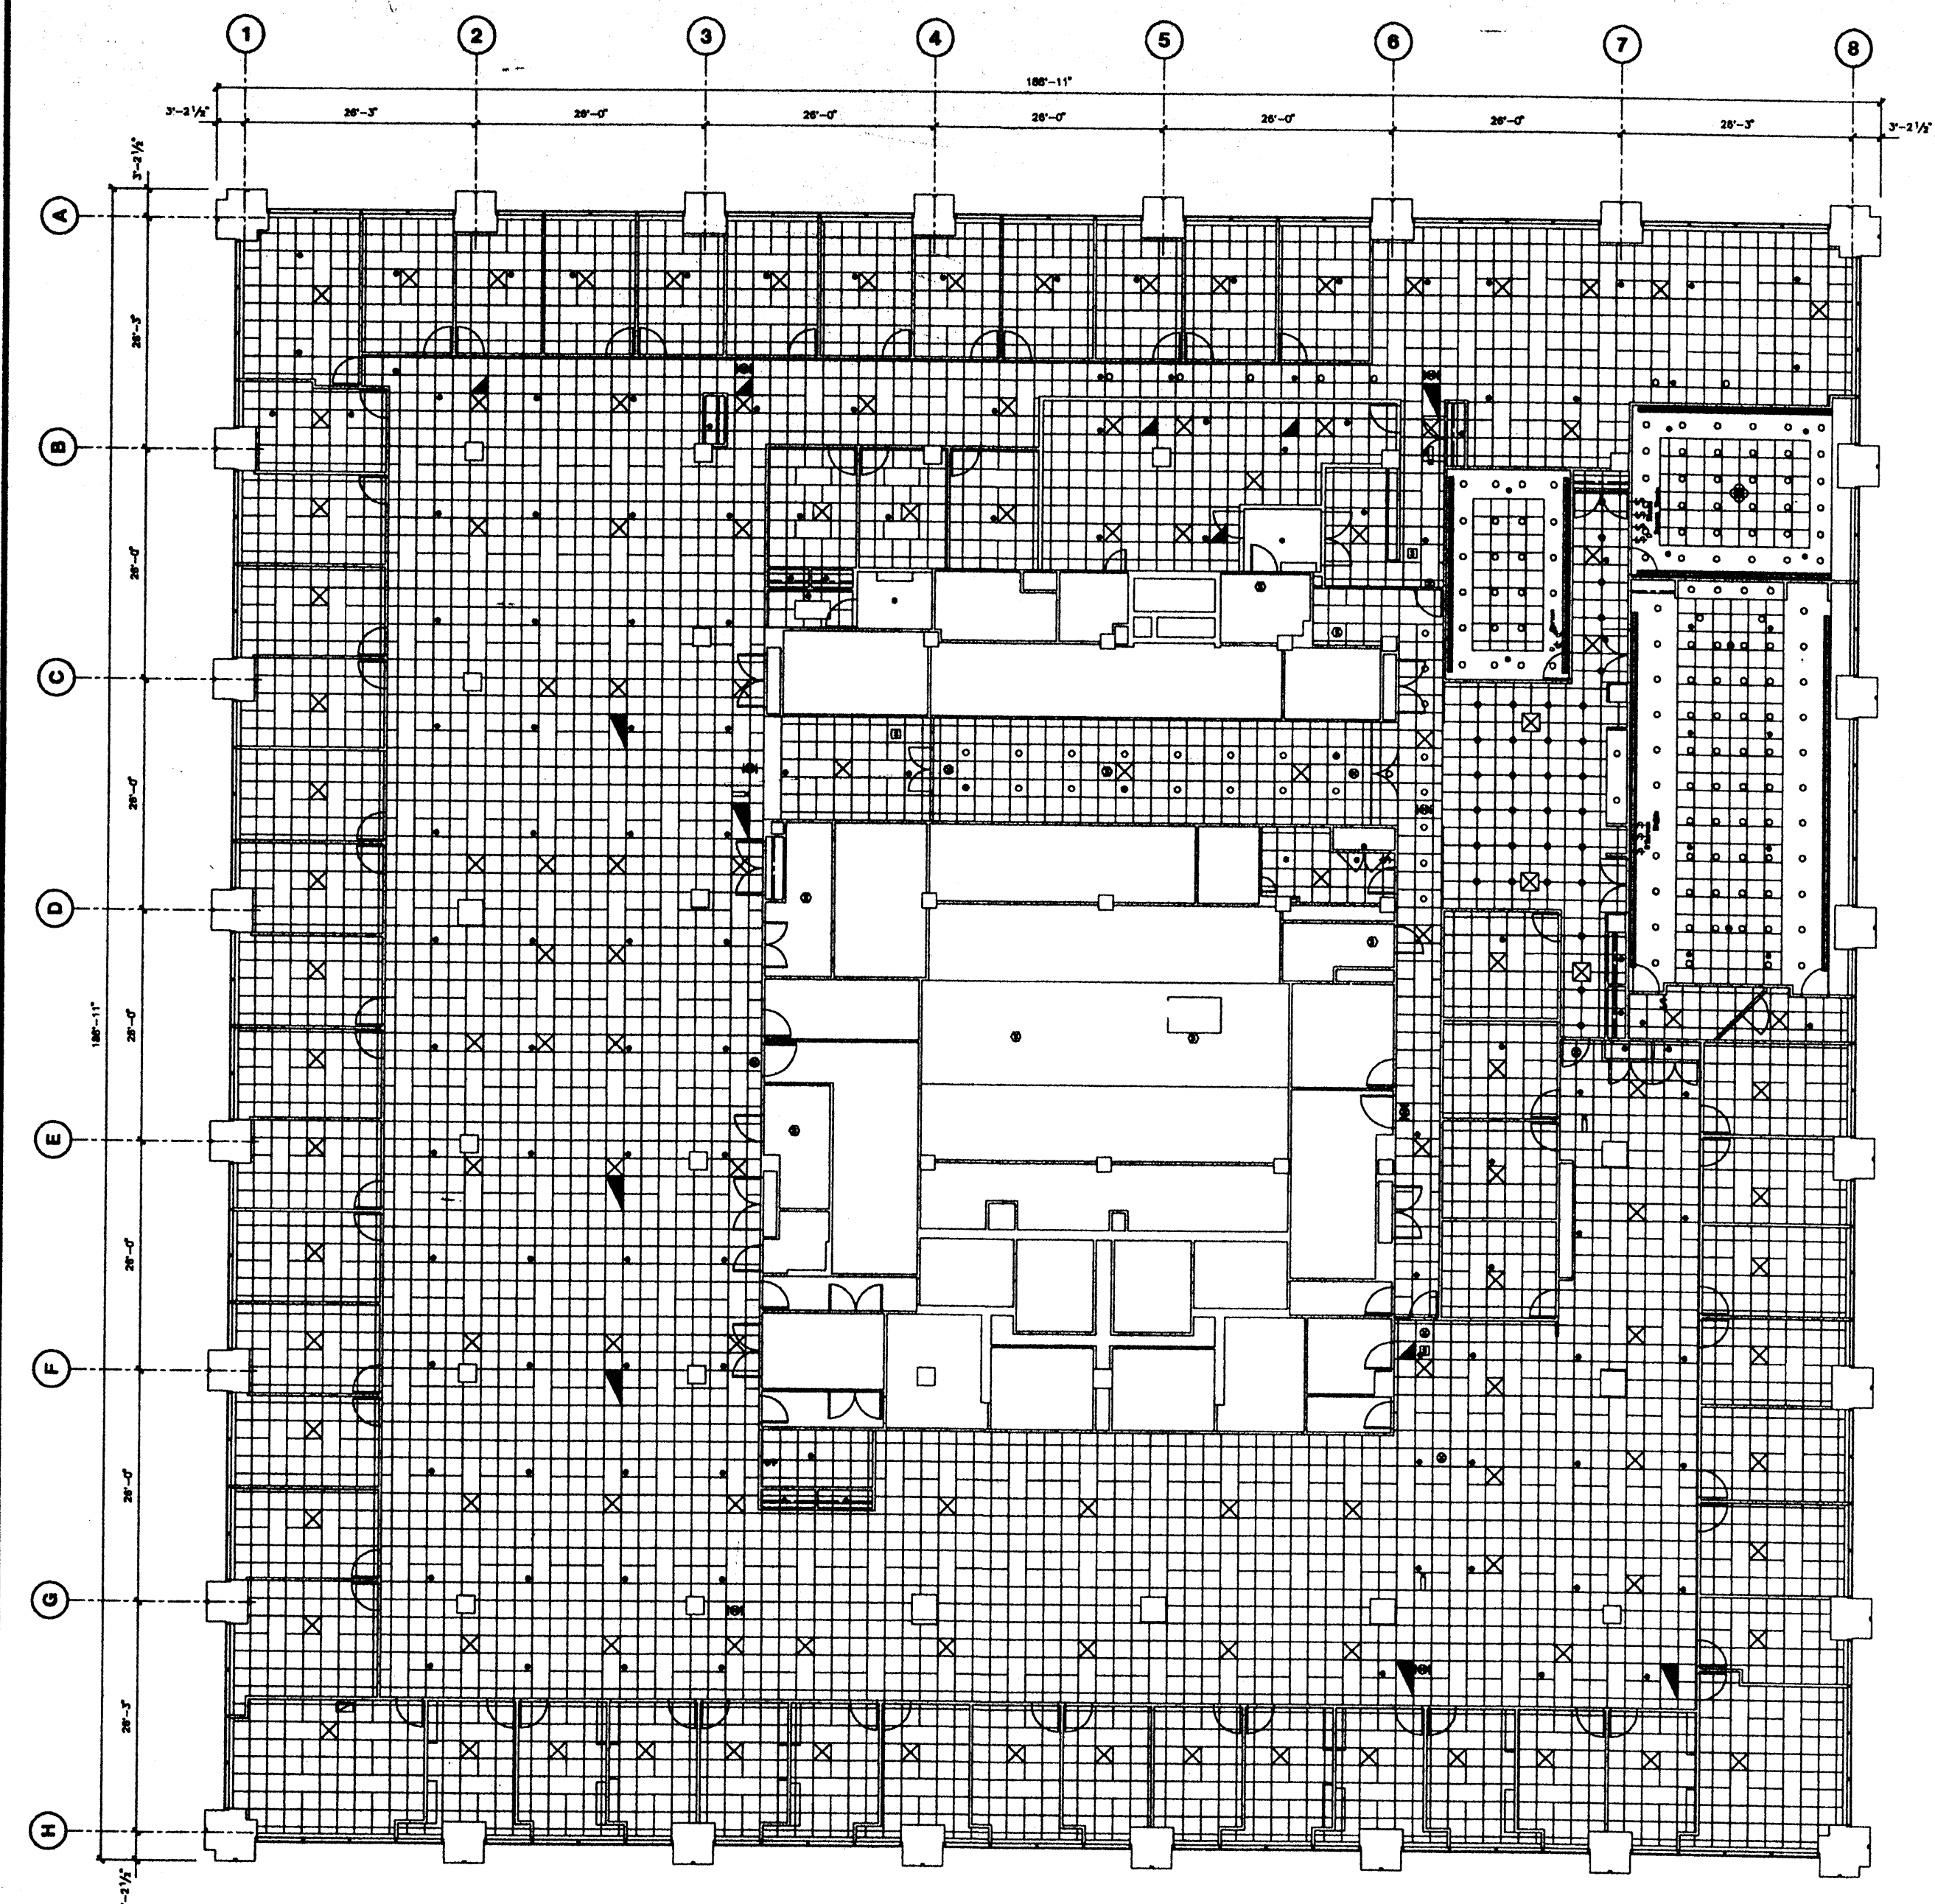

Deutsche Bank

No.	Date	Description
1	12/1/83	Project 880000375 - 2nd Legal Reformation
2	12/1/83	Project 020001834 - Old First Pennsylvania Plan
3	3/2/84	Project 880001633 - 2nd Bank Plan
4	7/1/87	Project 880000633 - Digital Structure Reformation
5	8/7/88	Added Wall to 29th Floor
6	7/1/88	Updated for Deutsche Credit Survey
7	4/1/88	Project 880001845 - Reformation
8	5/1/91	Updated for Existing Conditions


No.	Date	Issued To

130 LIBERTY STREET

30th FLOOR CEILING PLAN

Drawn By	
Checked By	
Date	9/1/01
Scale	
Project No.	



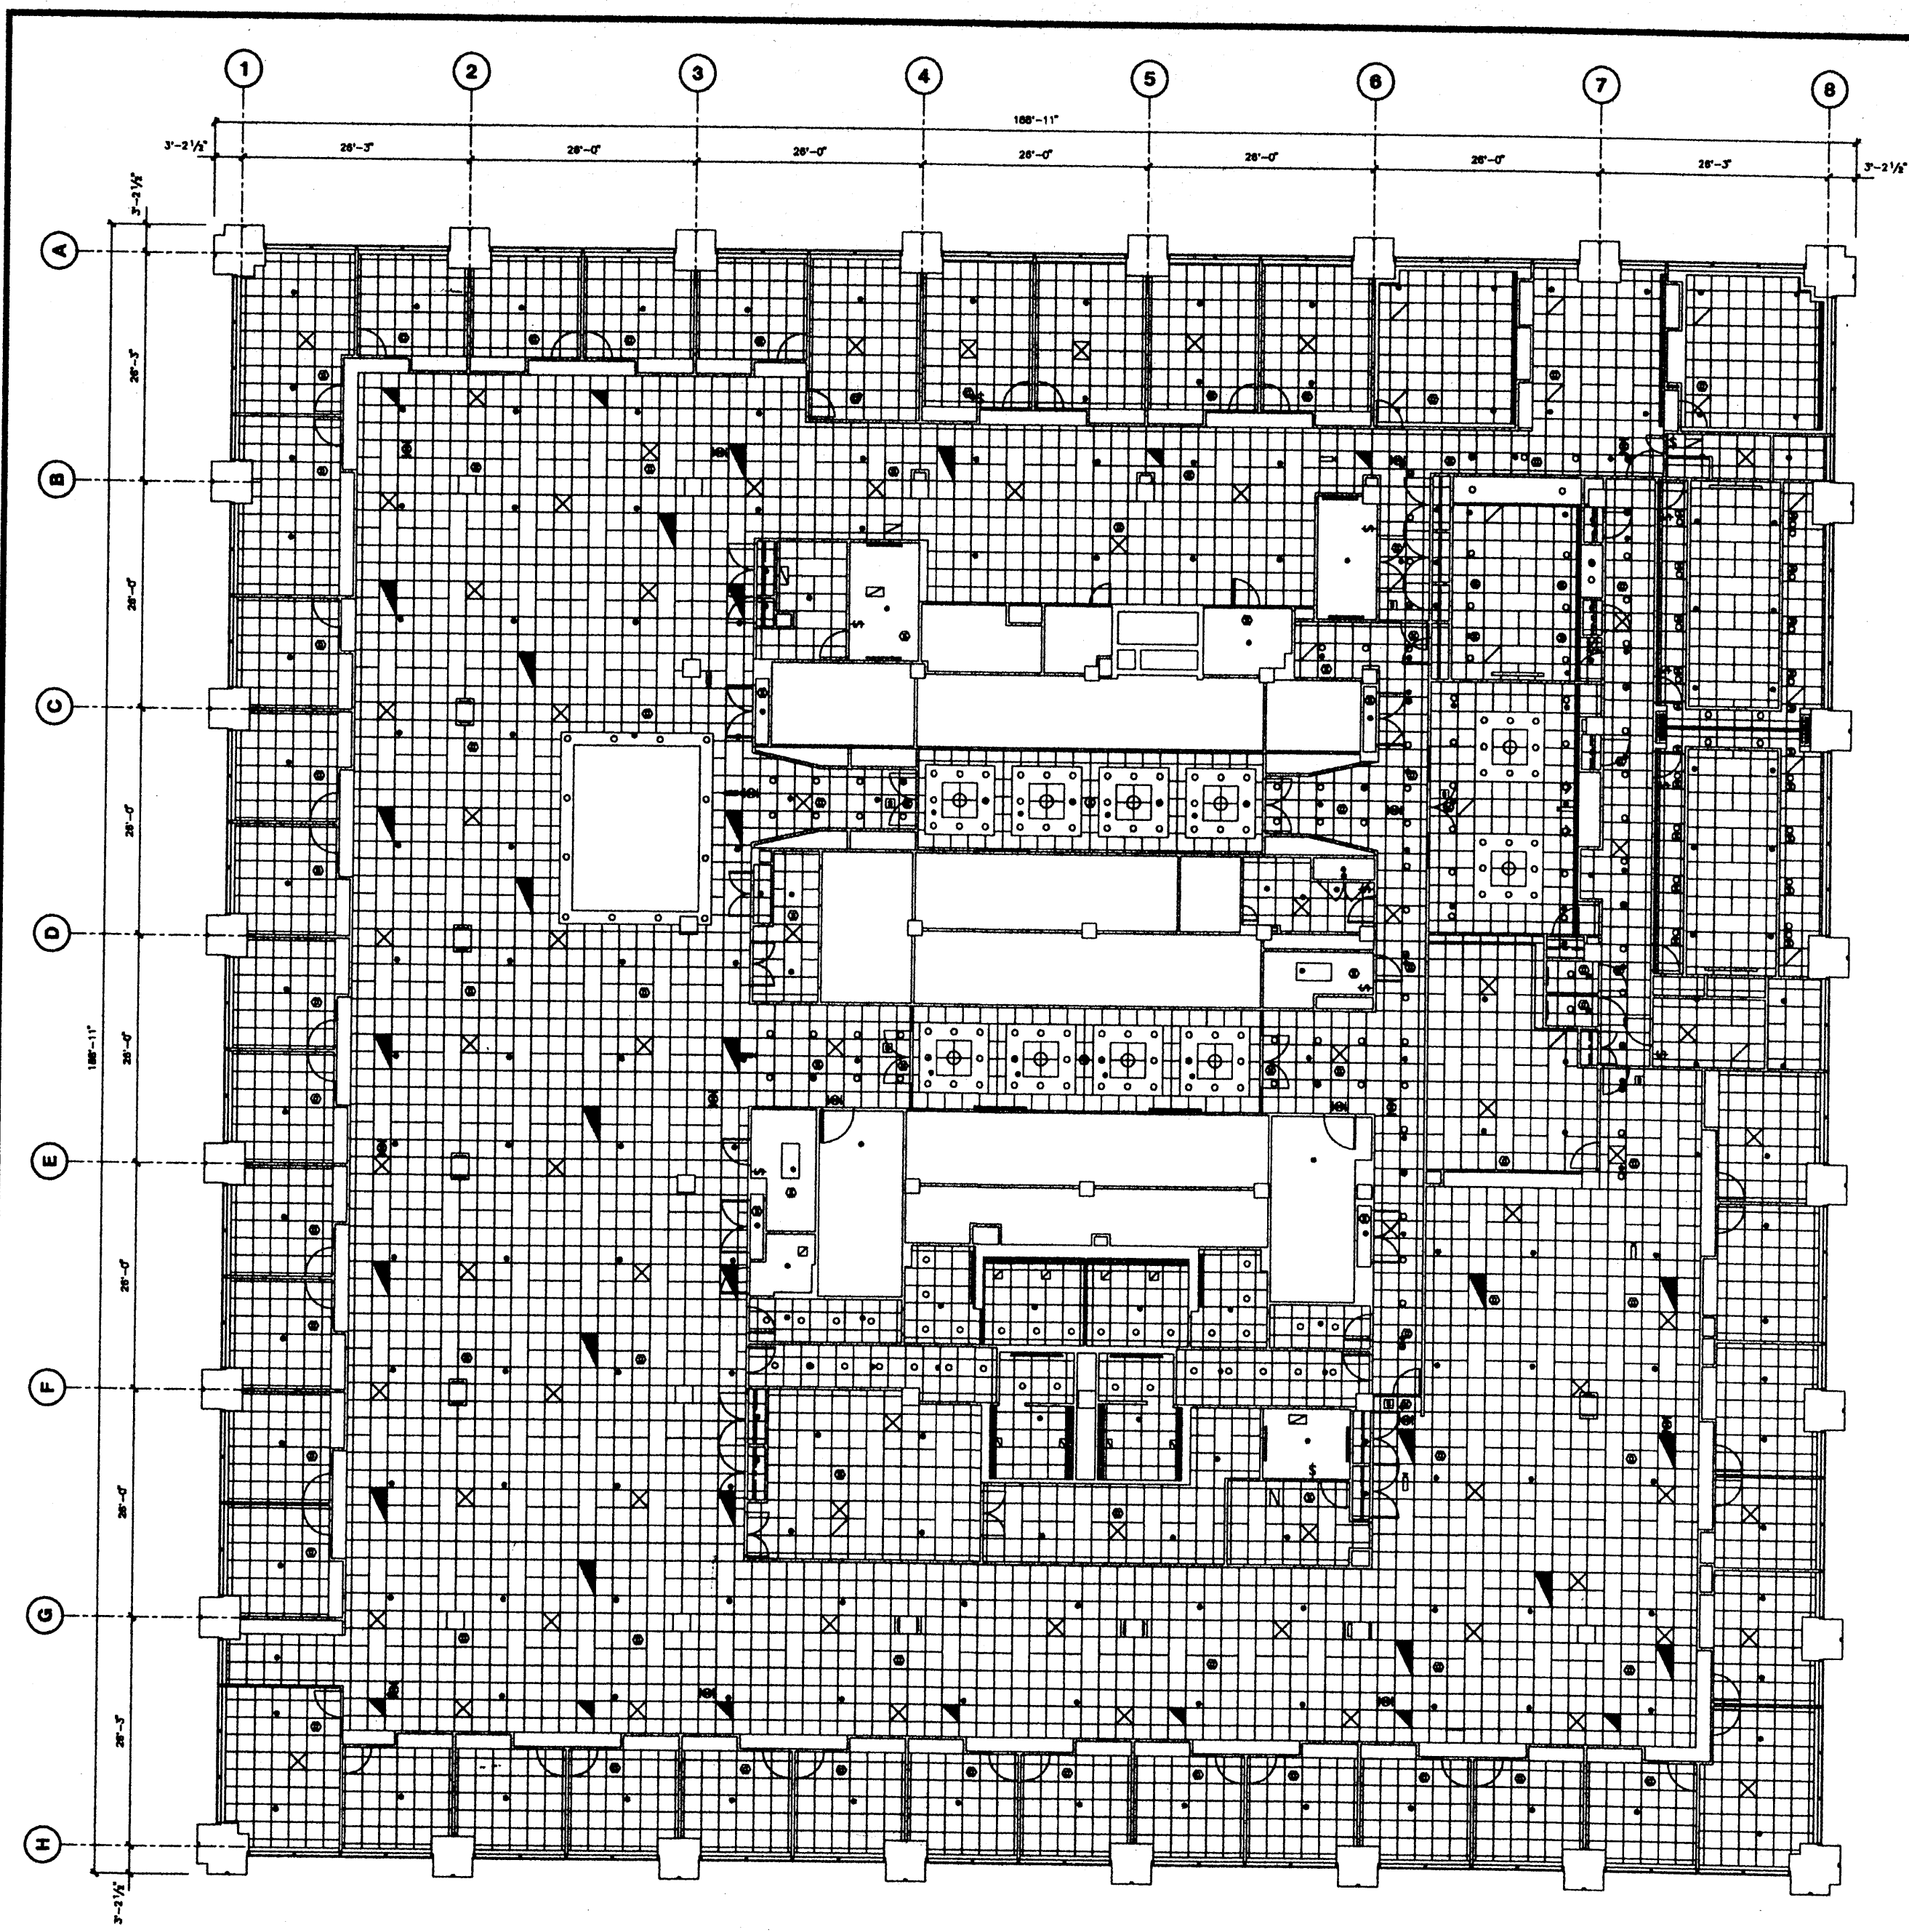

Deutsche Bank


No.	Date	Description
1	5/1/98	Project 020022000 27' Area, 2nd Floor
2	7/11/98	Updated for Client's Client Survey
3	5/25/01	Updated for Client's Conditions

No.	Date	Issued To

130 LIBERTY STREET
29th FLOOR
CEILING PLAN

Drawn By	
Checked By	
Date	5/25/01
Scale	
Project No.	



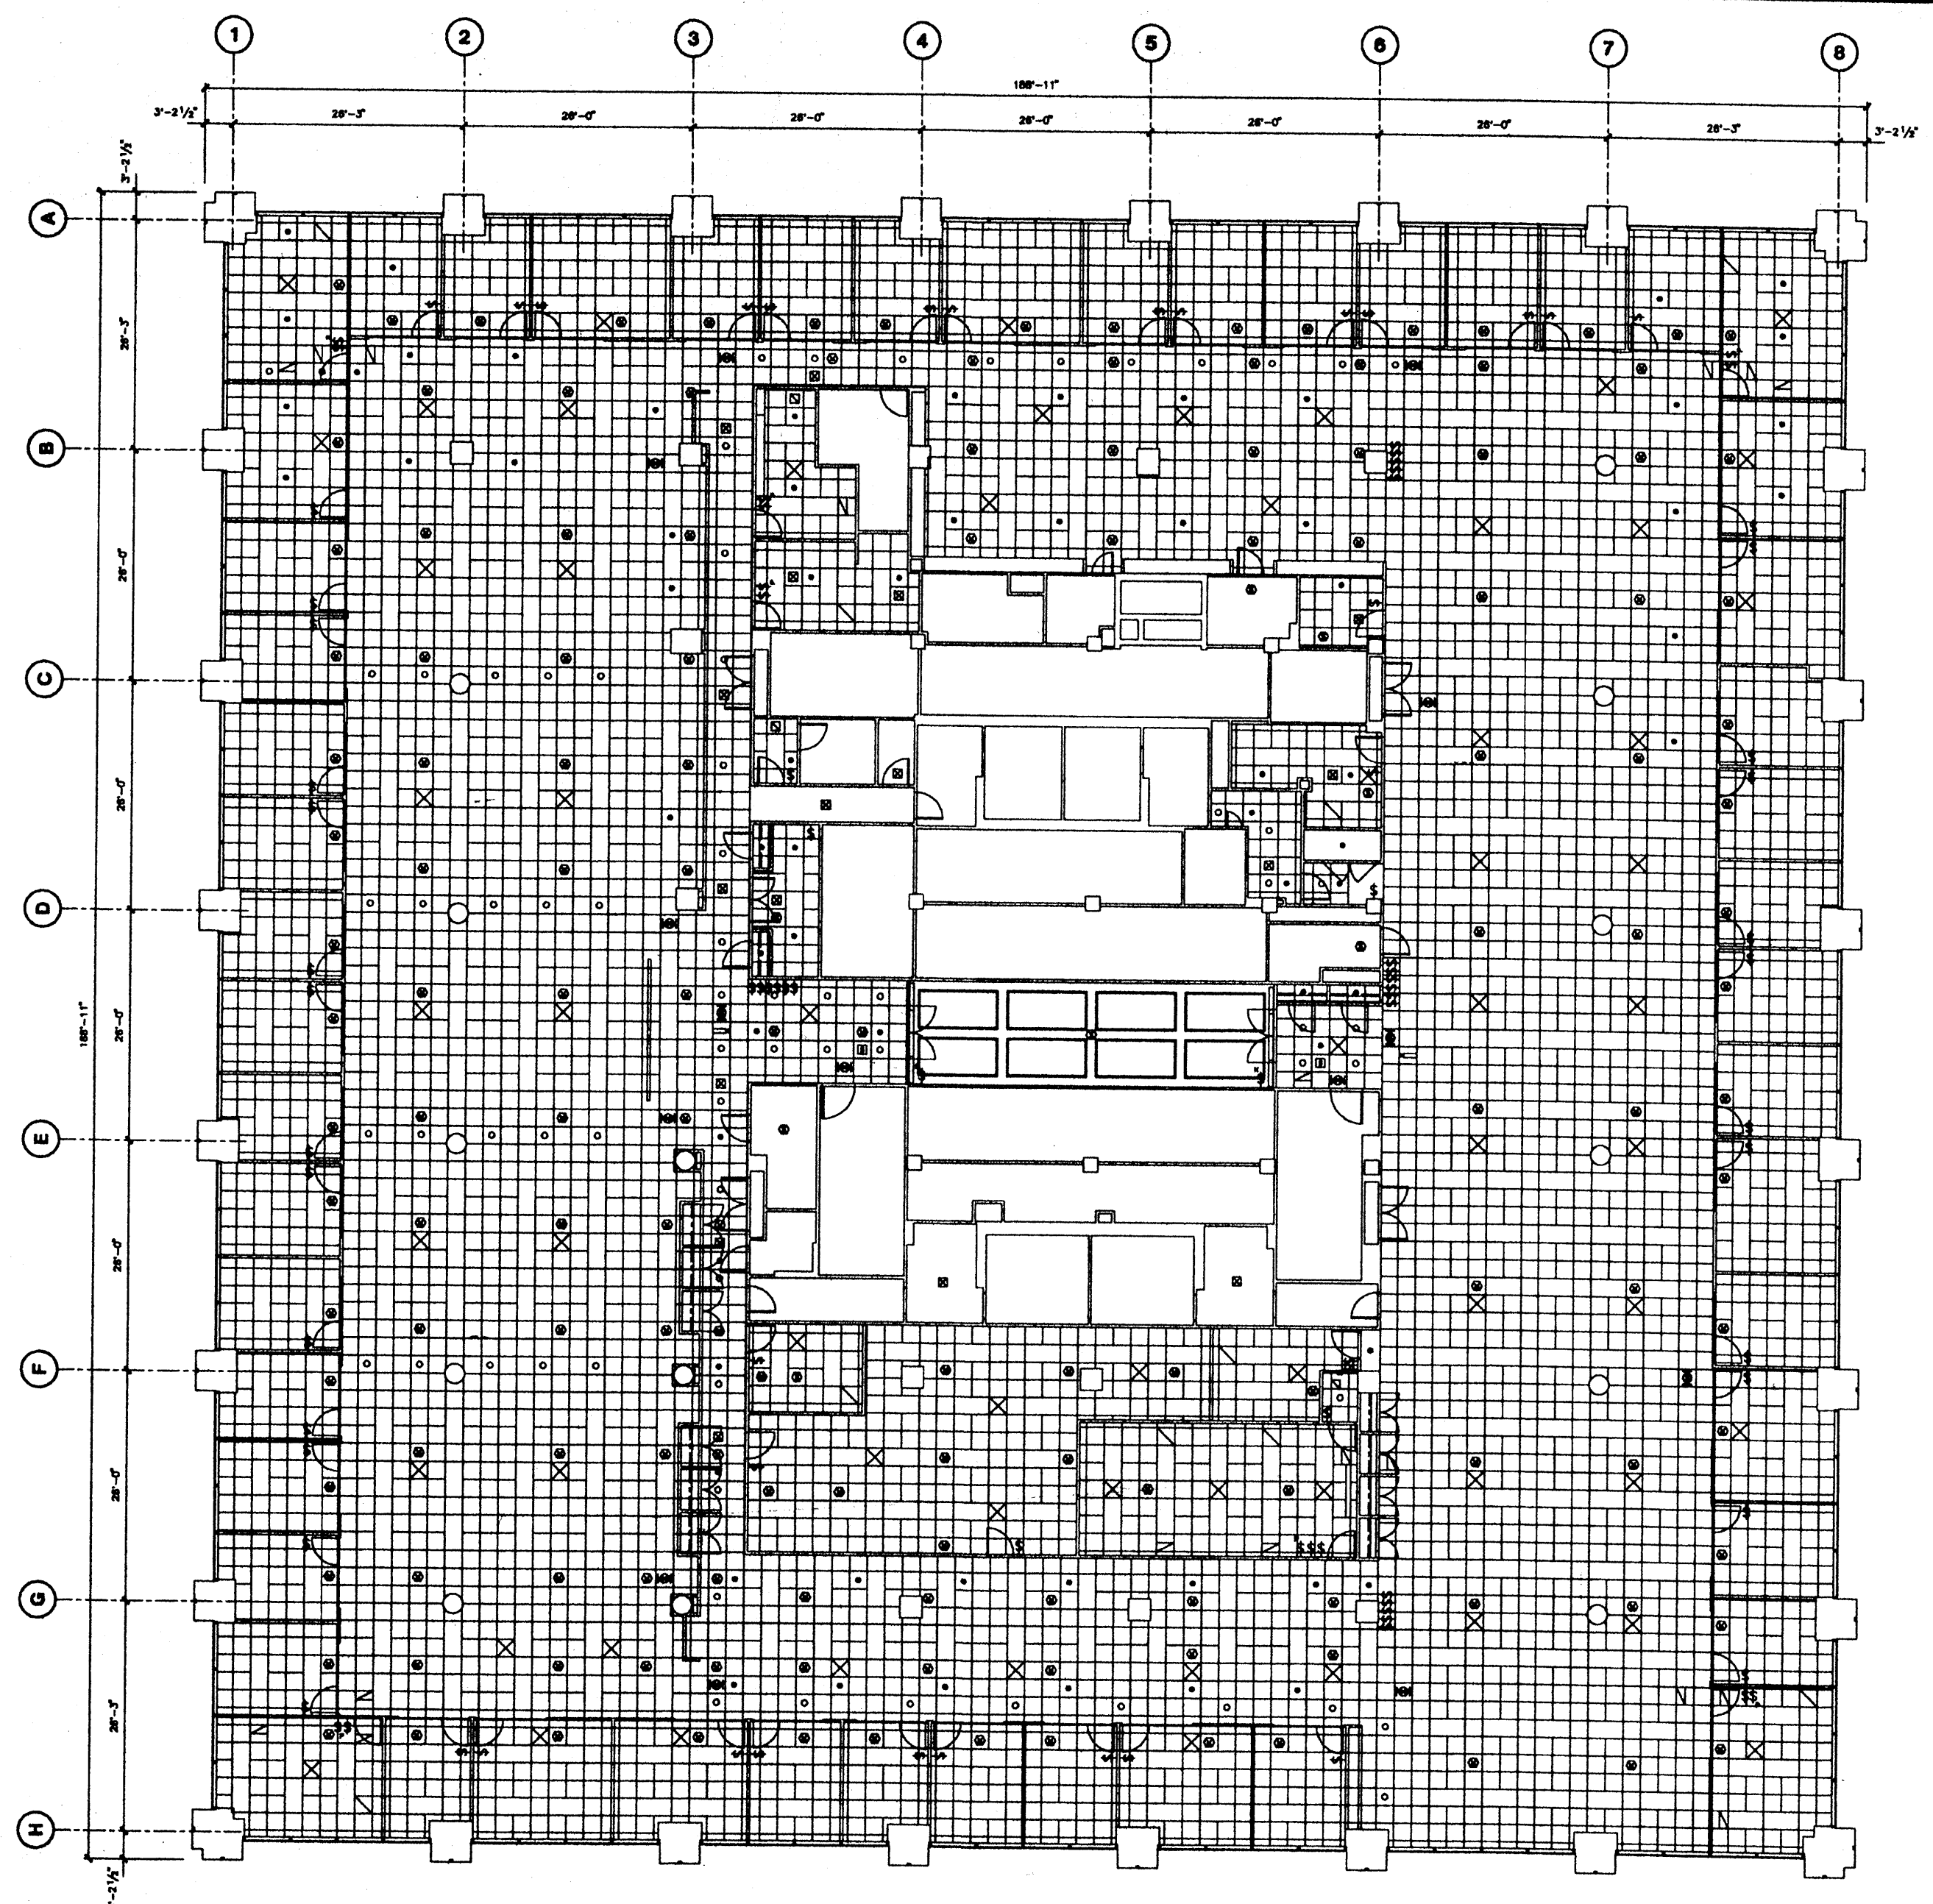

Deutsche Bank

No.	Date	Description
1	4/10/98	Project 130LIB0101 - Rise & Draft Measurement
2	7/15/98	Updated for Electric Cable Survey
3	1/15/01	Project 130LIB0101 - North & South Side Office
4	9/1/01	Updated for Existing Conditions


No.	Date	Issued To

PROJECT
130 LIBERTY STREET

DESCRIPTION
28th FLOOR CEILING PLAN

Drawn By	
Checked By	
Date	9/1/01
Project No.	



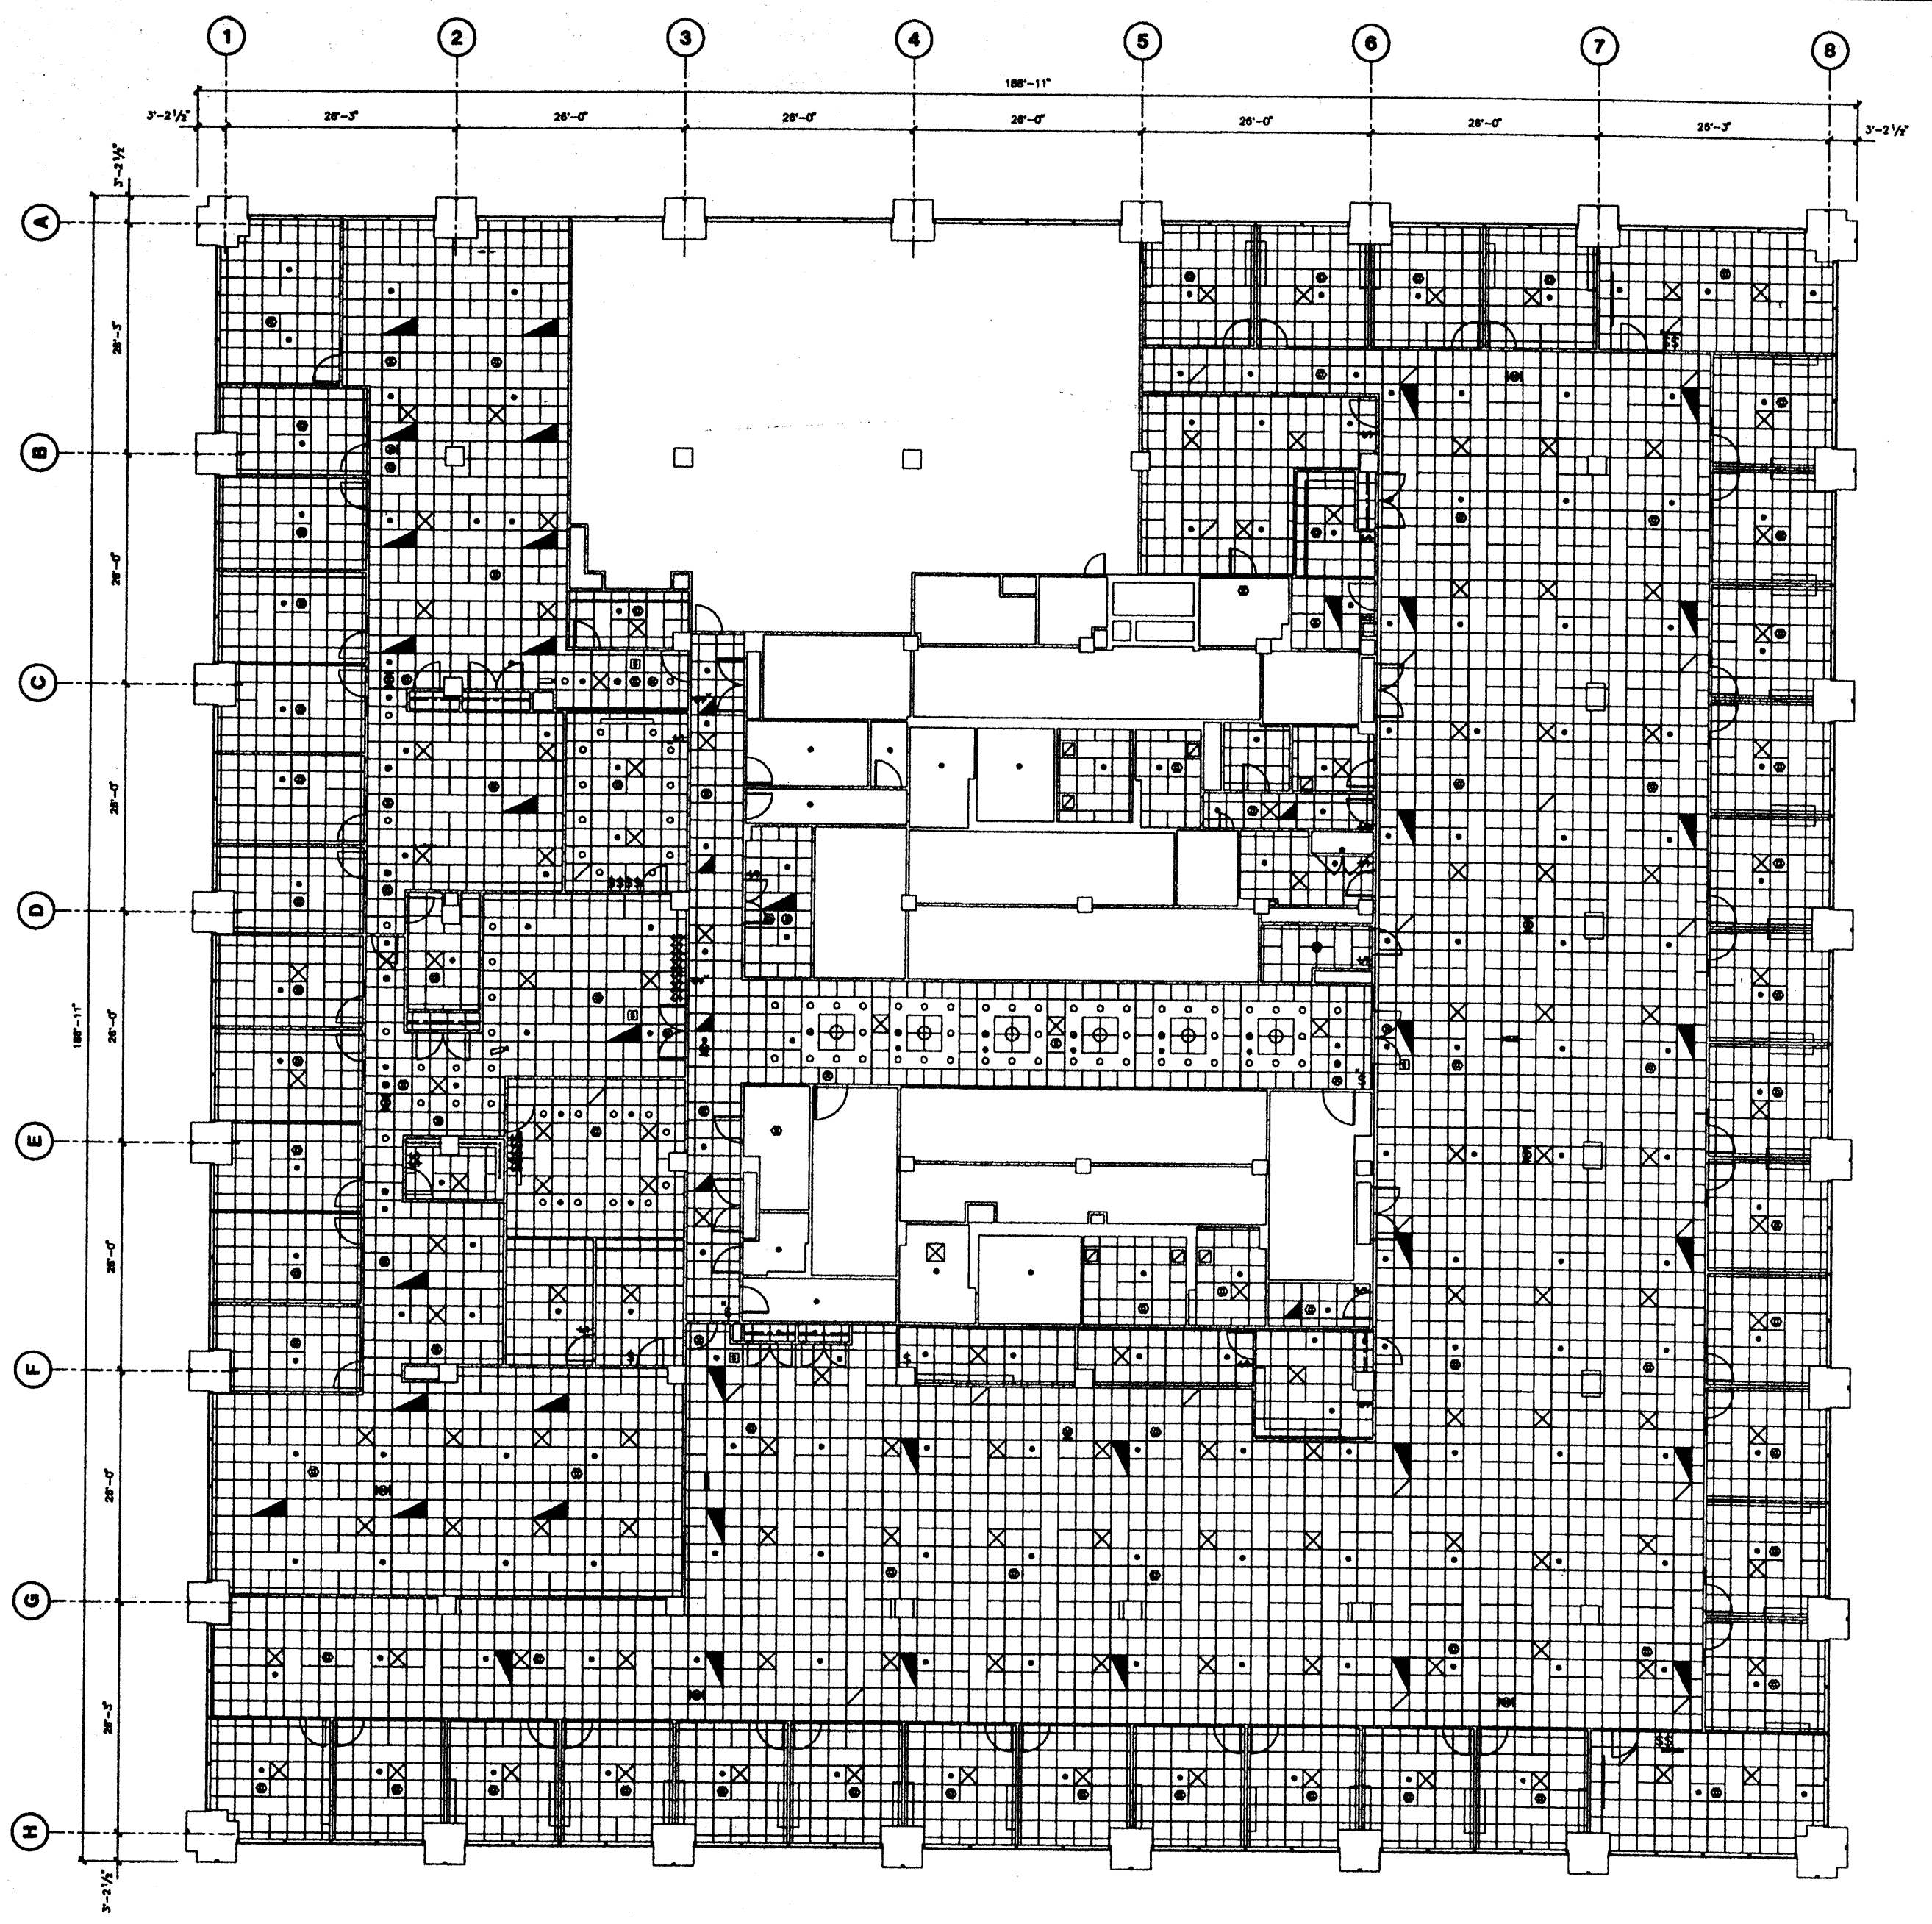

Deutsche Bank


No.	Date	Description
1	7/15/99	Update / Recondition interior construction per Deck 1st
2	1/28/98	Update for Existing Conditions
3	4/18/97	Update for Existing Conditions
4	3/9/96	Project #P0001438 - Delta Securities Hedge Fund
5	7/15/96	Update for Existing Deck Survey
6	10/1/96	Project #P0001437 - Comstock APN001 Remodel
7	8/1/96	Project #P0001439 - Comstock APN001 Remodel
8	5/25/01	Update for Existing Conditions

No.	Date	Issued To

PROJECT
130 LIBERTY STREET
 27th FLOOR
CEILING PLAN

Drawn By	
Checked By	
Date	5/25/01
Scale	
Project No.	



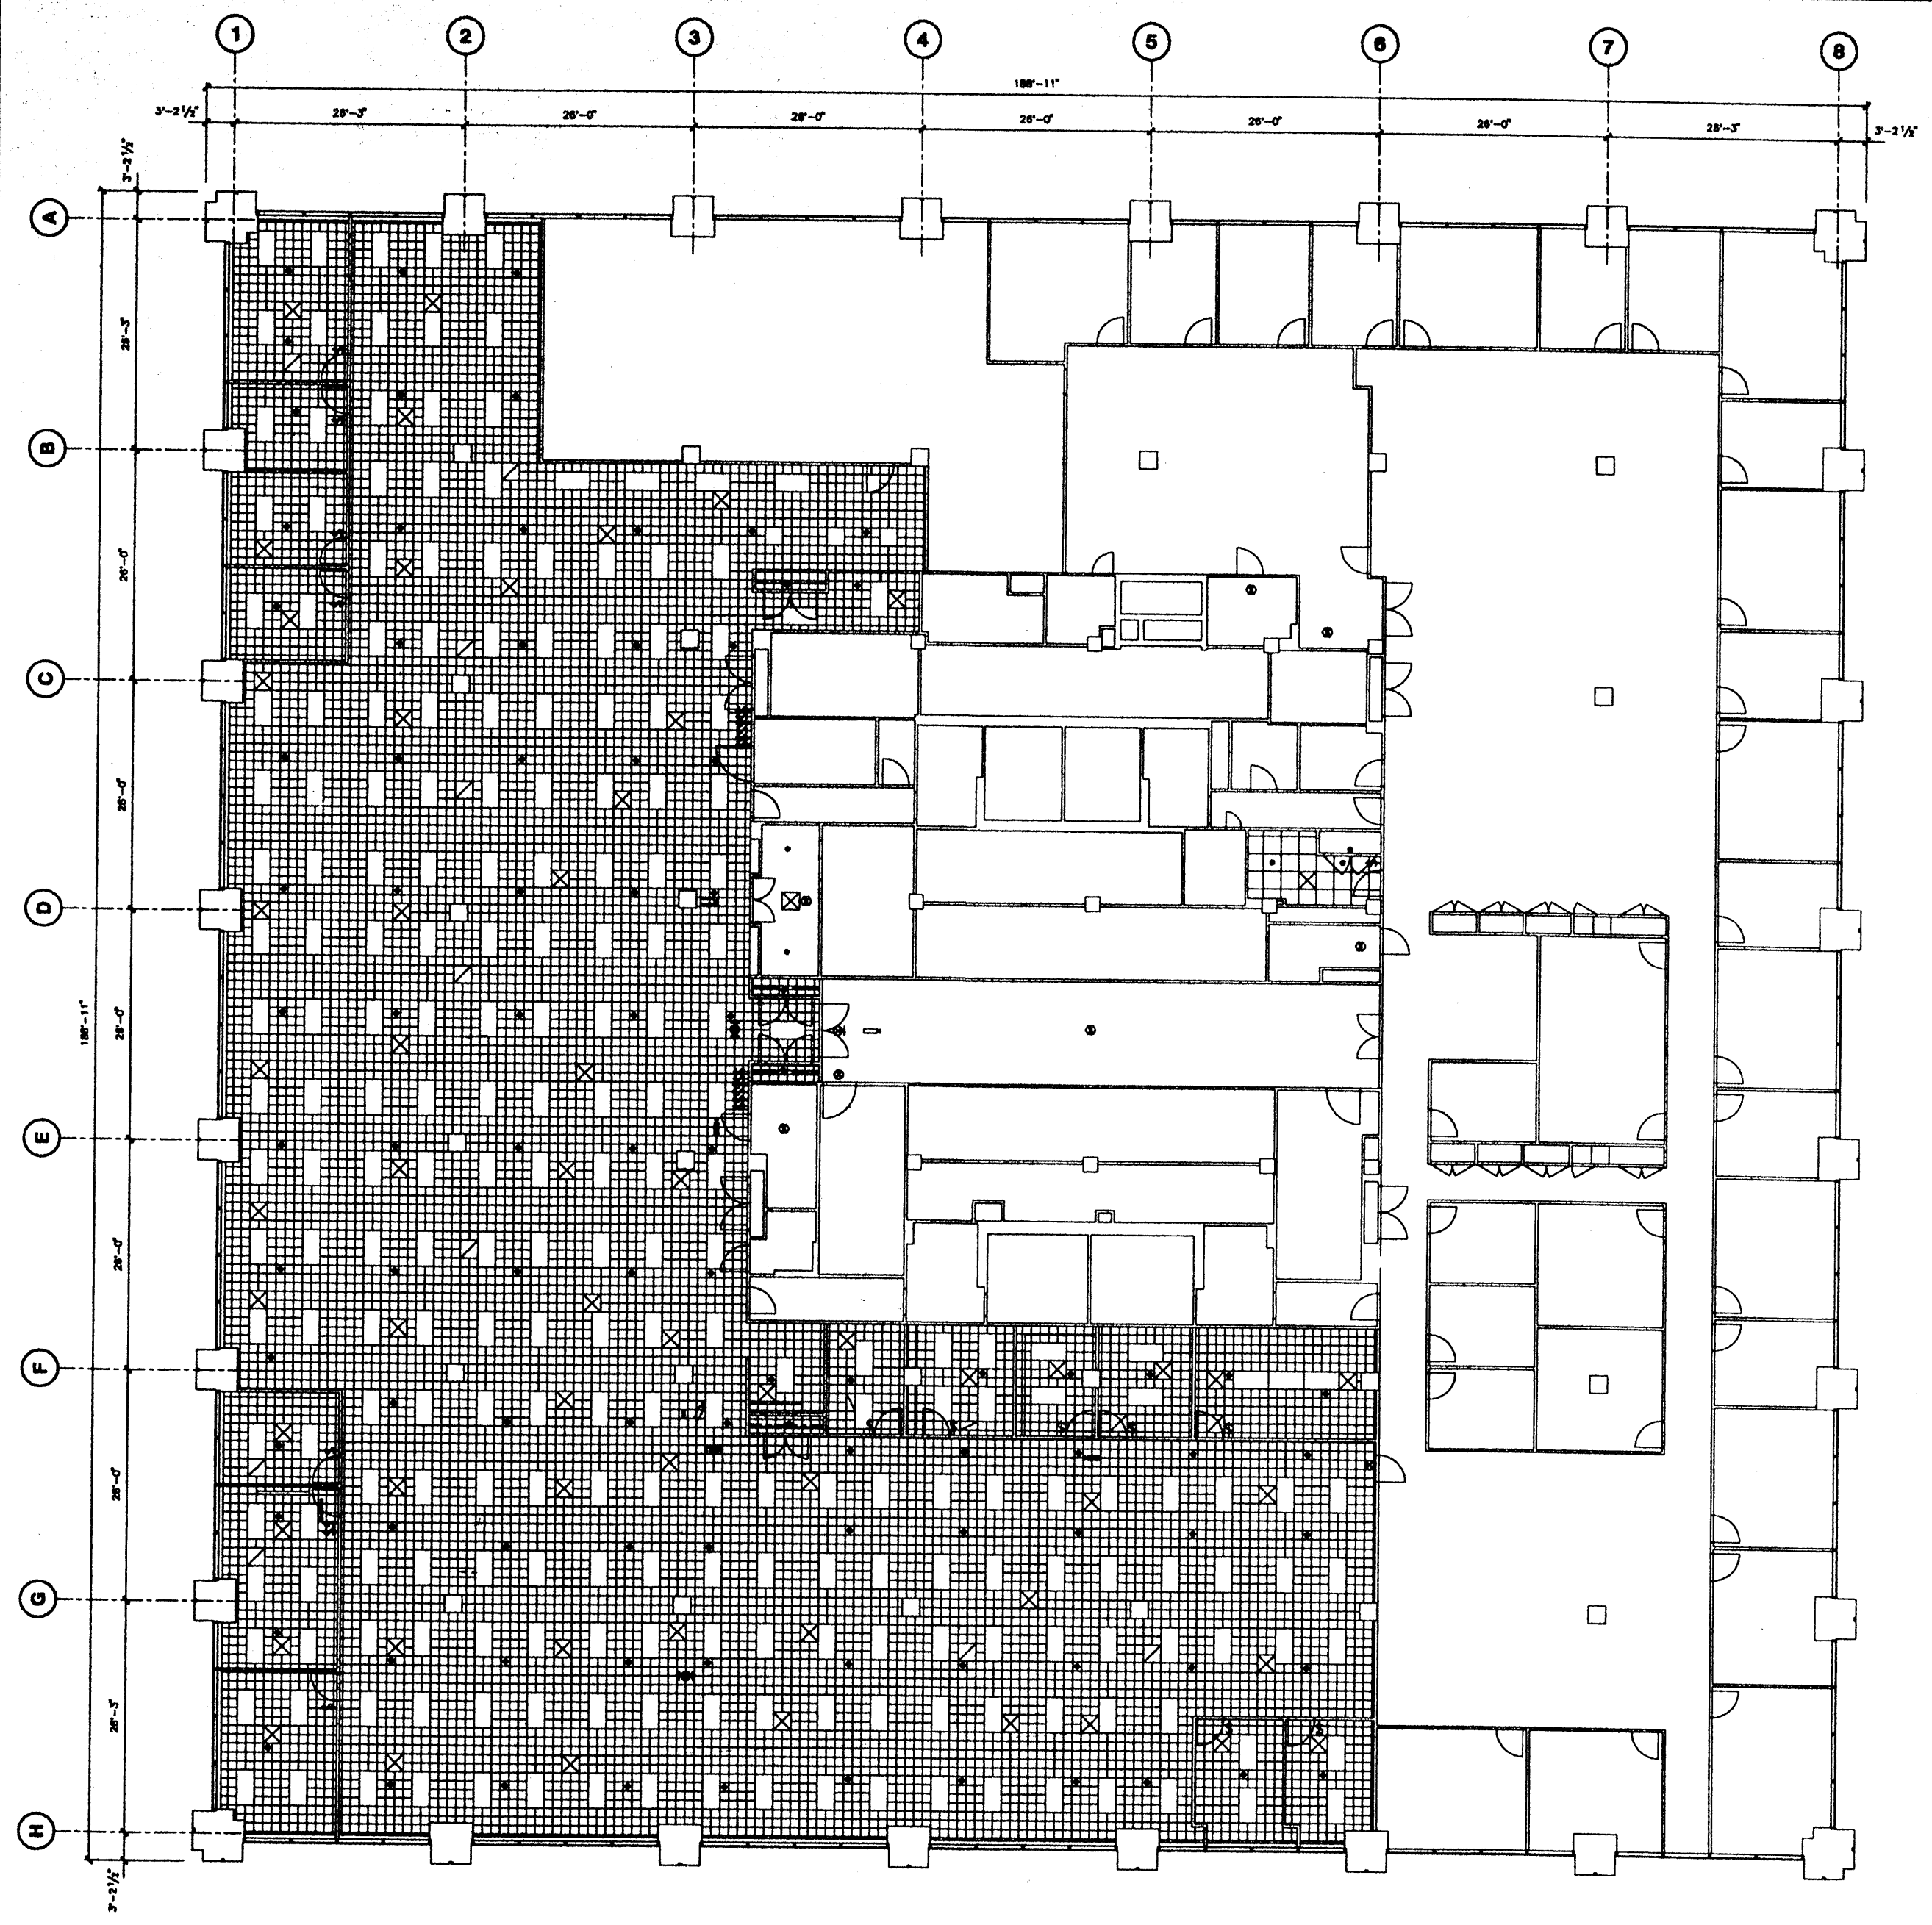

Deutsche Bank


No.	Date	Description
1	4/1/98	Project 980000000 - 26th Flr. Recovery
2	5/1/97	Project 980000000 - 26th Flr. Recovery
3	7/15/98	Updated for Electric Cloud Survey

No.	Date	Revised To

PROJECT
130 LIBERTY STREET
 26th FLOOR
CEILING PLAN



Drawn by	
Checked by	
Date	7/15/98
Scale	
Project No.	

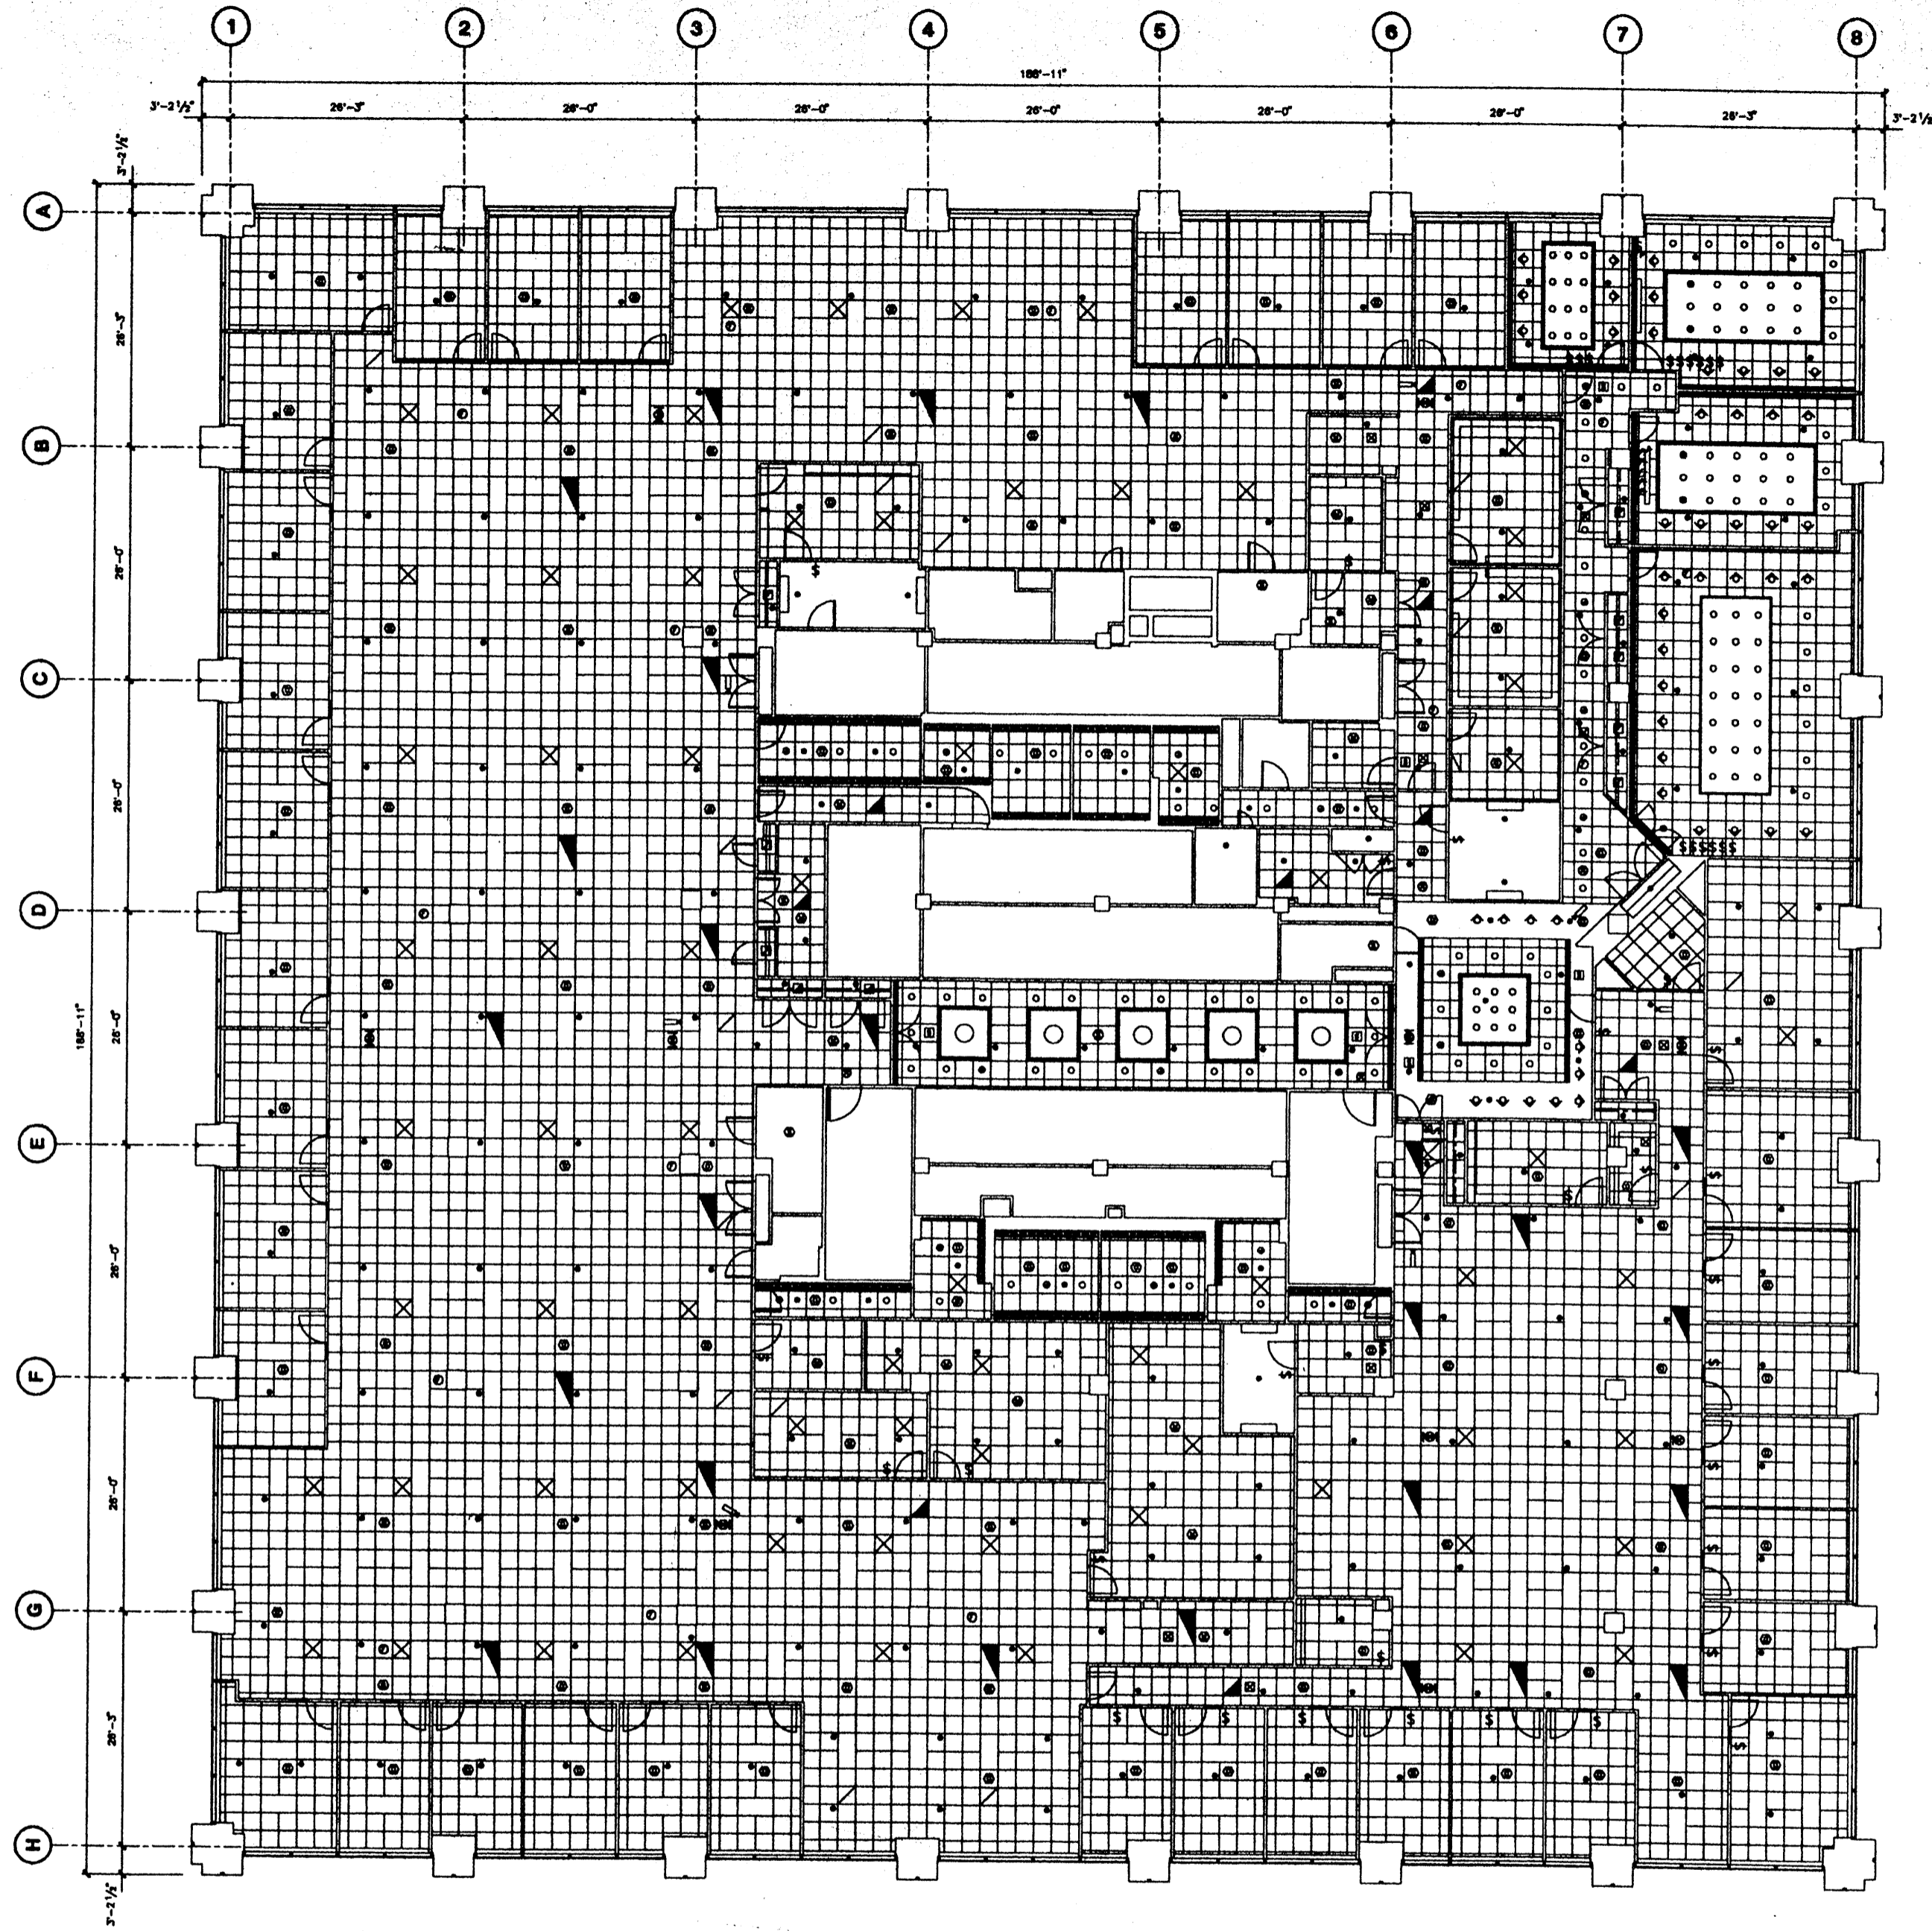

Deutsche Bank

No.	Date	Description
1	7/12/97	Project 98000000 - 25th Floor Supply Schedule
2	7/18/98	Updated for Deutsche Bank Project
3	4/28/01	Updated for Existing Conditions


No.	Date	Issued To	Notes

PROJECT
130 LIBERTY STREET

WORK AREA
25th FLOOR CEILING PLAN



Drawn By	Checked By	Date	Project No.
		5/25/01	

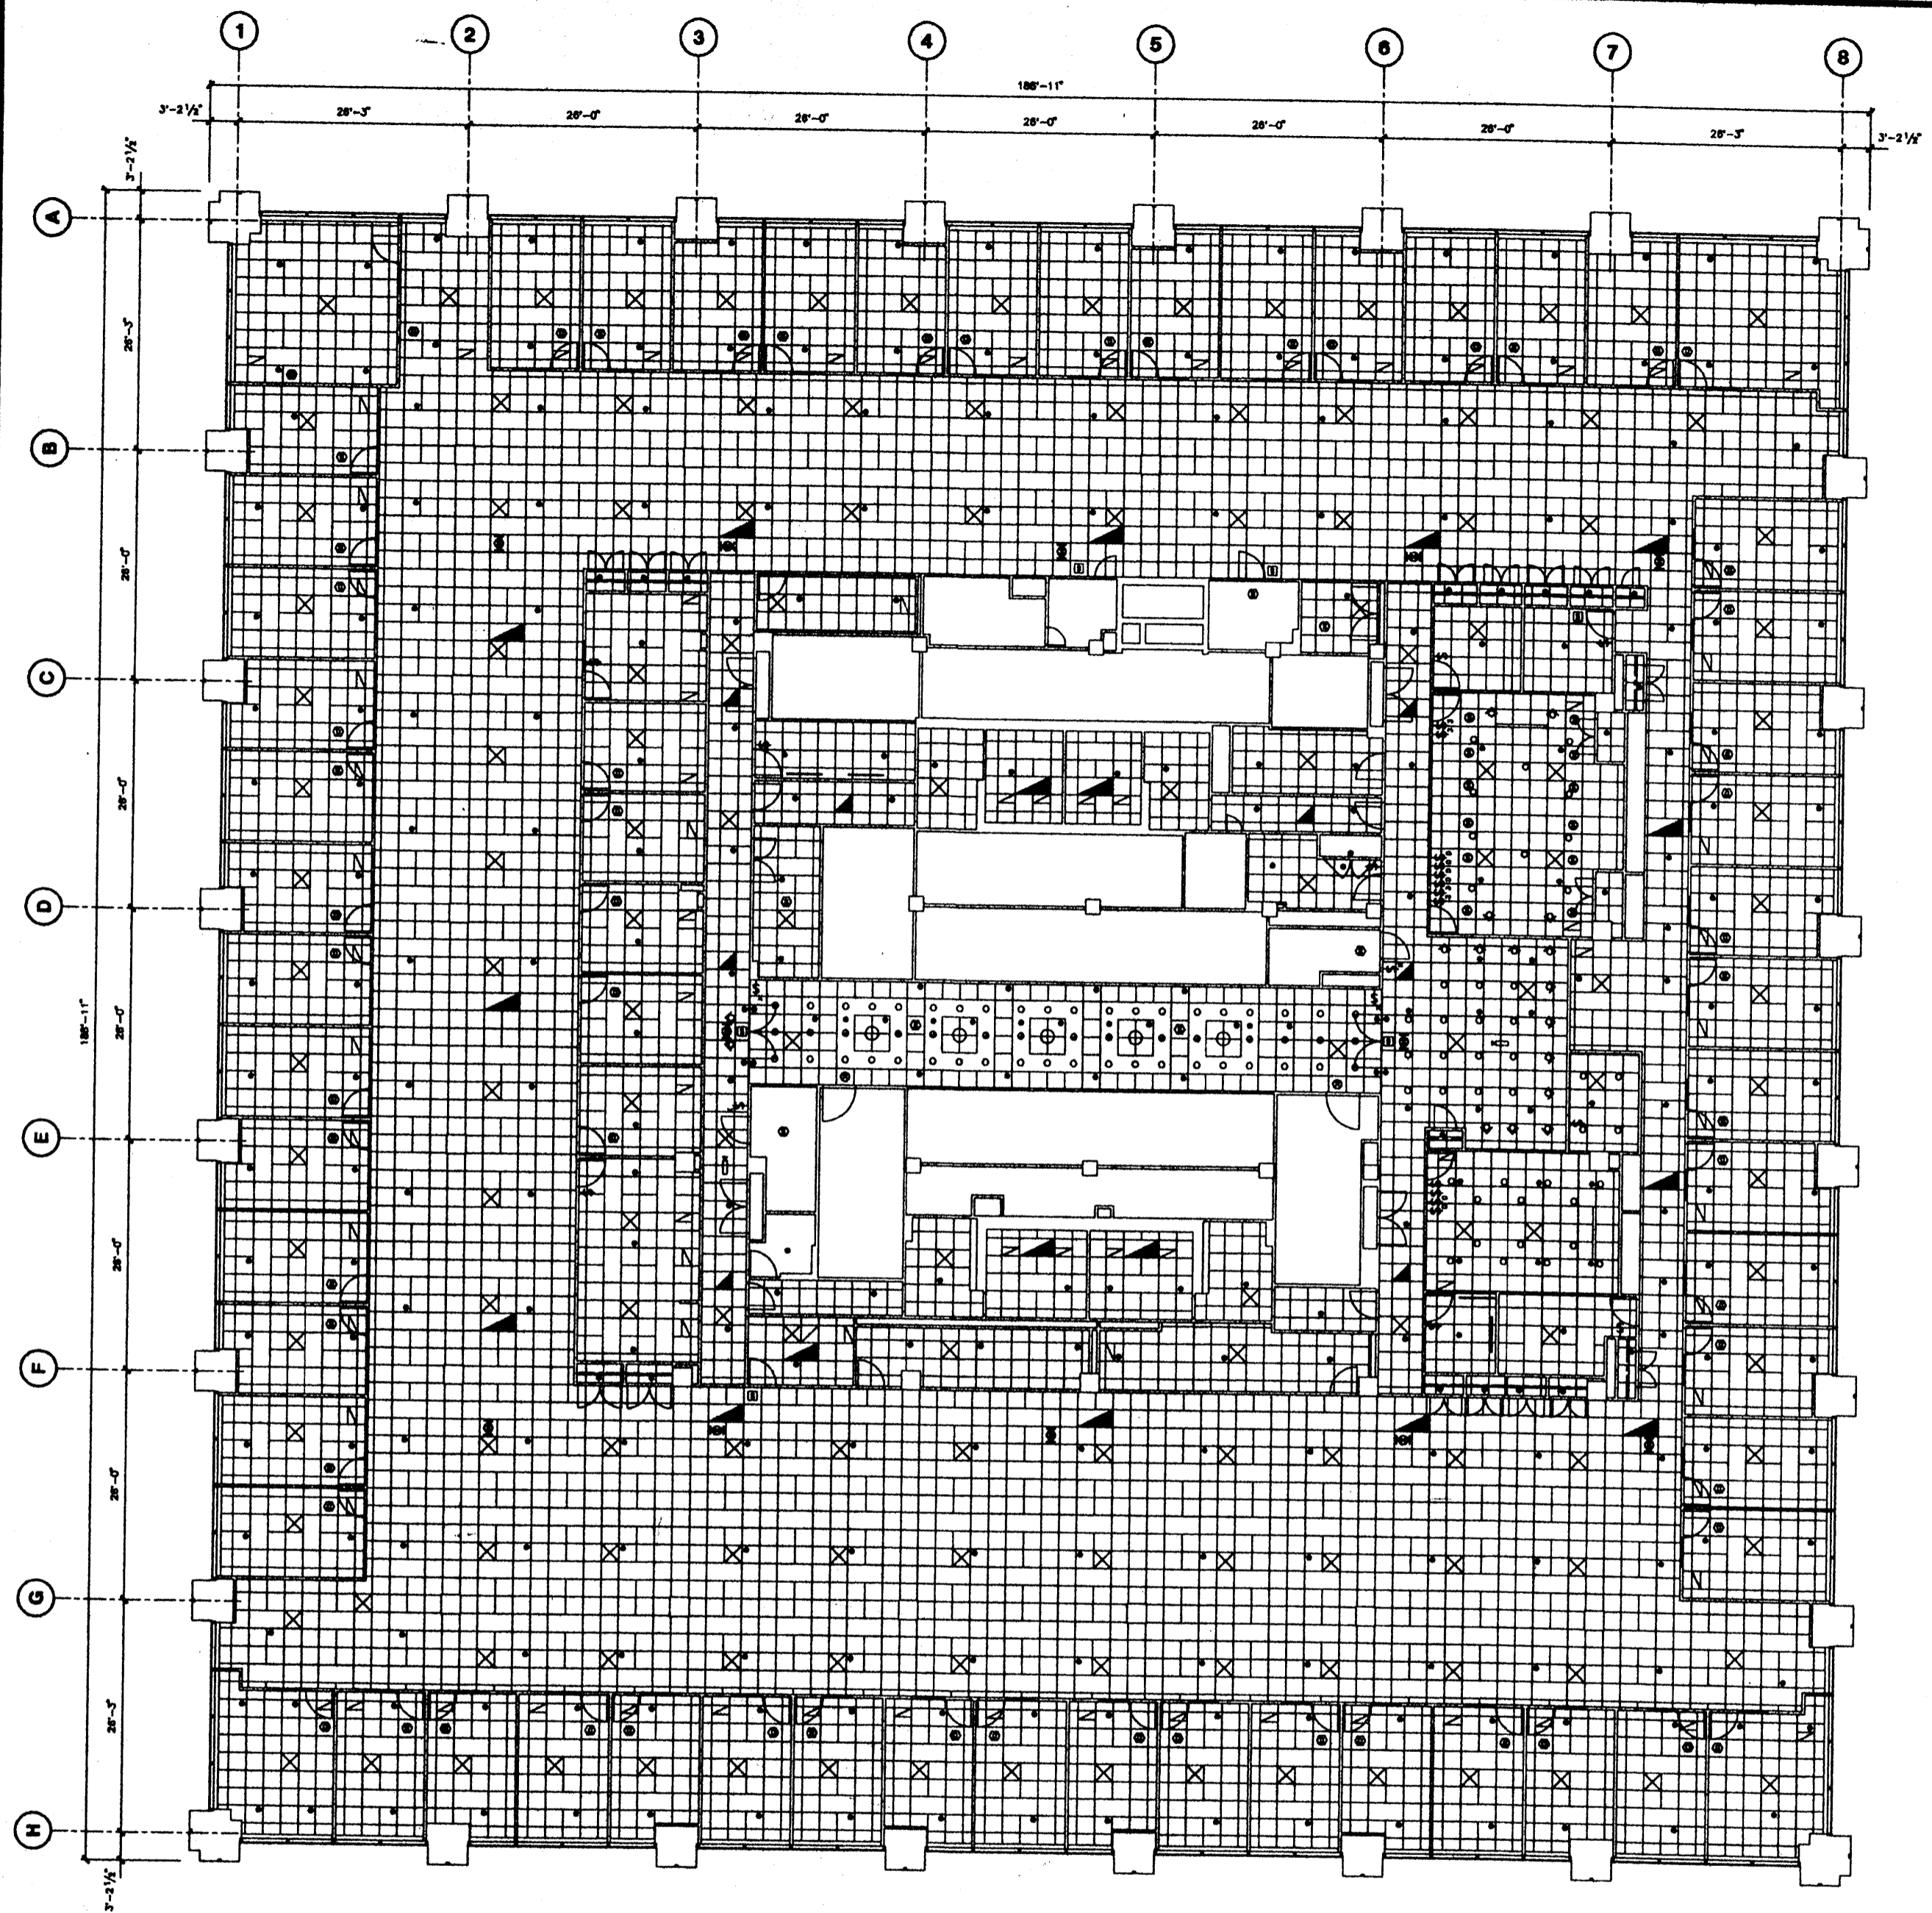

Deutsche Bank


No.	Date	Description
1	12/20/94	Design: 822000000 - CBS Technology Group
2	7/16/96	Updated for Deutsche Credit Group
3	8/1/2000	Project: 800002004

No.	Date	Issued To

130 LIBERTY STREET
24th FLOOR CEILING PLAN

Drawn By	
Checked By	
Date	8/1/2000
Scale	
Project No.	



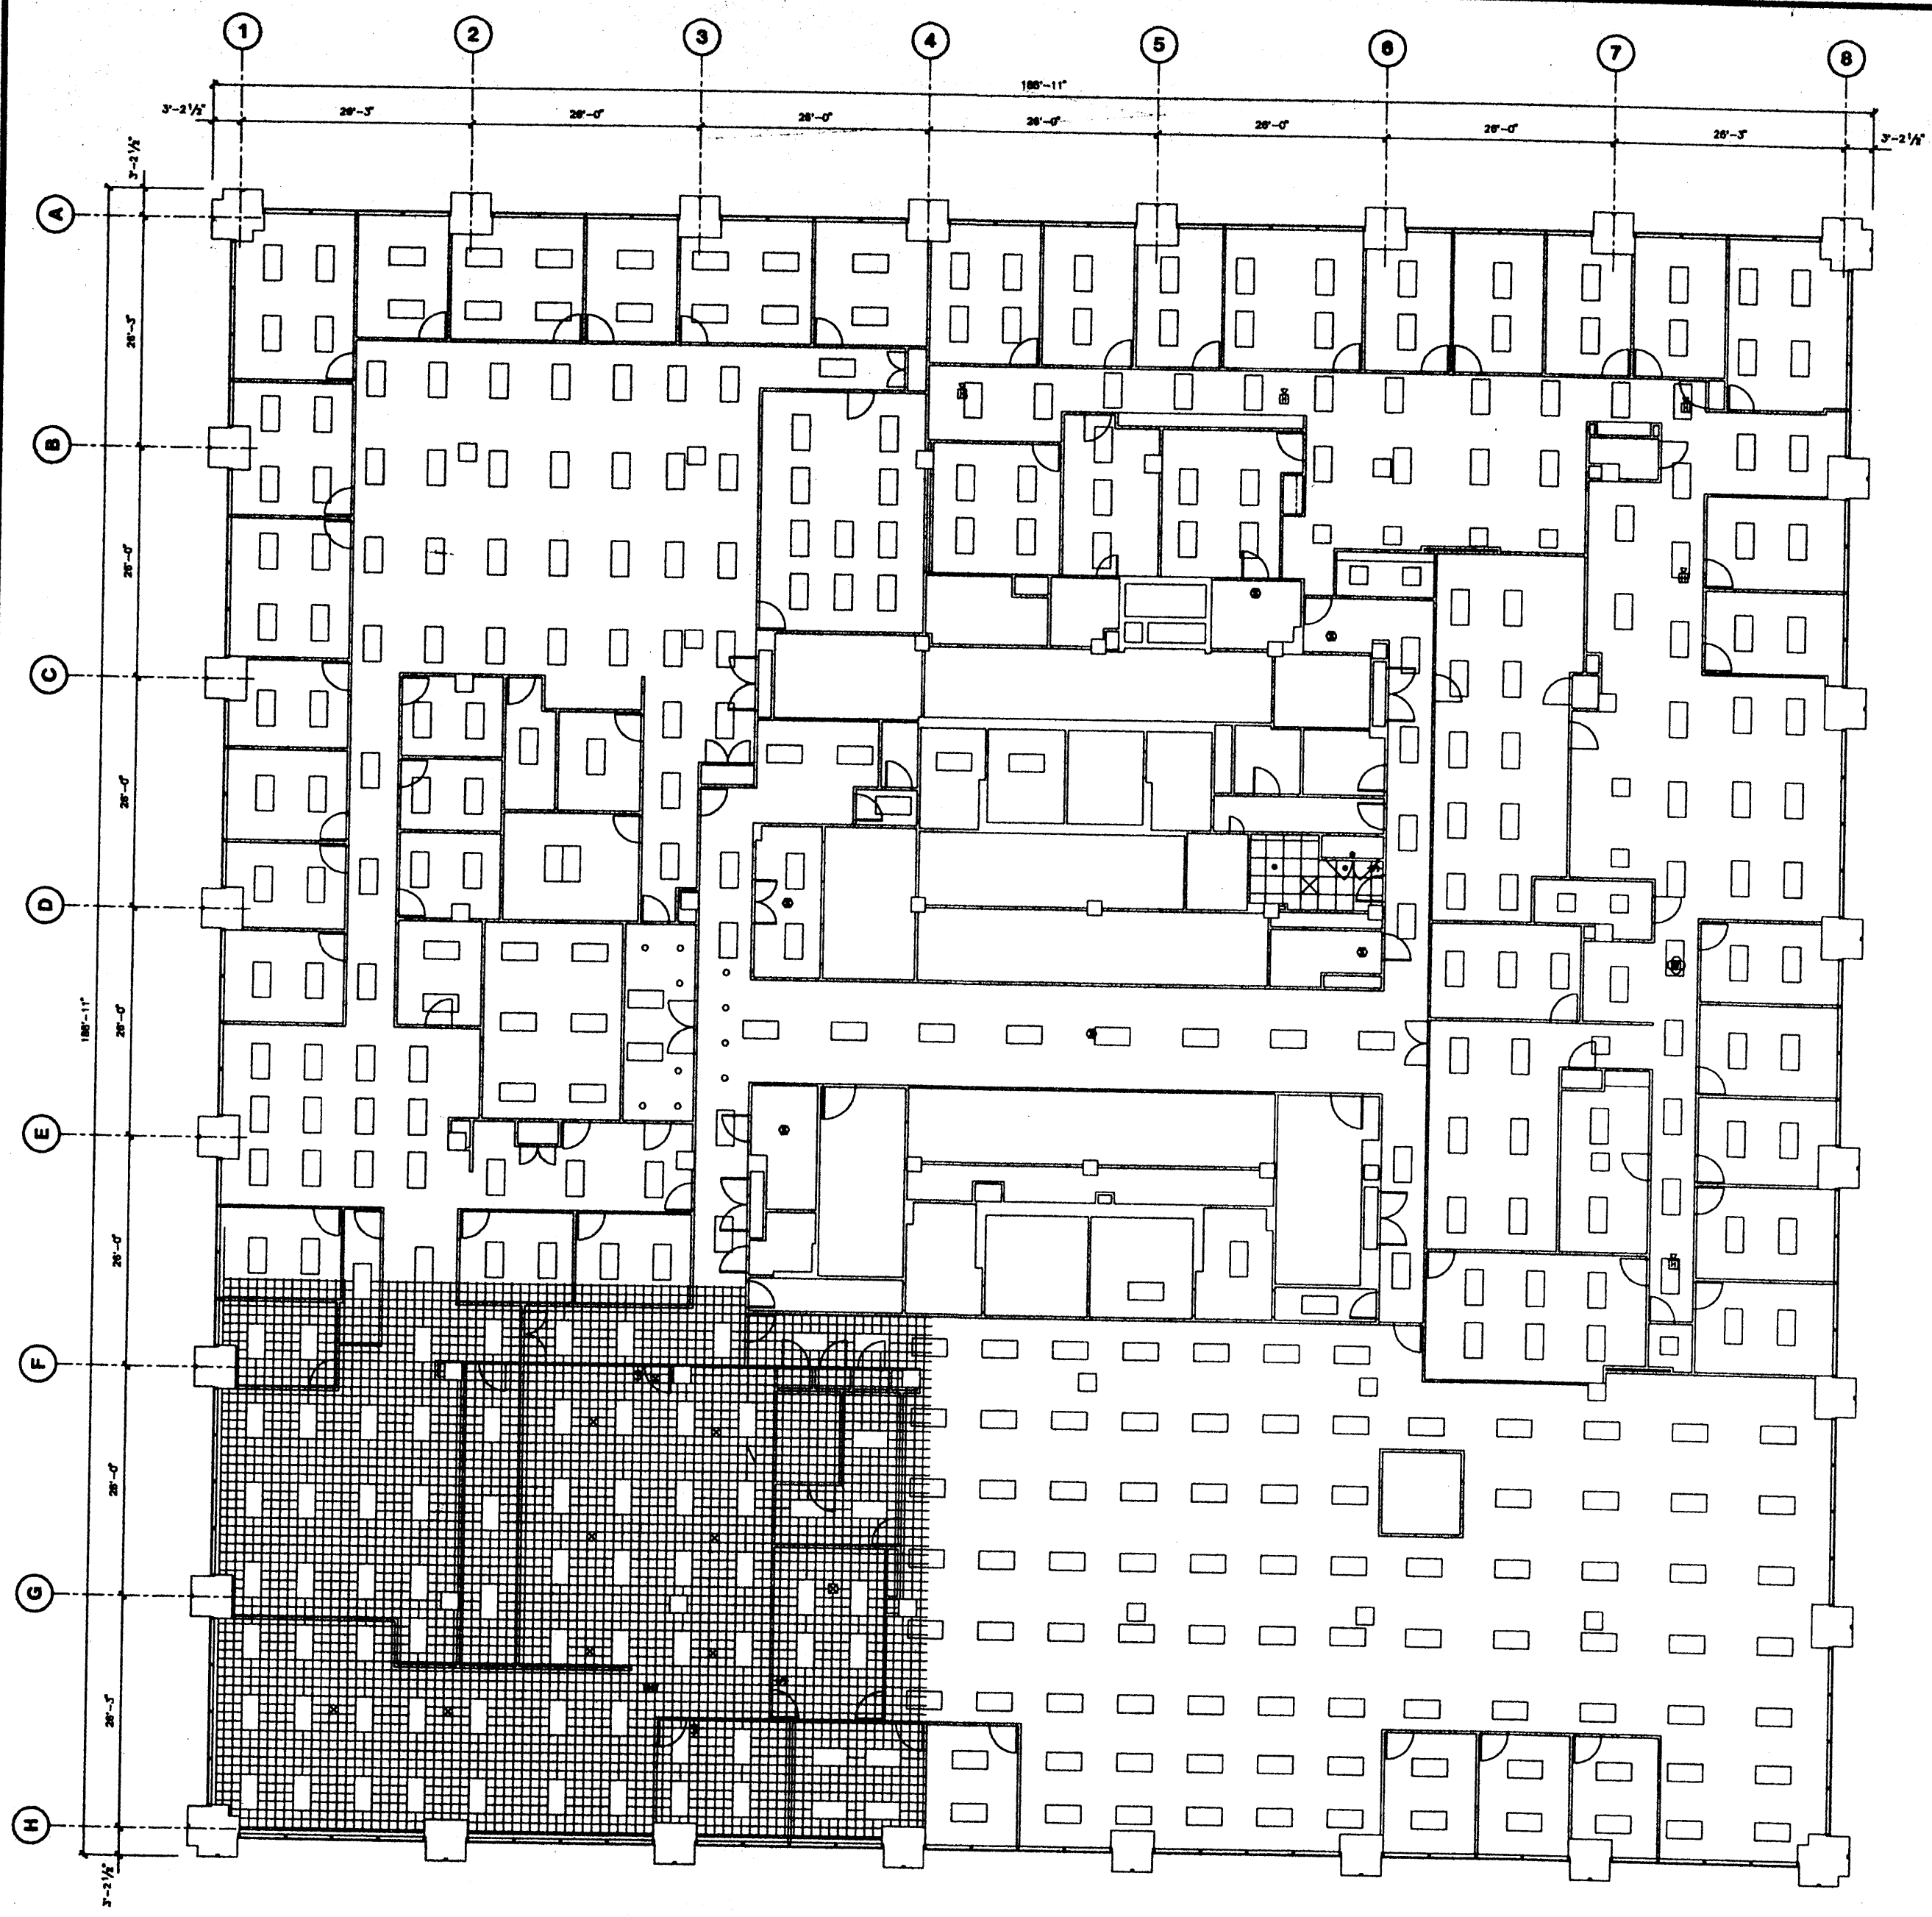

Deutsche Bank

No.	Date	Description
1	1/2/96	Project Initiation - Site Verification/Measurement
2	1/1/96	Project Initiation - Bank Expansion
3	1/1/97	Project Initiation - Initial Ceiling Layout
4	7/15/98	Updated for Electric Cable Strategy
5	1/1/01	Updated for Ceiling Condition


No.	Date	Revised To

130 LIBERTY STREET

22nd FLOOR CEILING PLAN



Drawn By	Checked By
Created By	
Date	9/1/01
Project No.	

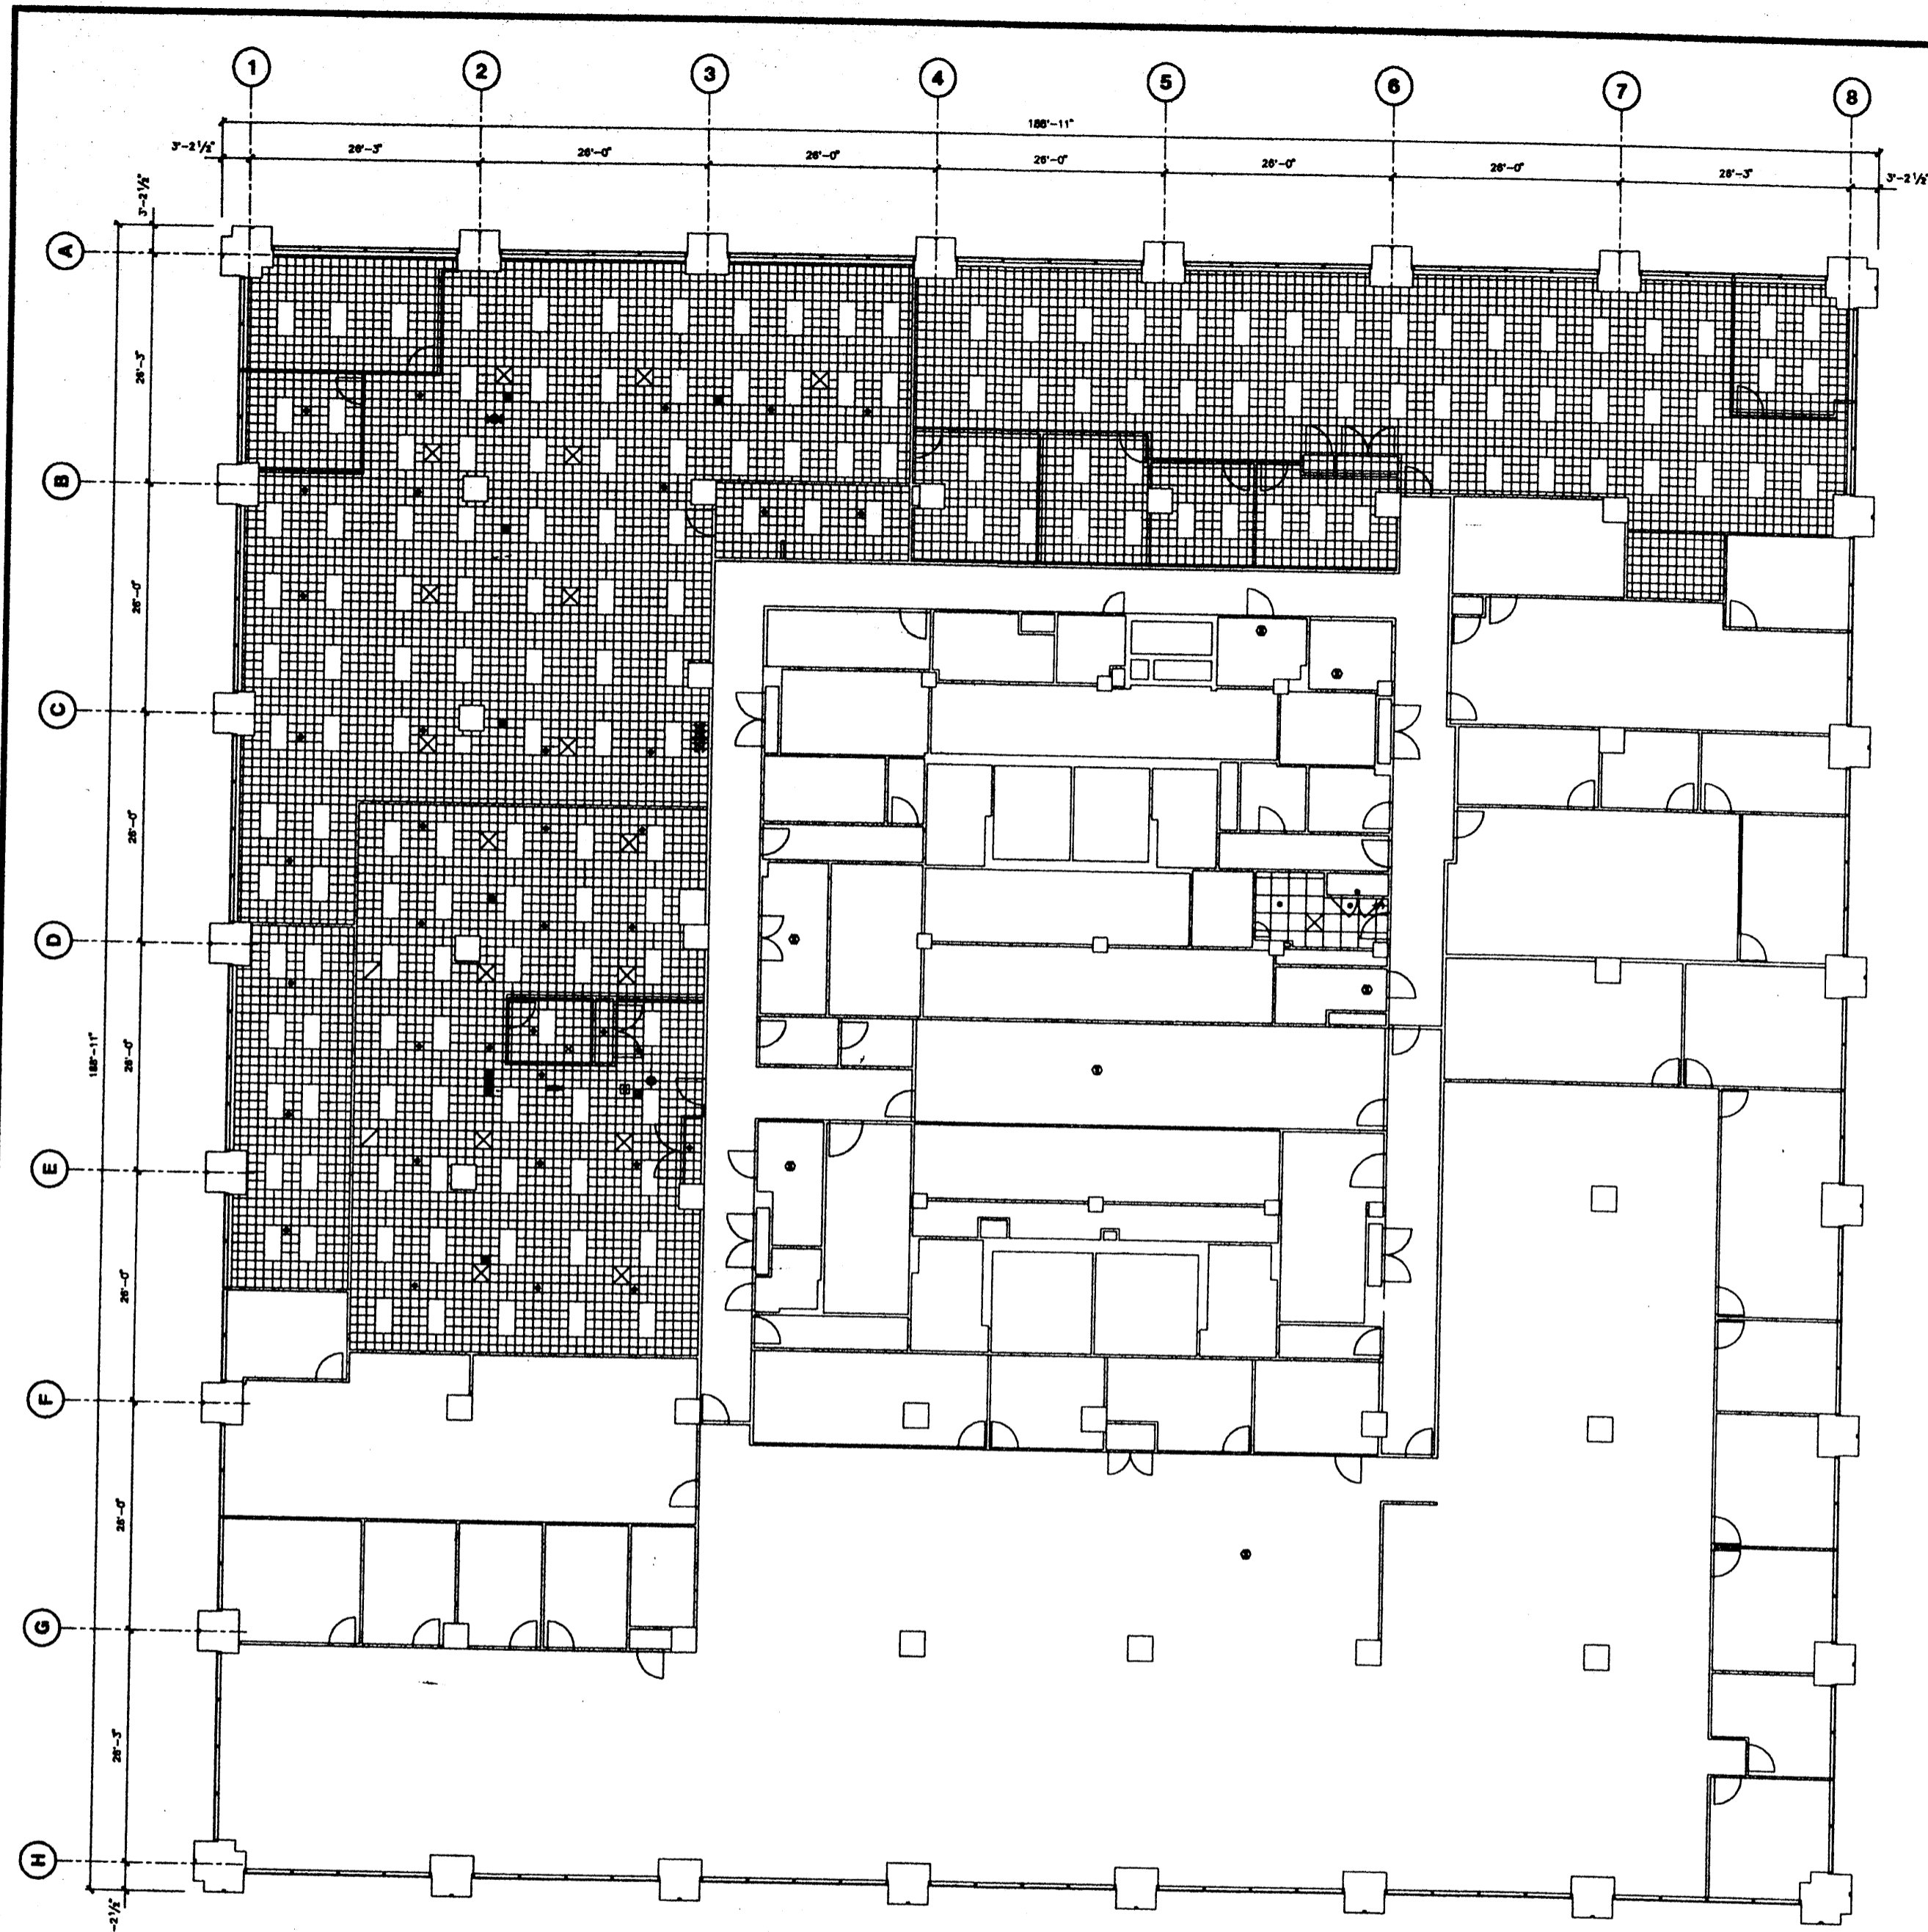

Deutsche Bank

No.	Date	Description
1	11/21/94	Project #000000001 Deutsche Bank Building Management Project #000000001 Release #1 F00
2	5/1/96	Project #000000277 Contractor Fee
3	6/21/96	Project #???
4	5/28/97	Updated for Existing Conditions
5	7/15/98	Updated for Electric Panel Survey


No.	Date	Issued To

130 LIBERTY STREET

23rd FLOOR
CEILING
PLAN

Drawn By	
Checked By	
Date	7/15/98
Project No.	



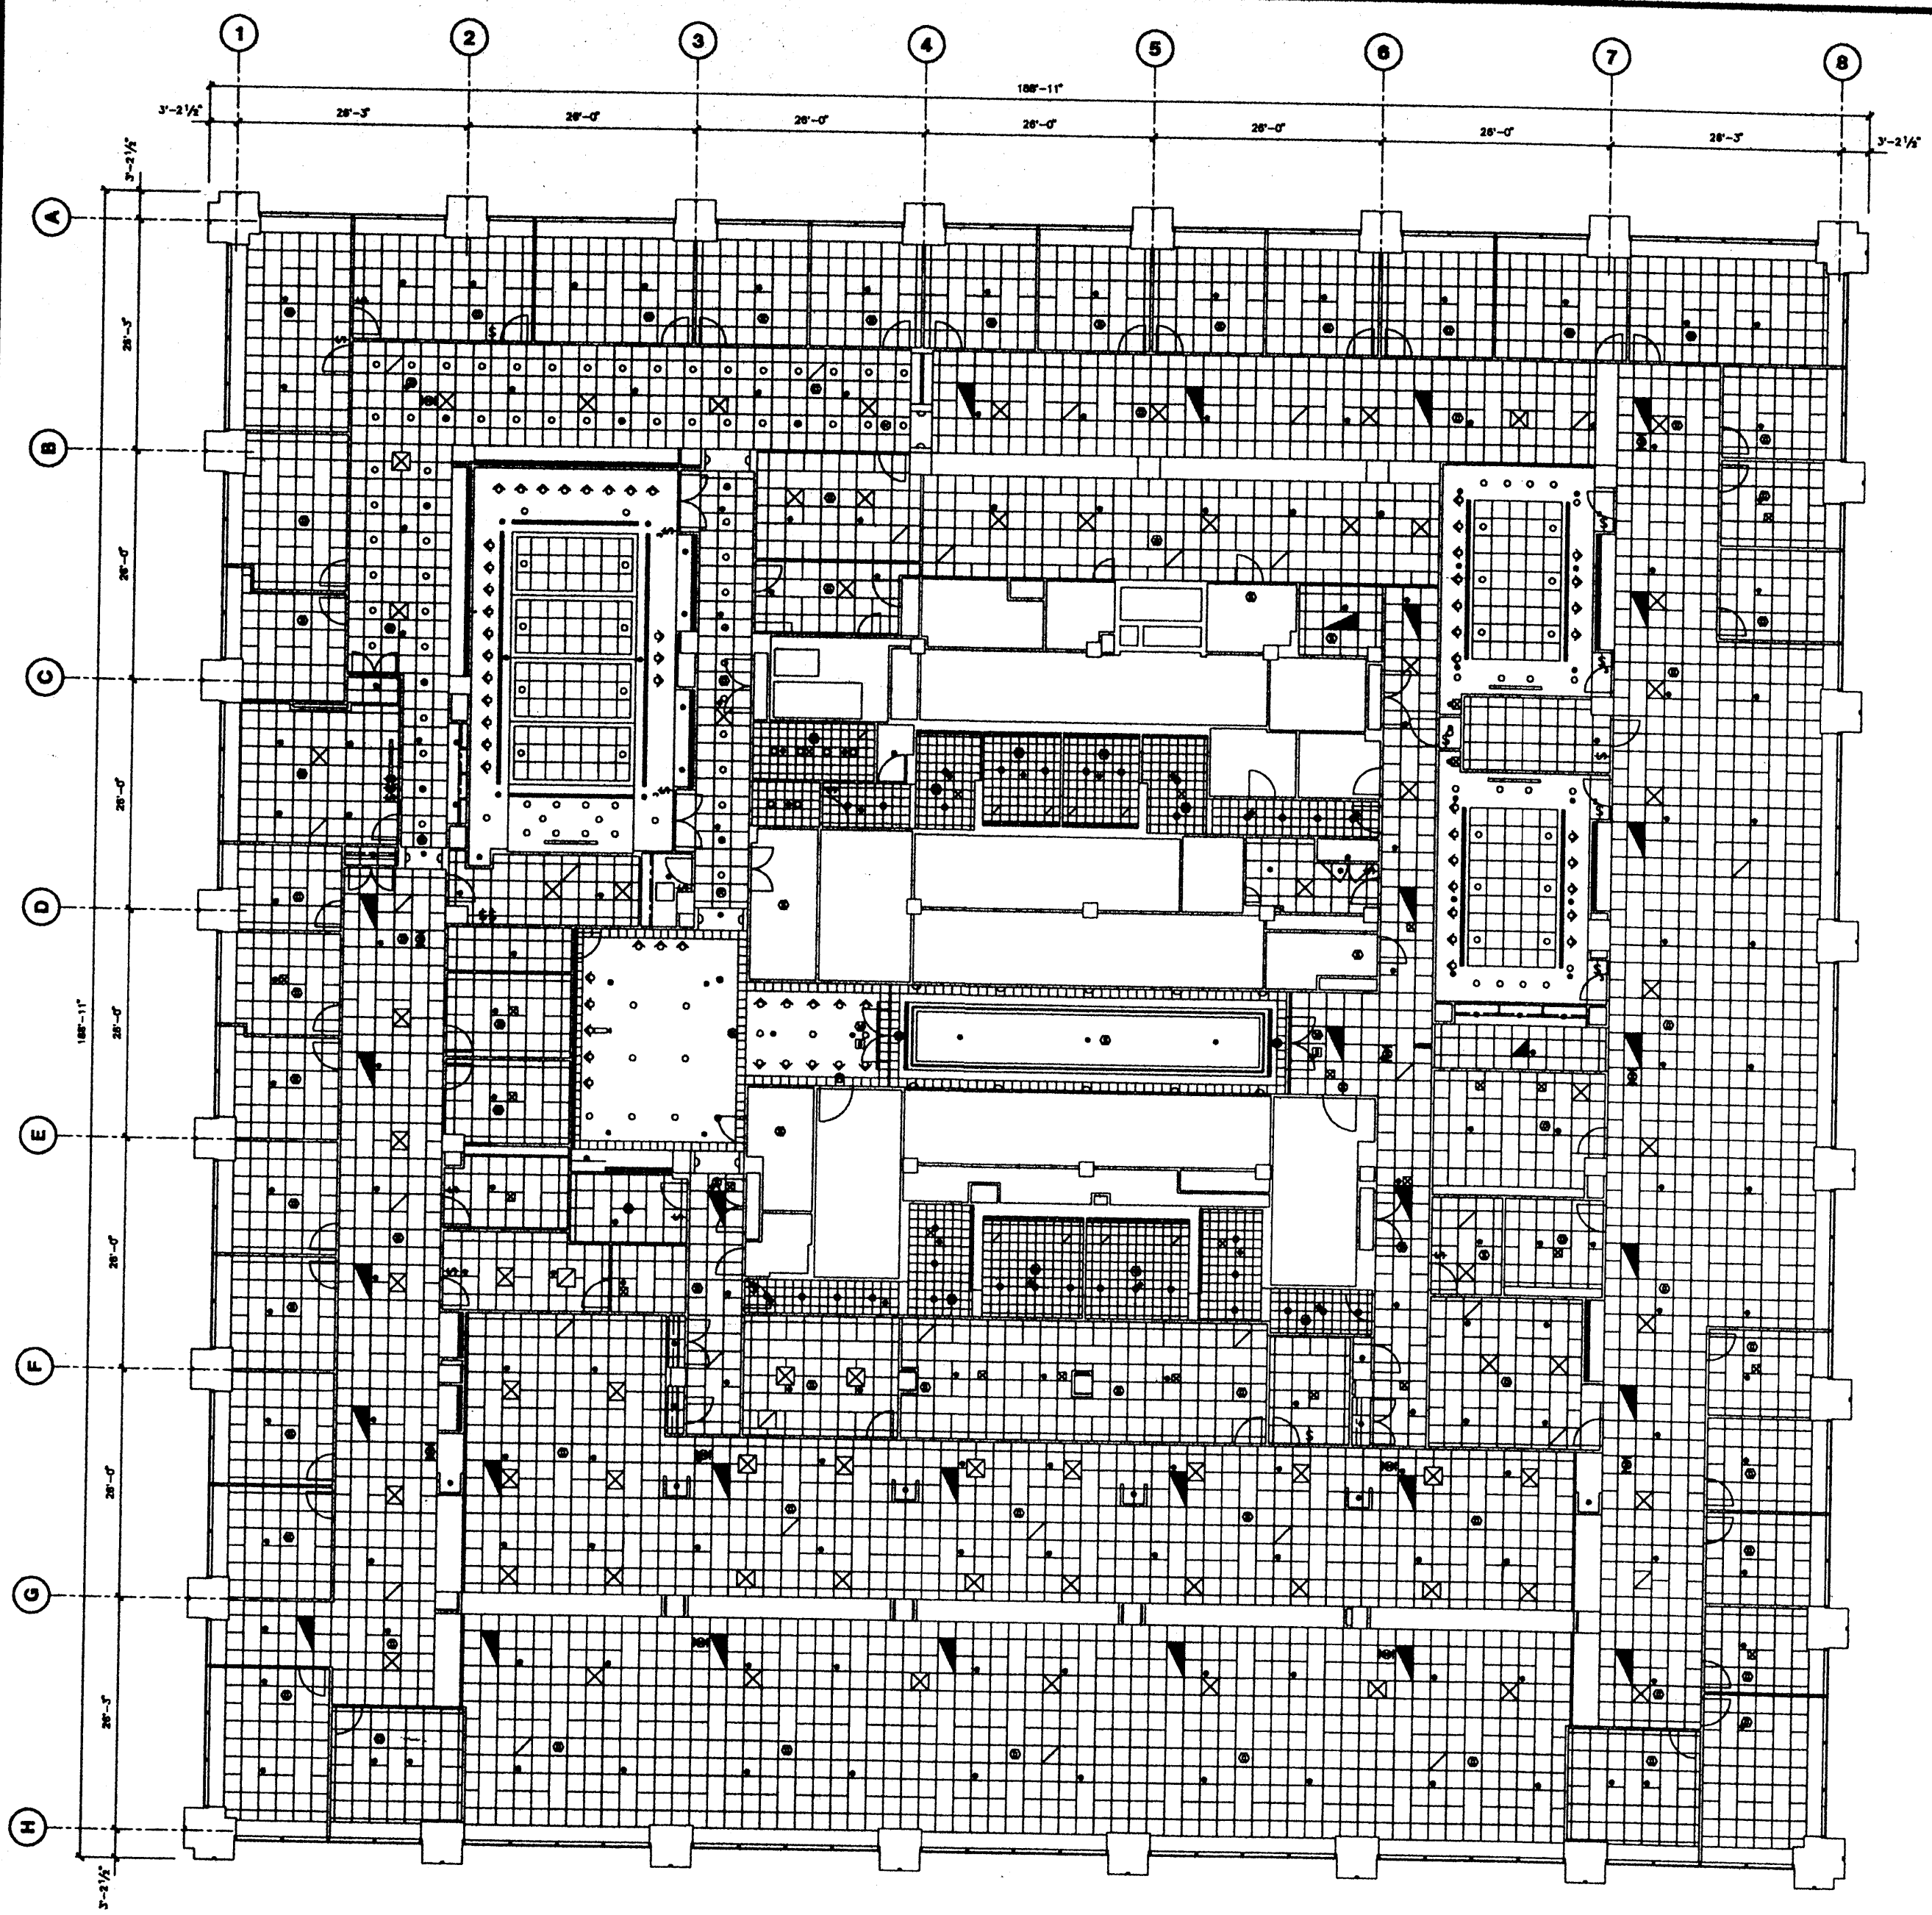

Deutsche Bank


No.	Date	Description
1	8/1/83	Update Furniture per Plans
2	8/1/87	Update Furniture per Plans
3	7/15/88	Update for Deutsche Bank
4	4/21/88	Update for Deutsche Bank

No.	Date	Revised To

130 LIBERTY STREET
21st FLOOR
CEILING PLAN

Drawn By	
Checked By	
Date	4/21/88
Scale	
Project No.	



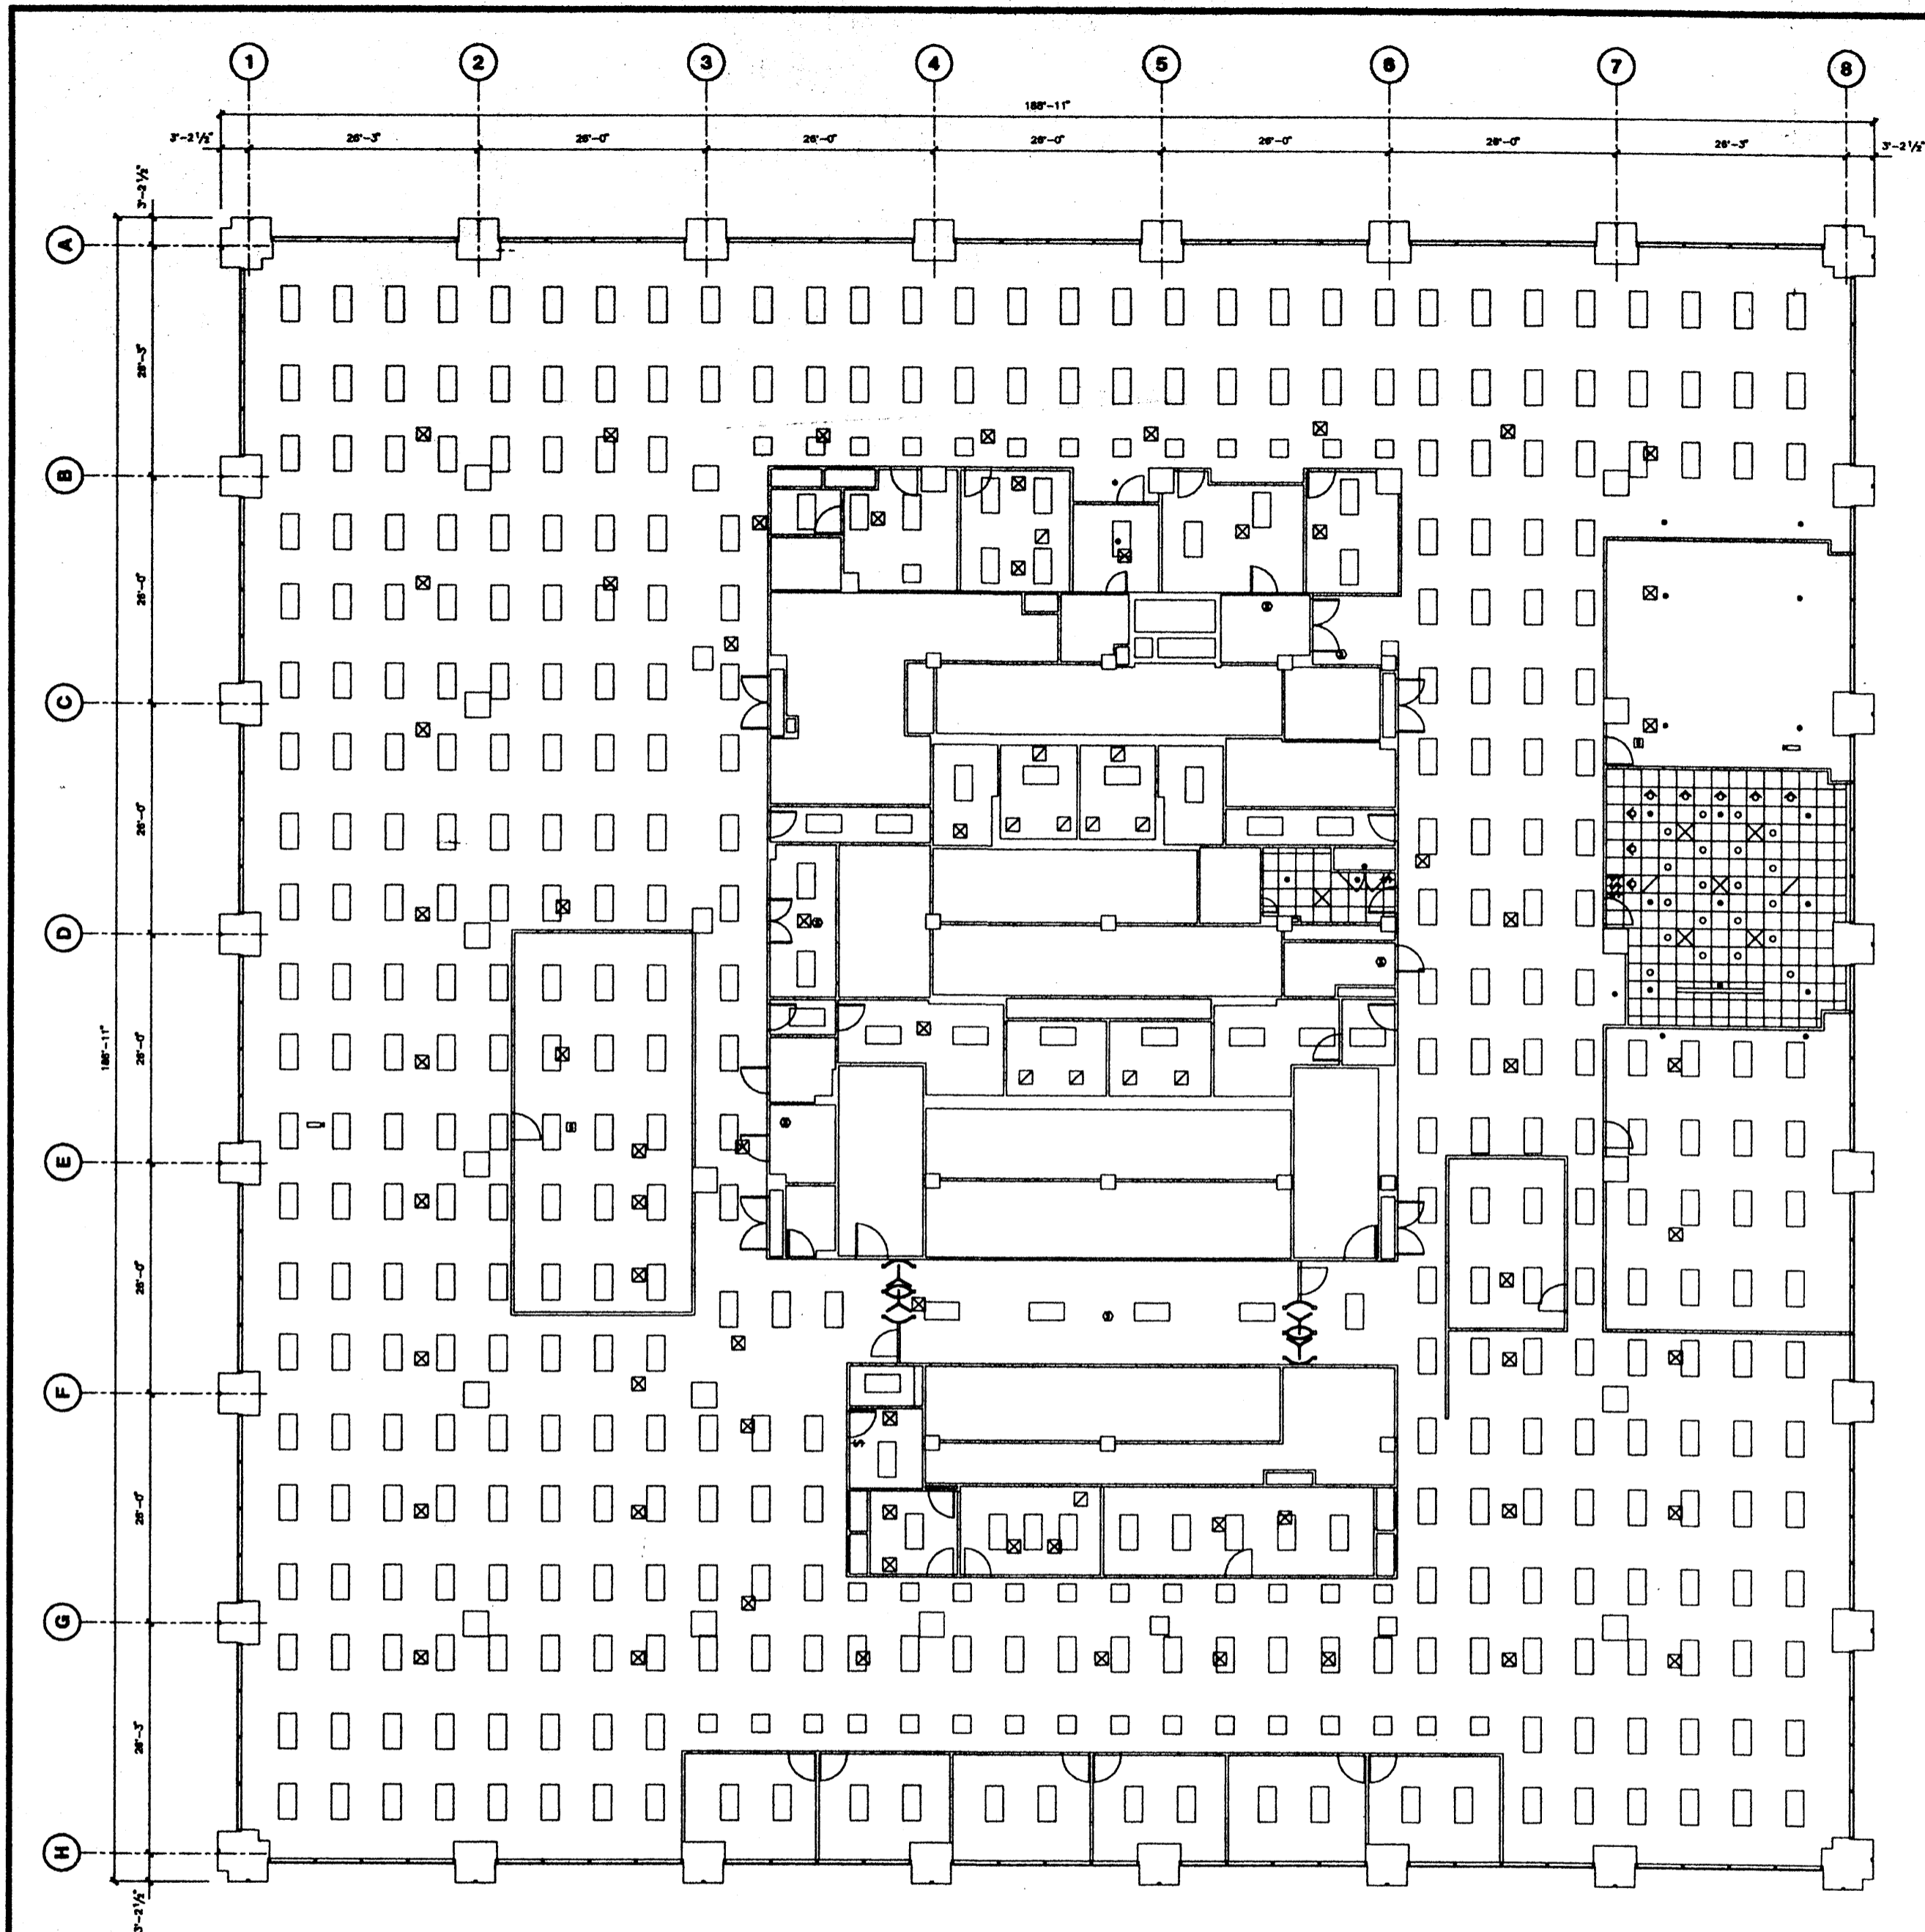

Deutsche Bank

No.	Date	Revised To
1	8/15/91	Final
2	8/1/97	Project No. 82001343 - Update Ceiling Layout
3	7/15/98	Updated for Bank's Client Entry
4	1/20/99	Project No. 82001343 - Entry Upgrade


No.	Date	Revised To

130 LIBERTY STREET

16th FLOOR CEILING PLAN

Made by: _____
 Checked by: _____
 Date: 1/20/99
 Scale: _____
 Project No.: _____



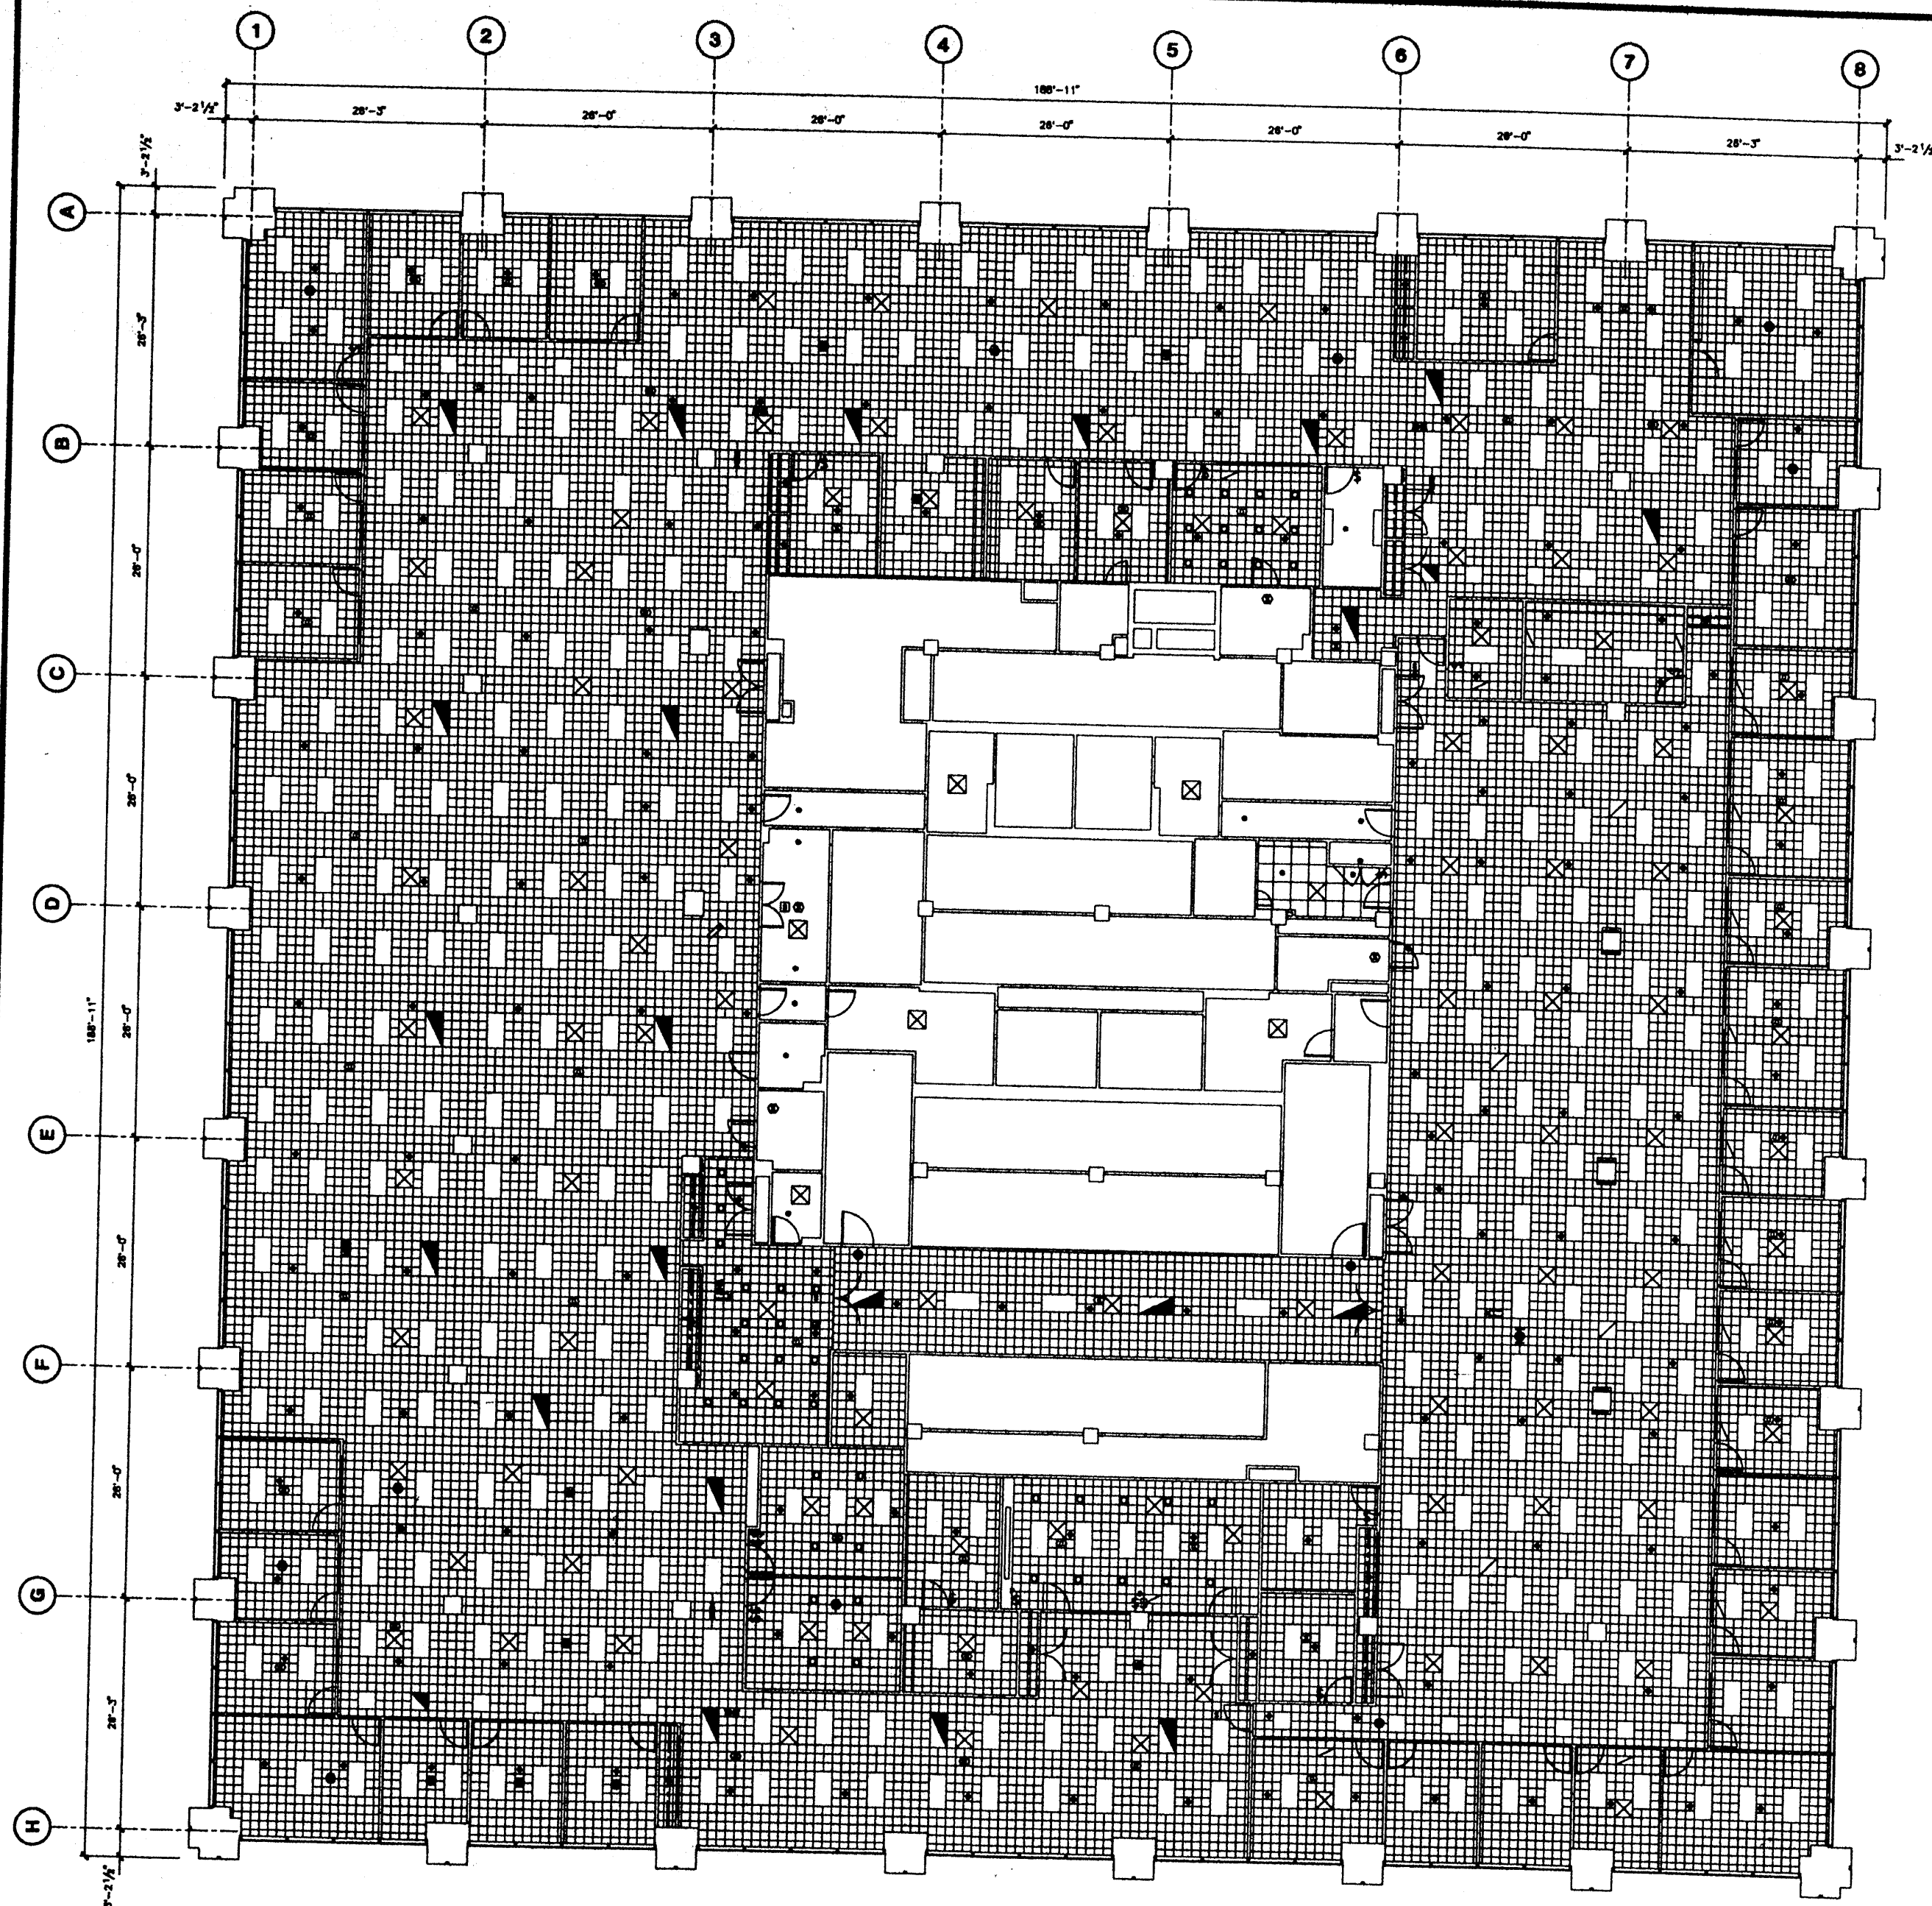

Deutsche Bank

No.	Date	Description
1	5/1/02	Update Furniture per new Panels
2	12/1/02	Project 00001427 - Release CPU and Mary Services
3	5/7/04	Project 00000305 - Annuals Control Tracking
4	5/1/07	Project 00000318 - Update Lighting Layout
5	1/7/08	Project 00000000 - 00 Commission
6	7/15/08	Update for Client's Client Survey
7	5/1/09	Project 00000000 - 00 Commission


No.	Date	Issued To

130 LIBERTY STREET

15th FLOOR CEILING PLAN

Drawn by	Project No.
Checked by	
Date	5/1/01
Scale	
Project No.	



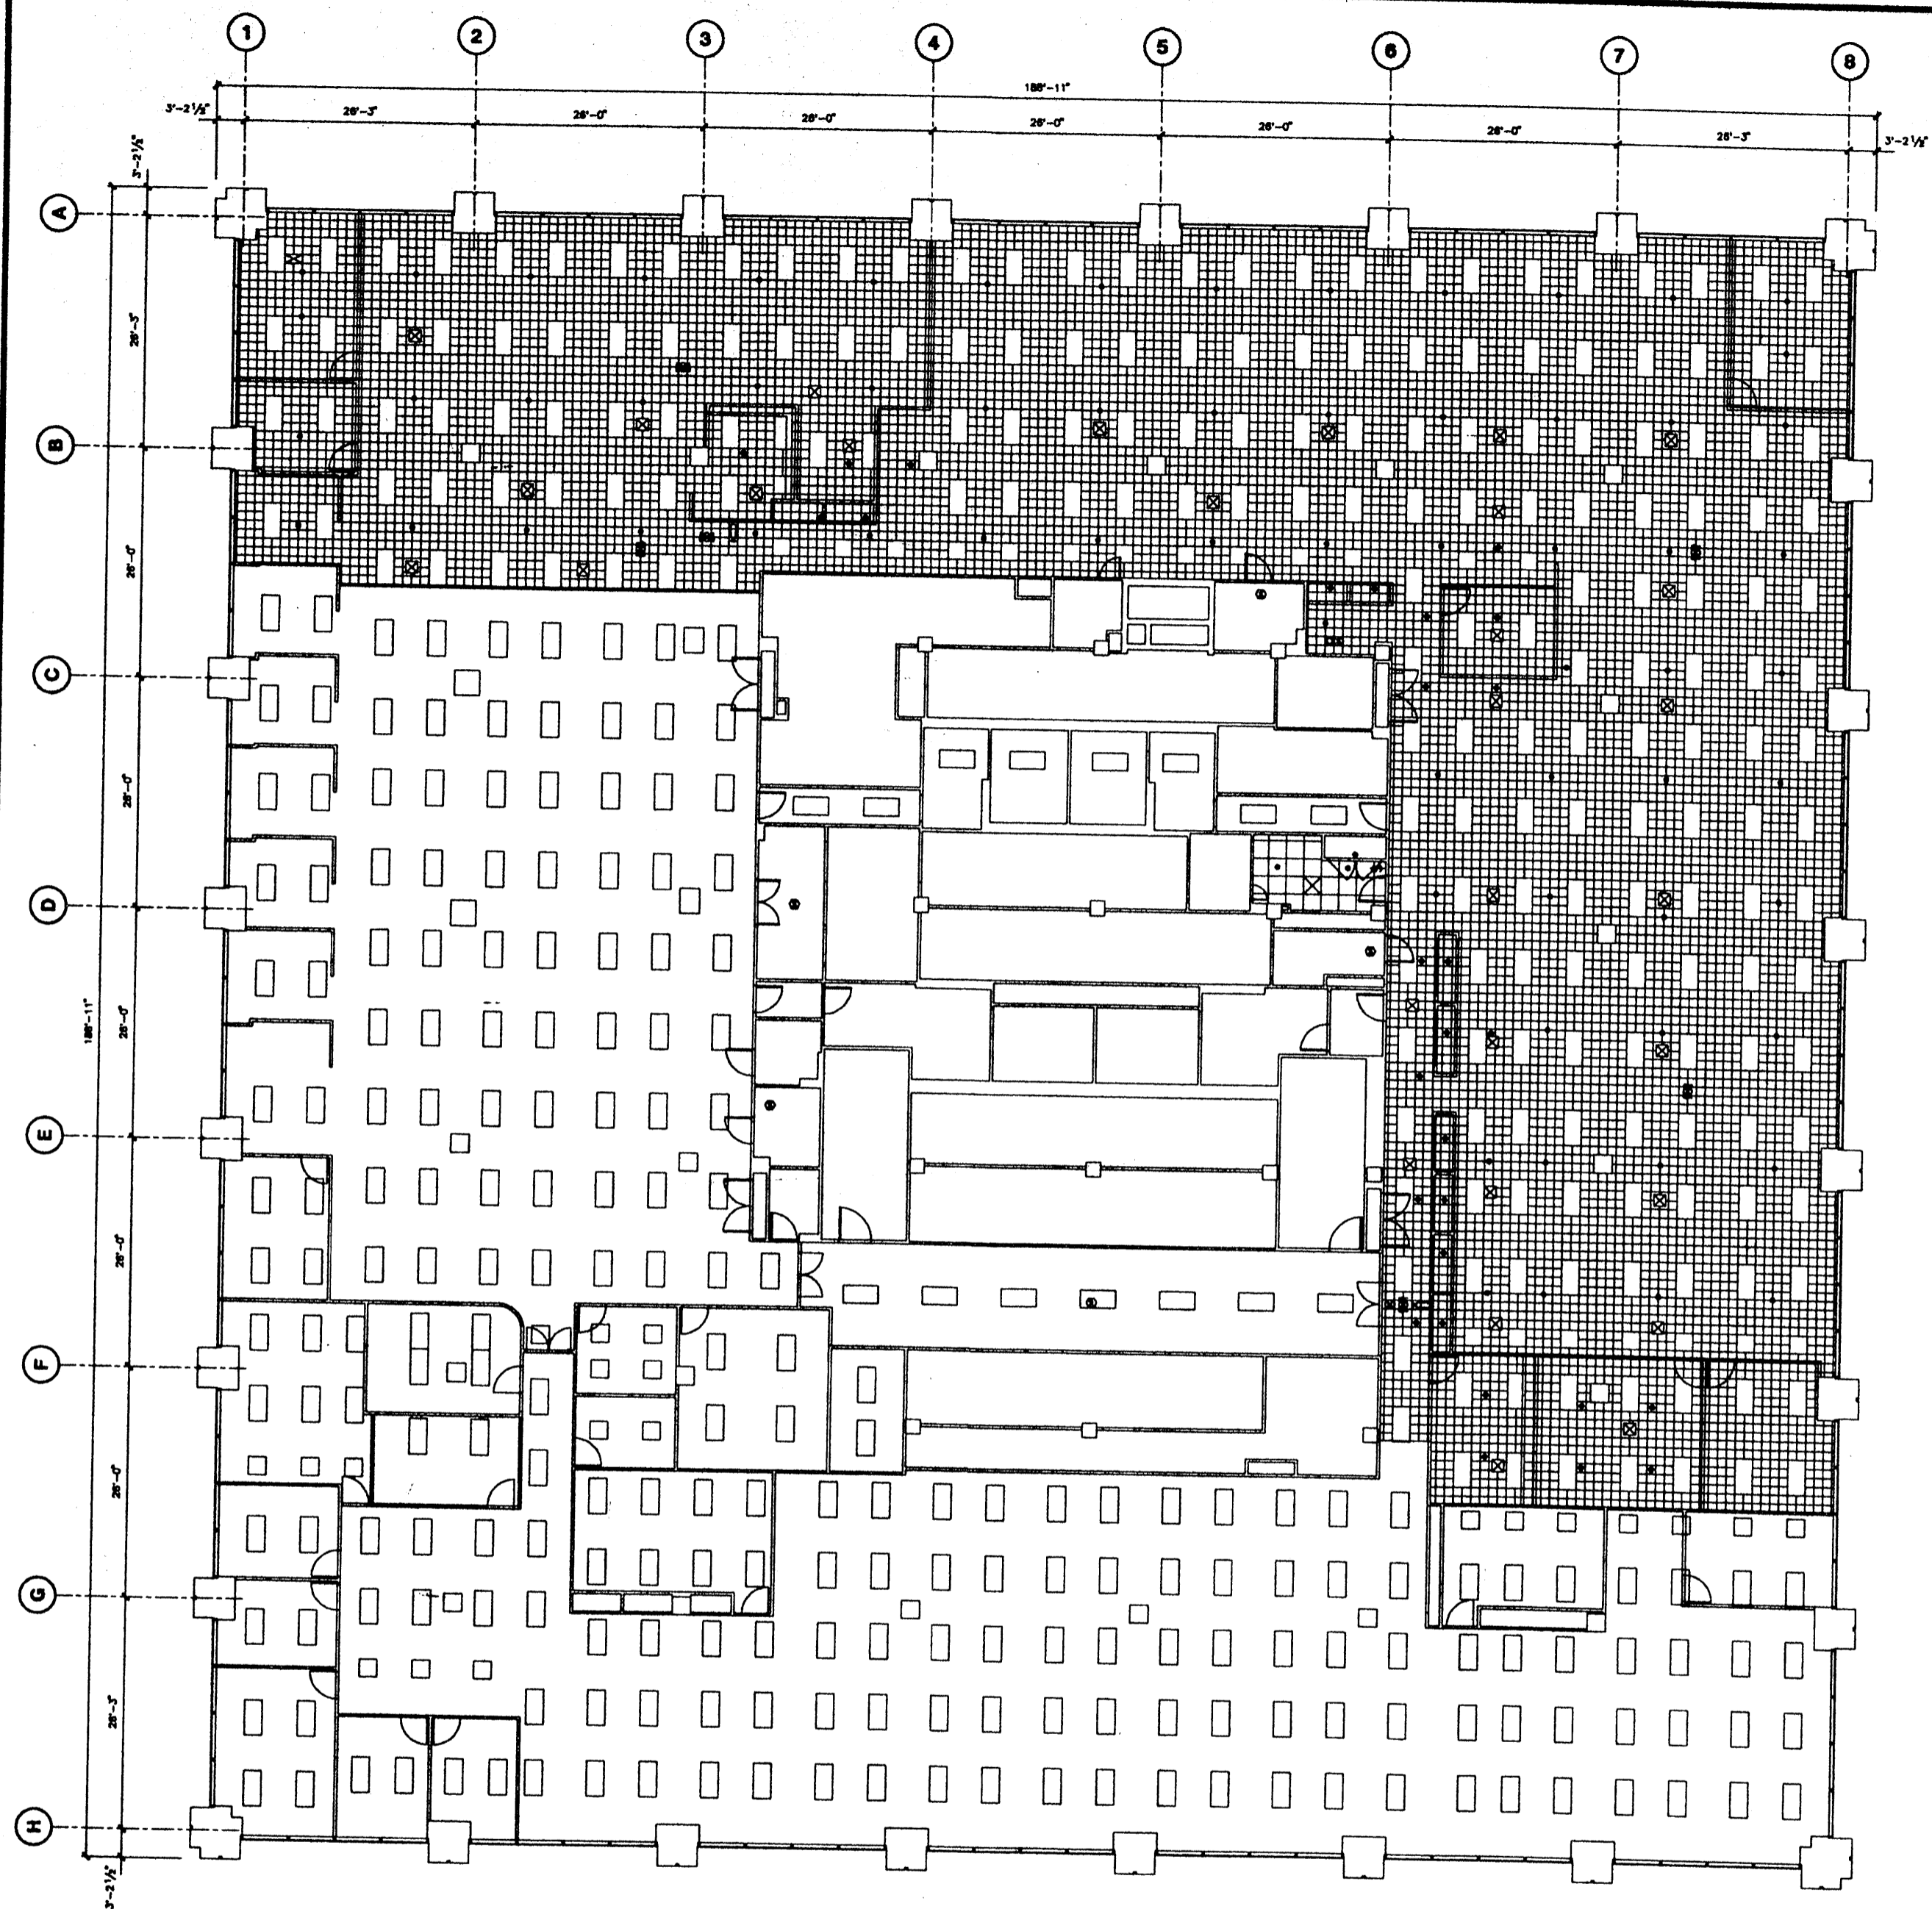

Deutsche Bank

No.	Date	Description
1	4/7/00	Project #00001631 - Old Loan Operations
2	5/19/00	Project #00000000 - Old Loan Operations - New Installation
3	5/1/01	Project #00000014 - Update Lighting Layout
4	7/18/00	Updated for Checkat Glass Barrier
5	8/28/01	Updated for Fixing Condition


No.	Date	Issued To

130 LIBERTY STREET

14th FLOOR CEILING PLAN



Drawn by	Checked by
Date	3/25/01
Project No.	

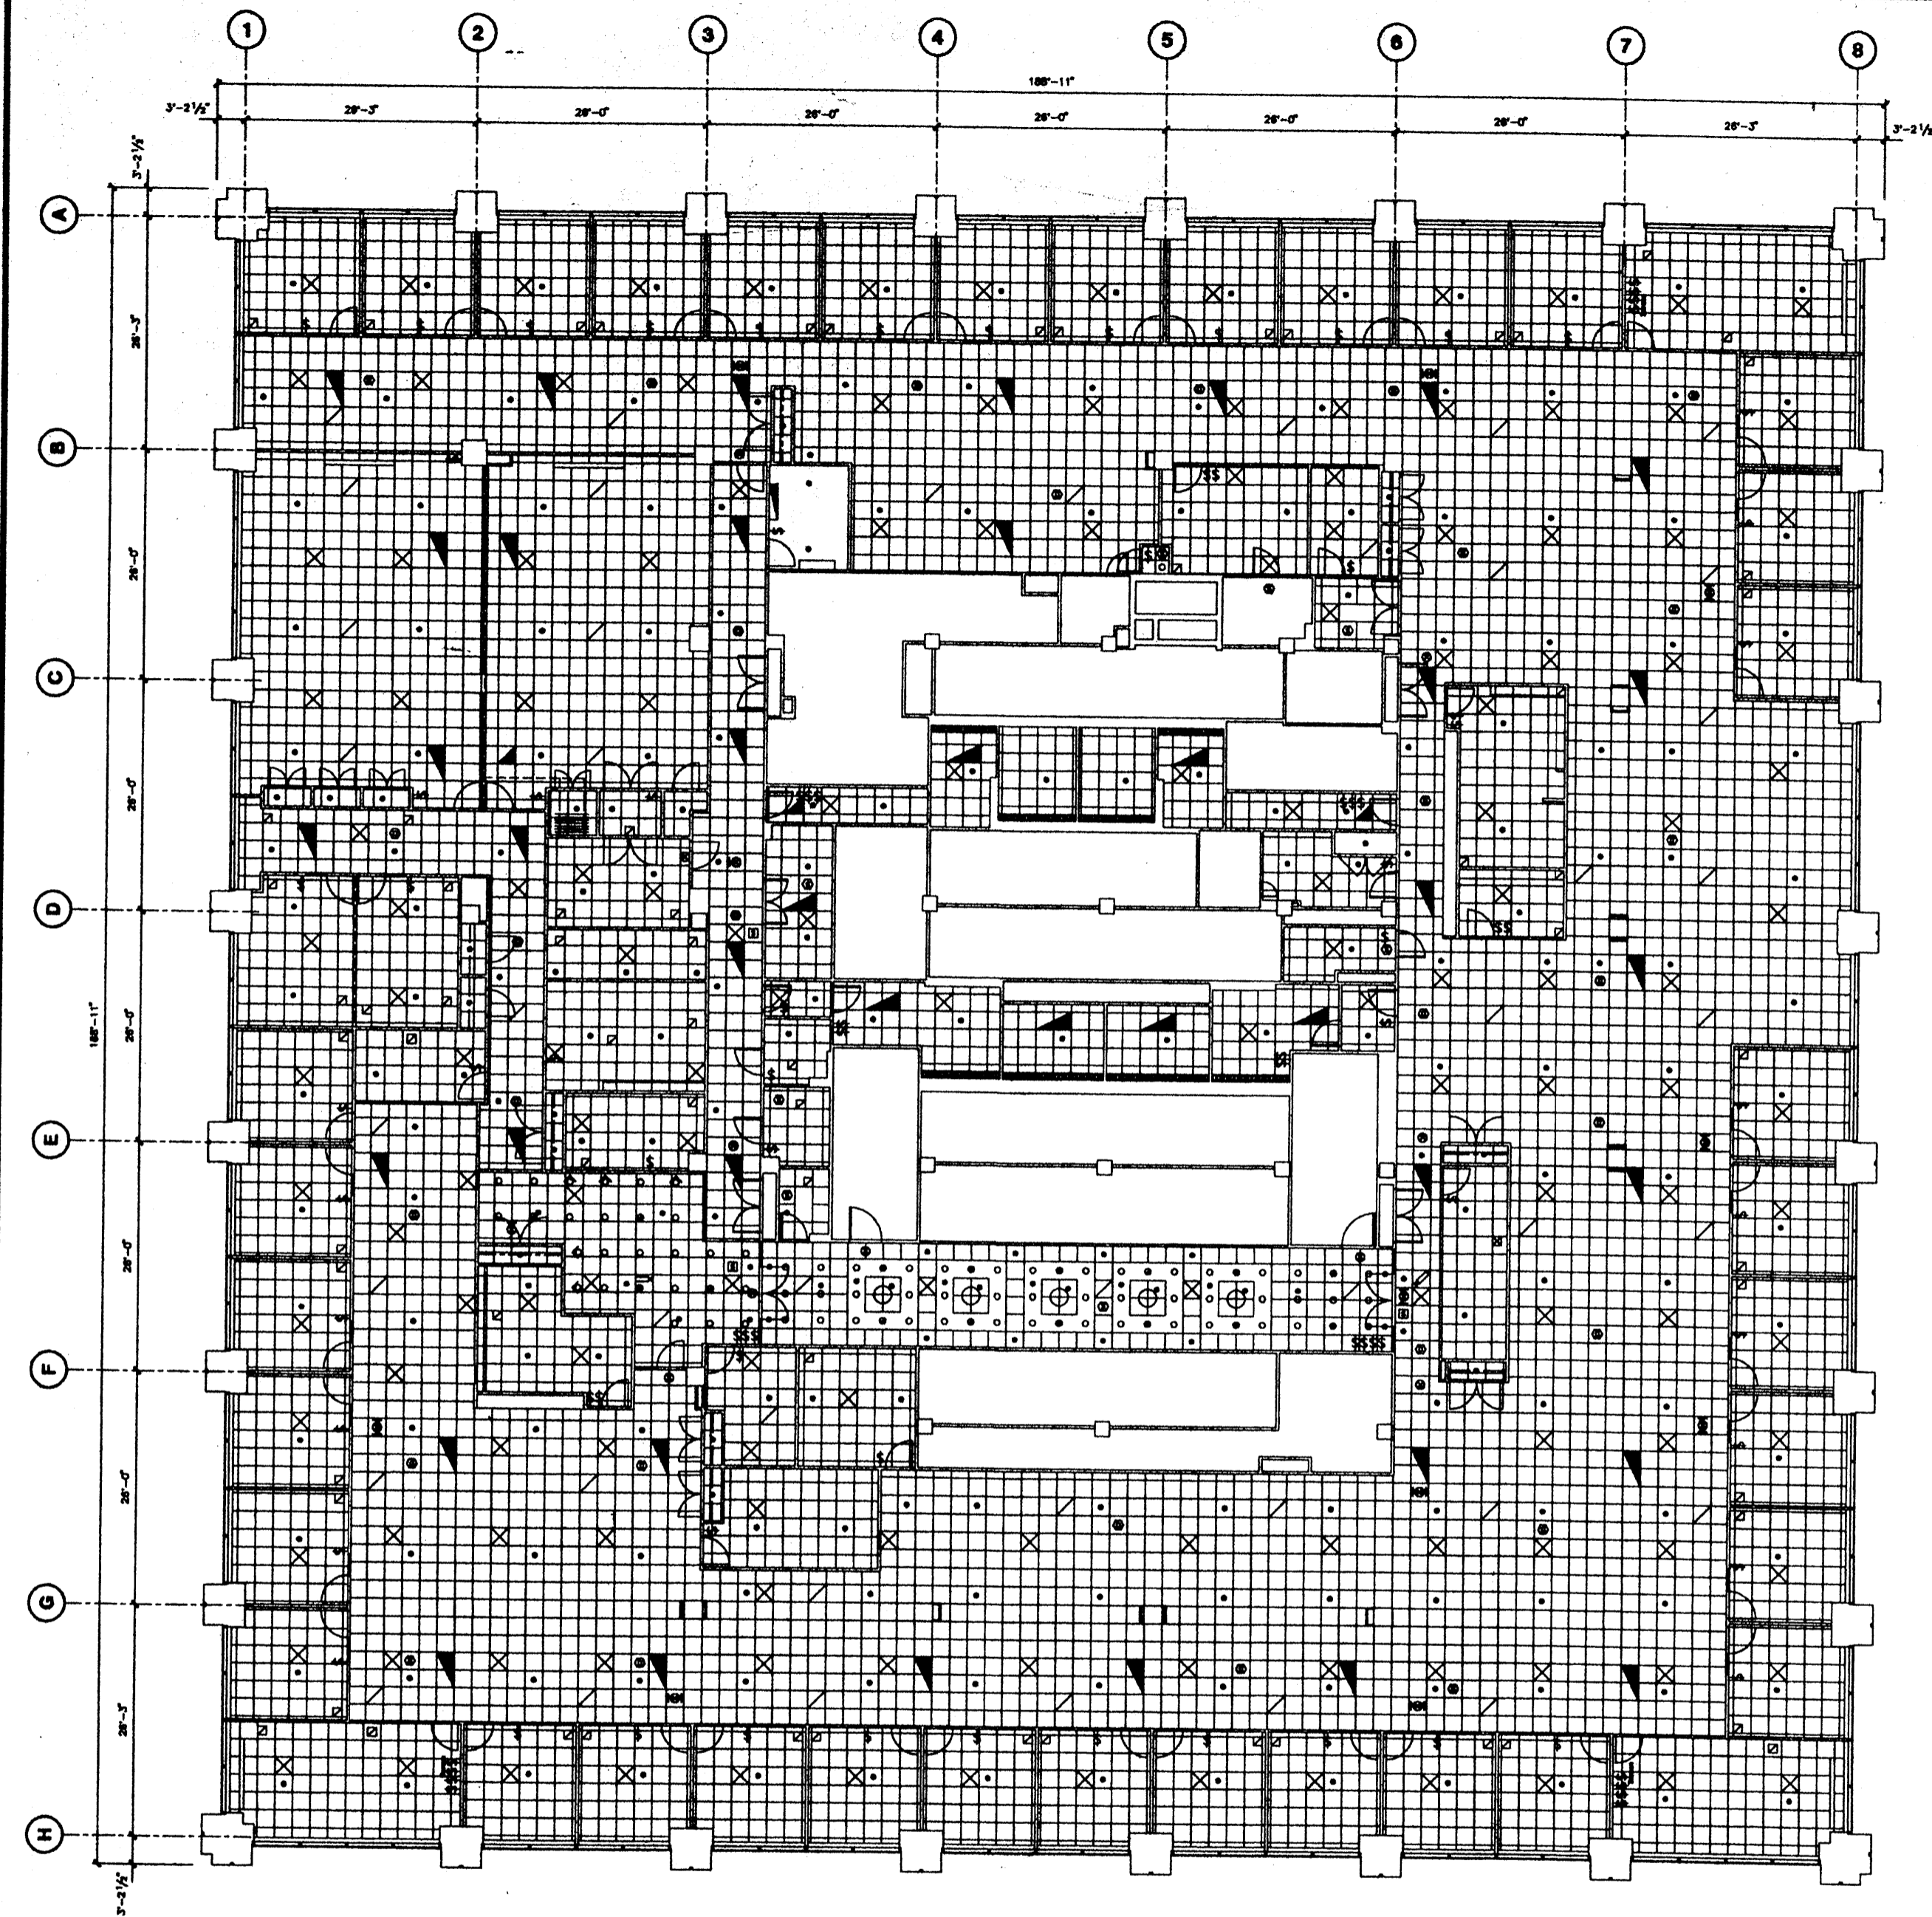

Deutsche Bank


No.	Date	Description
1	12/1/93	Project 880000000 - 12th Floor Ceiling Construction
2	4/15/94	Project 880000000 - Raising Recessed FF Top
3	10/26/98	Updated for Ceiling Construction
4	4/1/00	Project 880000000 - Updated Lighting Layout
5	7/15/98	Updated by Electric Cloud Survey
6	4/15/01	Project 128000001

No.	Date	Issued To

PROJECT
**130 LIBERTY
 STREET**
 DRAWING
**12th FLOOR
 CEILING
 PLAN**

Drawn By	
Checked By	
Date	6/15/01
Scale	
Project No.	



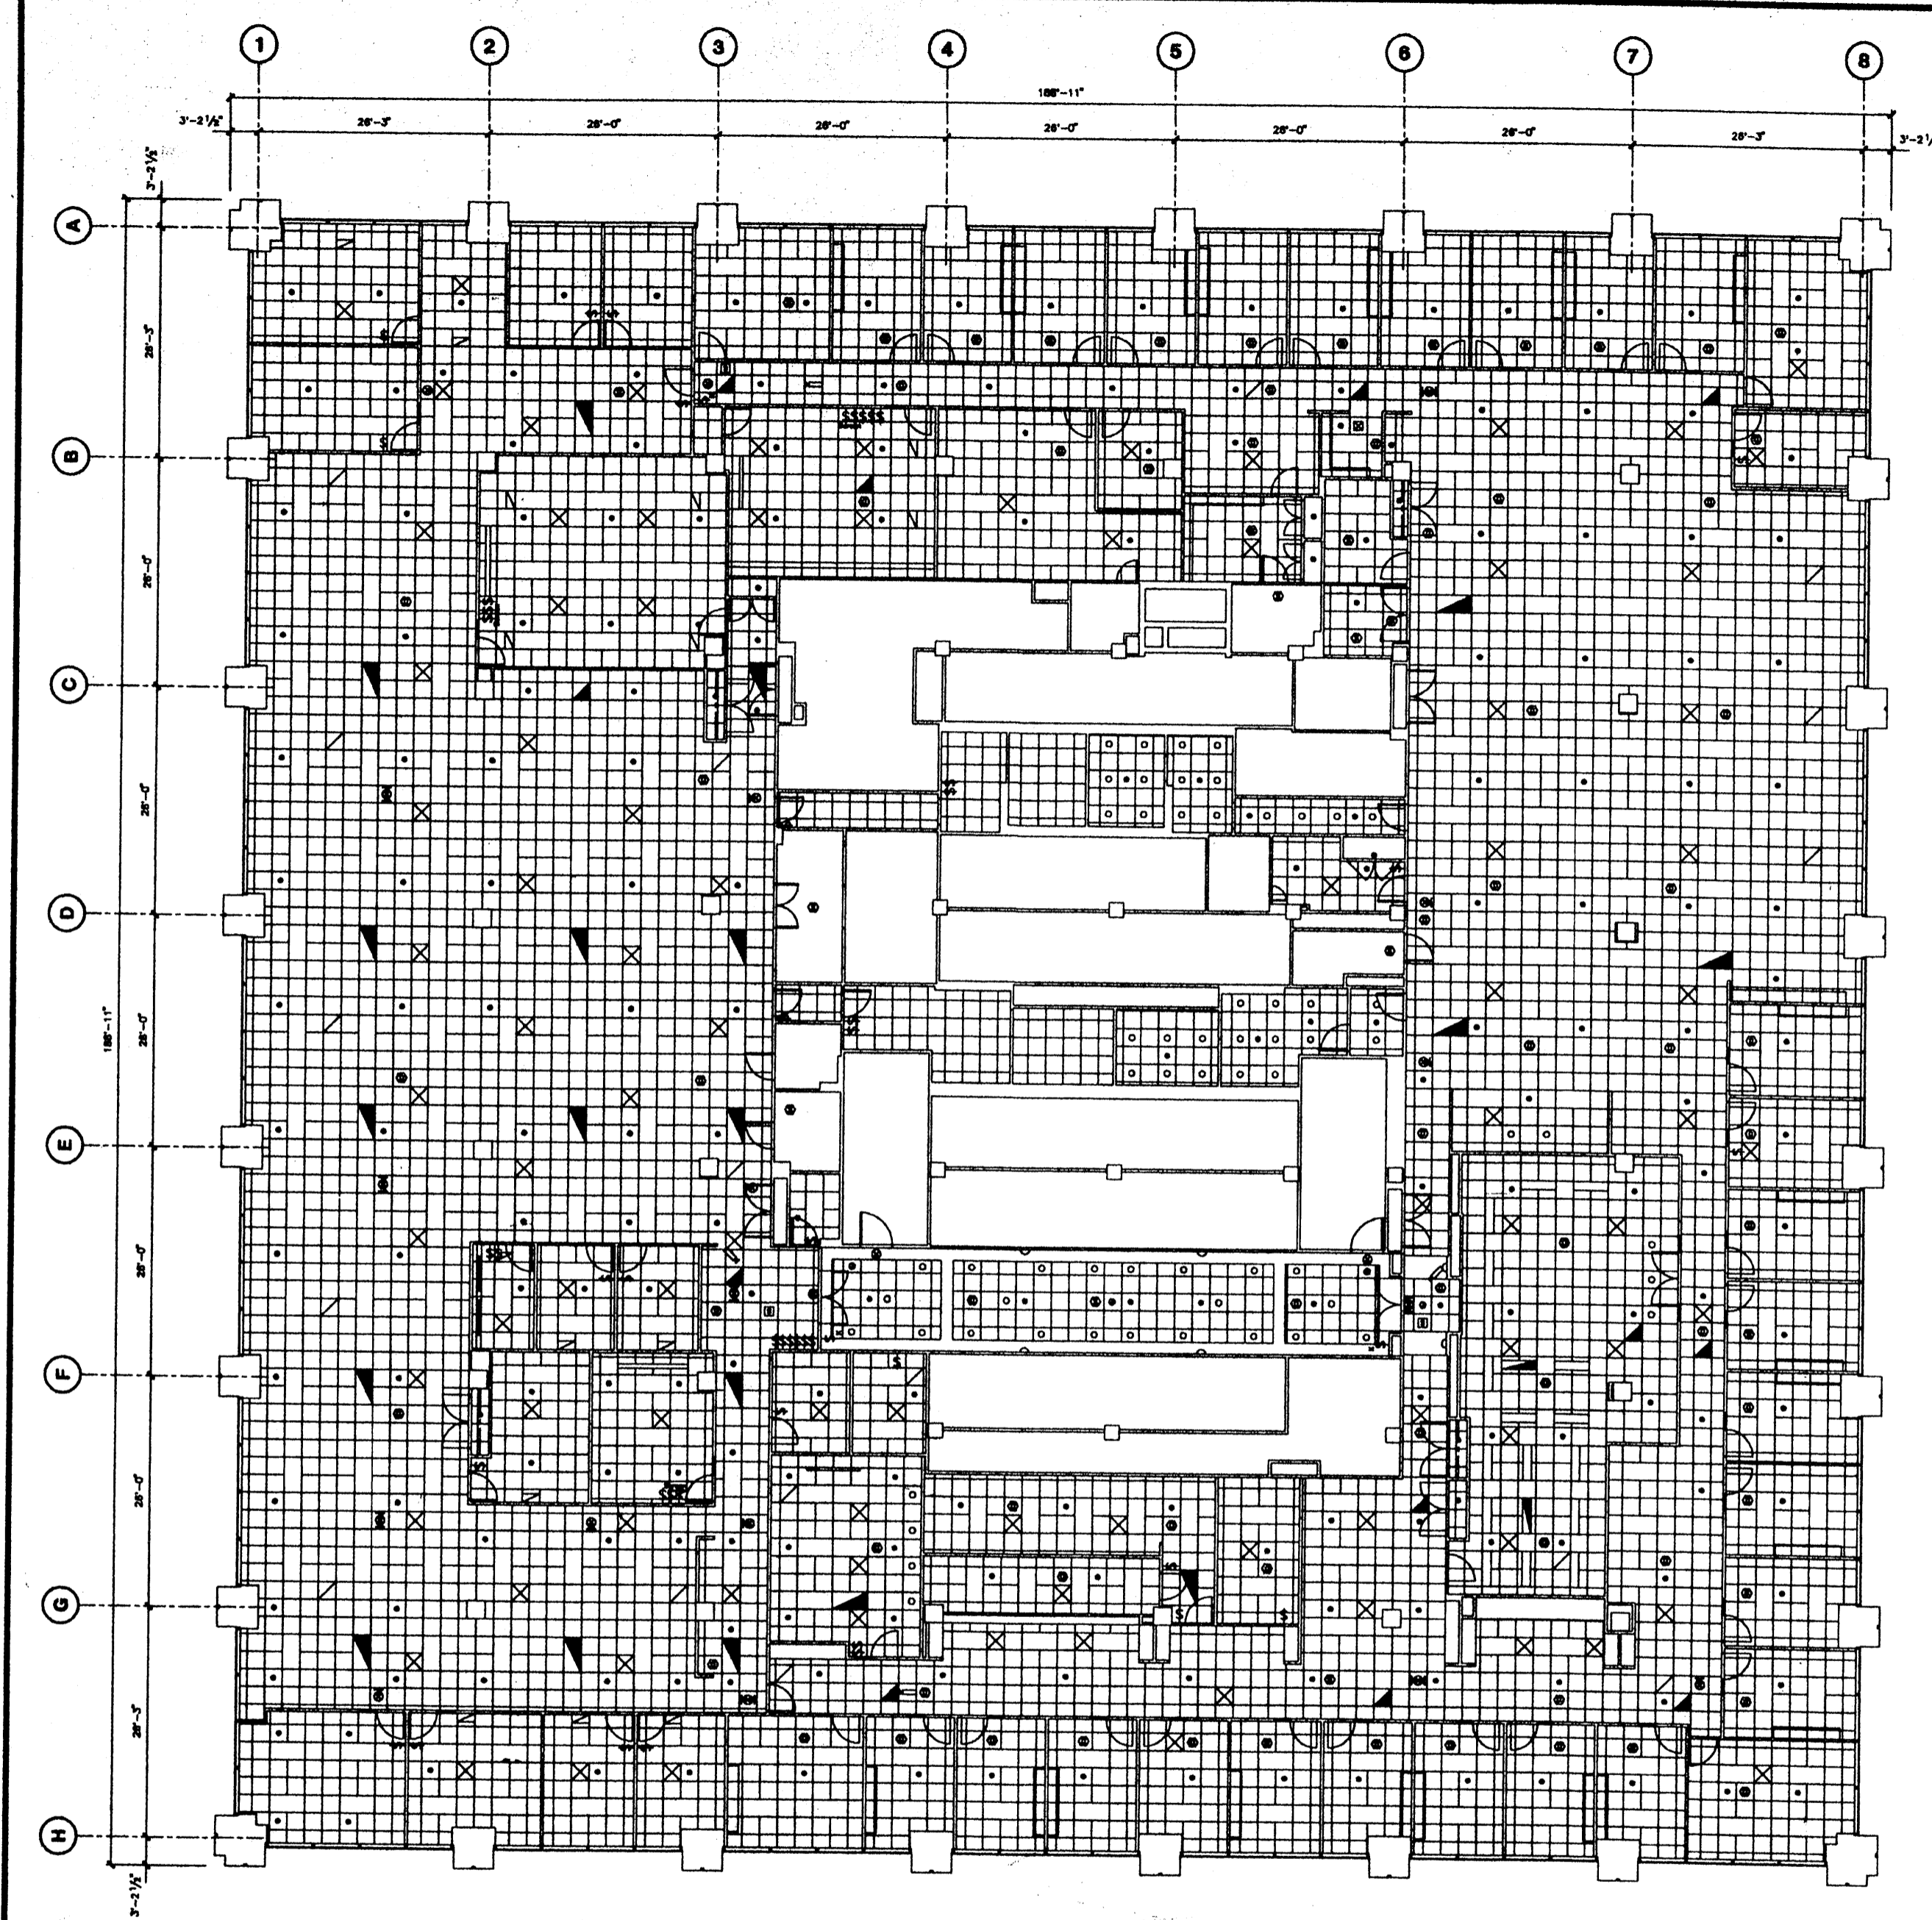

Deutsche Bank


No.	Date	Revised To
1	6/4/97	Furniture Updates
2	7/15/98	Updated for Deutsche Bank Signage
3	6/15/98	Project #70001433 - Corporate Ten Renovation
4	1/15/98	Project #70001433 - Corporate Ten Renovation
5	6/15/01	Project #82785001 - Corporate Renovation

No.	Date	Revised To

130 LIBERTY STREET

11th FLOOR CEILING PLAN

Drawn By	
Checked By	
Date	6/15/01
Project No.	

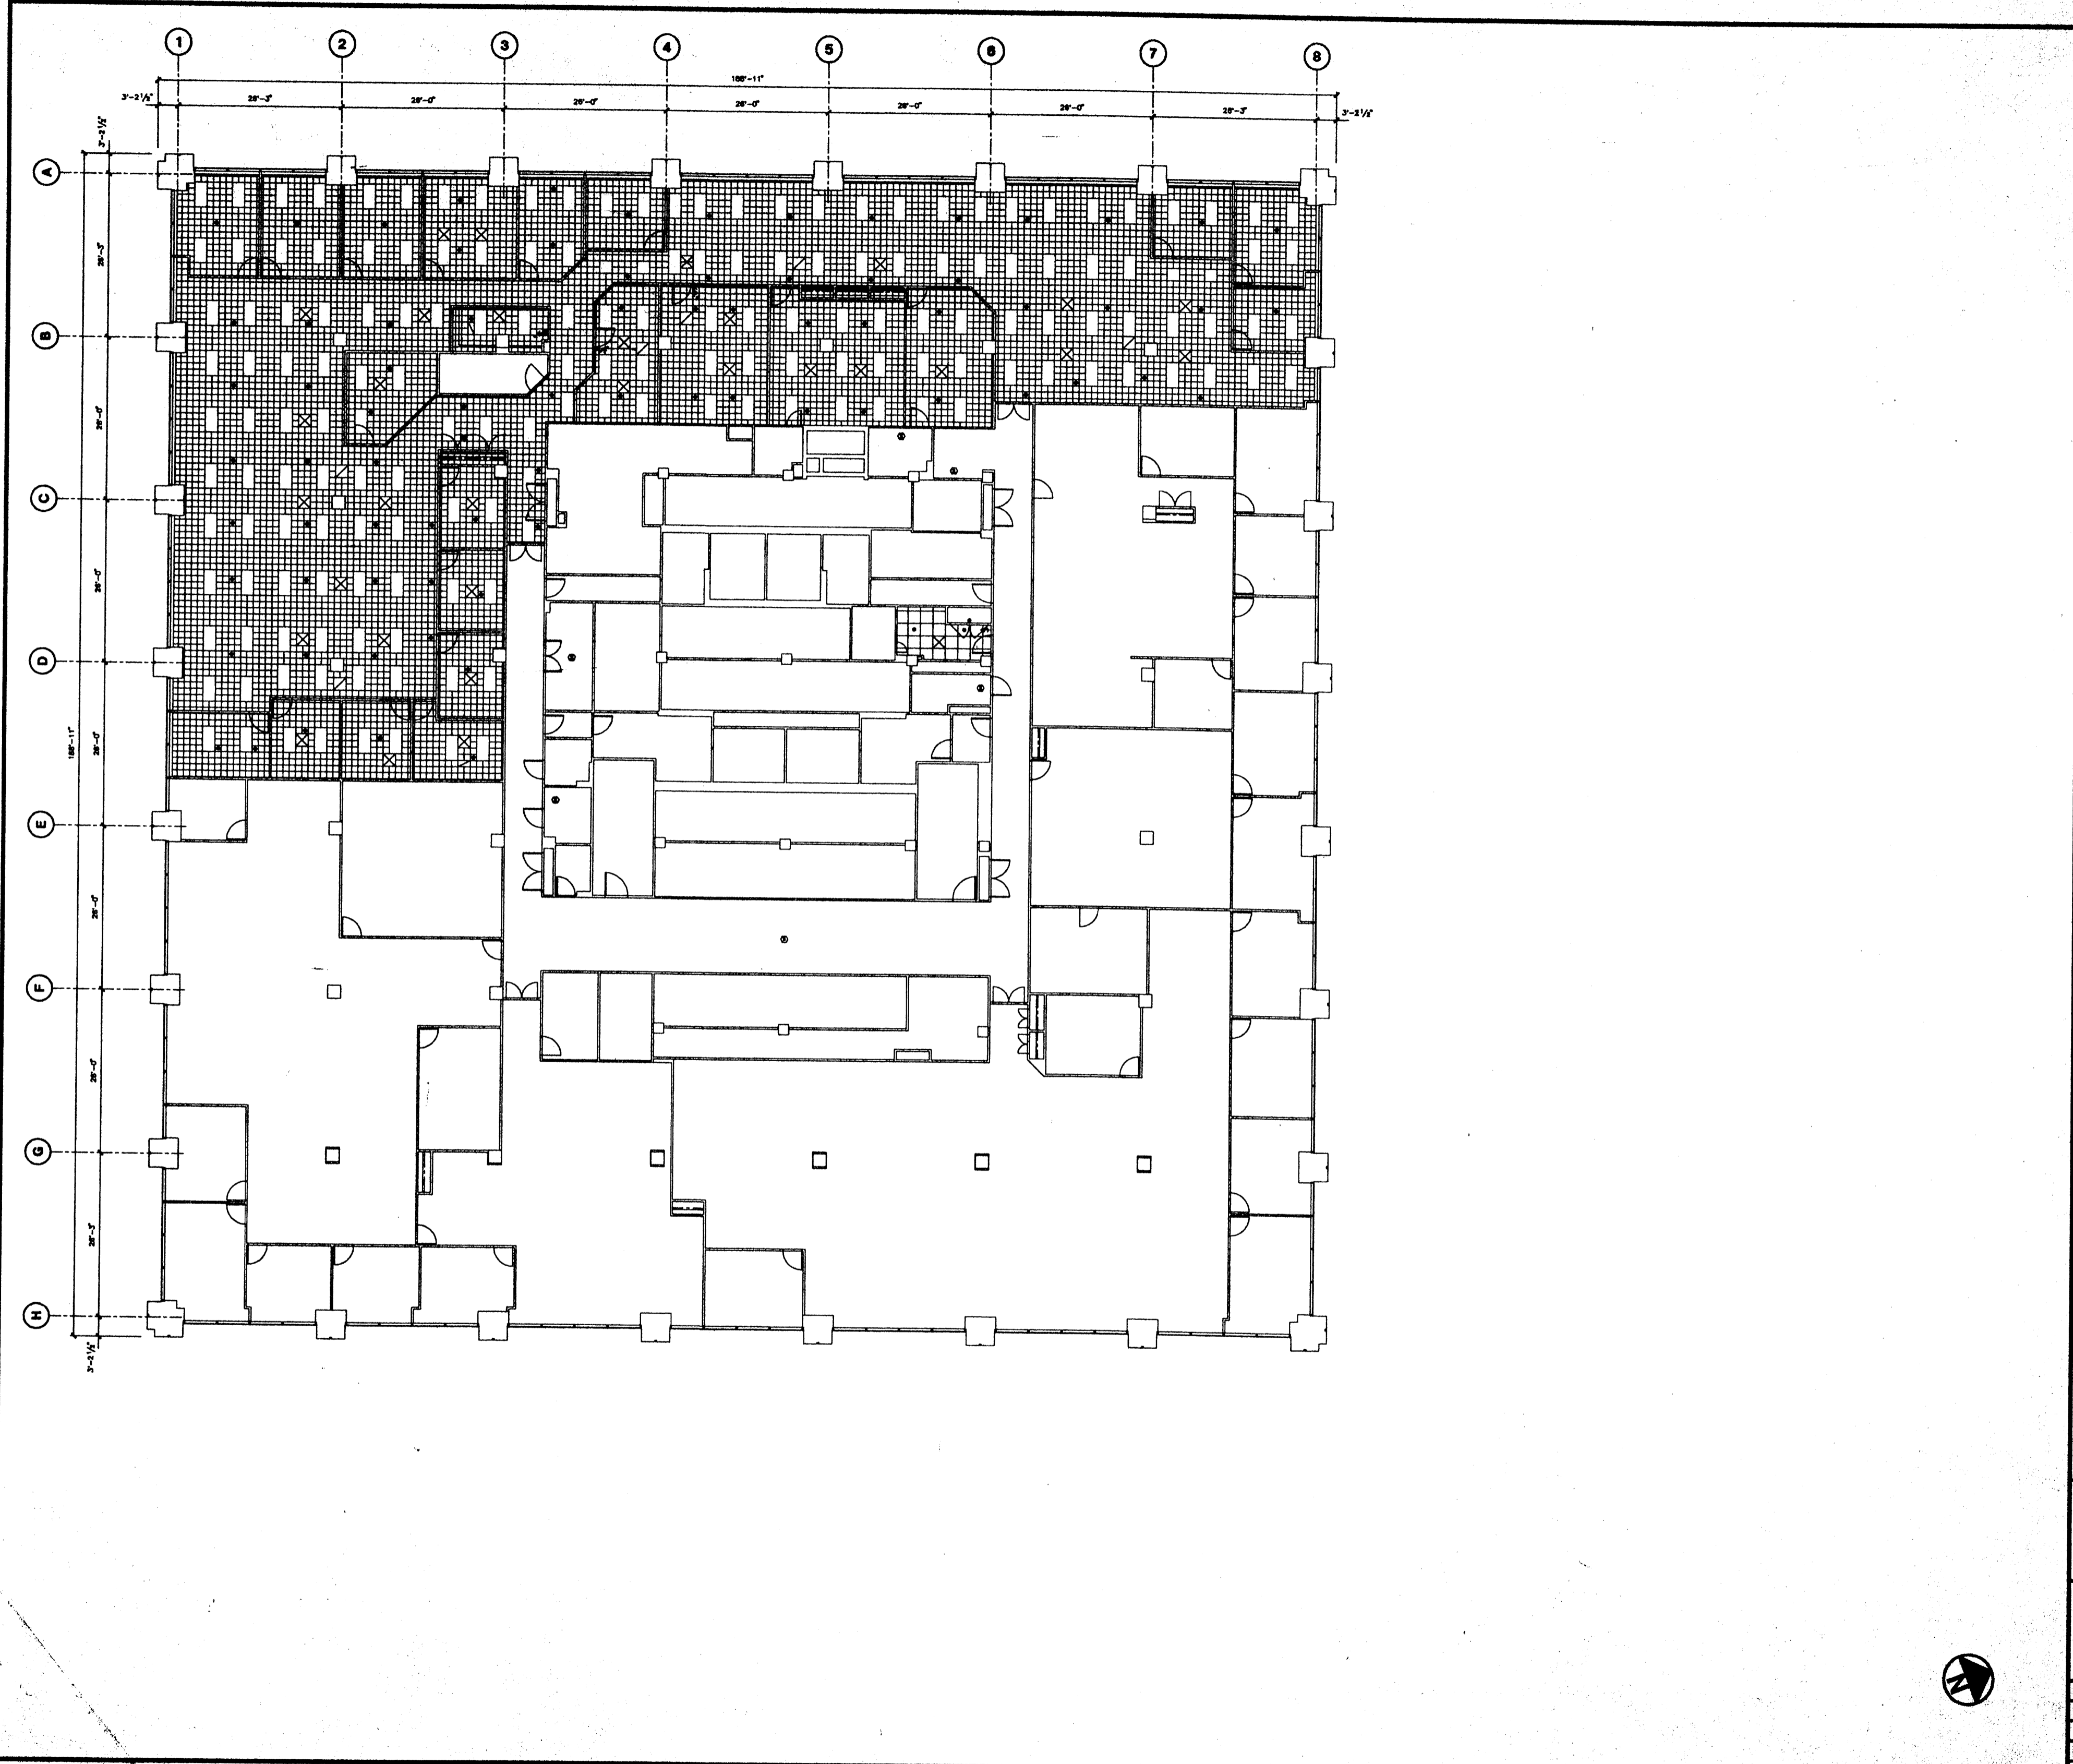

Deutsche Bank

No.	Date	Description
1	6/1/99	Initial Conditions and PIA Survey
2	6/1/99	Updated on PIA Survey Results
3	6/12/97	Project #7501222 - Chapman / Hubert, Inc.
4	7/15/98	Updated for Ceiling Detail Survey
5	4/1/98	Project #8000000 - 1200 Equity Replacement
6	6/25/01	Updated for Ceiling Conditions


No.	Date	Issued To

PROJECT
**130 LIBERTY
STREET**

DRAWING
**10th FLOOR
CEILING
PLAN**

Drawn by	
Checked by	
Date	6/15/01
Scale	
Project No.	



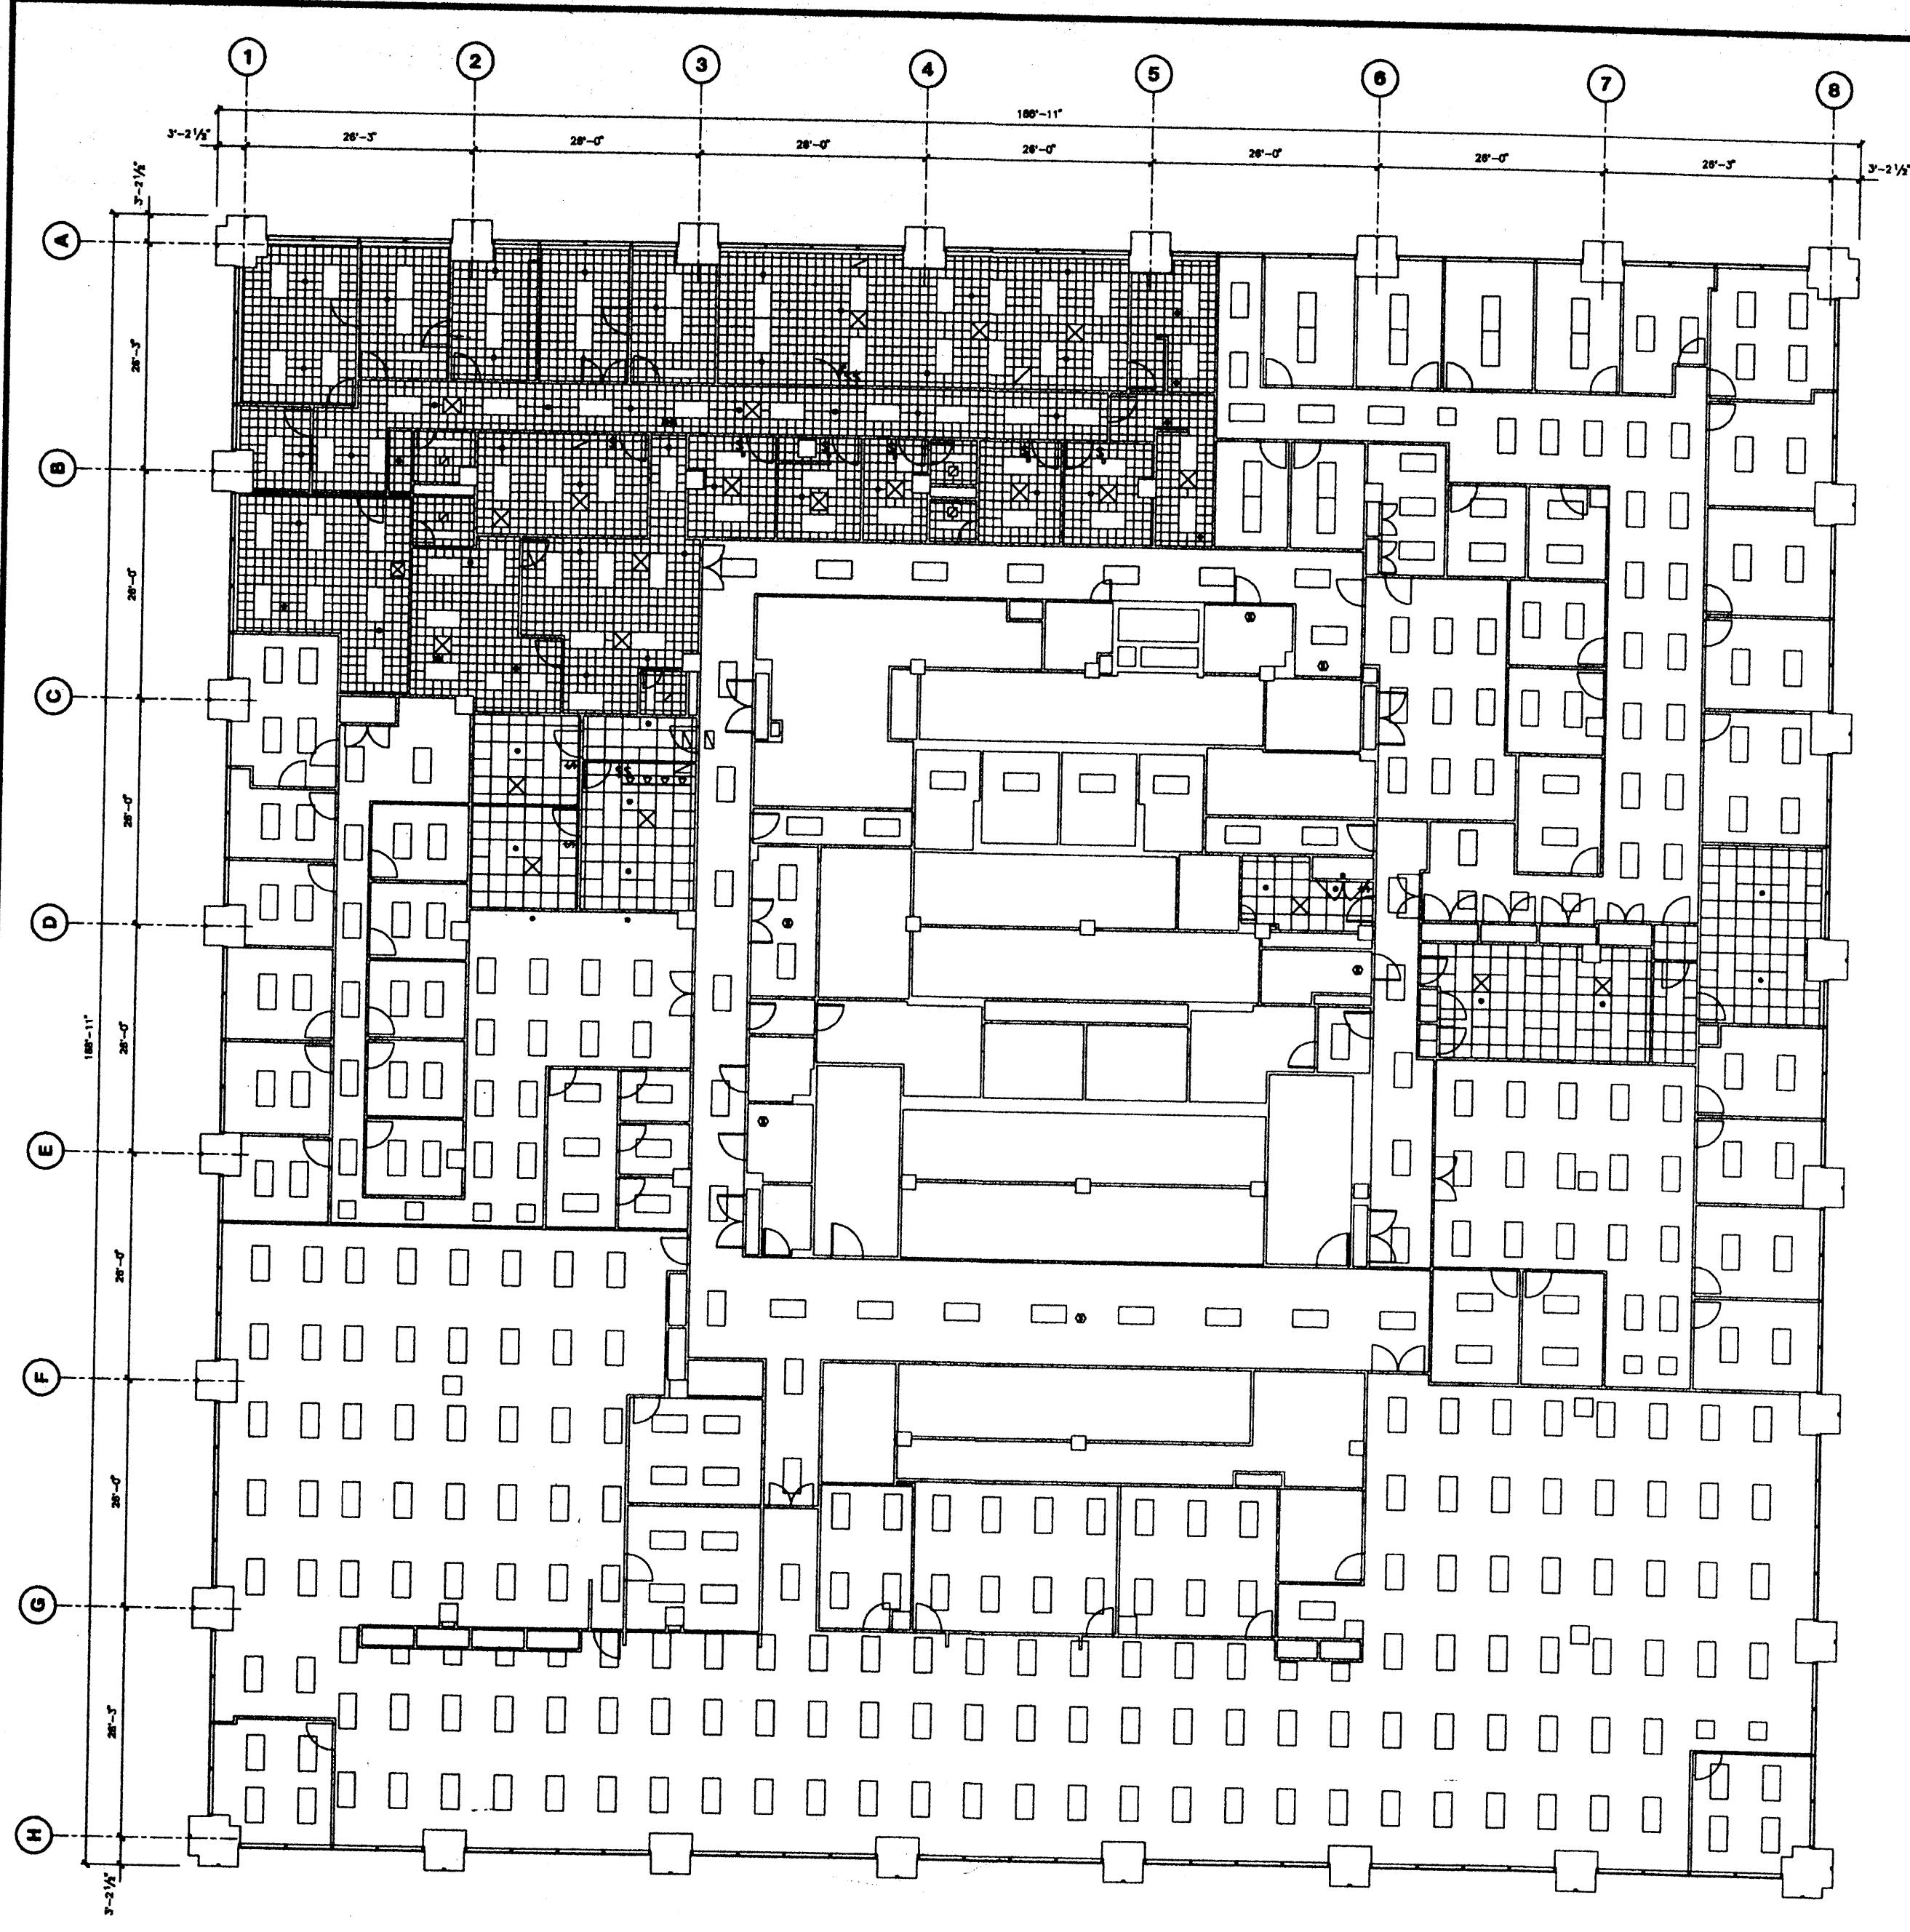

Deutsche Bank


No.	Date	Description
1	8/12/92	Updated Furniture per latest drawings (Global Project)
2	9/1/93	Updated Furniture per latest drawings (GSD)
3	8/17/94	Updated Furniture per latest drawings (Detailed Department)
4	8/1/97	Project No. 870001238 - St. Bernard's Suite
5	8/12/97	Project No. 870001238 - St. Bernard's Suite
6	7/19/98	Updated for Deutsche Credit Survey
7	10/18/00	Project No. LB2434-001-100 - Wireless Center
8	5/18/01	Updated for Existing Conditions

No.	Date	Issued To

PROJECT
130 LIBERTY STREET
 9th FLOOR
 CEILING
 PLAN

Drawn By	
Checked By	
Date	5/15/01
Scale	
Project No.	



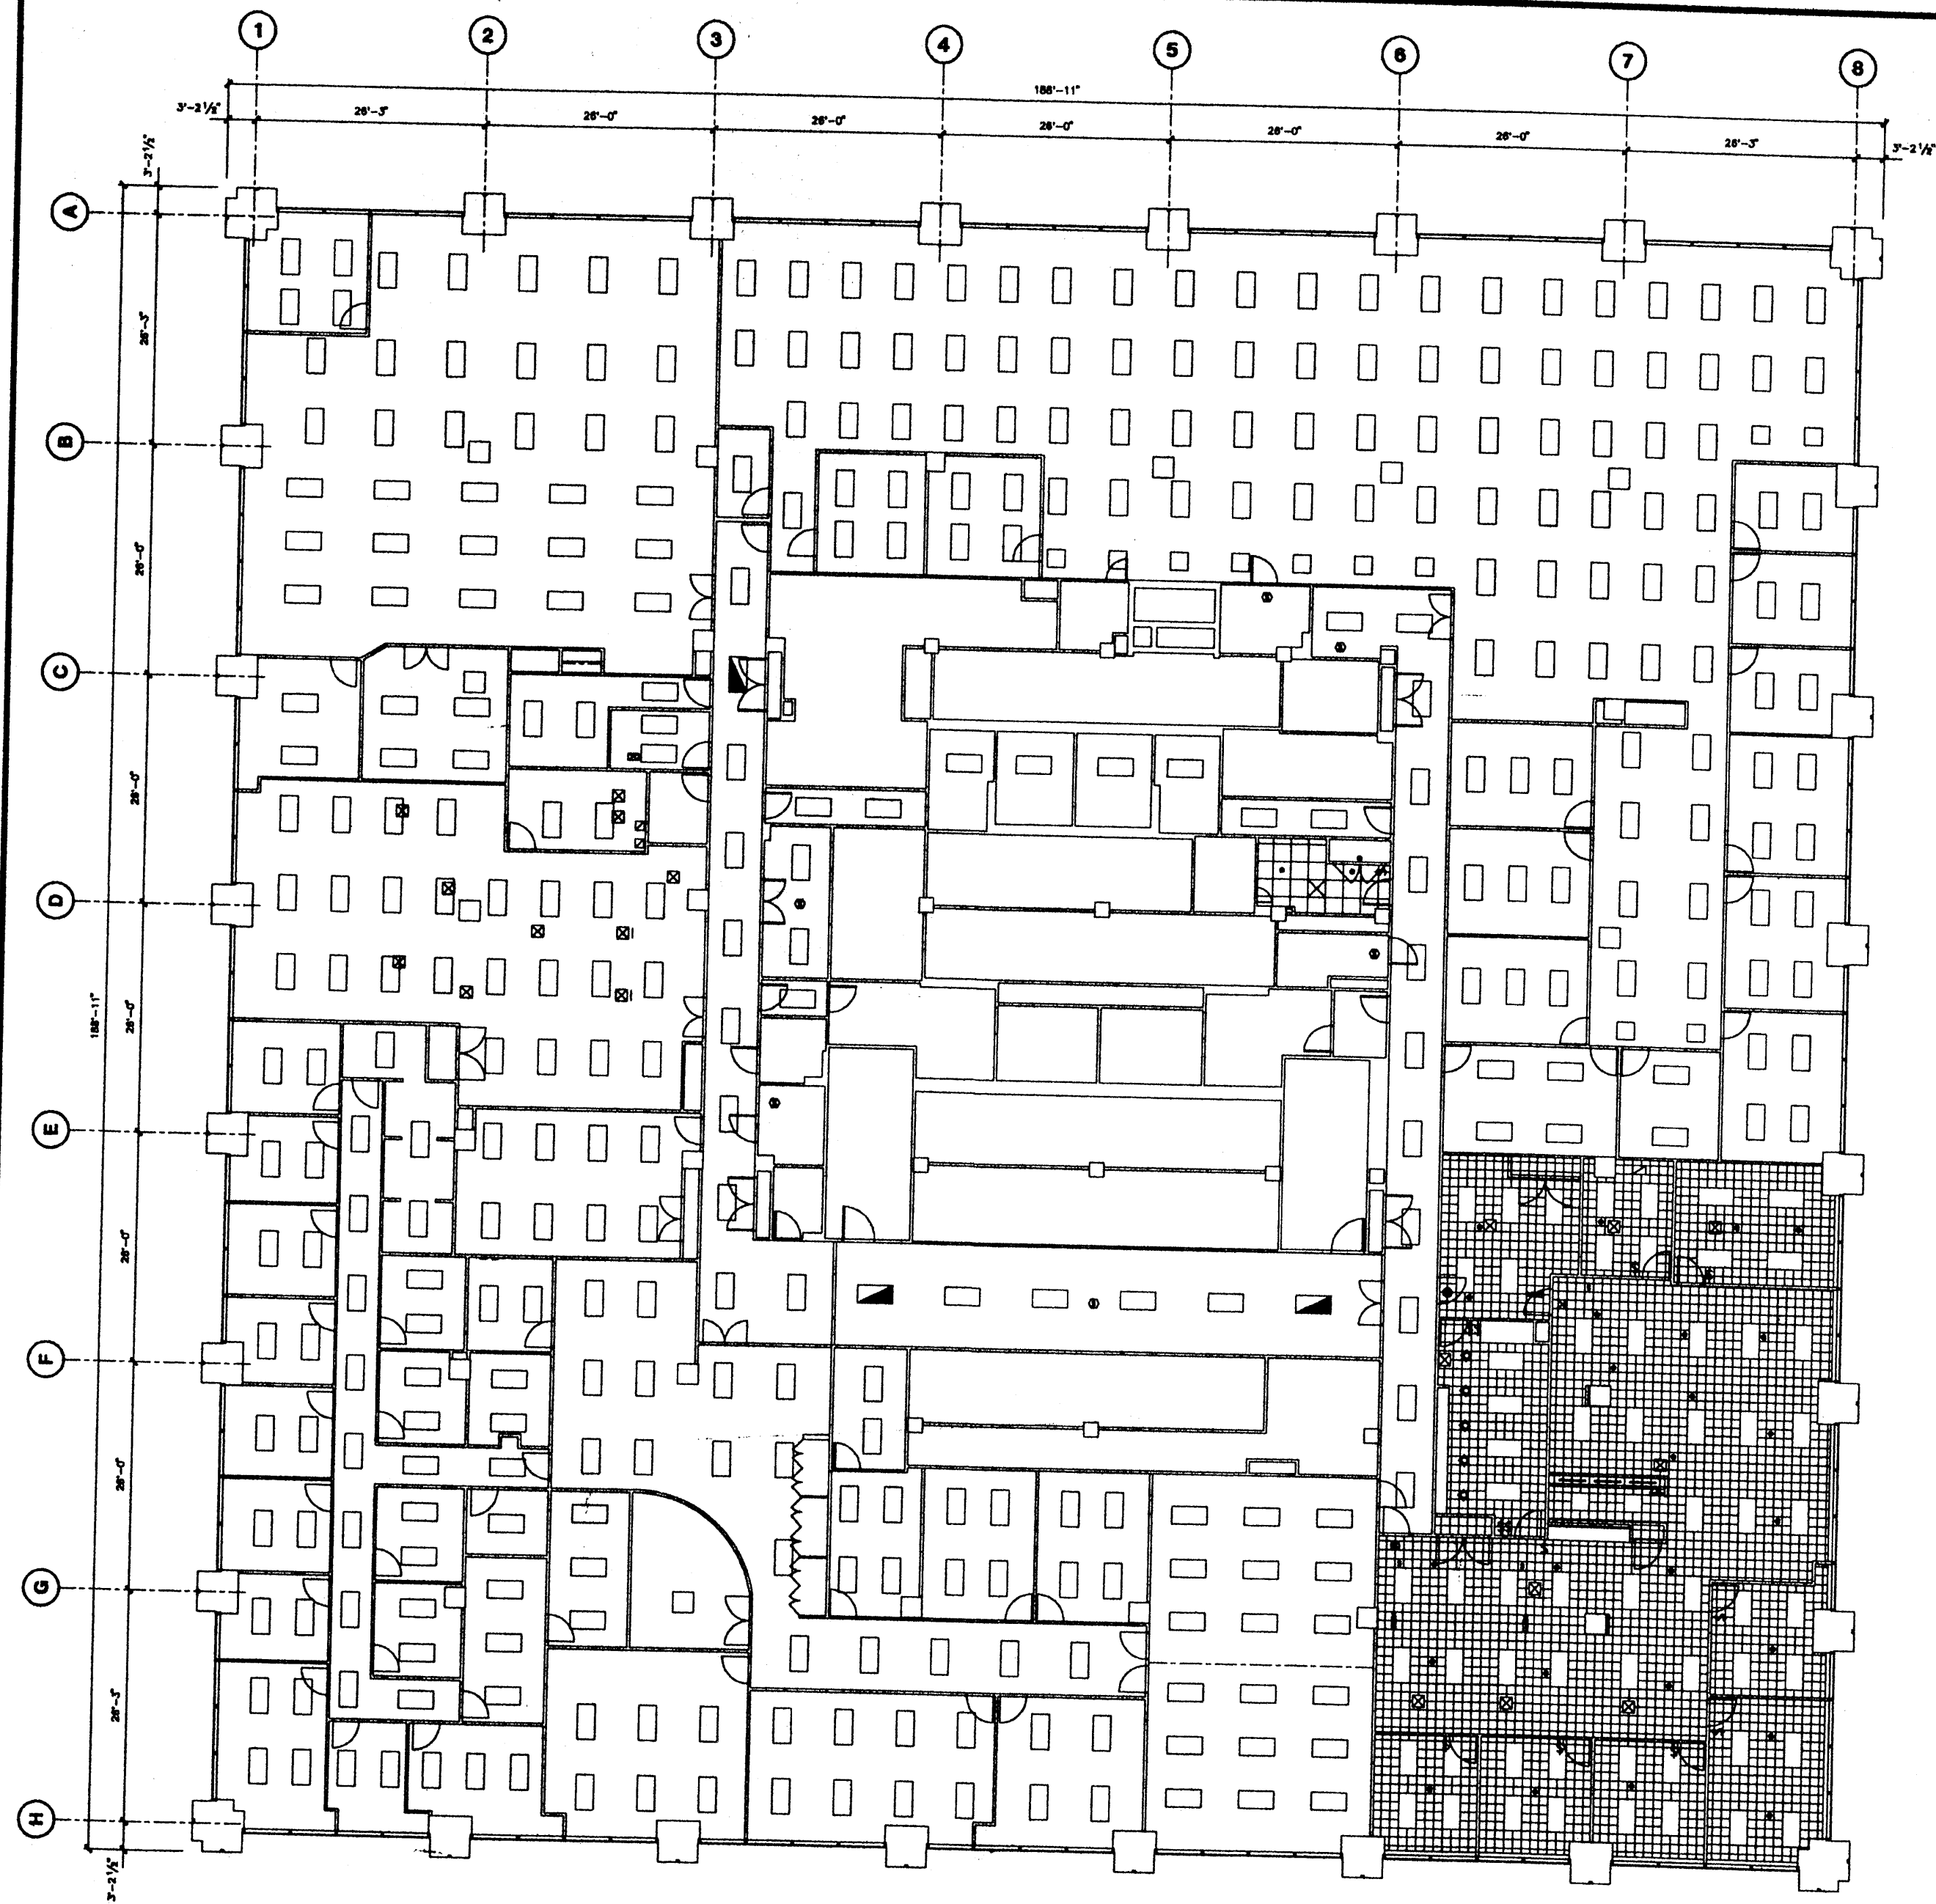

Deutsche Bank

No.	Date	Description
1	5/11/92	Add Entrance Doors to Page 11
2	10/7/94	Project No. R00003194 Revised for R00003372 08/15/94 08/15/94
3	11/23/94	Project No. C00003282 Complete Compliance Specification
4	5/21/96	Project No. 177 Revised for Floor Plan
5	5/1/97	Project No. R00003314 Updated Lighting Layout
6	7/15/98	Updated for Electric Ceiling Service
7	5/15/99	Revised Southwest Portion of Floor


No.	Date	Issued To

130 LIBERTY STREET

8th FLOOR
CEILING
PLAN



Drawn By	
Checked By	
Date	5/15/99
Scale	
Project No.	

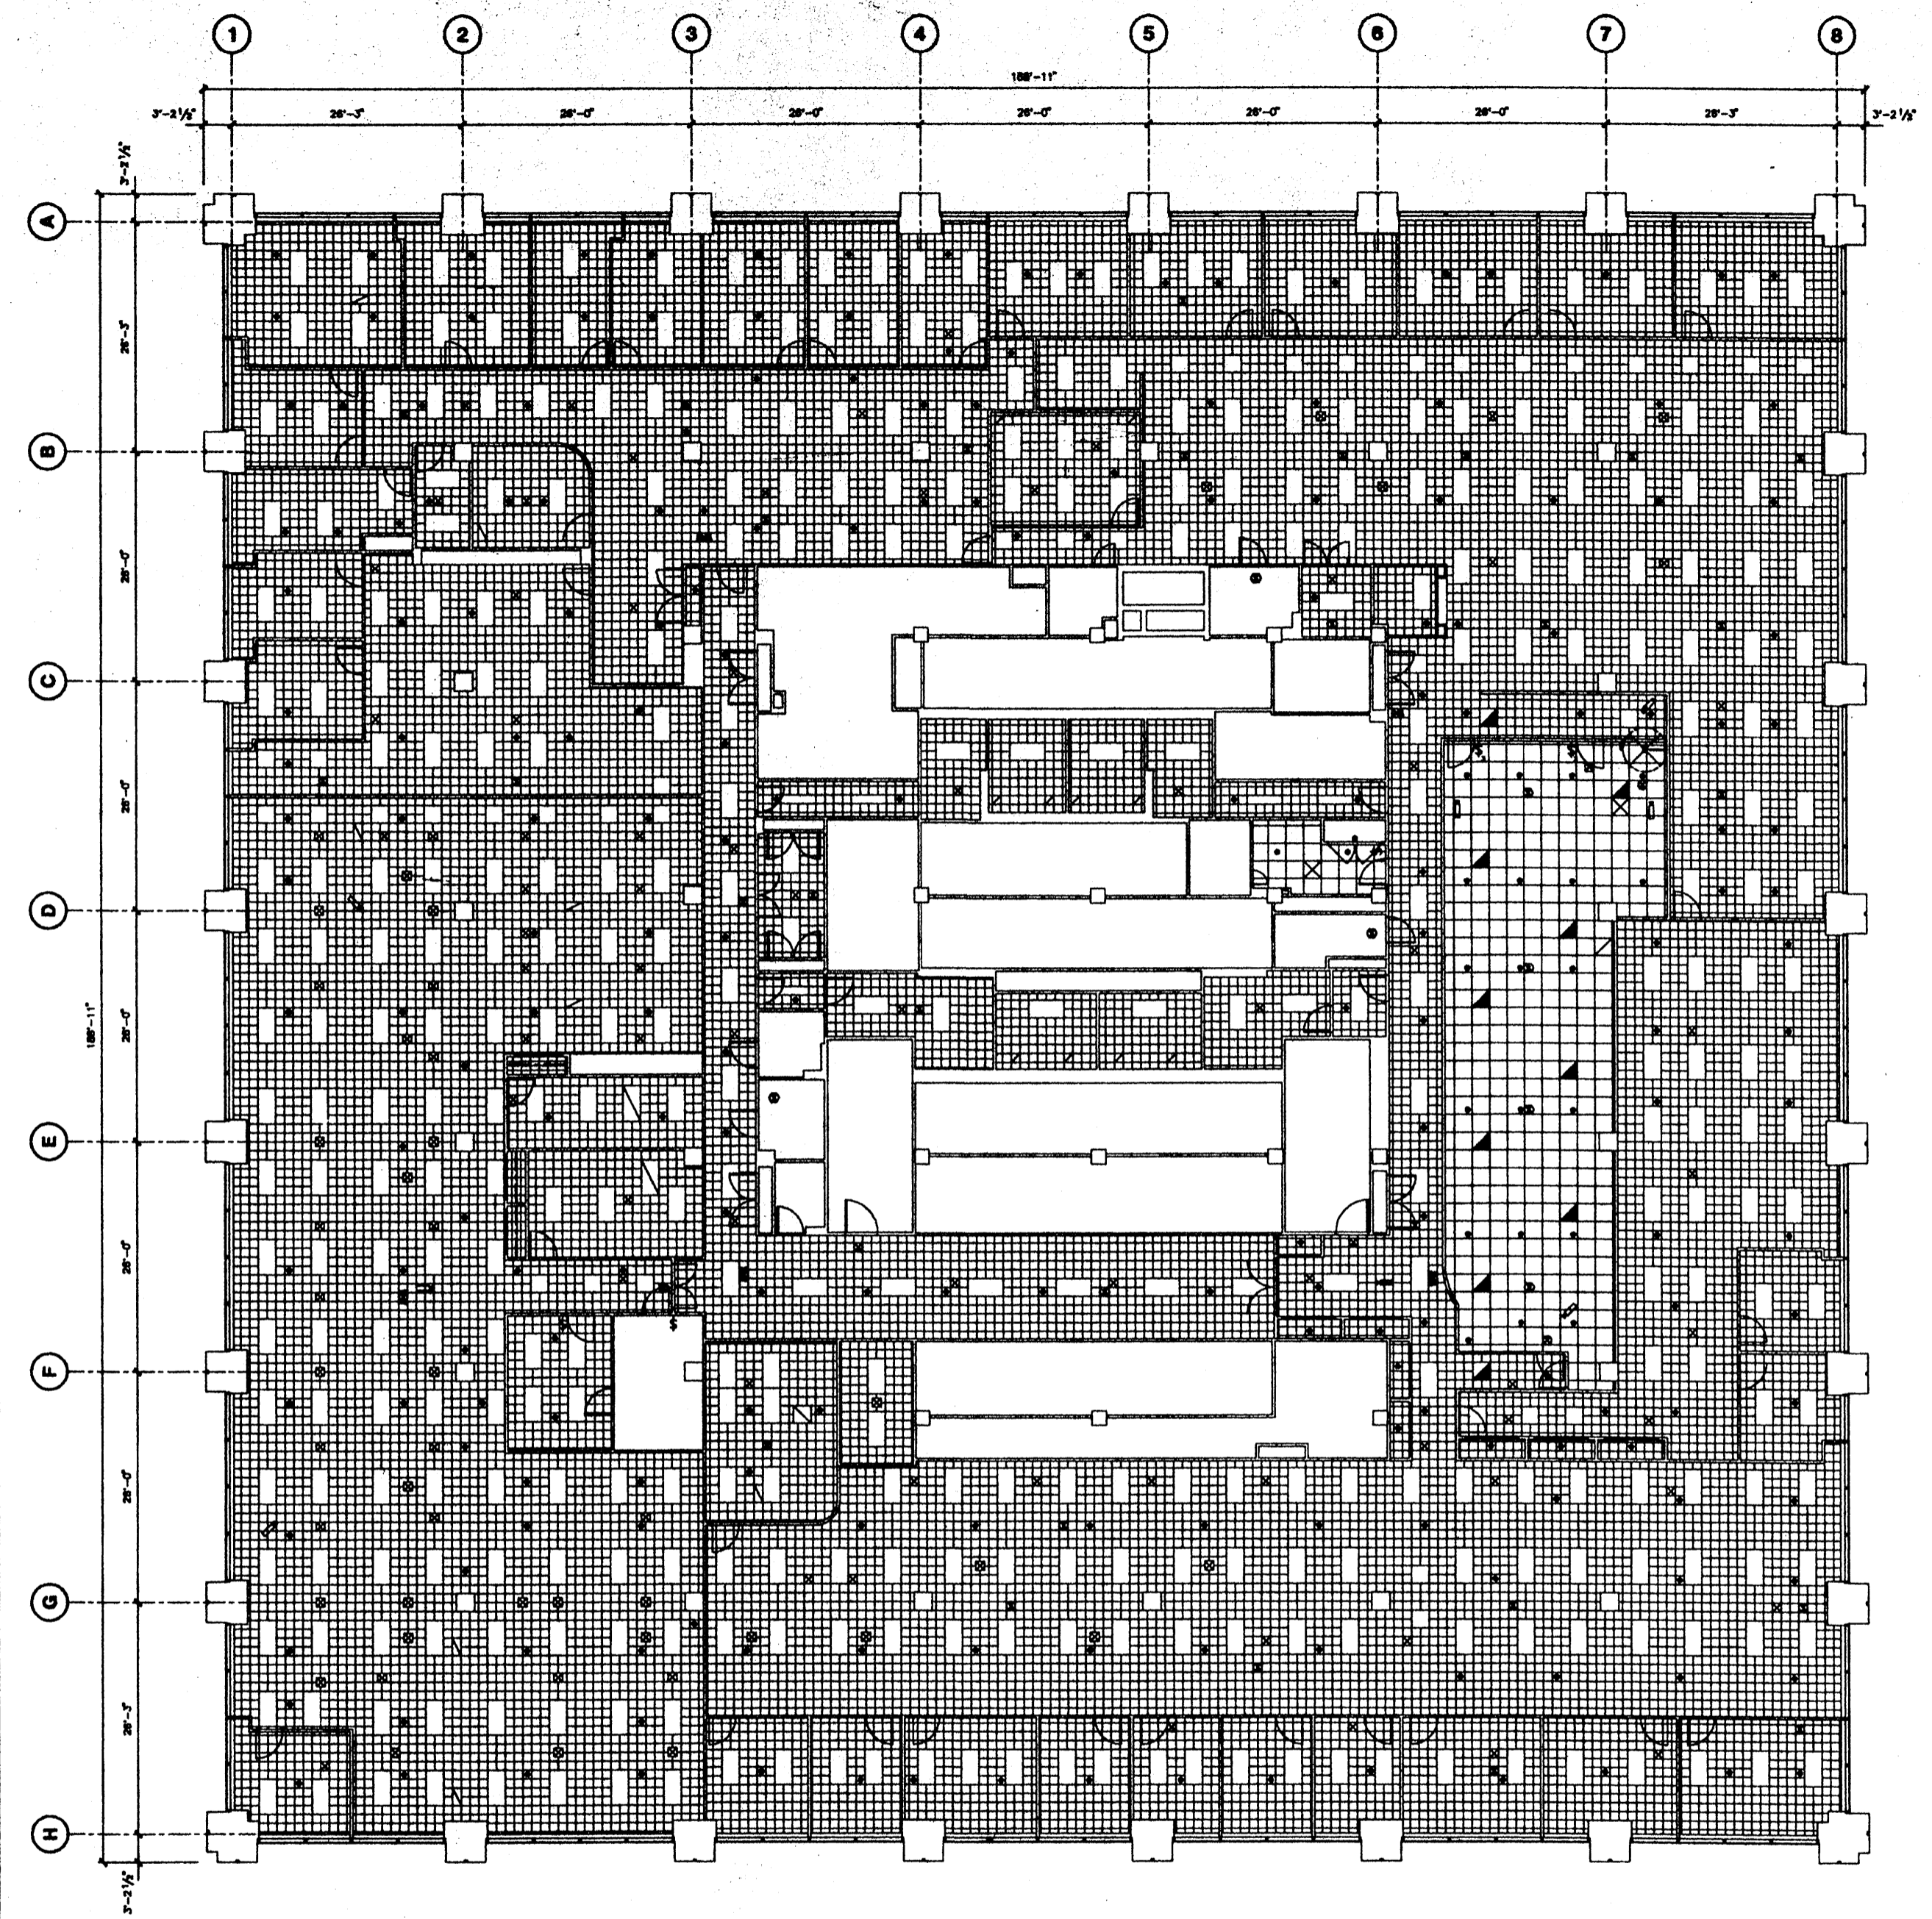

Deutsche Bank

No.	Date	Description
1	12/1/98	Initial Ceiling Plan
2	4/1/03	Update Ceiling Plan for New Ceiling
3	5/15/06	Project 000000004 Telephone/FX Support Relocation
4	1/9/07	Project 000000008 Telephone Equipment Room
5	2/1/07	Project 000000014 Update Lighting Layout
6	7/15/09	Updated for Deutsche Global Survey
7	5/15/01	Updated for Existing Conditions


No.	Date	Issued To

PROJECT
130 LIBERTY STREET

WORK
**7th FLOOR
CEILING
PLAN**

Drawn By	Project No.
Checked By	
Date	5/15/01
Scale	
Project No.	



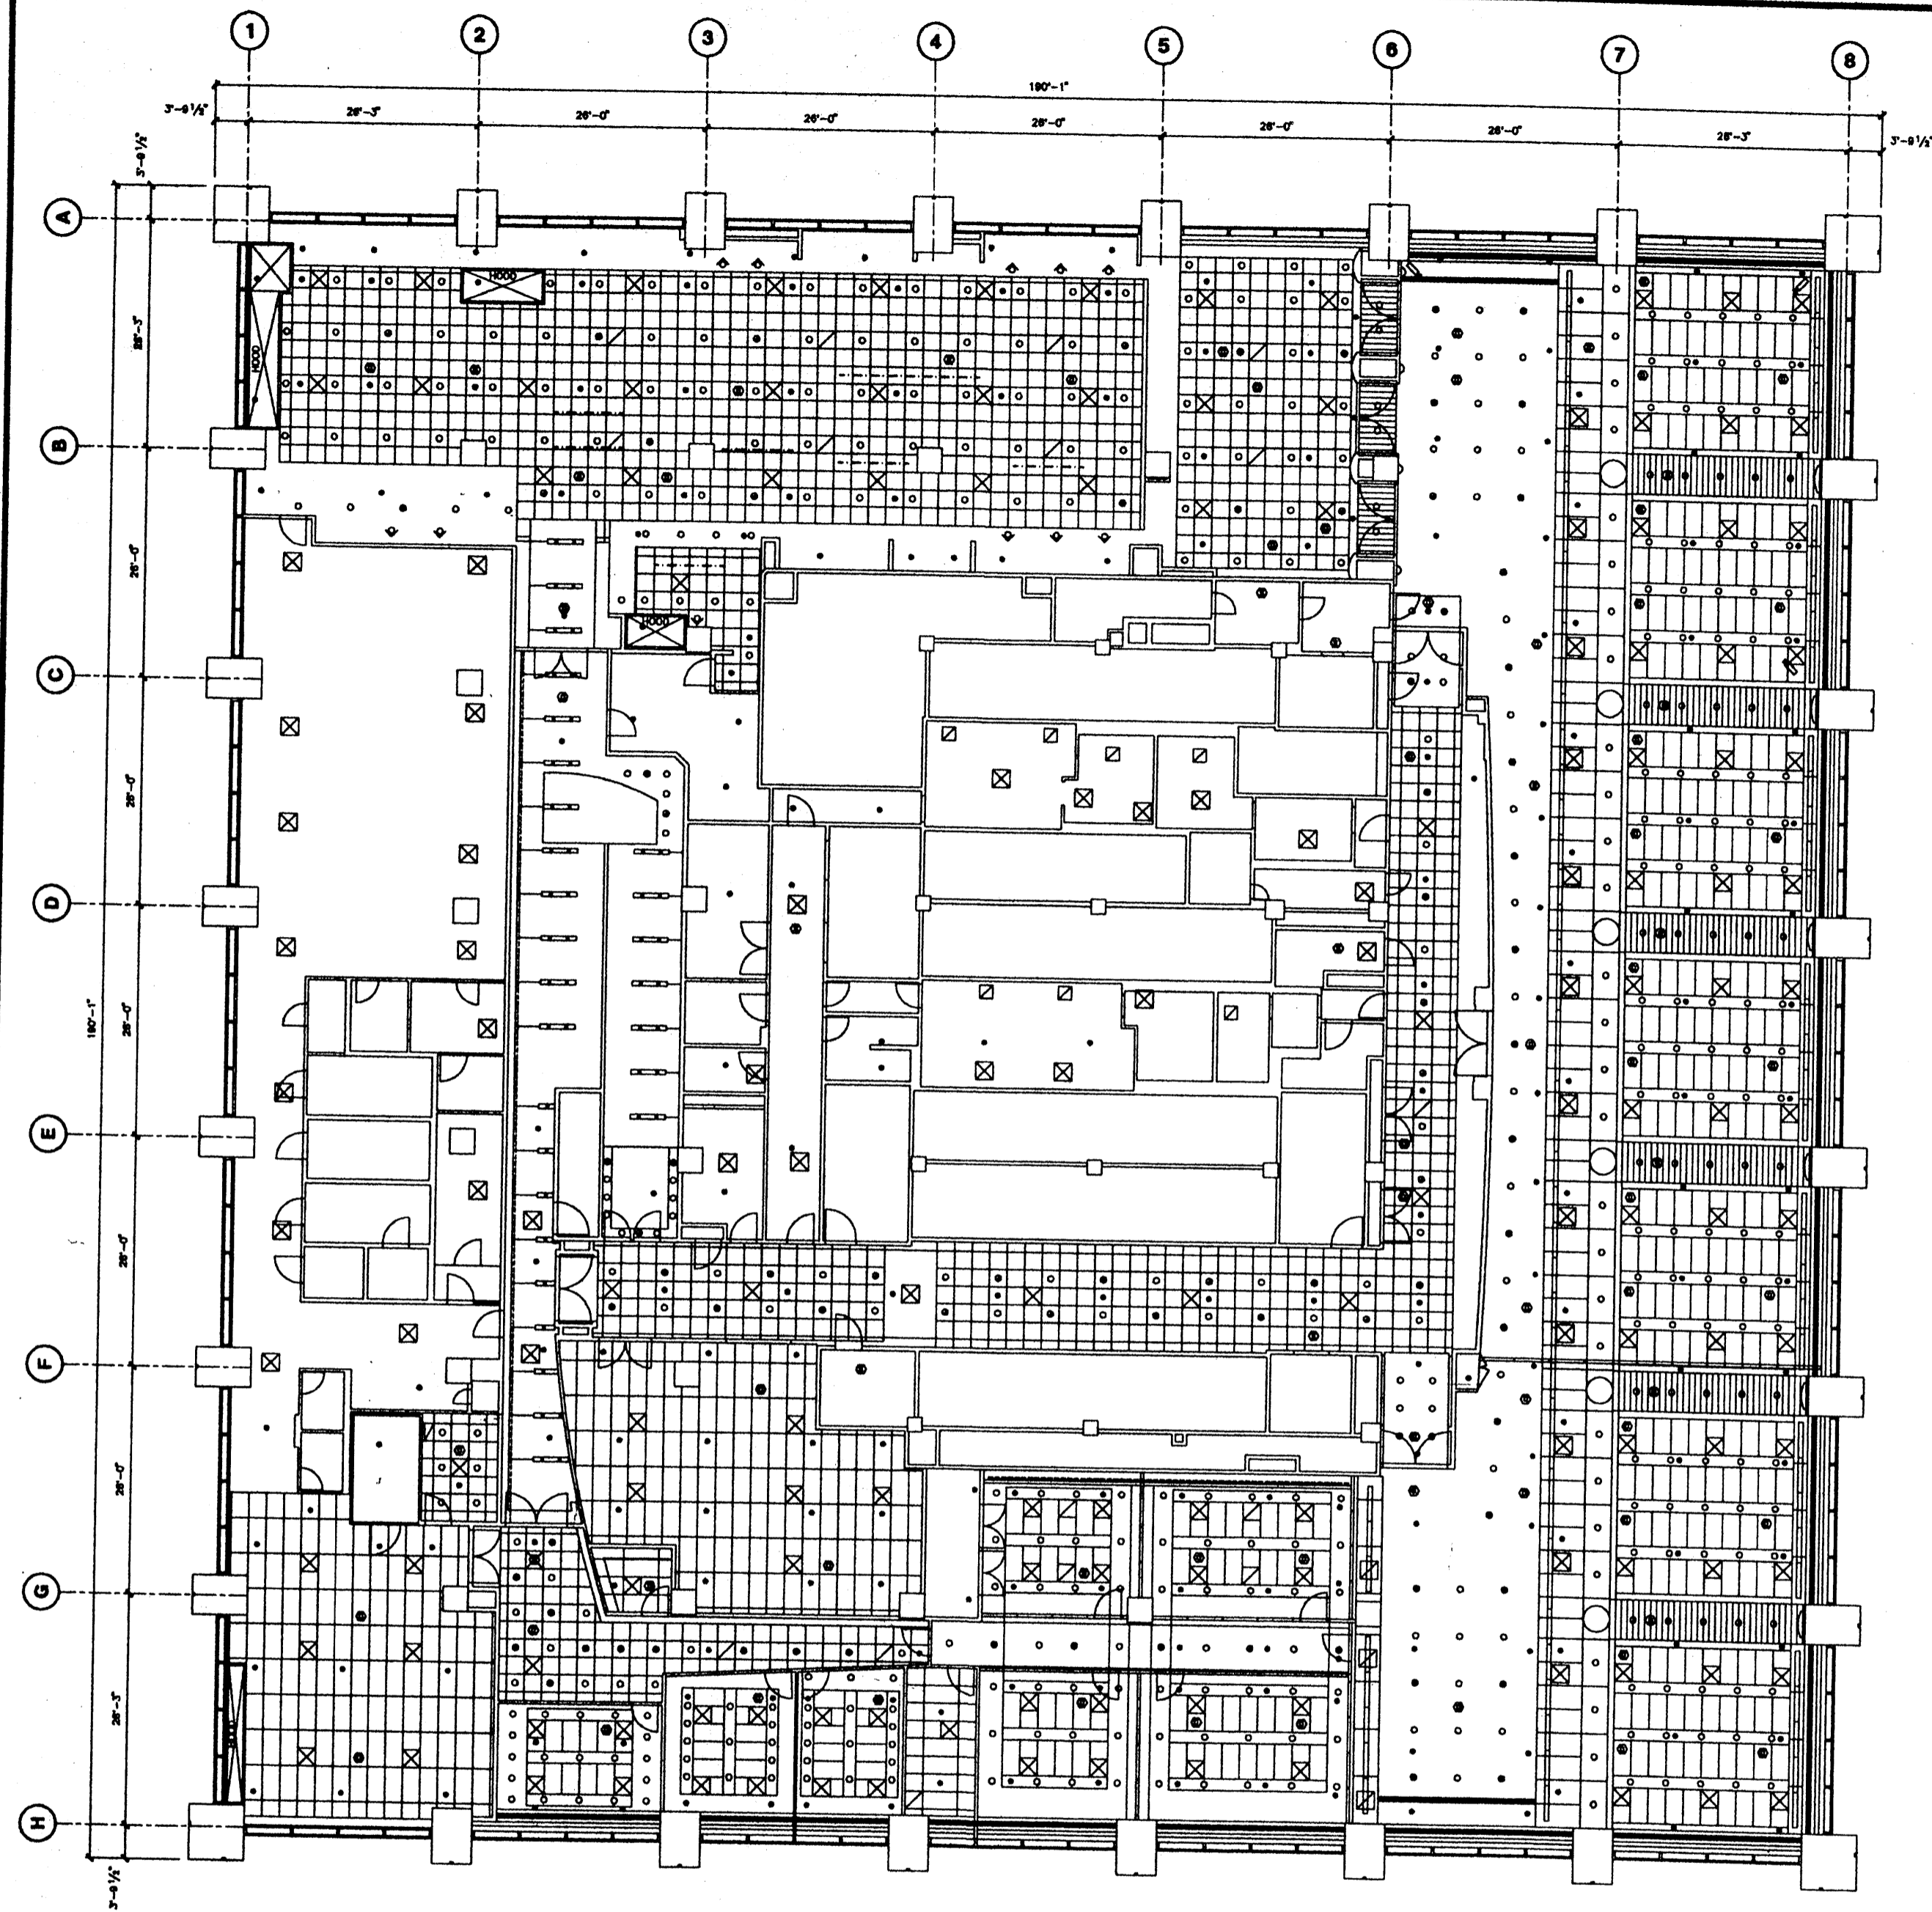

Deutsche Bank

No.	Date	Description
1	12/1/03	Design, 400000011 - Deutsche Bank, System
2	2/6/05	Final, 400000011 - Deutsche Bank, System
3	7/15/05	Updated for Client's Design System
4	6/1/06	Revised floor


No.	Date	Revised To

130 LIBERTY STREET

4th FLOOR CEILING PLAN

Drawn by	
Checked by	
Date	5/1/06
Scale	
Project No.	



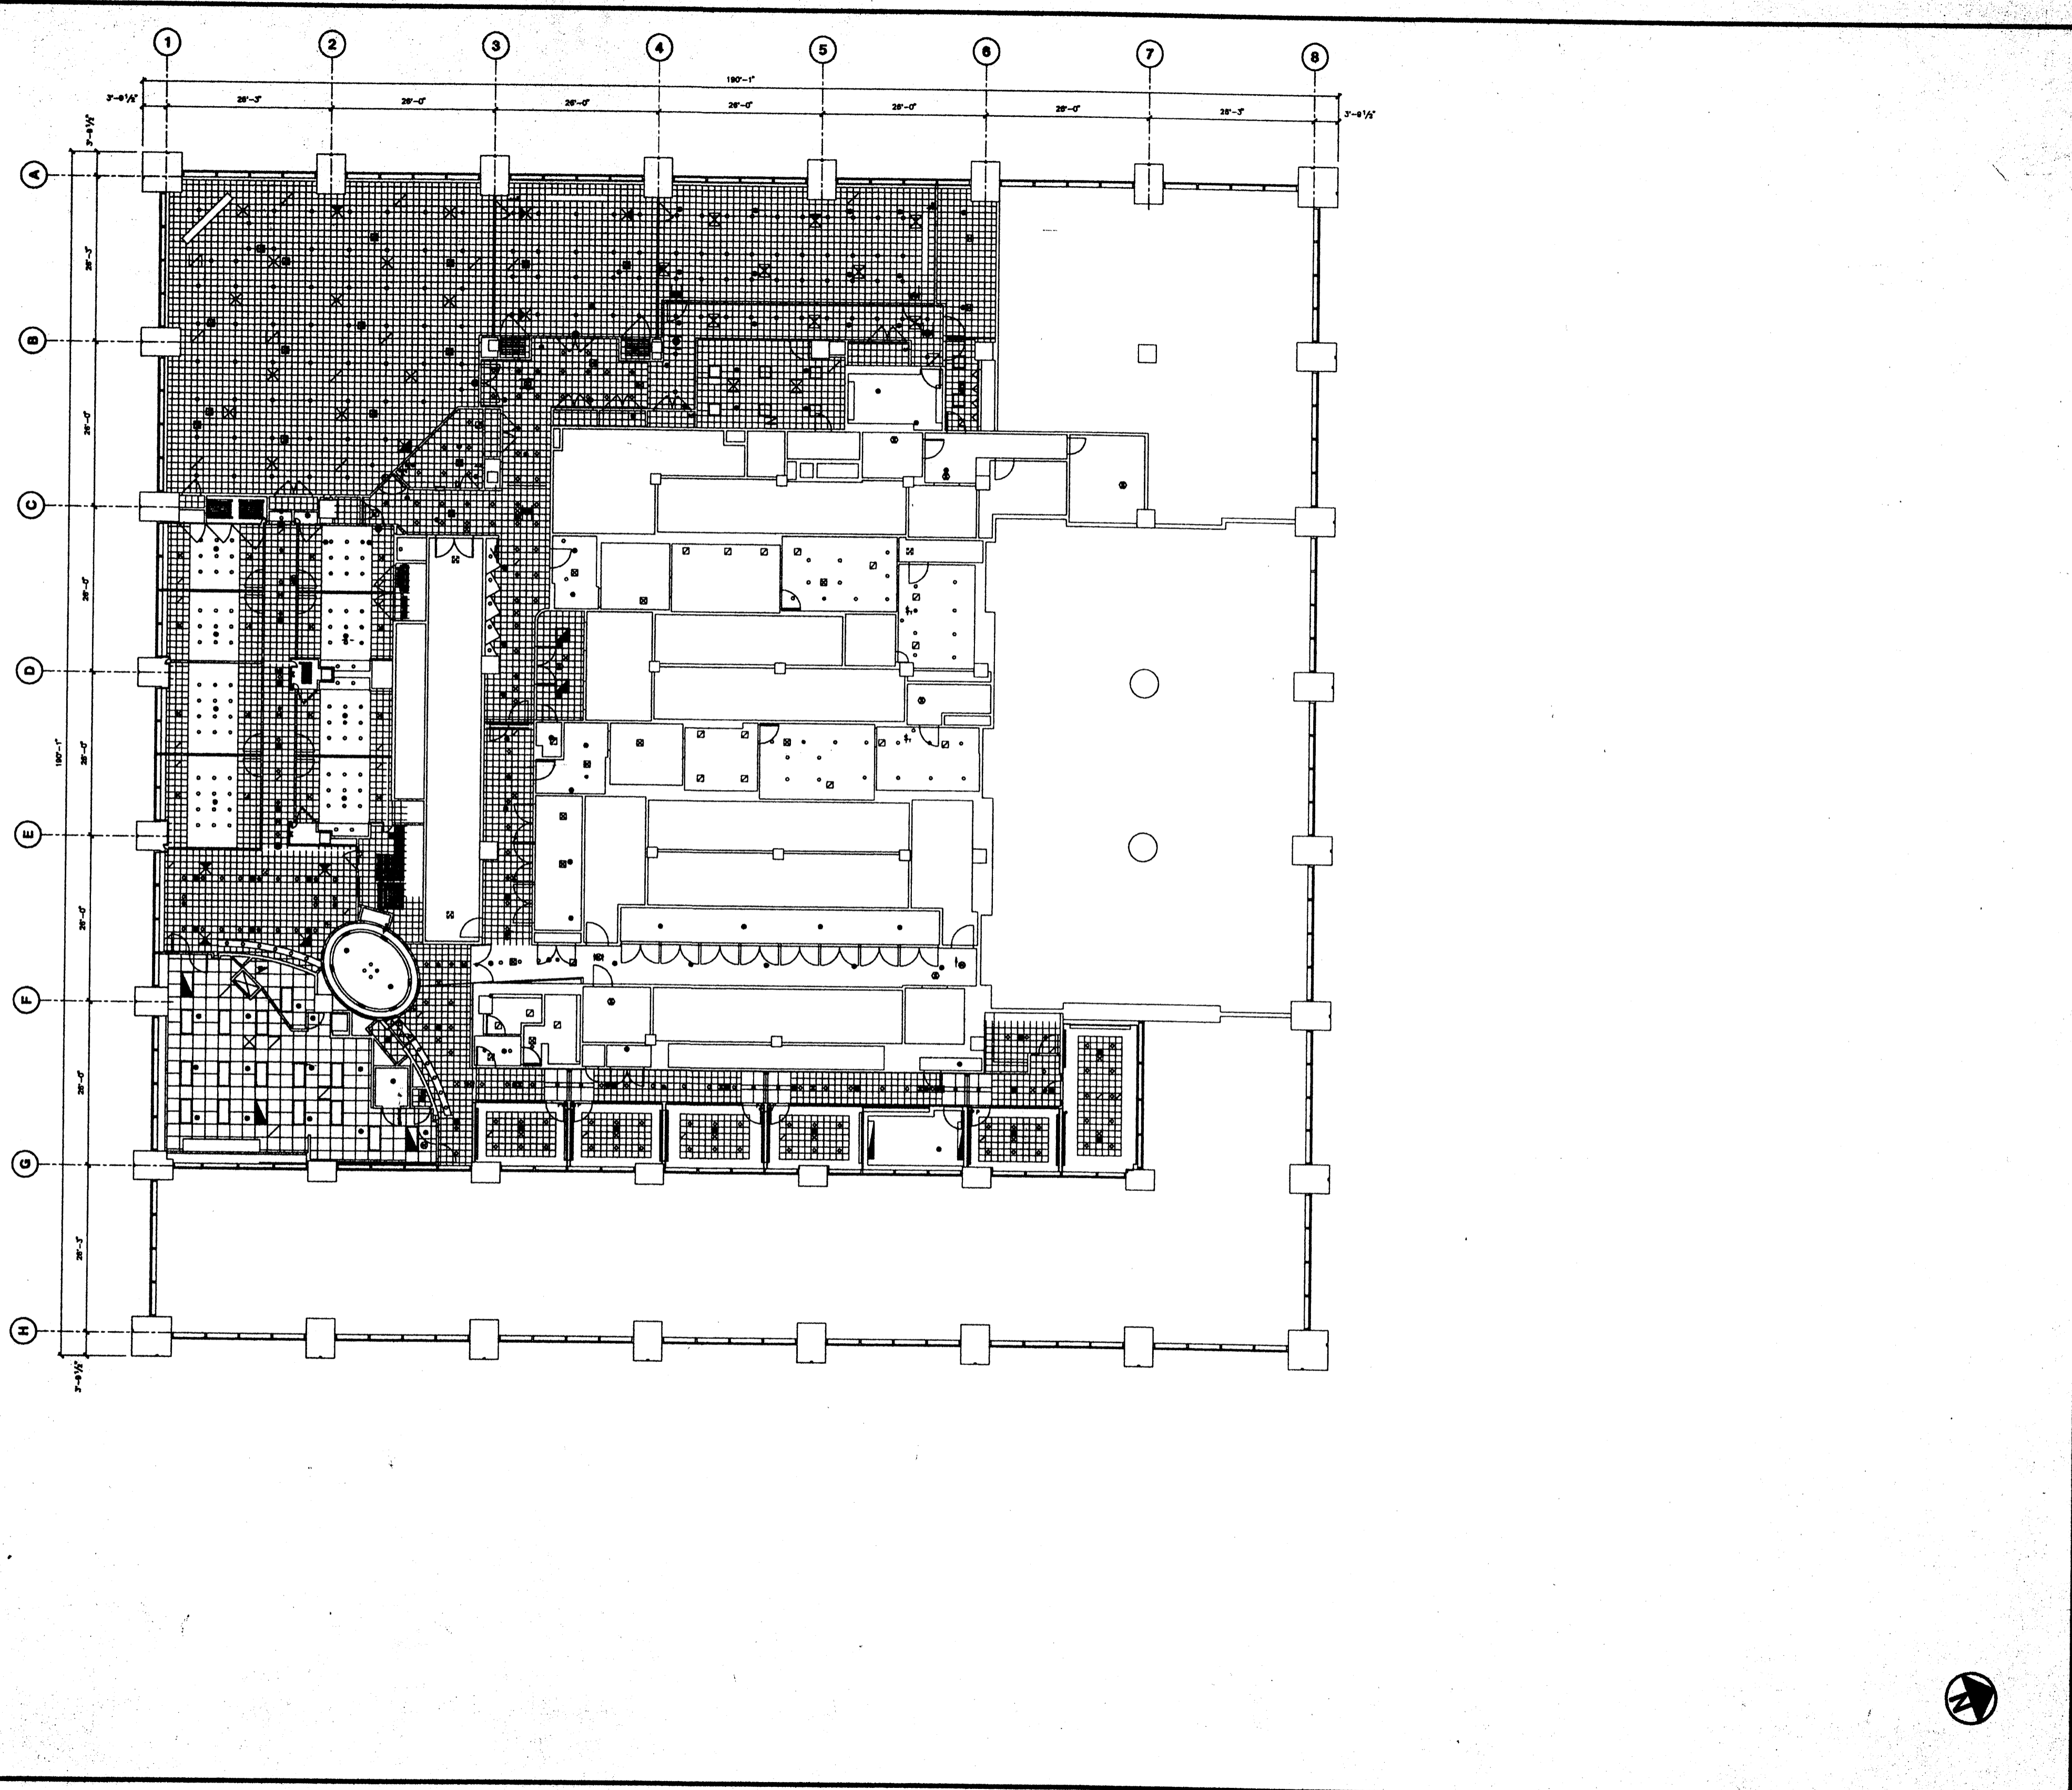

Deutsche Bank


No.	Date	Description
1	11/15/93	Initial Concept, 02007000 & 02000100, 02000200, 02000300, 02009900, 02010000
2	10/25/98	Added Corridor at Western Banking Hours
3	7/15/98	Updated for Deutsche Bank Signage


No.	Date	Issued To

PROJECT
130 LIBERTY STREET

WORK
3rd FLOOR CEILING PLAN

Drawn By	
Checked By	
Date	7/15/98
Scale	
Project No.	

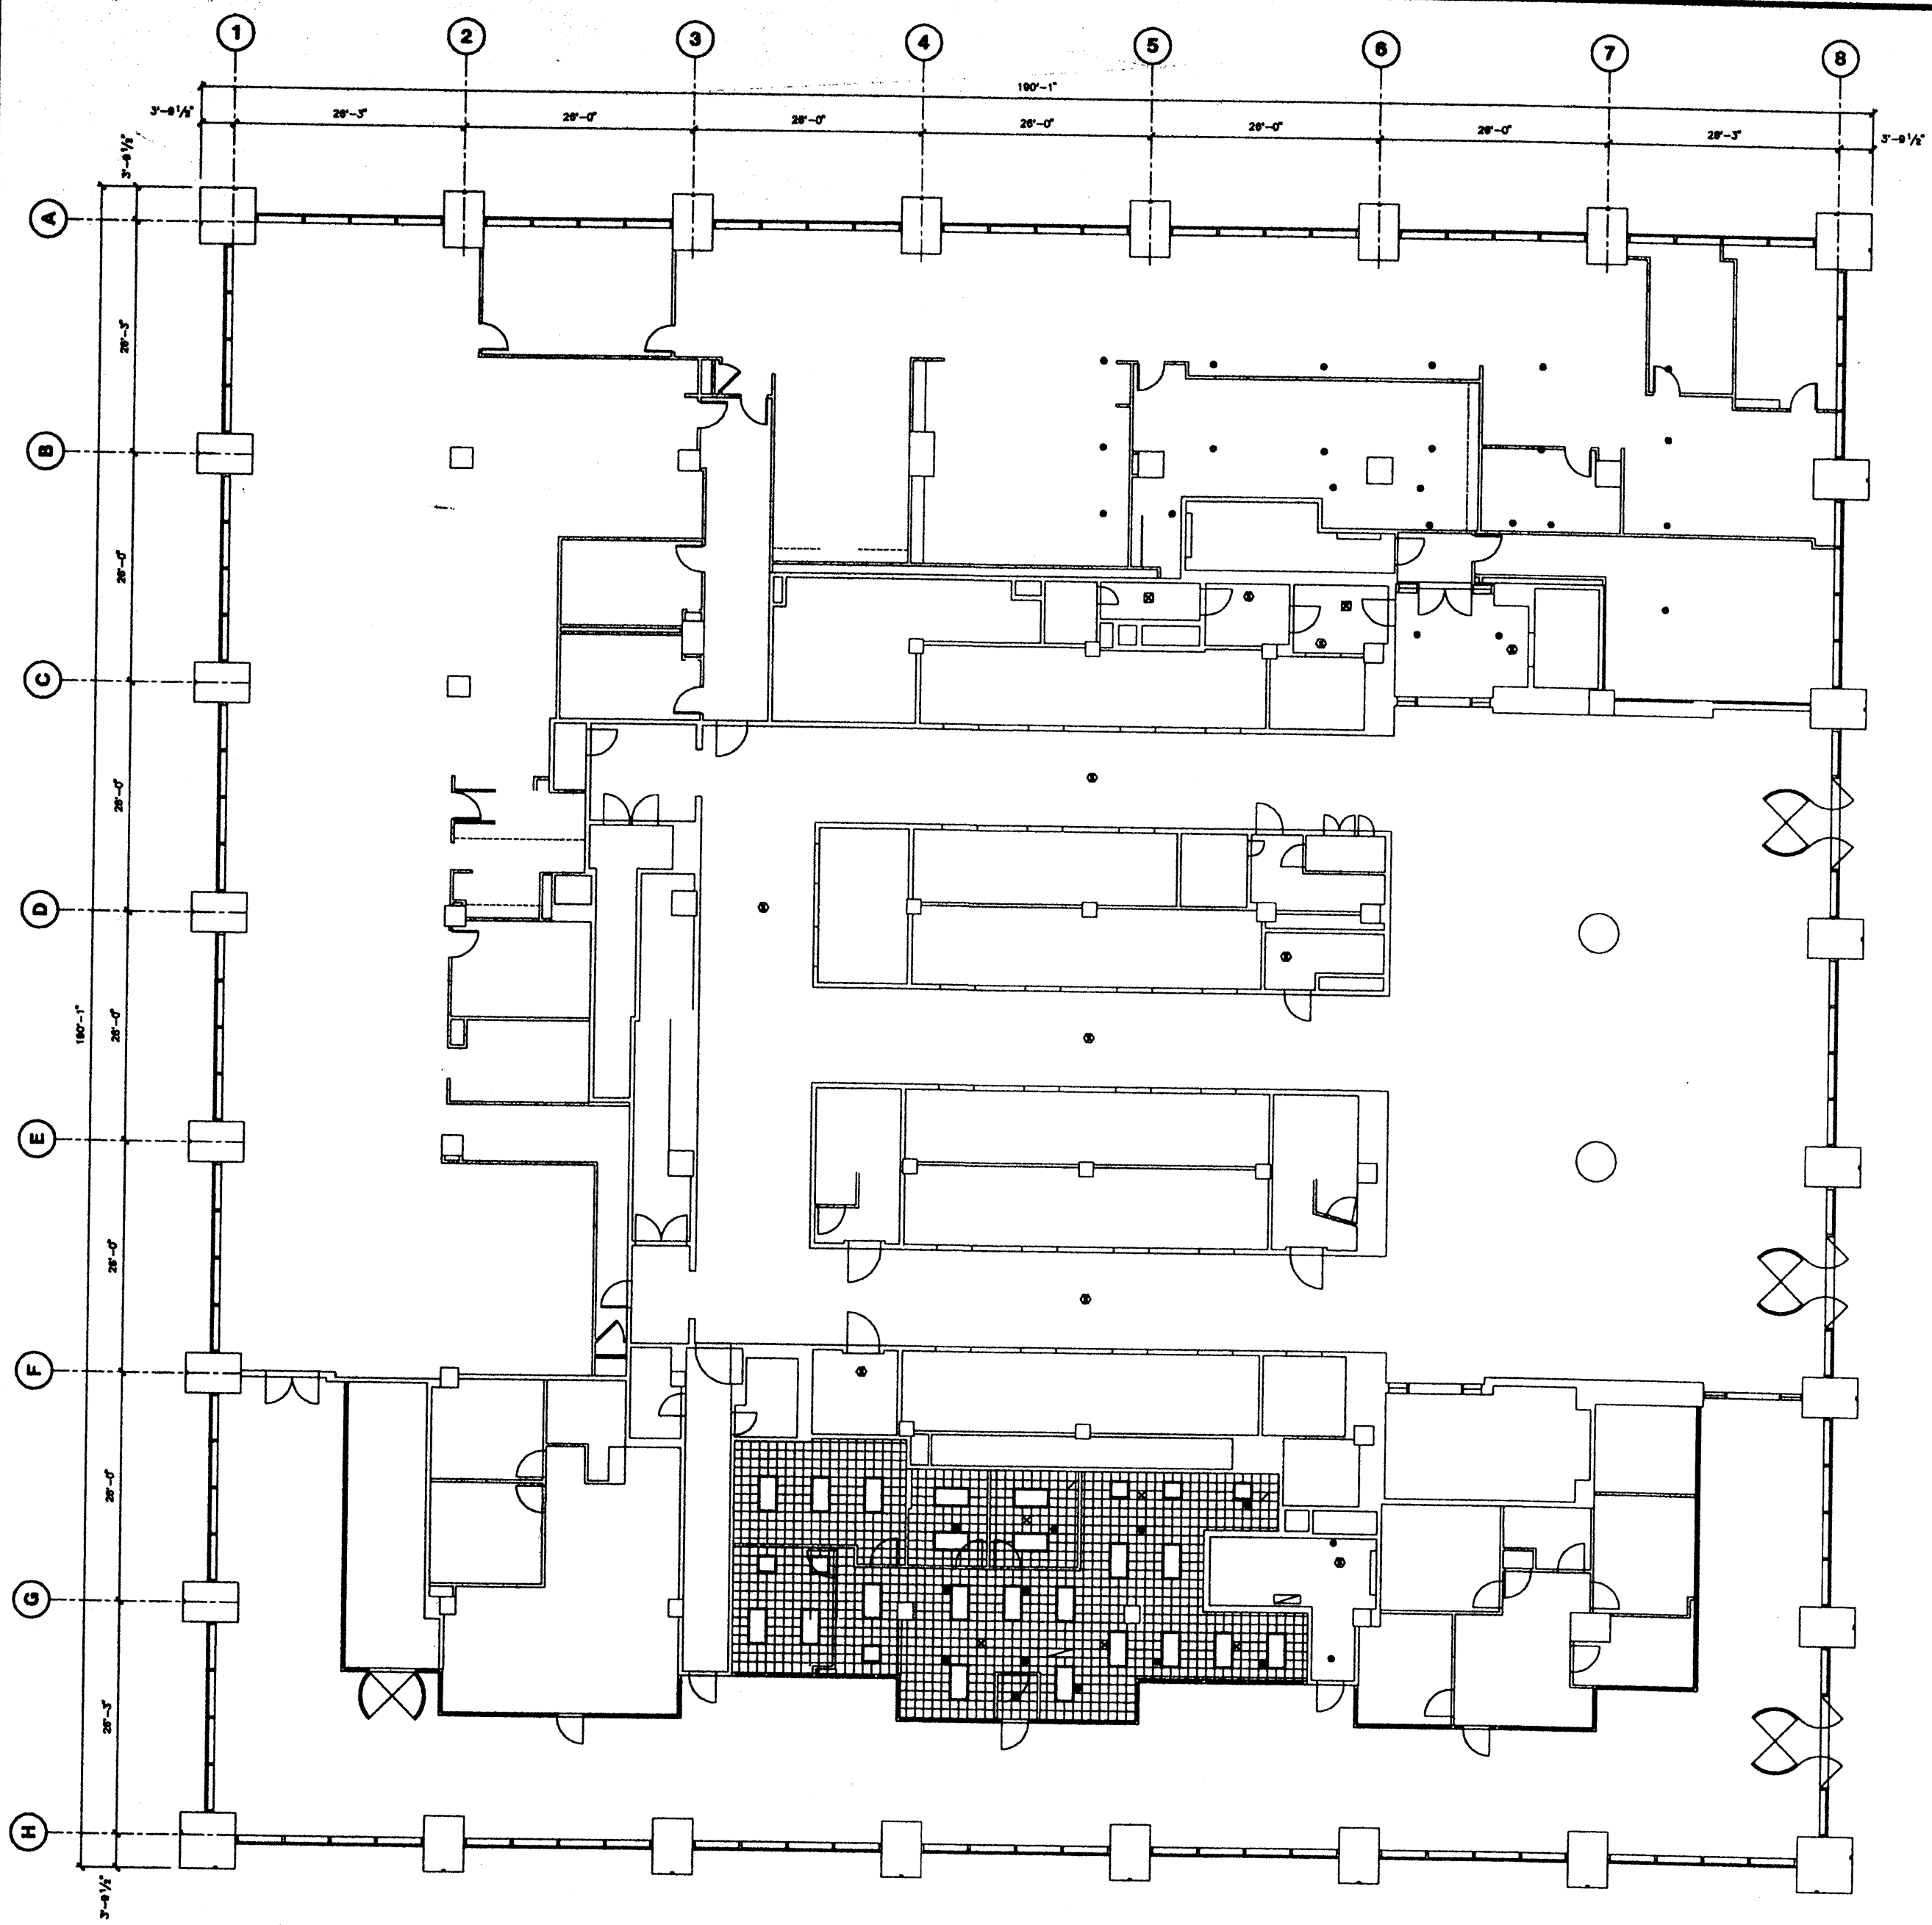

Deutsche Bank 
130 LIBERTY STREET
2nd FLOOR CEILING PLAN

3	7/15/99	Updated for Electric Closet Survey	Checked By	
2	6/26/97	Added - Project #80000792	Date	7/15/99
1	11/15/93	Added Stairs to Third Floor	Drawn	
			Project No.	