


RECEIVED
 DEC 19 2001
 GILBANE

Deutsche Bank
 130 LIBERTY STREET
 1st FLOOR

3	7/1/98	Updated Fire Alarm Control Panel
4	7/1/98	Project #20001983 - Civil Work
5	8/1/98	Project #20002392 - Emergency Generators
6	5/10/98	Project #20003482 - Display Center
7	5/10/98	Project #20002813 - Display Center
8	5/10/98	Project #20002813 - Display Center
9	5/10/98	Project #20002813 - Display Center
10	5/10/98	Project #20002813 - Display Center

Drawn By	Checked By
Date	0/1/95
Scale	
Project No.	

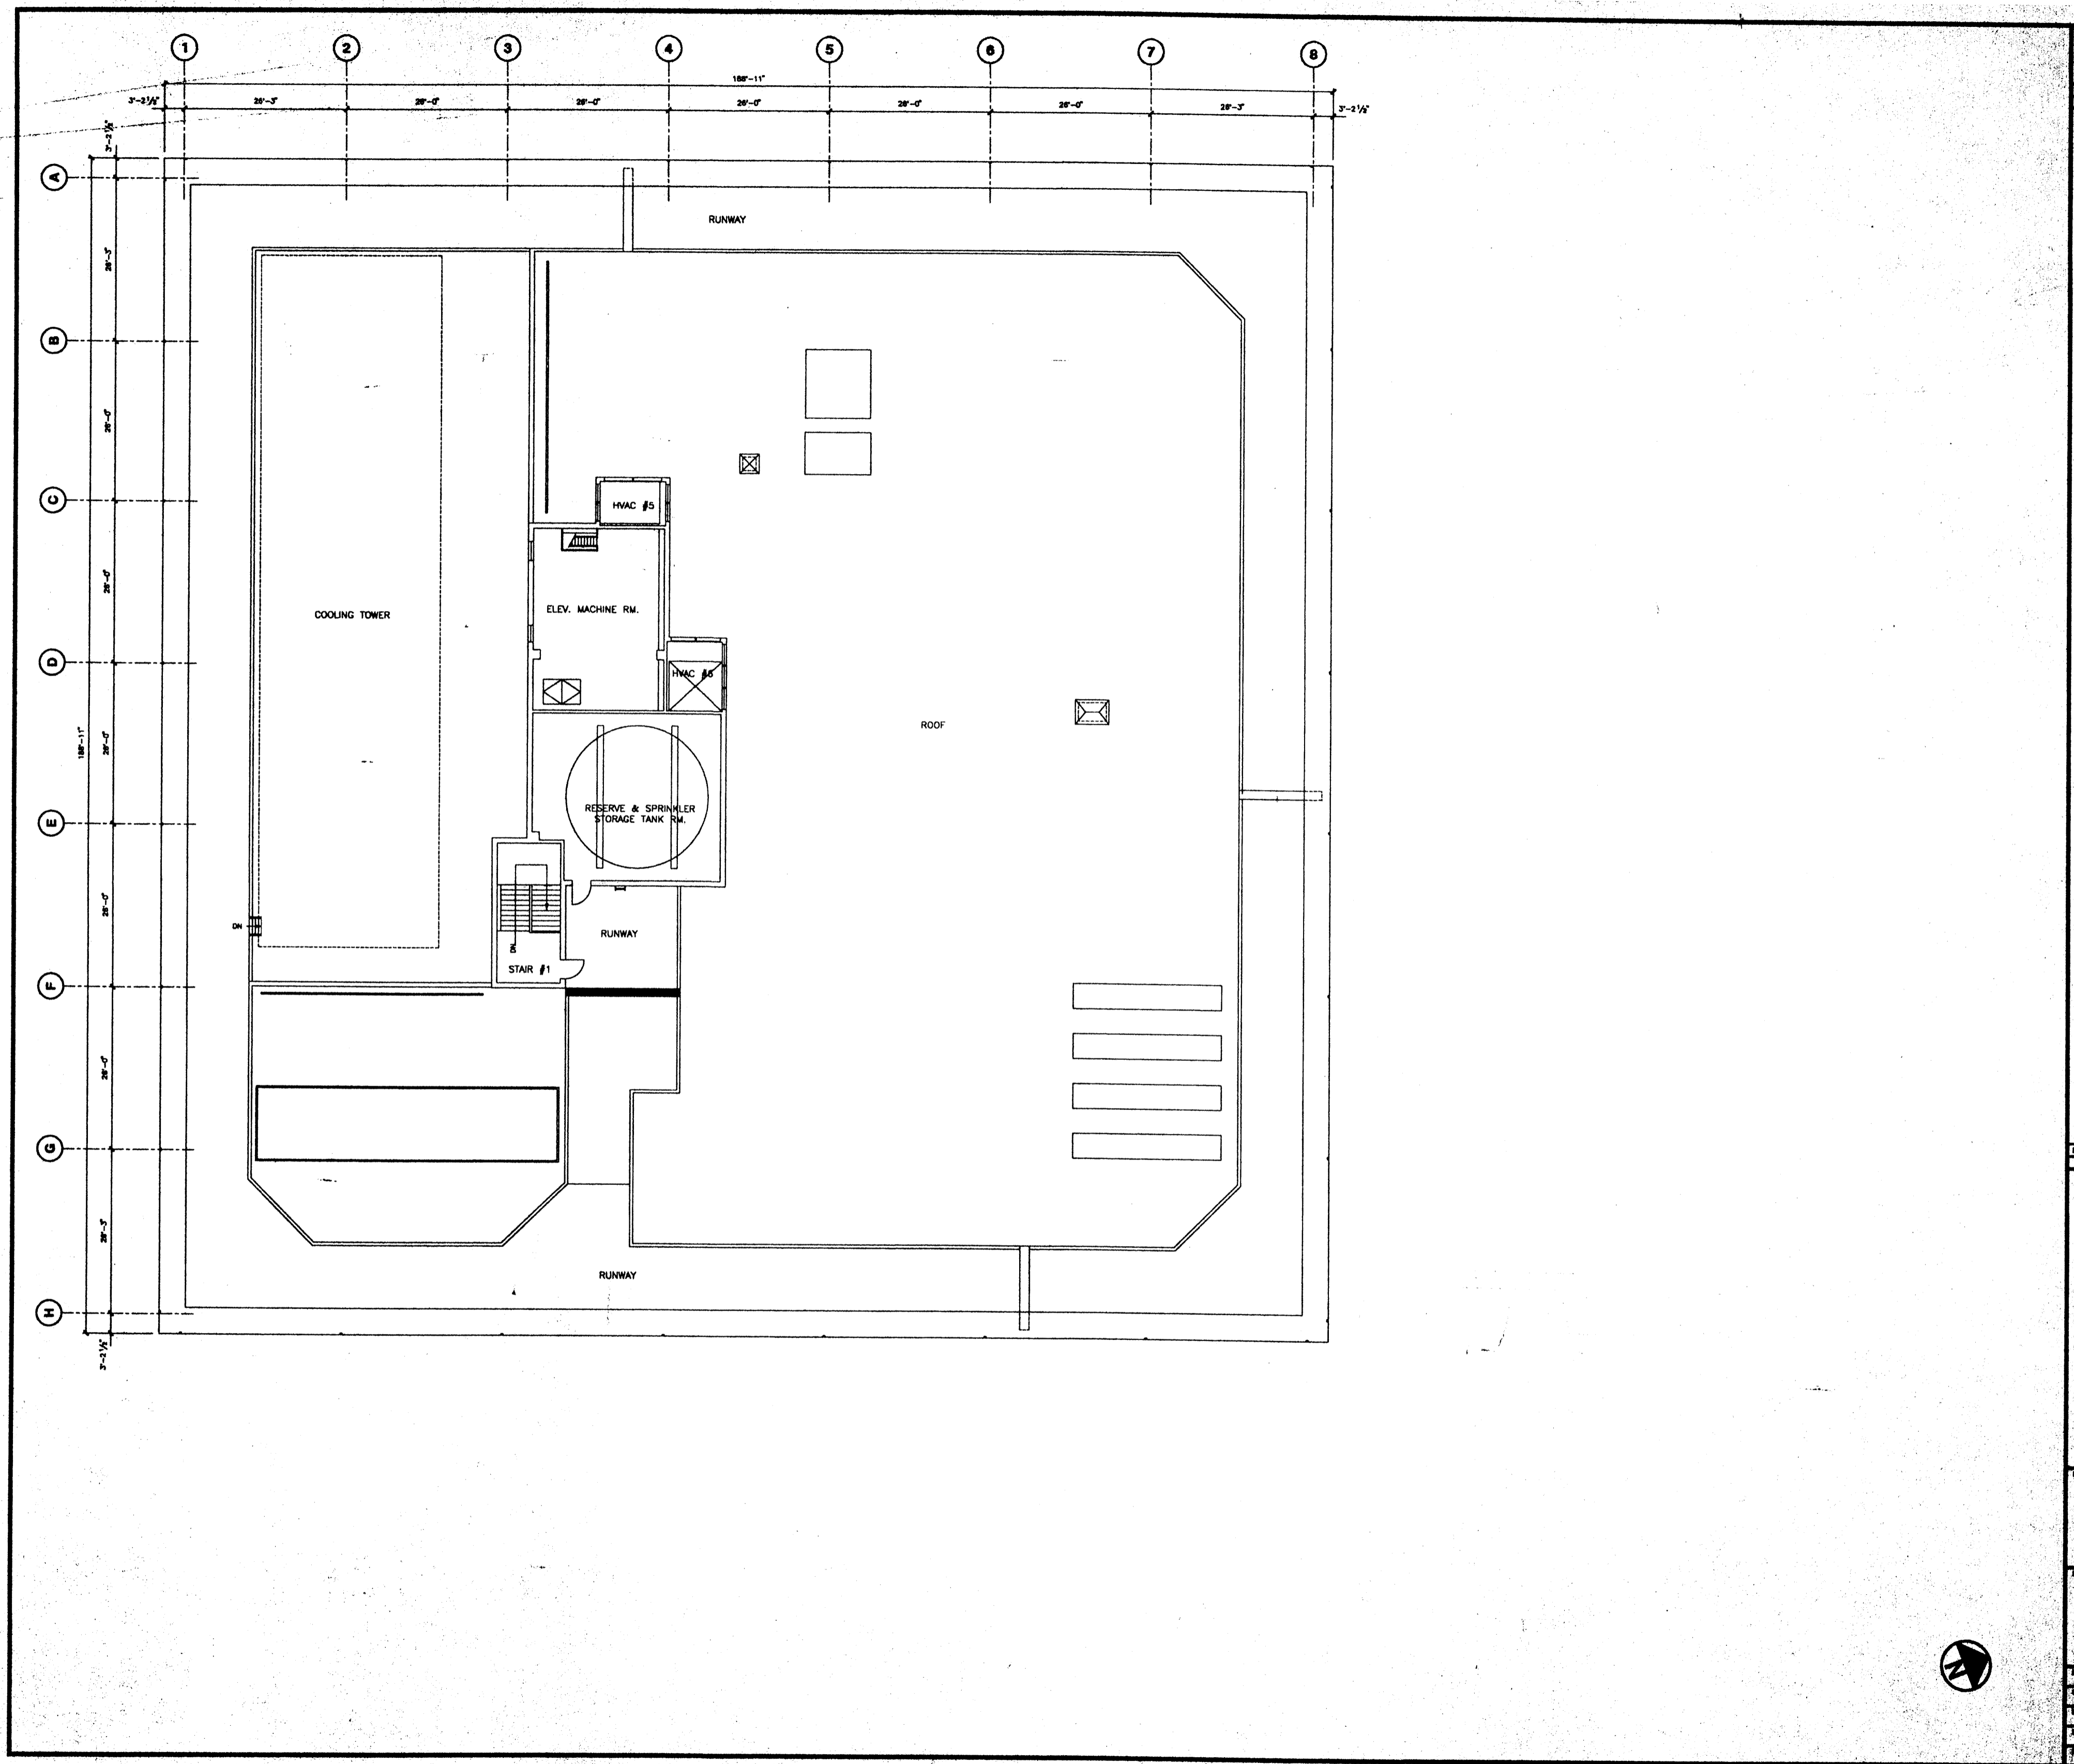

Deutsche Bank


No. Date Issued To

130 LIBERTY STREET

ROOF

Date: 1/13/05
 Prepared By:



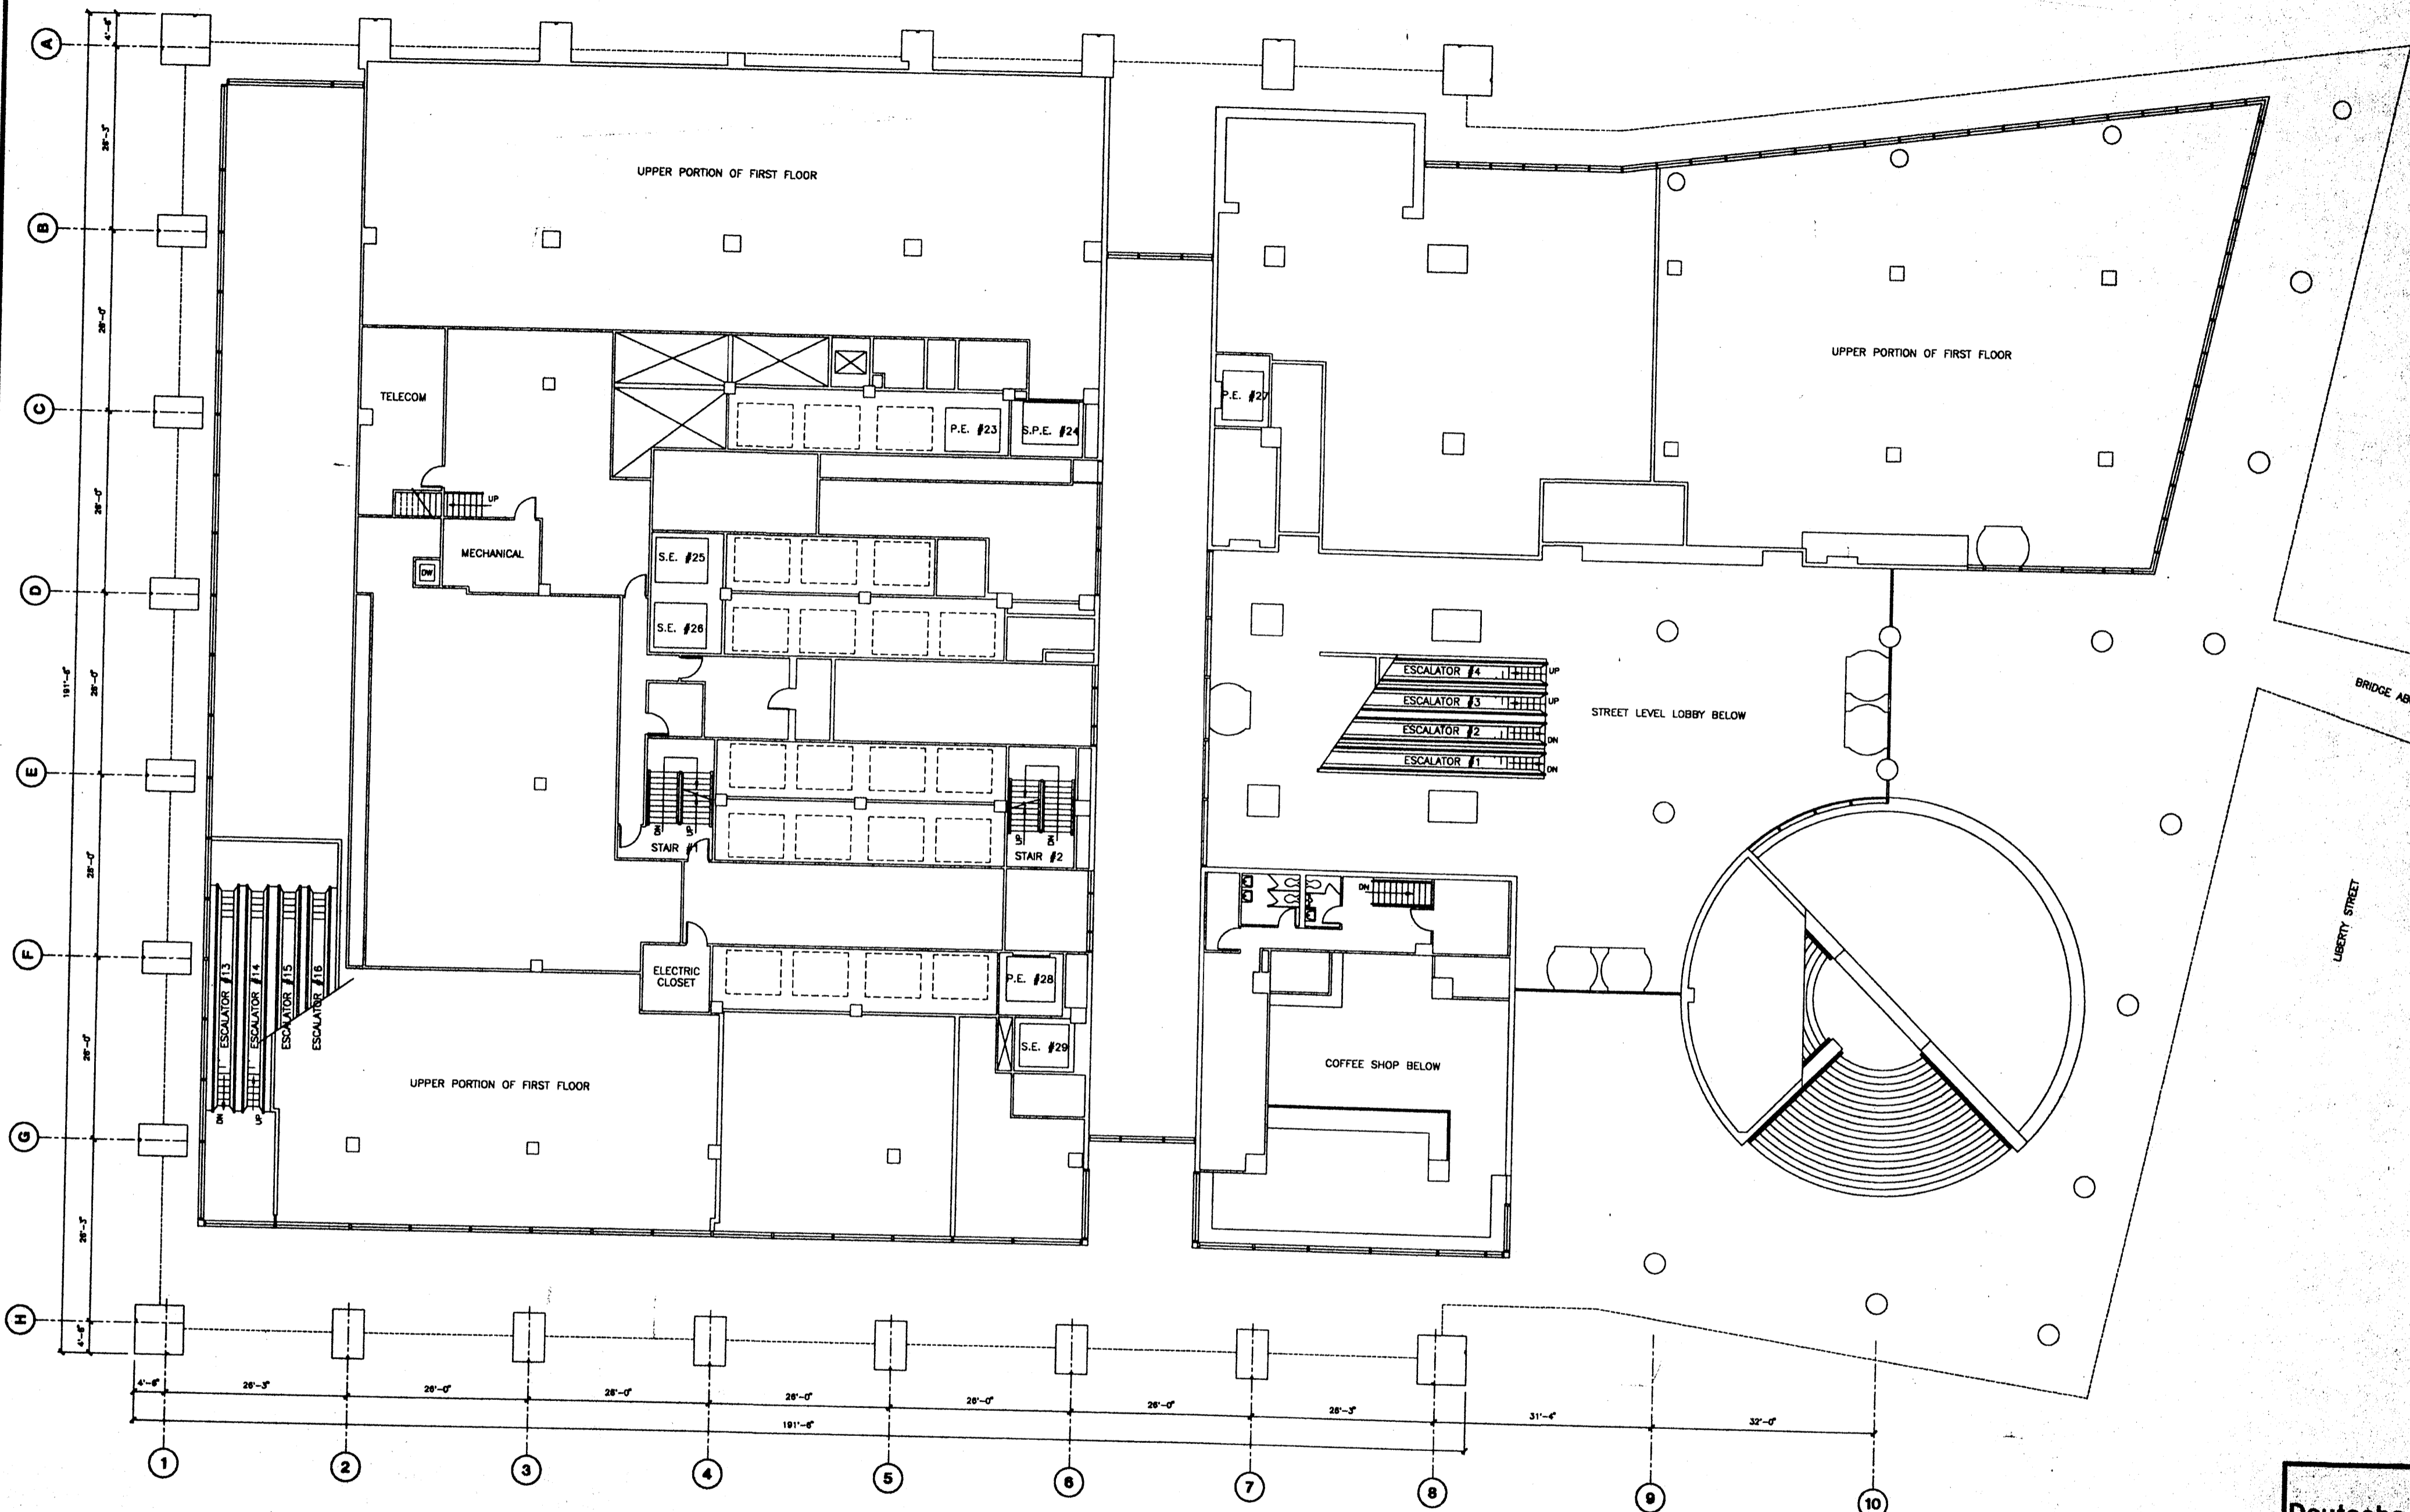


Deutsche Bank

130 LIBERTY STREET

MEZZANINE



Drawn By	Checked By	Scale	Date	7/1/98
Author	Designer	Architect	Project No.	

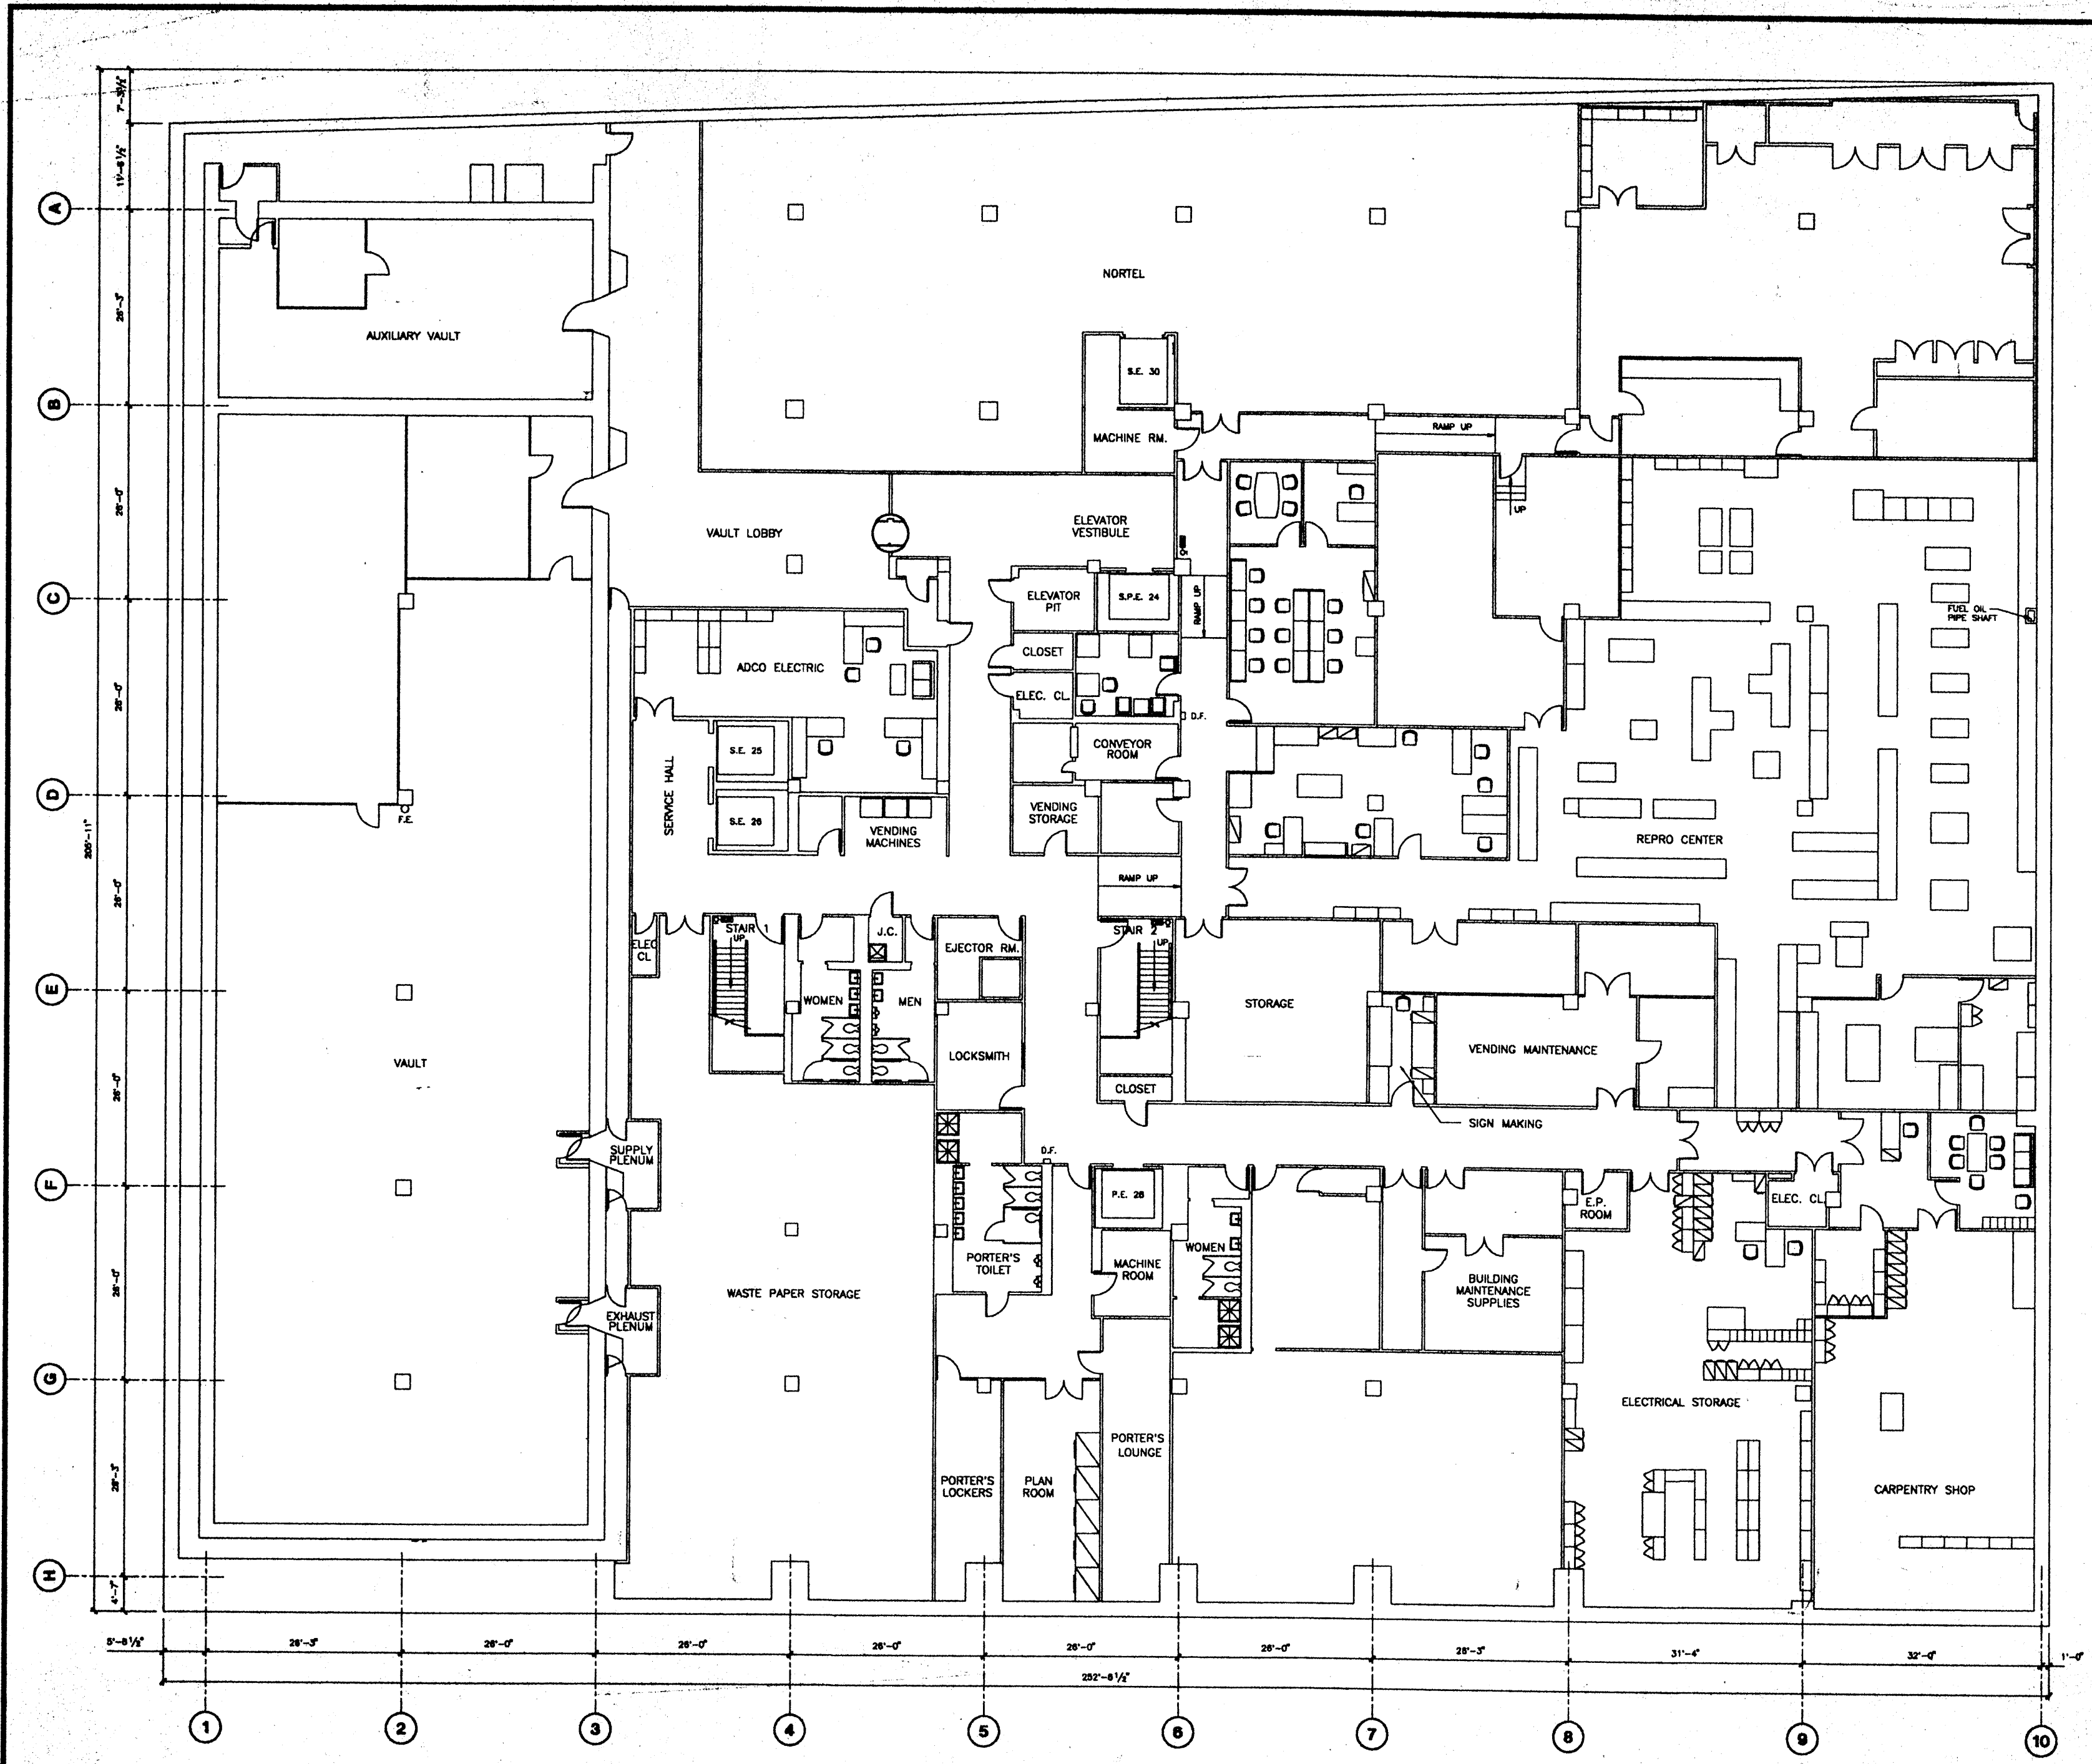

Deutsche Bank

No.	Date	Description
1	2/1/97	Updated with 2nd Floor Plans
2	7/18/98	Updated for Deutsche Bank Branch
3	9/1/01	Modified for Electrical Compliance


No.	Date	Revised To

130 LIBERTY STREET

CELLAR B

Drawn By	
Checked By	
Date	9/1/01
Scale	
Project No.	




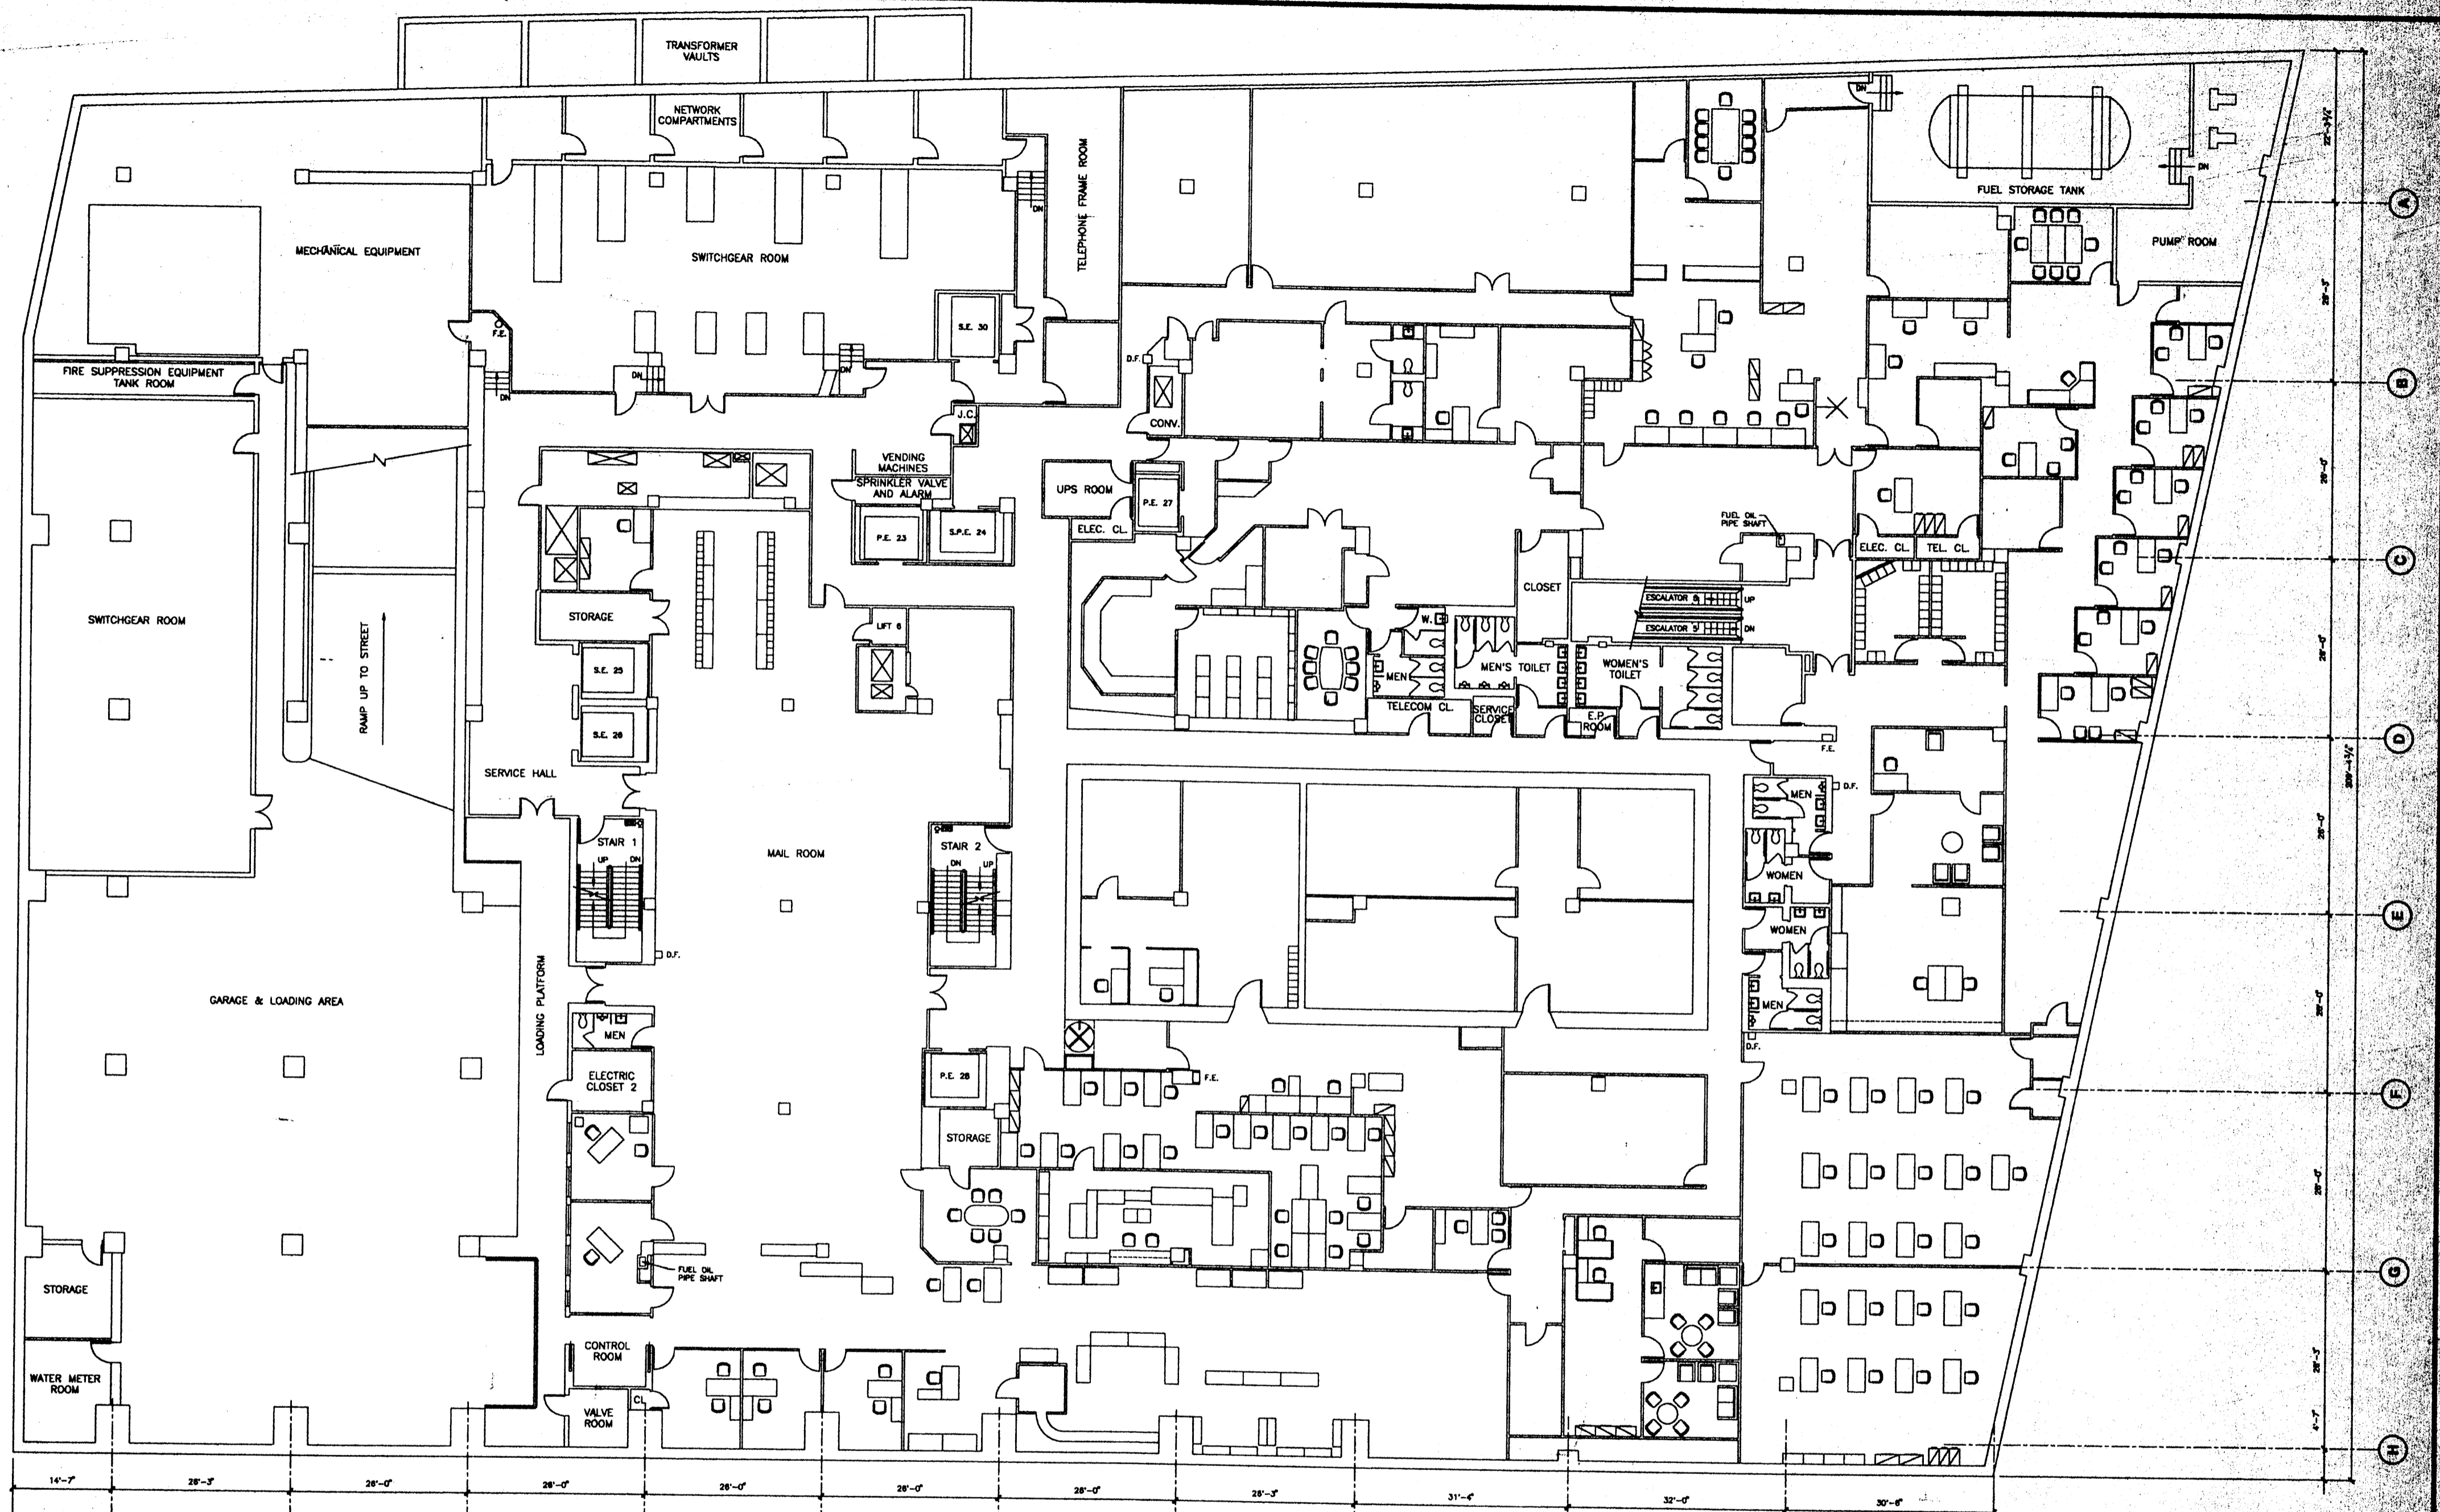

Deutsche Bank
 PROJECT
130 LIBERTY STREET
 DRAWING
CELLAR A

3	8/1/01	Updated for Existing Conditions	Checked By	
2	7/15/98	Updated for Electric Closet Survey	Date	8/1/01
1	8/1/98	Project #00003300 - Emergency Structures	Scale	
Rev.	Date	Description	Project No.	



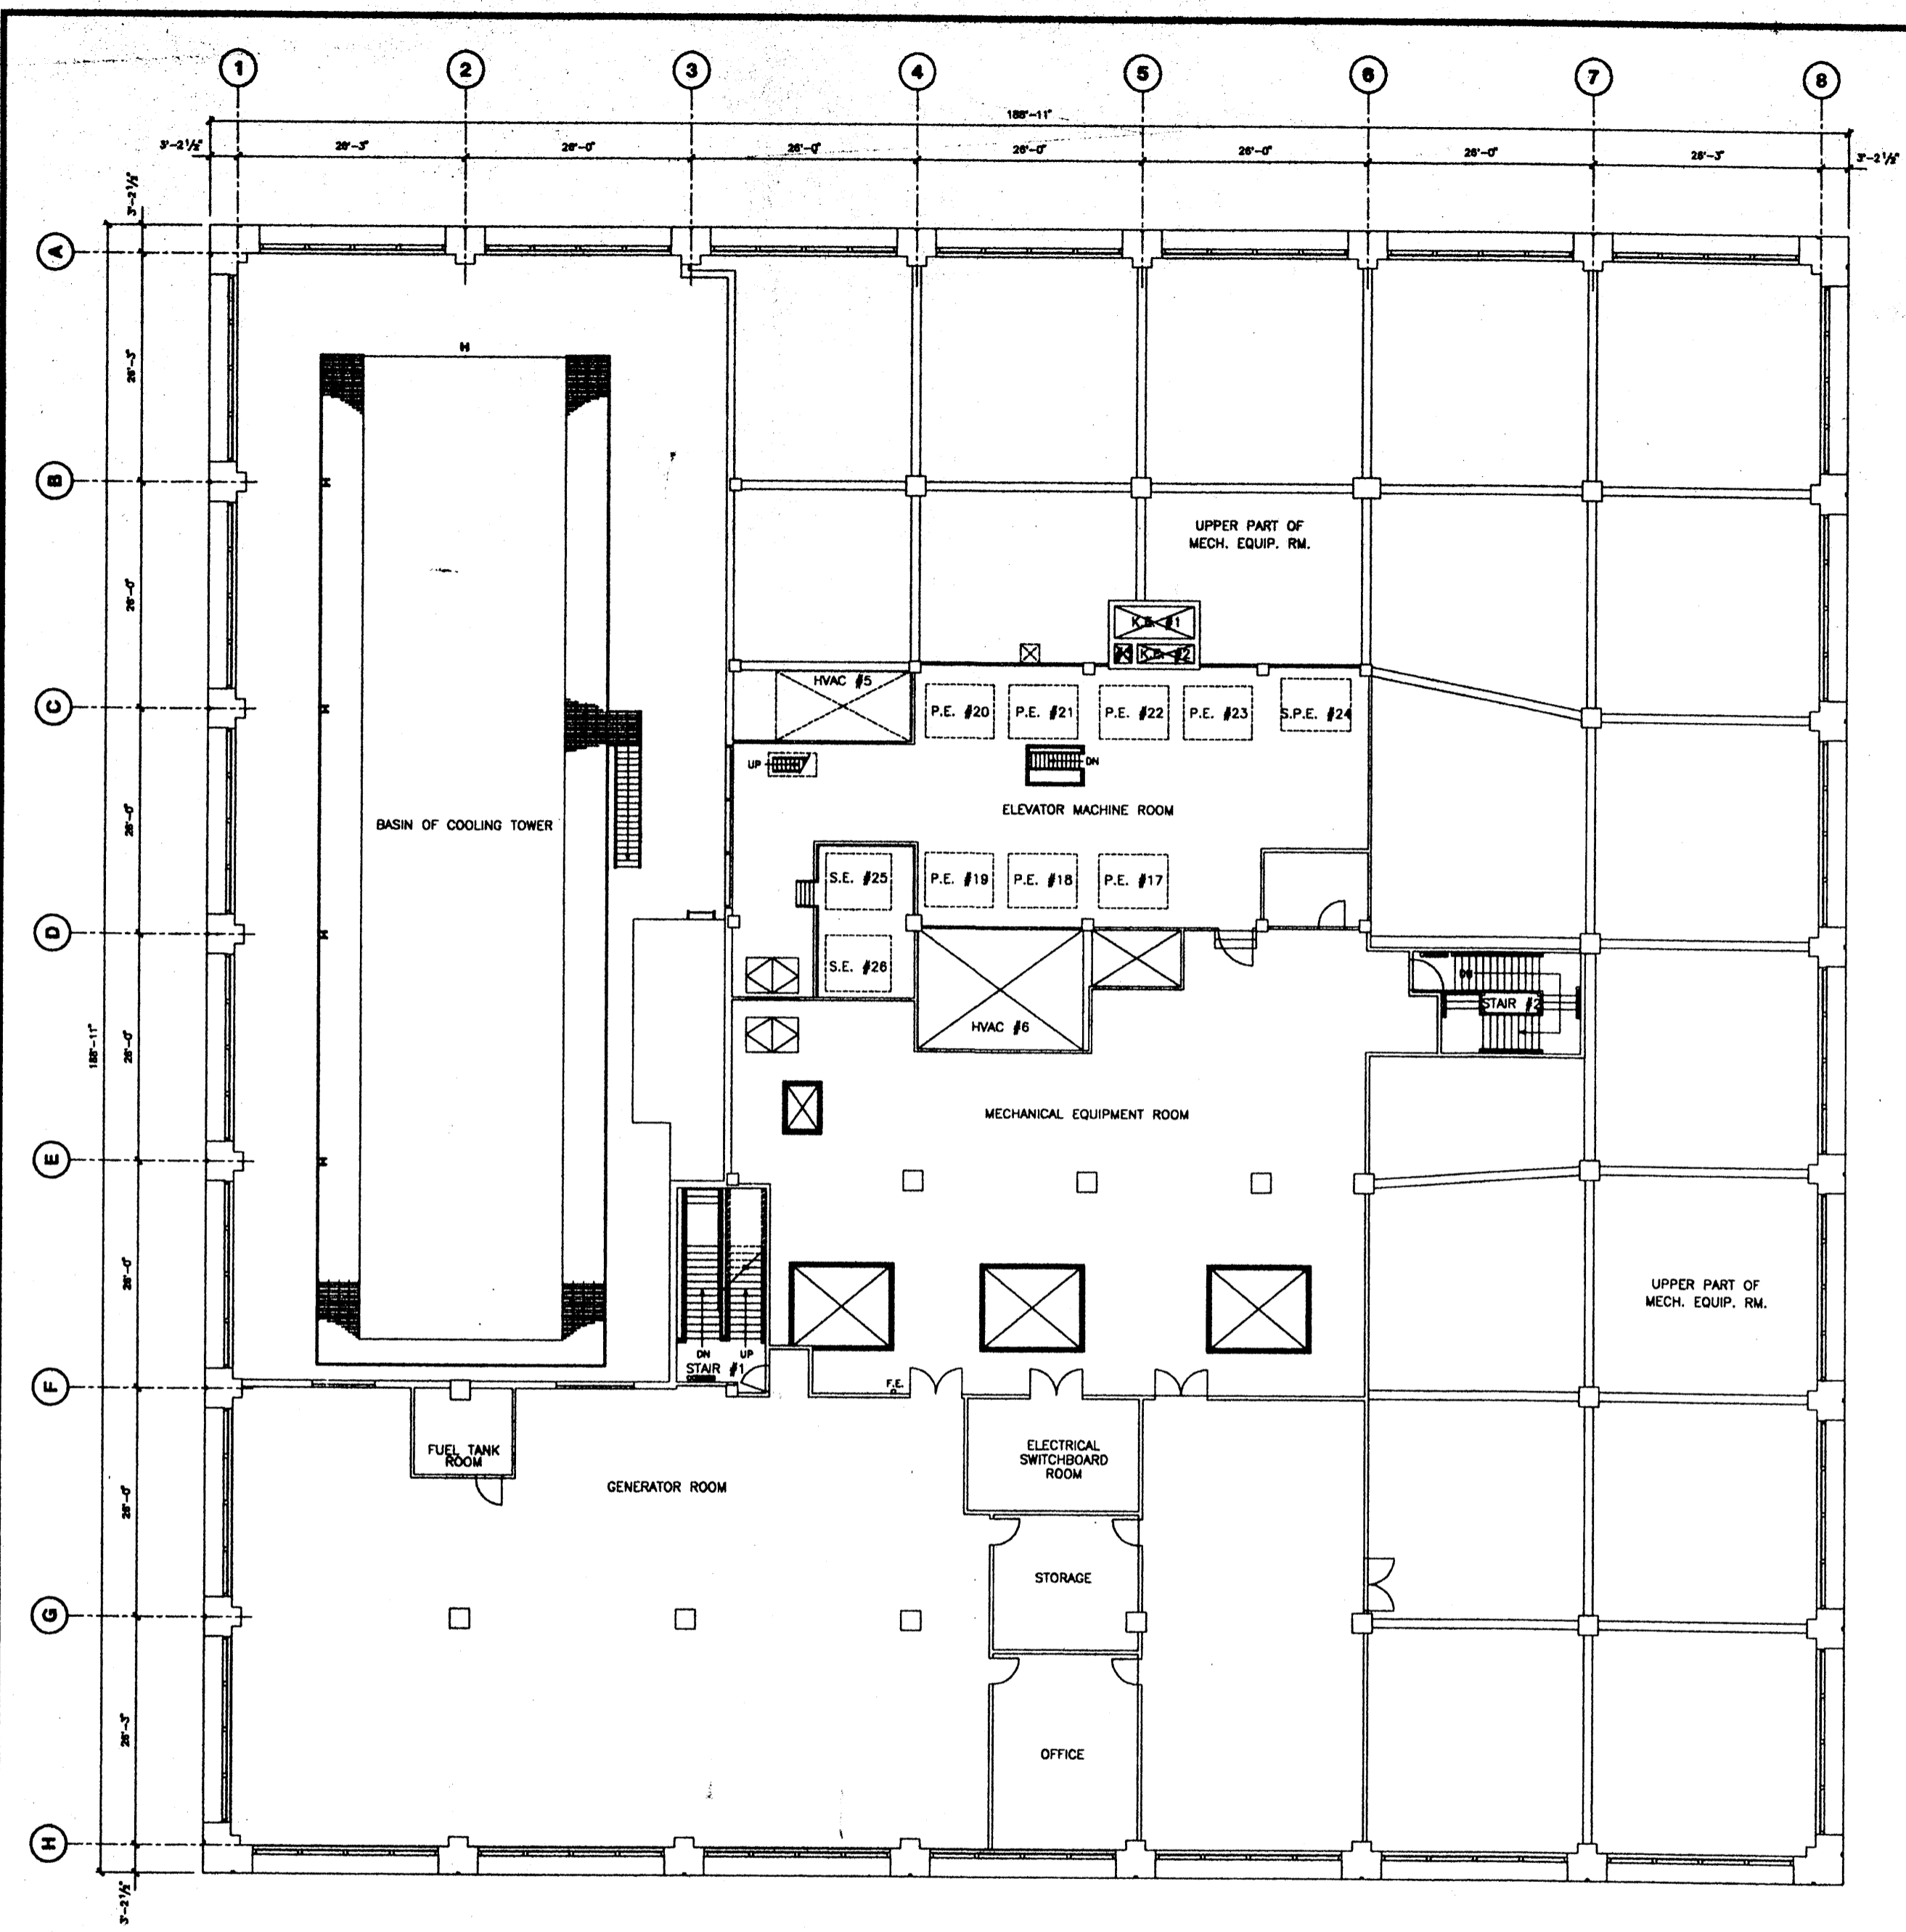

Deutsche Bank


NO.	DATE	REVISION


NO.	DATE	REVISION

PROJECT
130 LIBERTY STREET
 DRAWING
41st FLOOR

Drawn By	Checked By
Date	
1/18/95	
Project No.	




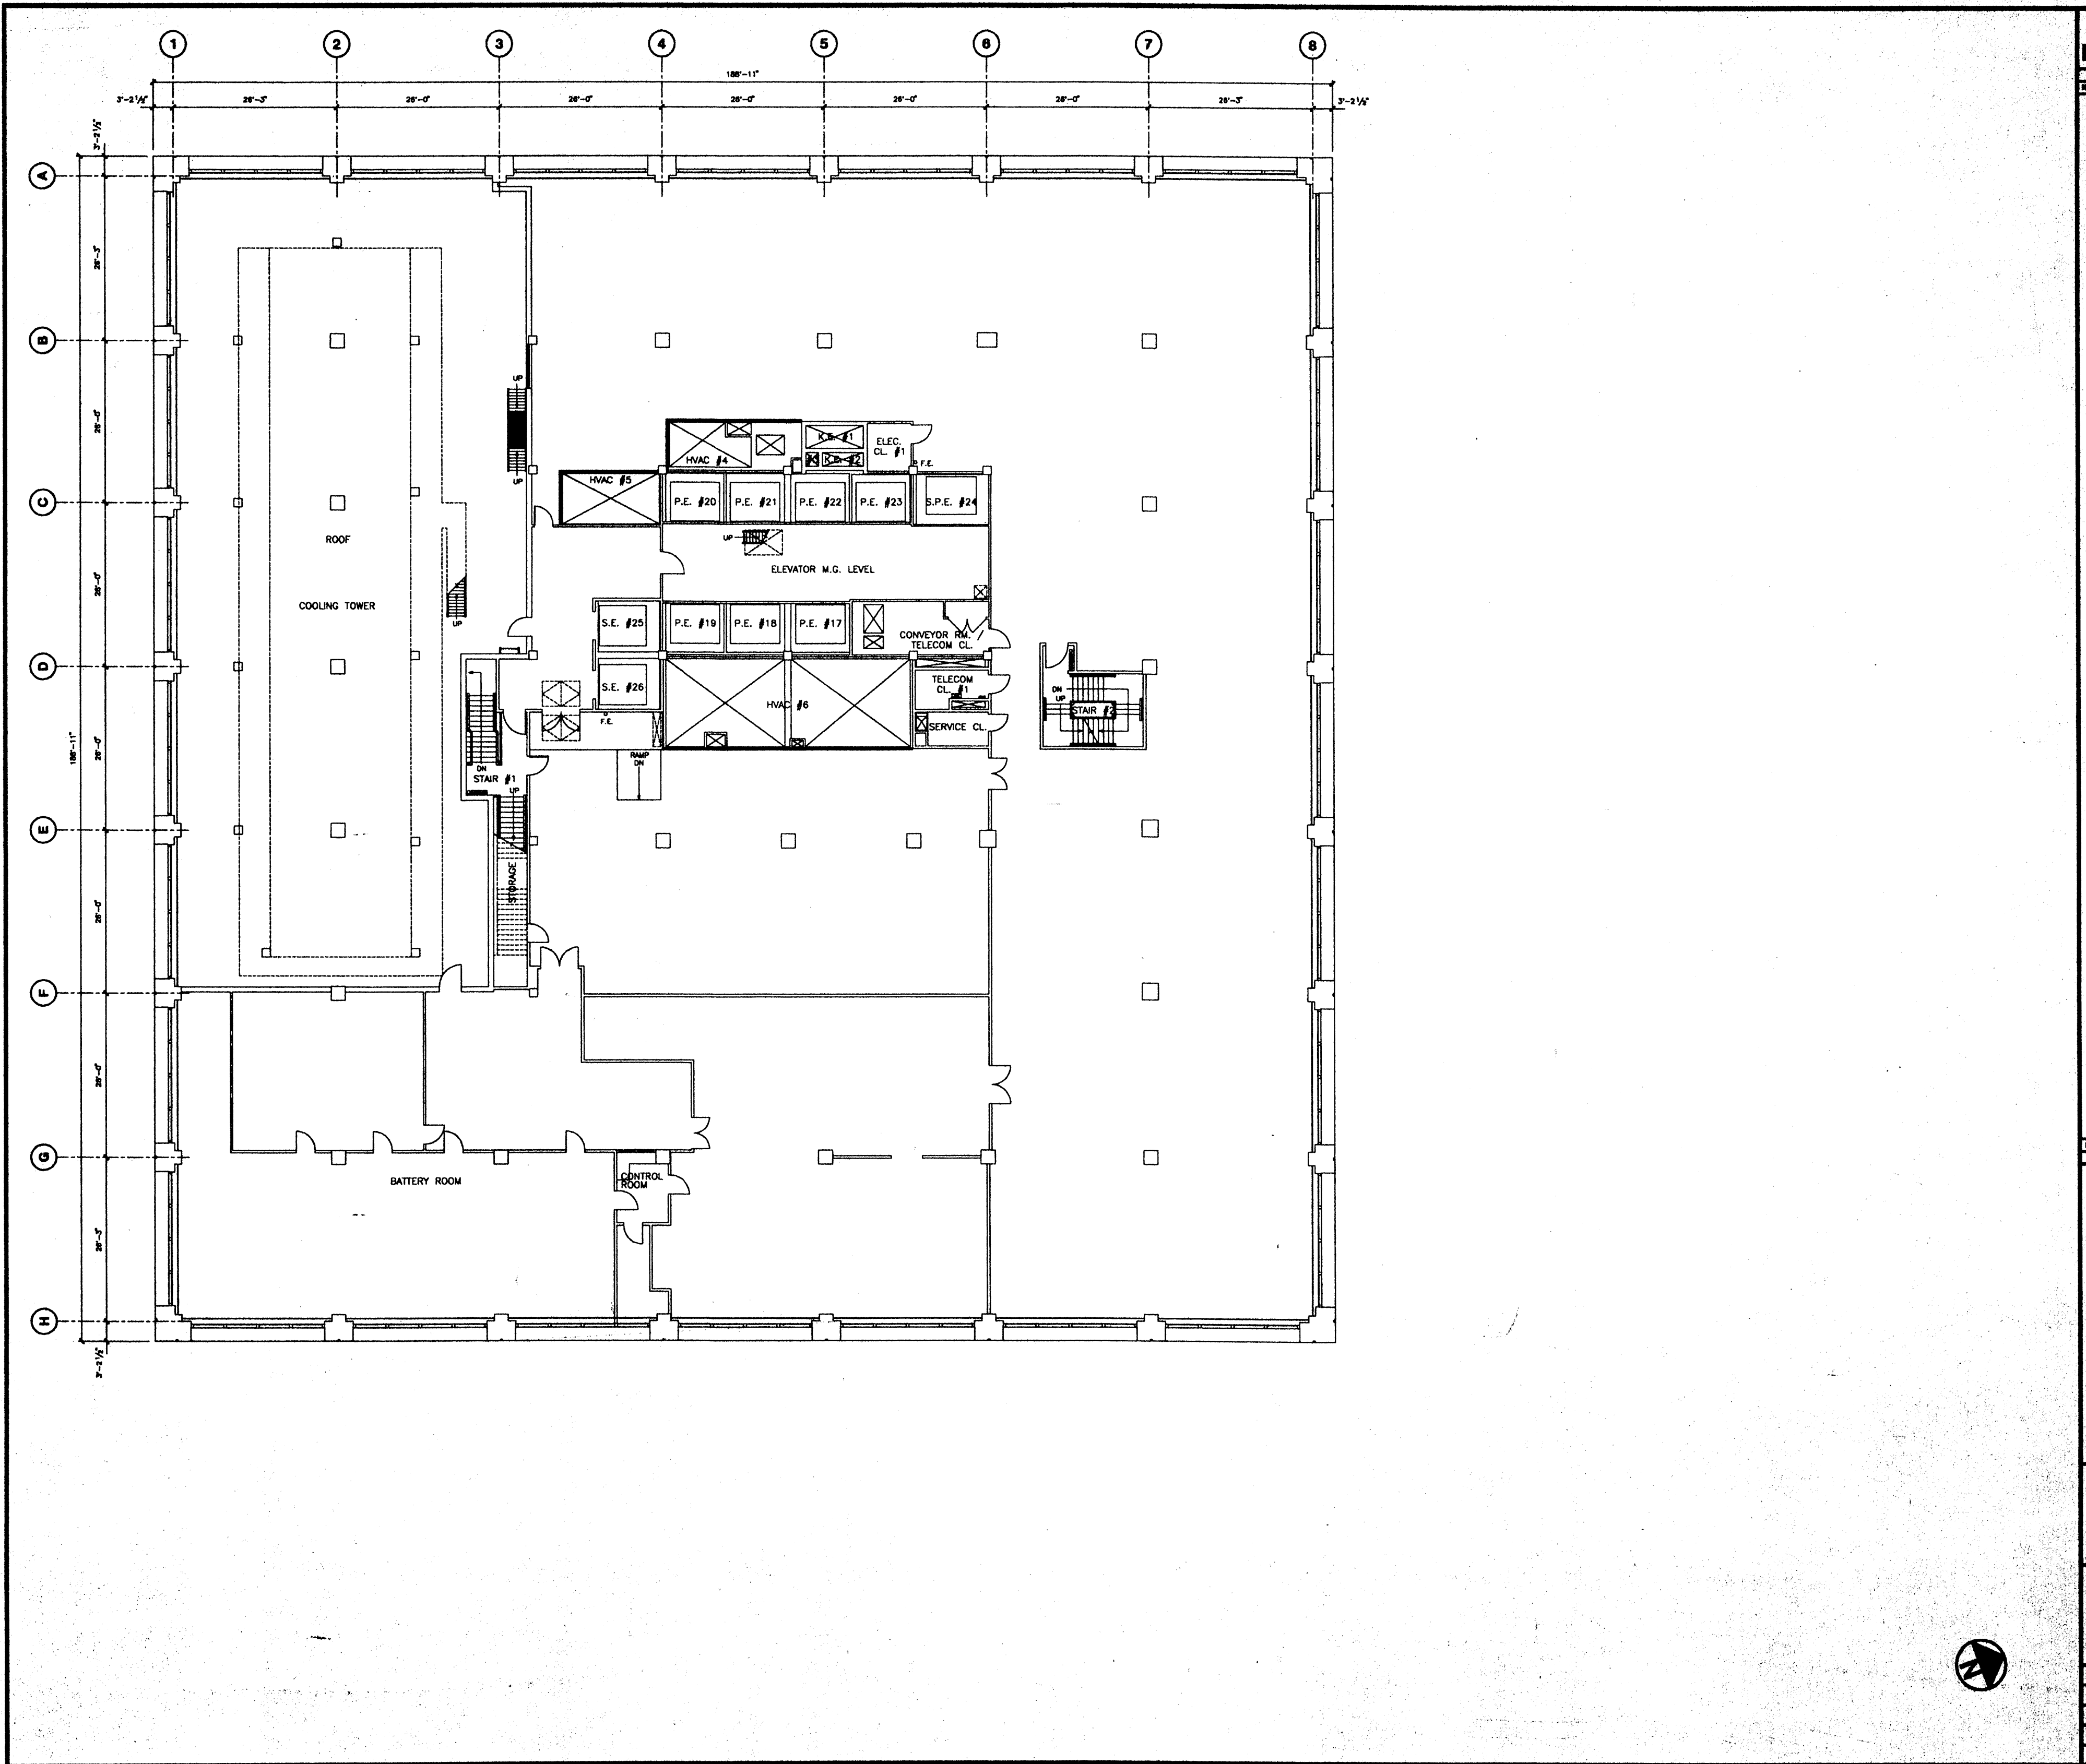

Deutsche Bank 

No.	Date	Revised To
130 LIBERTY STREET		
40th FLOOR		
Drawn By		
Checked By		
Date	1/15/95	
Scale		
Project No.		



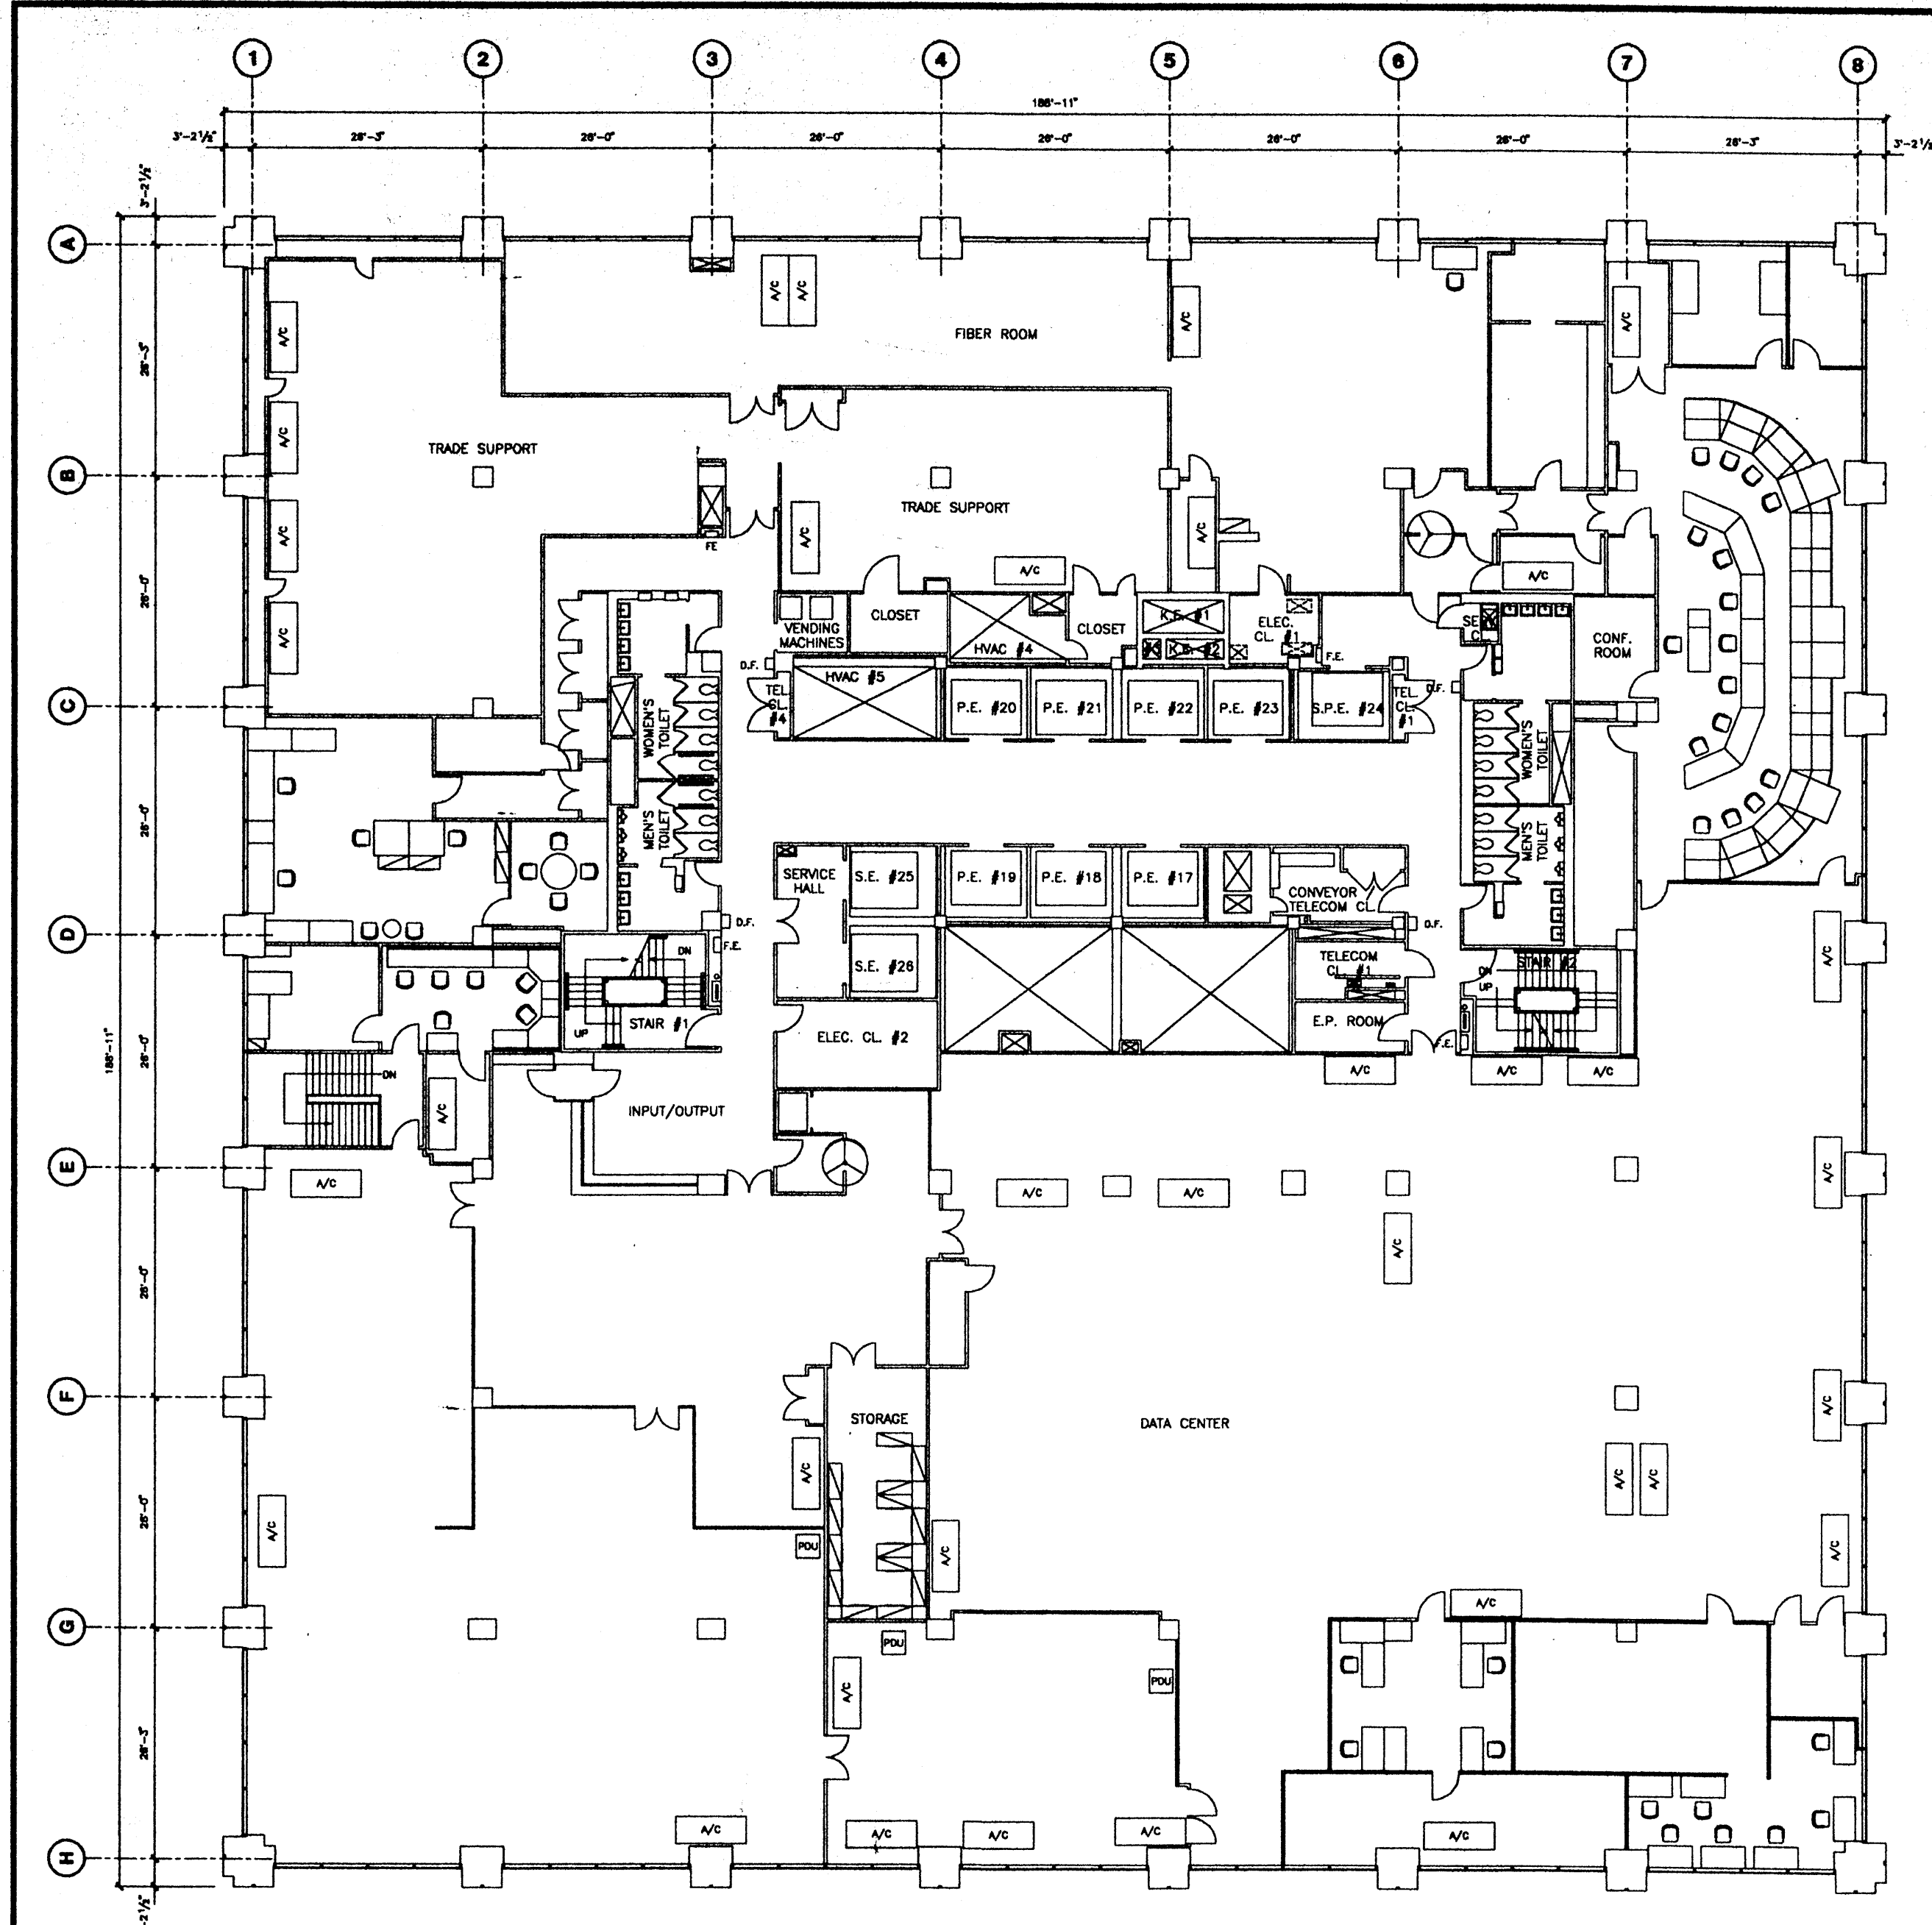

NOTE:
REFER TO CRITICAL SYSTEMS DRAWING BTPCR139
FOR FURNITURE, EQUIPMENT, AND OUTLETS

Deutsche Bank


No.	Date	Description
1	8/1/03	Project #20021011 39th Floor Control Room
2	8/1/04	Project #20021011 39th Floor Control Room
3	8/1/04	Updated for Air Conditioning
4	10/28/04	Updated for New Electrical Plan
5	4/1/07	Project #20021011 39th Floor Control Room
6	7/15/08	Updated for Electrical Control System
7	12/15/08	Updated for Building Information

No.	Date	Revised To

130 LIBERTY STREET
39th FLOOR

Drawn By	
Checked By	
Date	12/15/08
Scale	
Project No.	



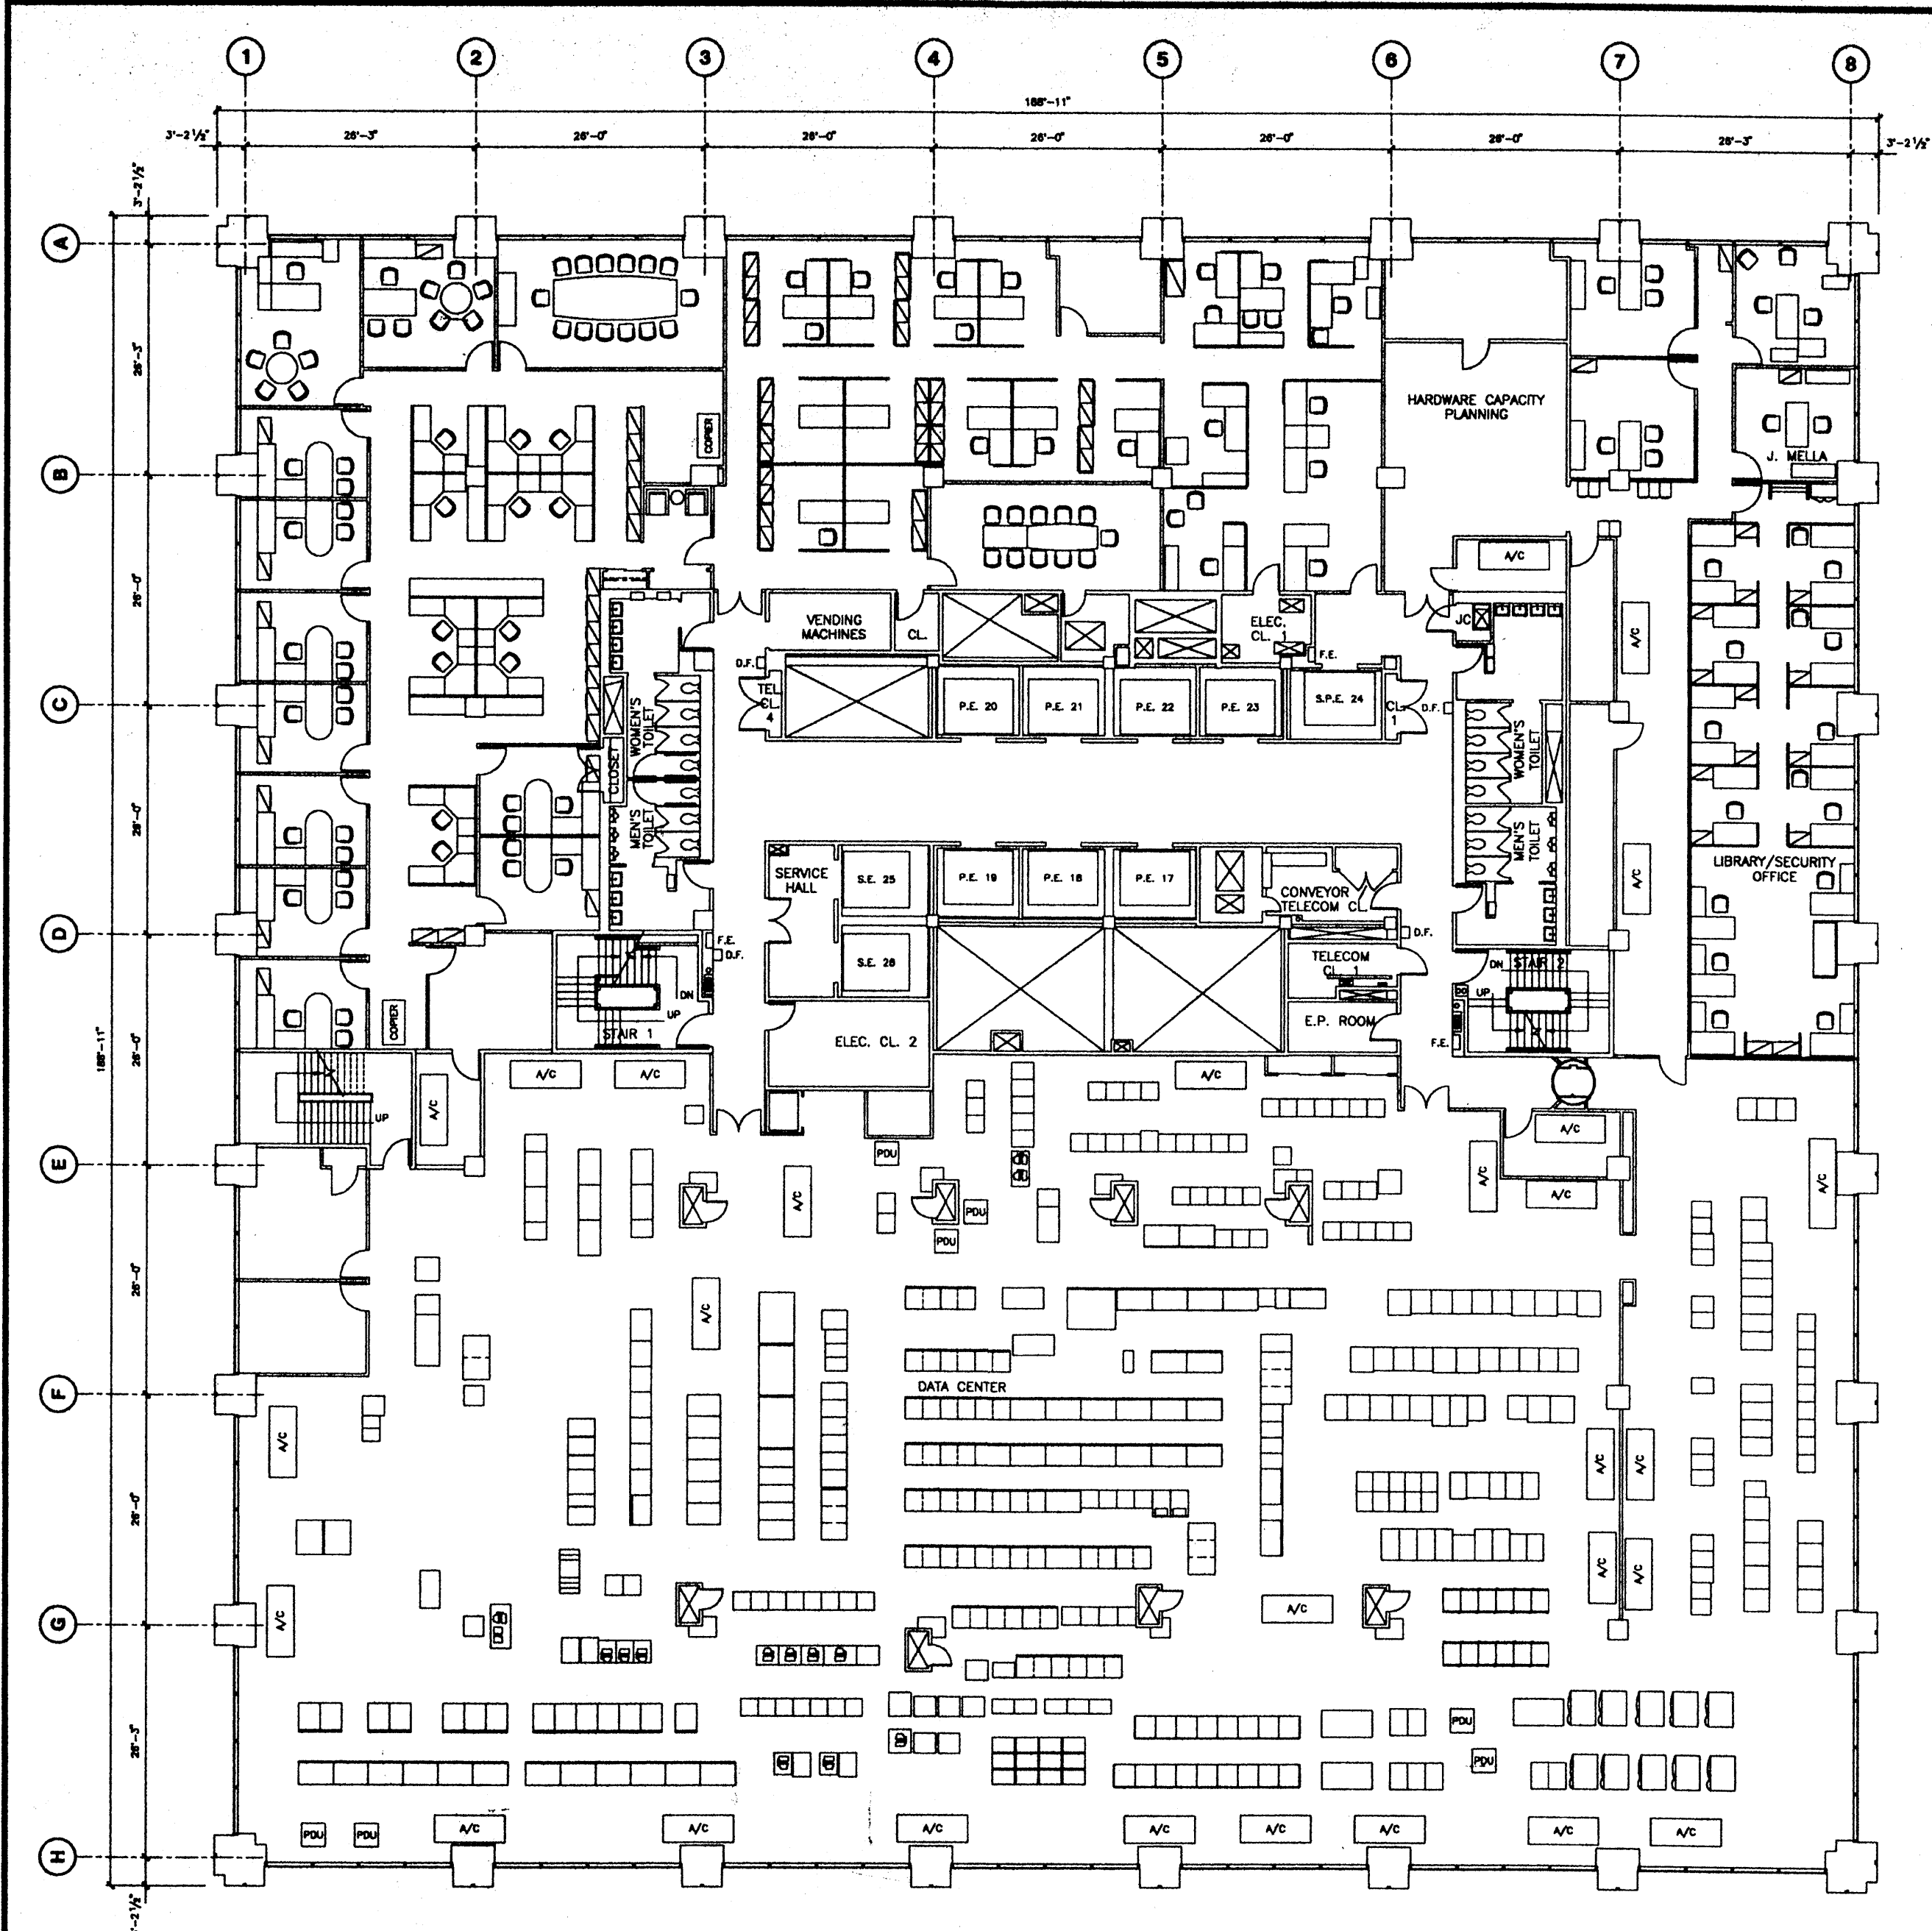

Deutsche Bank

No.	Date	Description
1	2/15/93	Project: 82001678 - Initial Design
2	5/1/93	Updated for Existing Conditions
3	2/1/97	Project: 88000708 - 2000 Renovation
4	7/15/98	Updated for Existing Conditions
5	12/15/98	Updated for Existing Conditions
6	5/1/01	Project: 122000100 - Data Center Changes


No.	Date	Issued To	By

130 LIBERTY STREET

38th FLOOR

Drawn By	
Checked By	
Date	5/1/01
Scale	
Project No.	



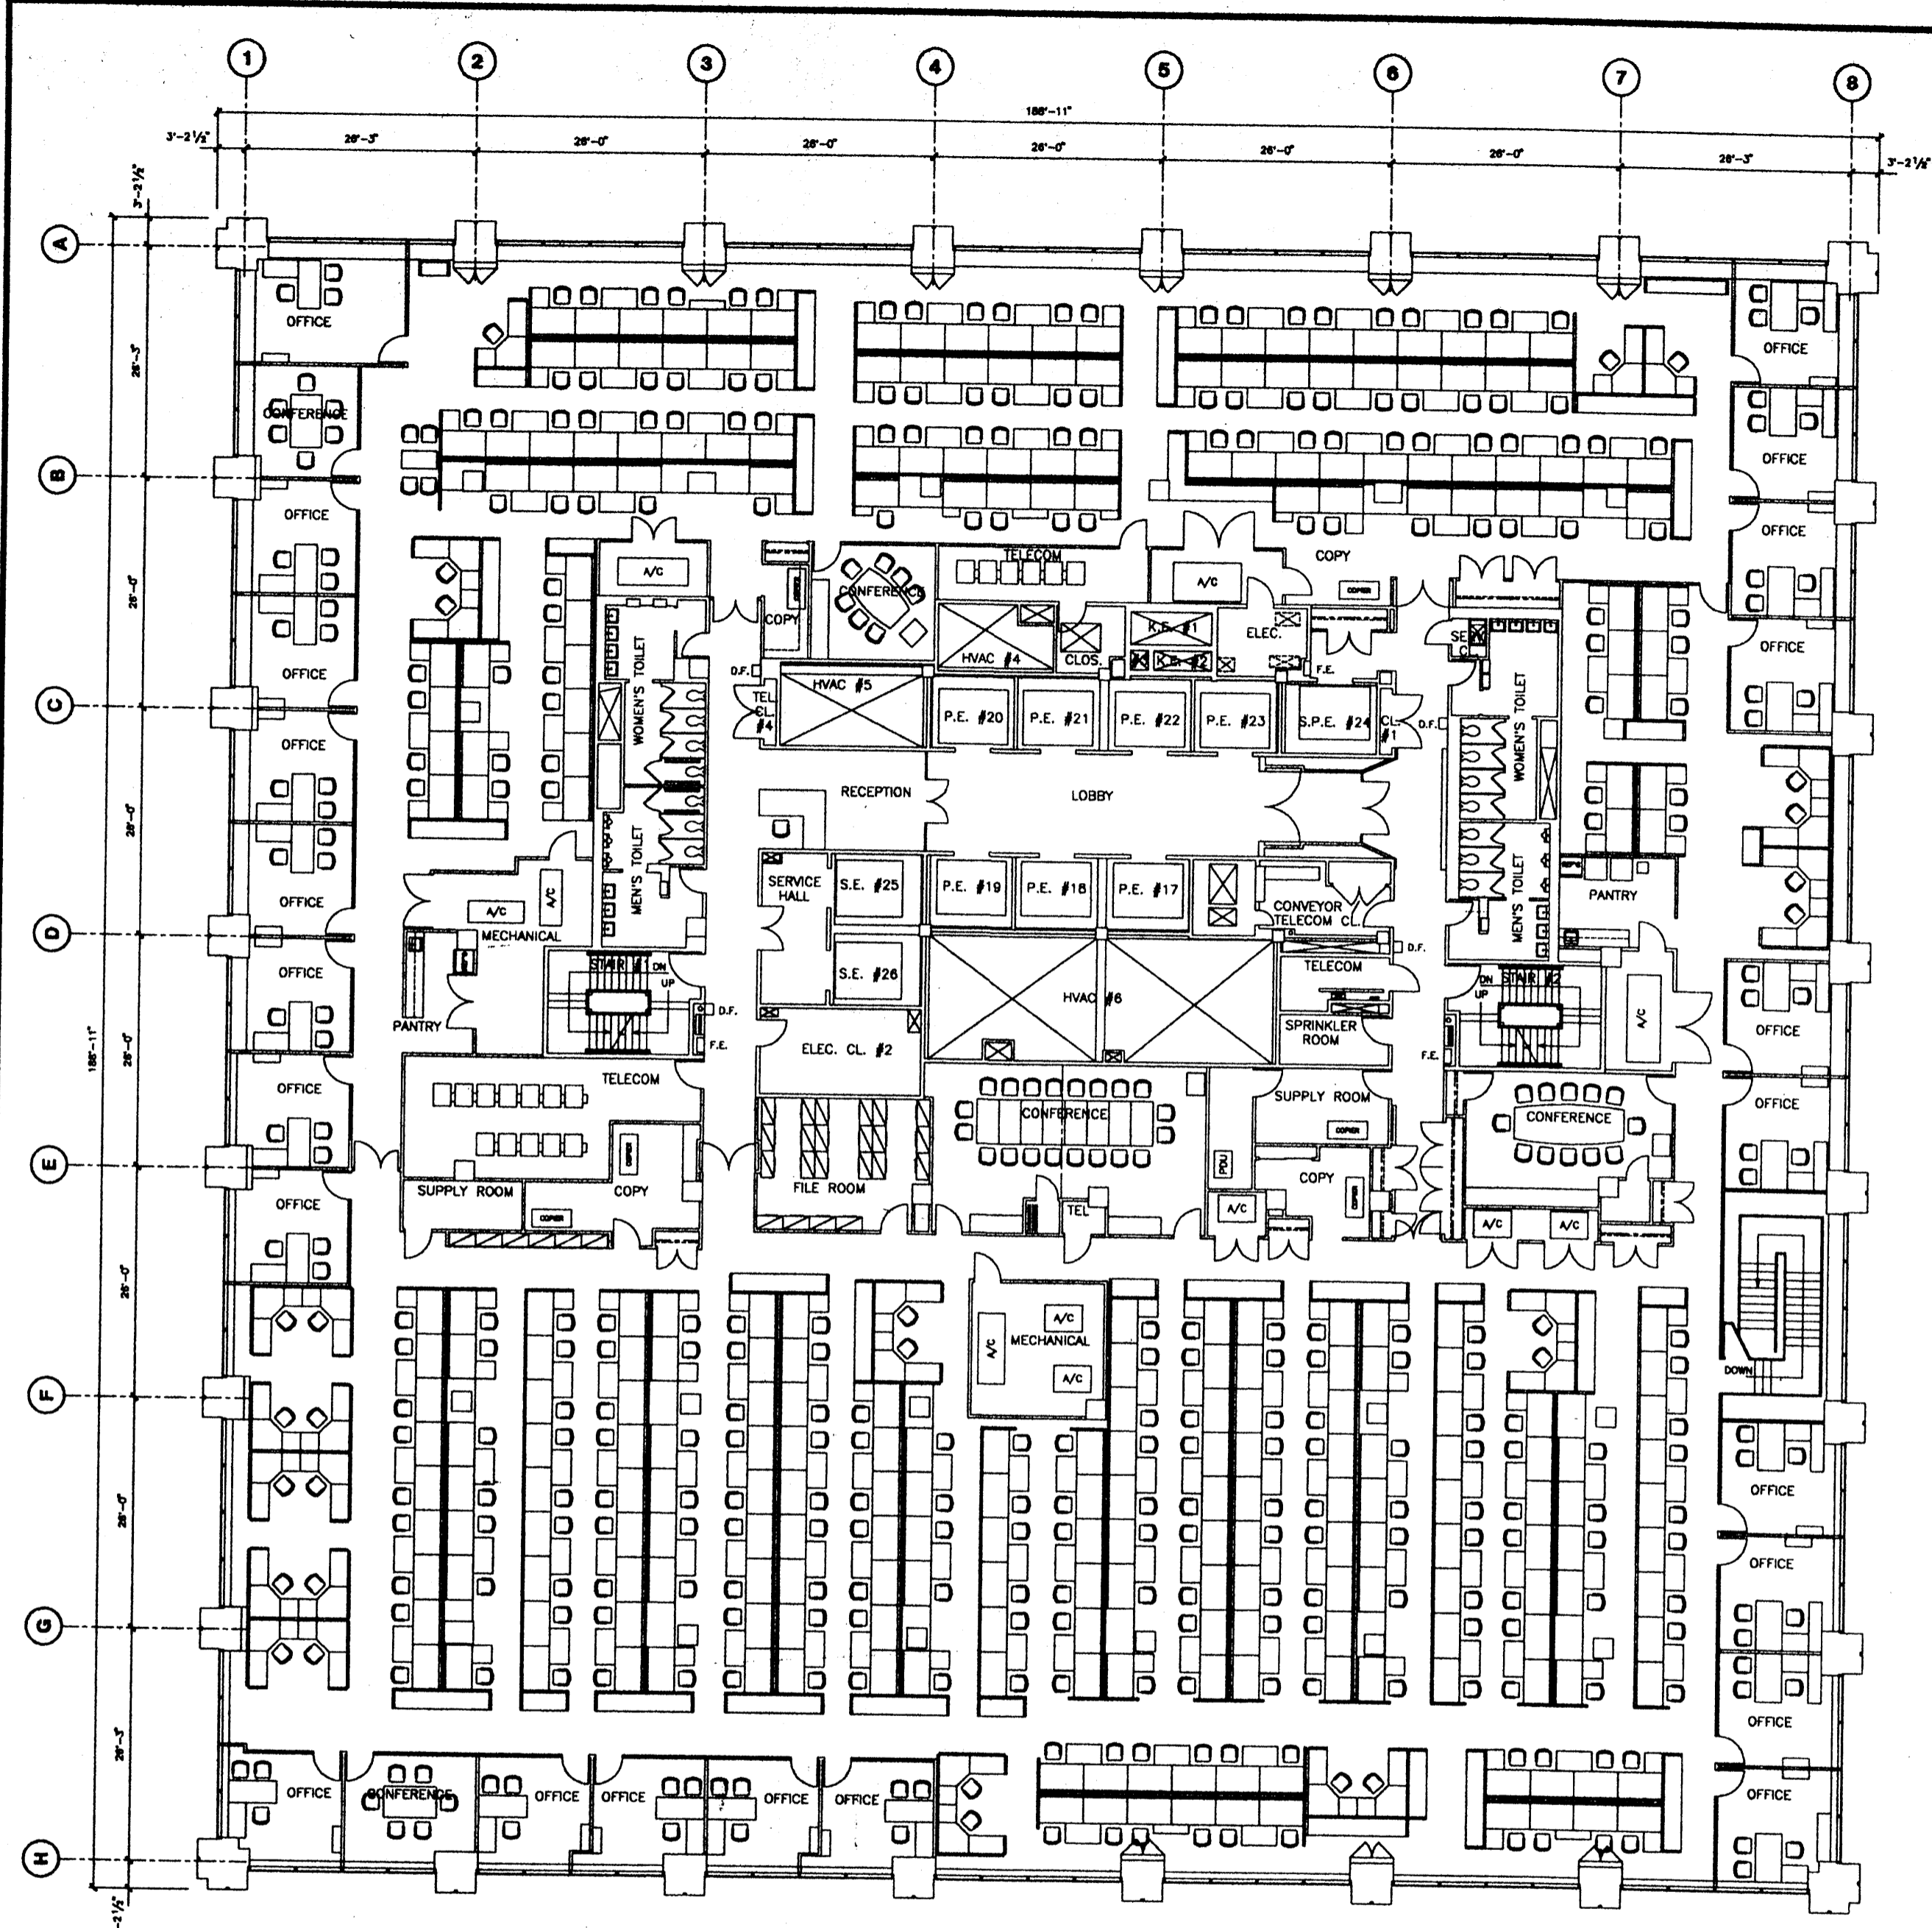

Deutsche Bank


No.	Date	Description
1	10/24/98	Updated for TCM Installation per final Report
2	4/7/98	Project #02002718 - New Trade Building - Latin America Trade
3	5/4/98	Project #02002326 - Trade Floor Expansion & Staff
4	4/18/98	Project #02002113 - Trade Floor Expansion
5	2/1/97	Project #02002729 - Trade Floor Expansion & Staff
6	12/10/97	Project #07001408 - Investment Property Renovation
7	7/15/98	Updated for Deutsche Credit Survey
8	6/16/98	Project #02002378 - BIF Integration

No.	Date	Issued To

130 LIBERTY STREET
37th FLOOR

Drawn By	
Checked By	
Date	9/20/99
Scale	
Project No.	



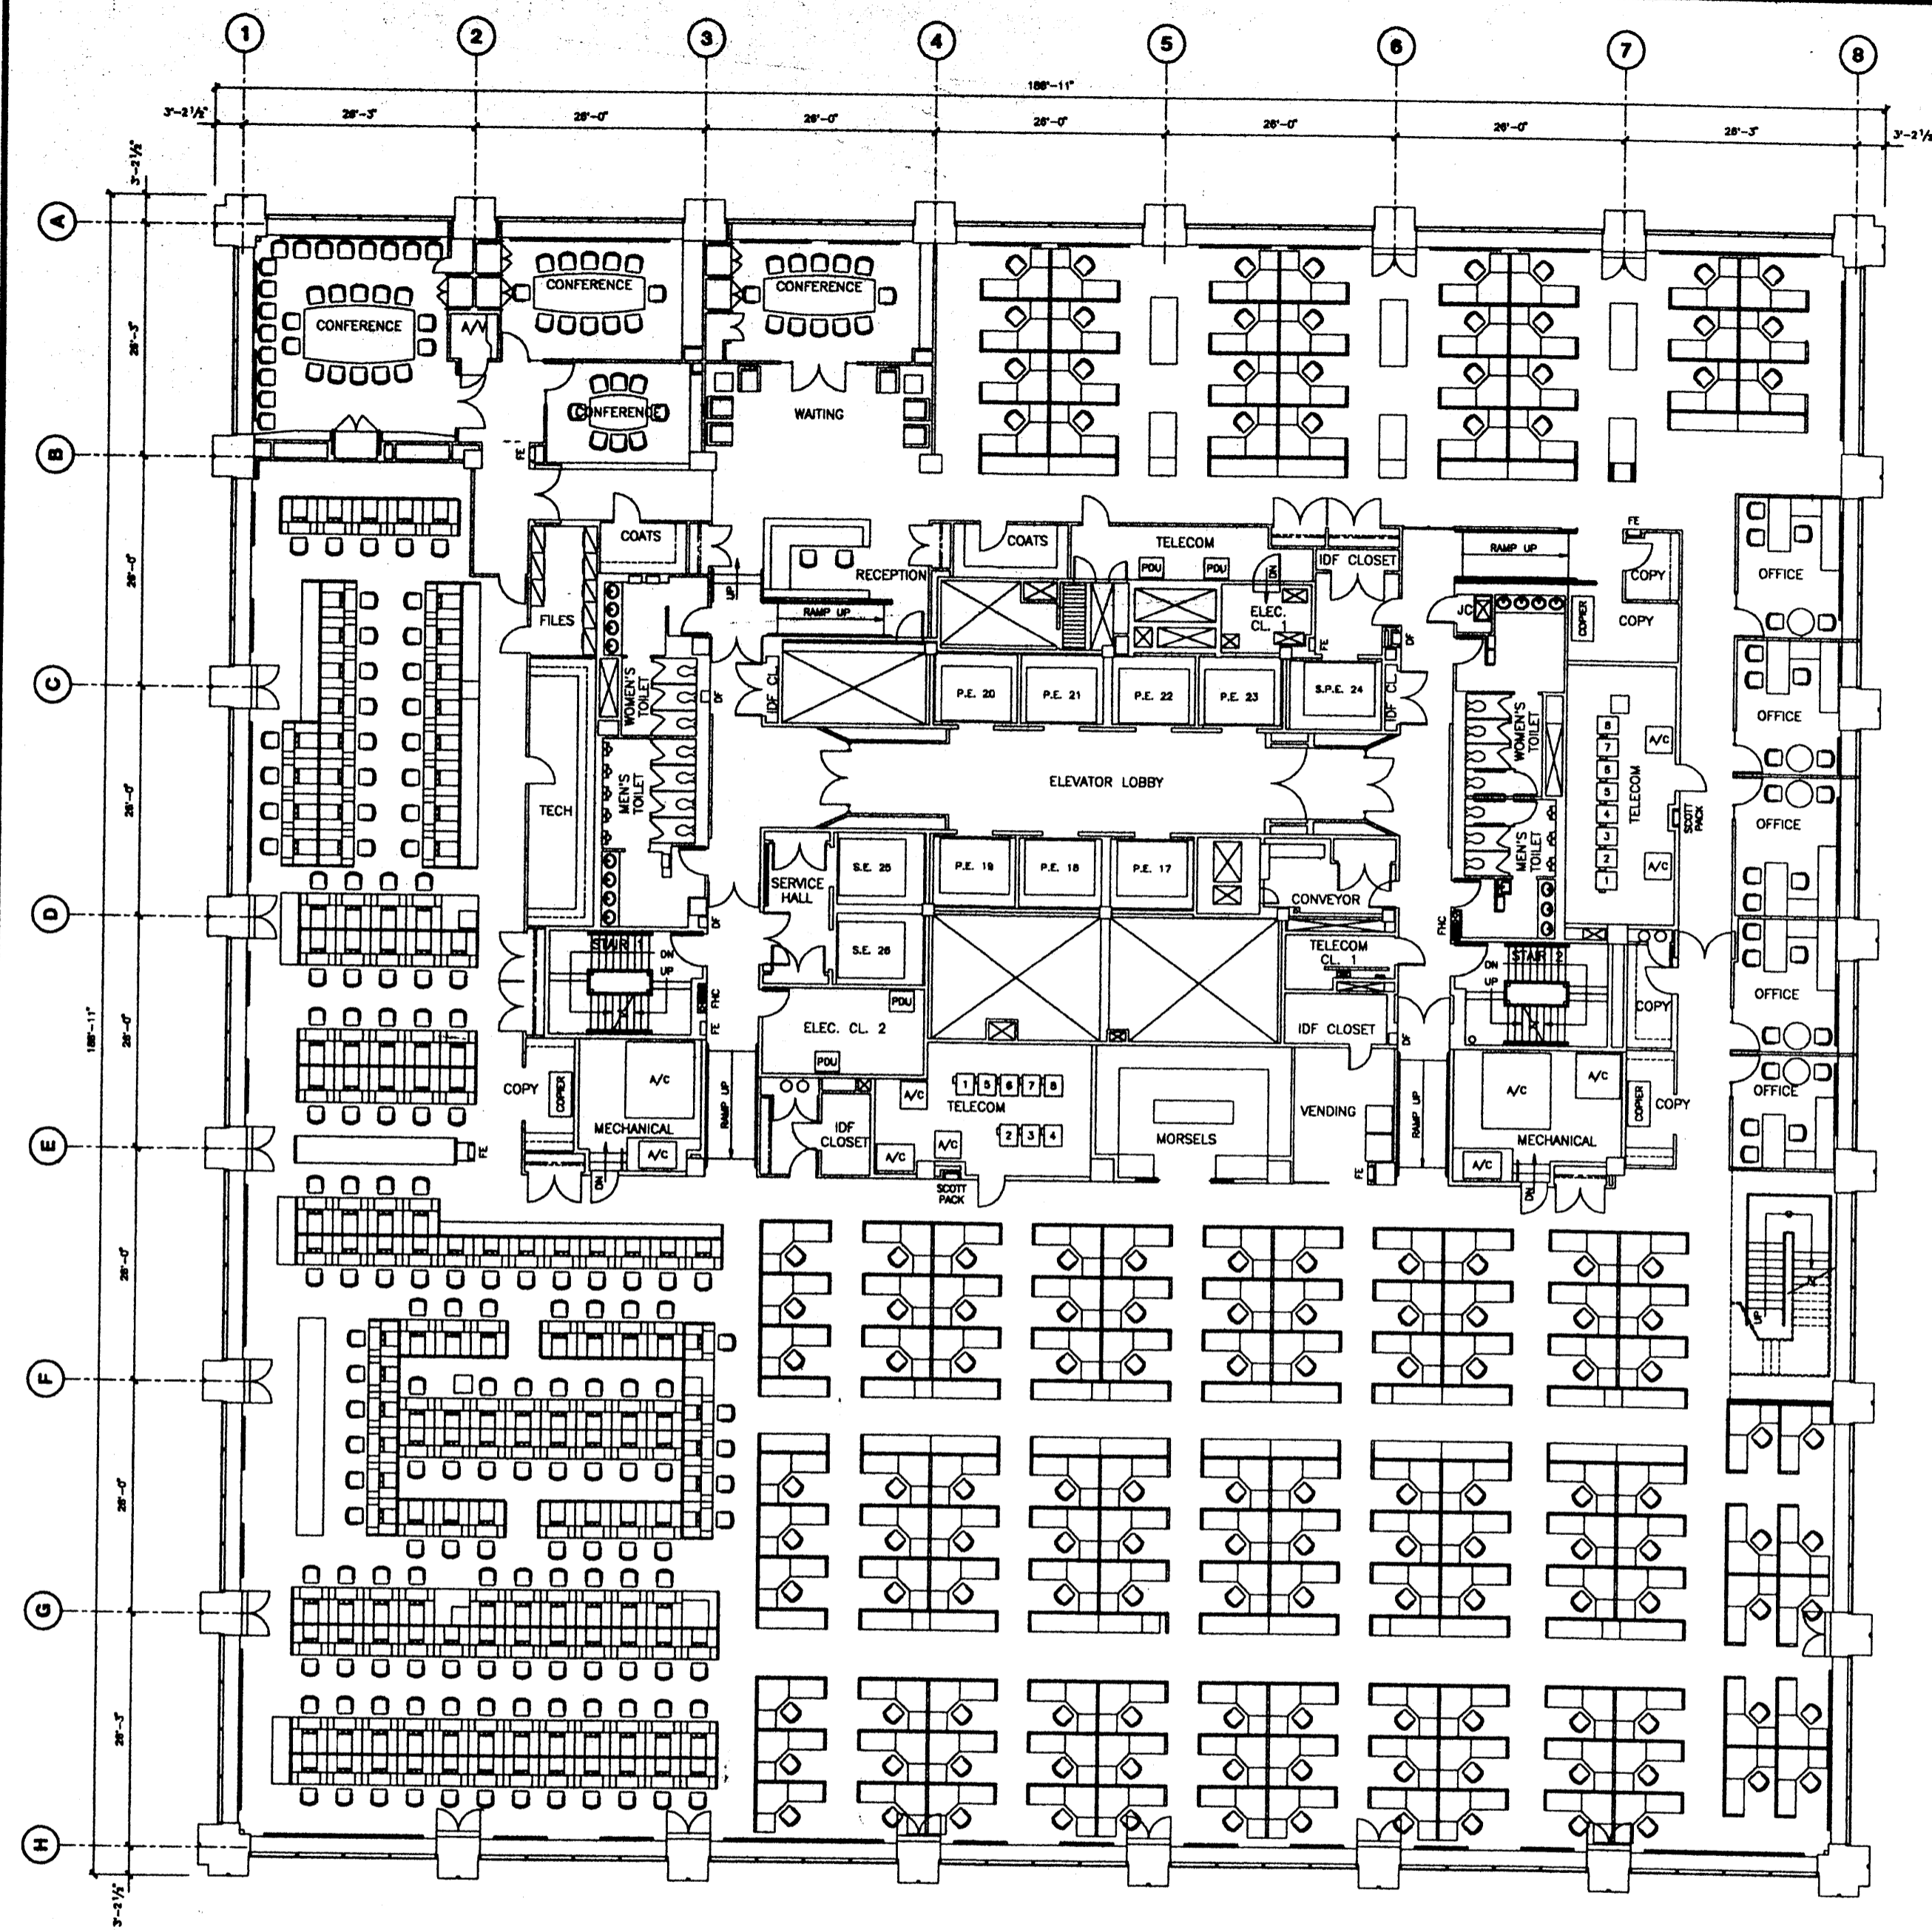

Deutsche Bank

No.	Date	Description
1	4/15/98	Revised Interior Specifications
2	2/1/97	Project 980022222 - 100 Trading Floor & Hall
3	12/9/97	Project 97001382 - 10 New
4	7/15/98	Updated for Deutsche Bank
5	8/27/01	Project 182846101 - Asset Management


No.	Date	Revised To

130 LIBERTY STREET

36th FLOOR

Drawn By	Checked By
Date	8/27/01
Project No.	



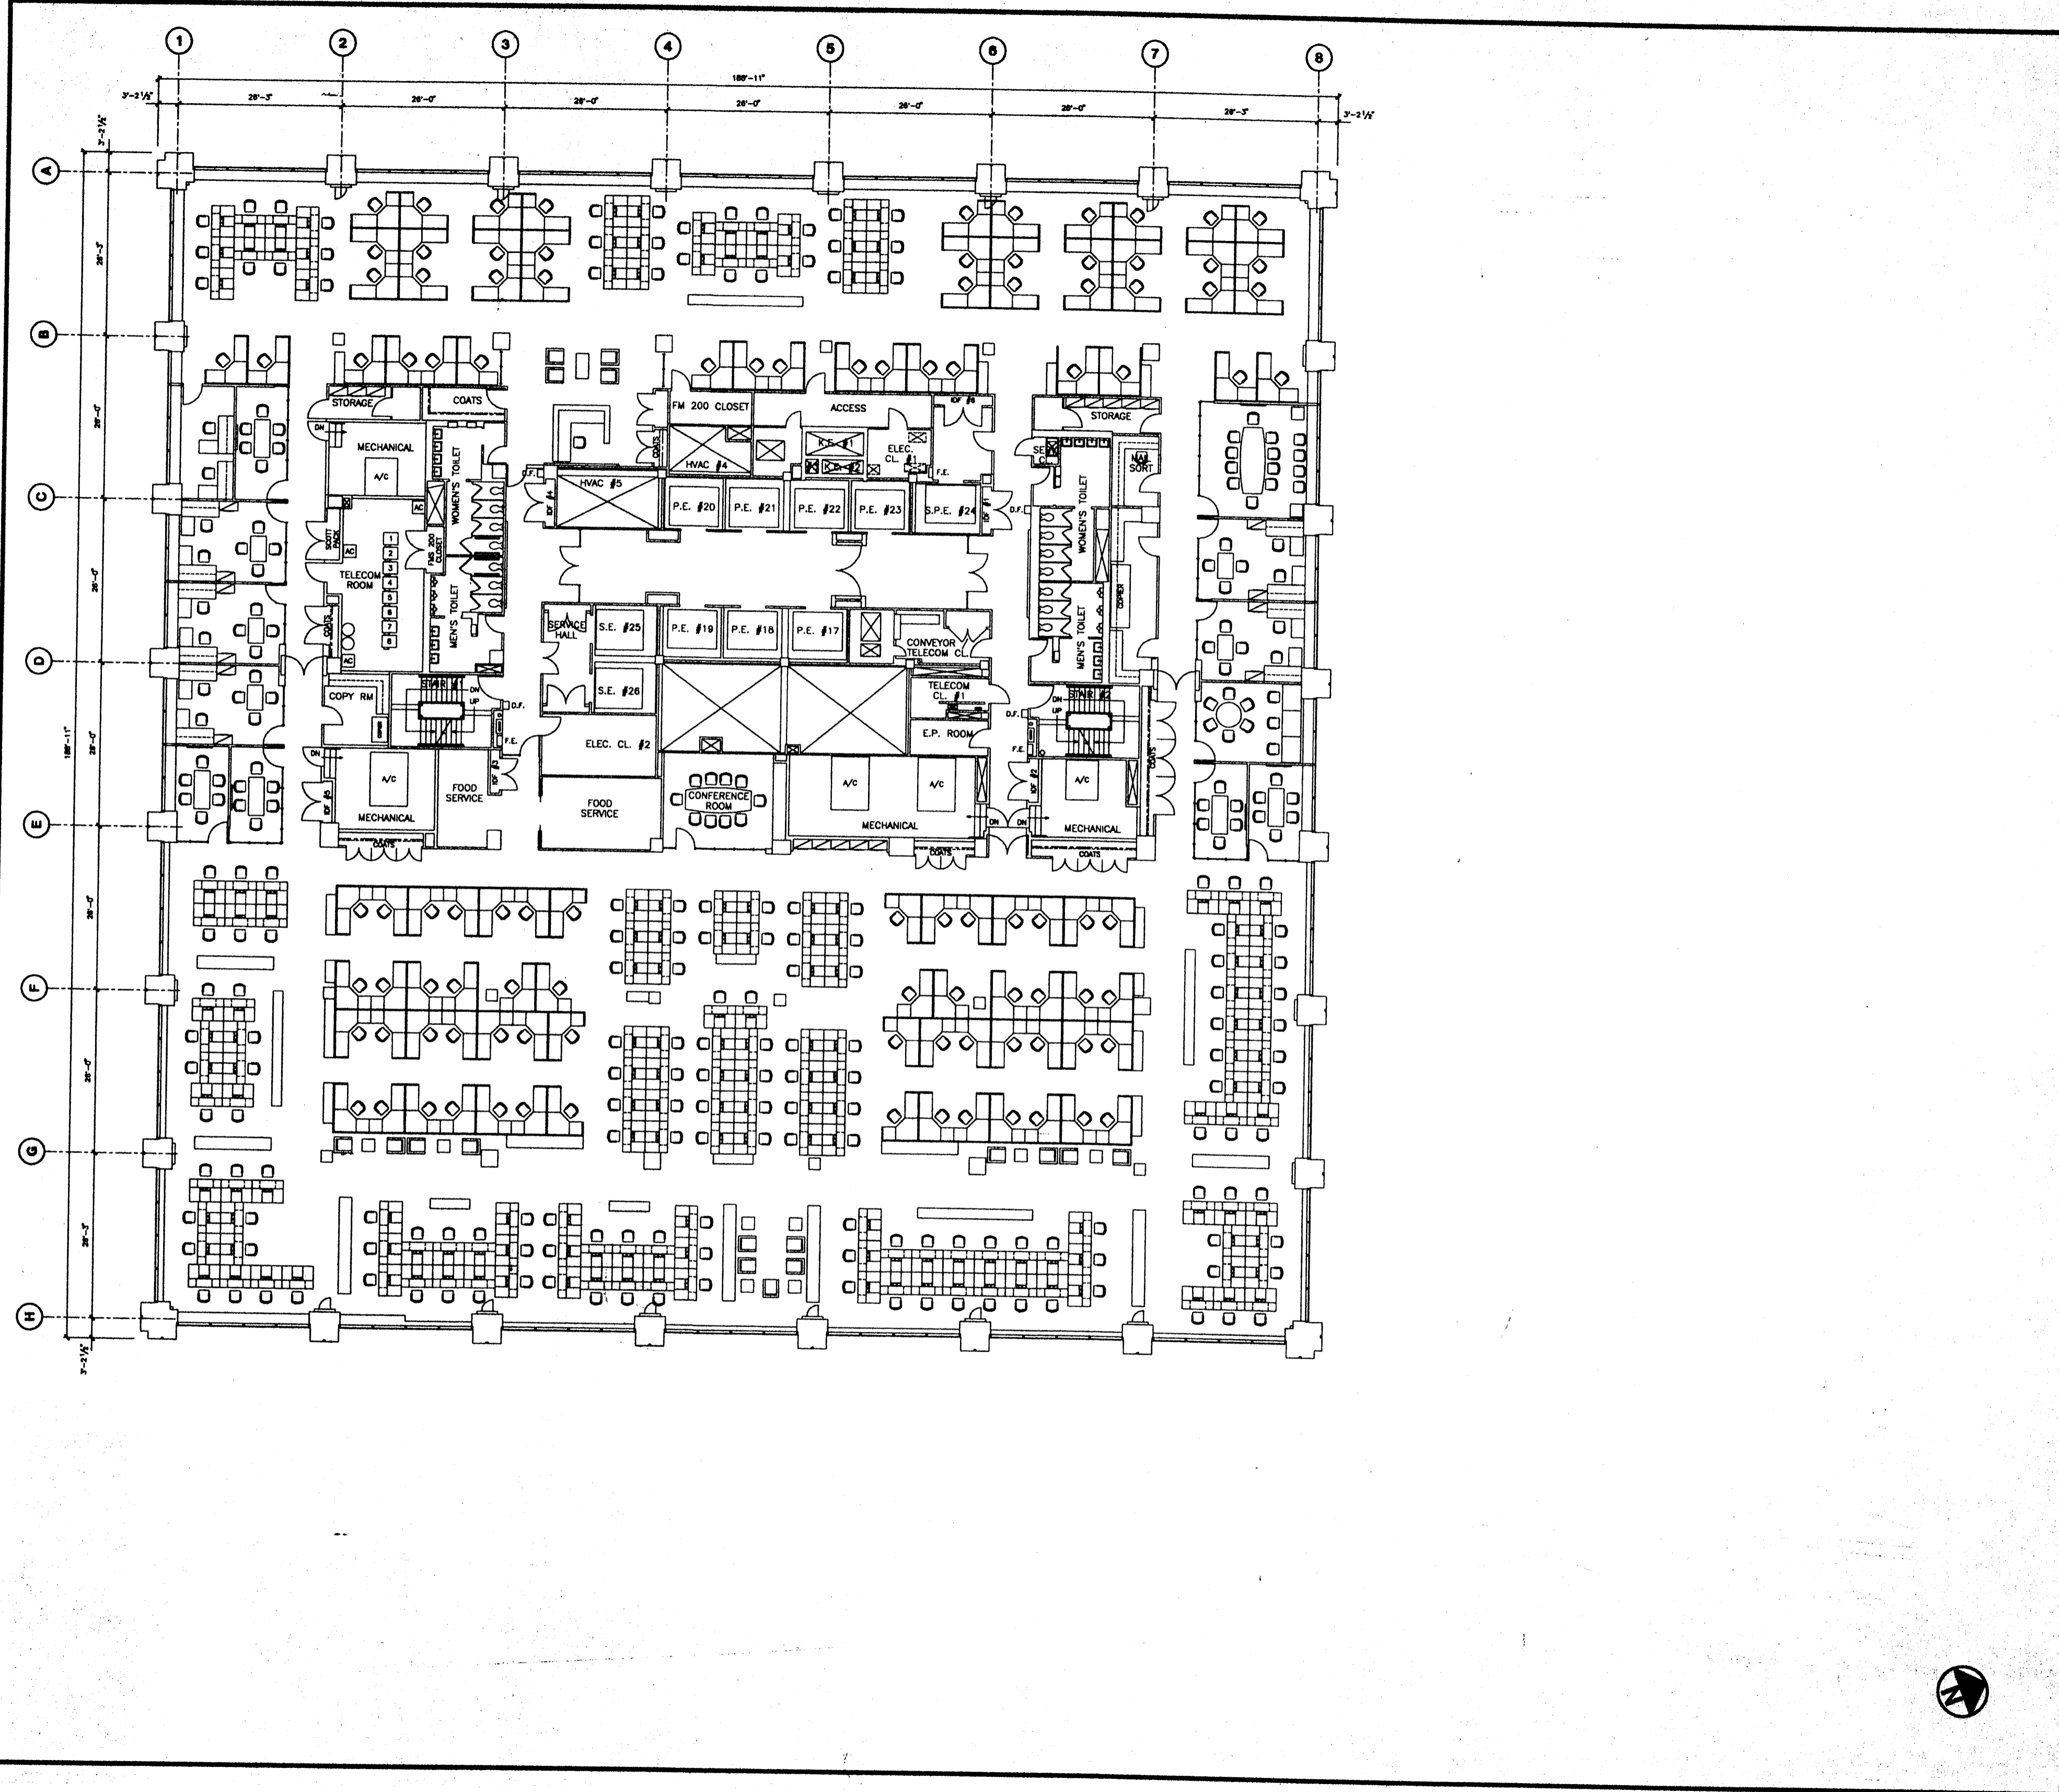

Deutsche Bank


No.	Date	Description
1	9/1/83	Project #80021430 - 608 Check Processing
2	4/1/84	Project #80021430 - 608 Check Processing
3	7/15/88	Updated for Check Desk Service

No.	Date	Issued To

130 LIBERTY STREET
35th FLOOR



Drawn By	
Checked By	
Date	7/15/88
Scale	
Project No.	

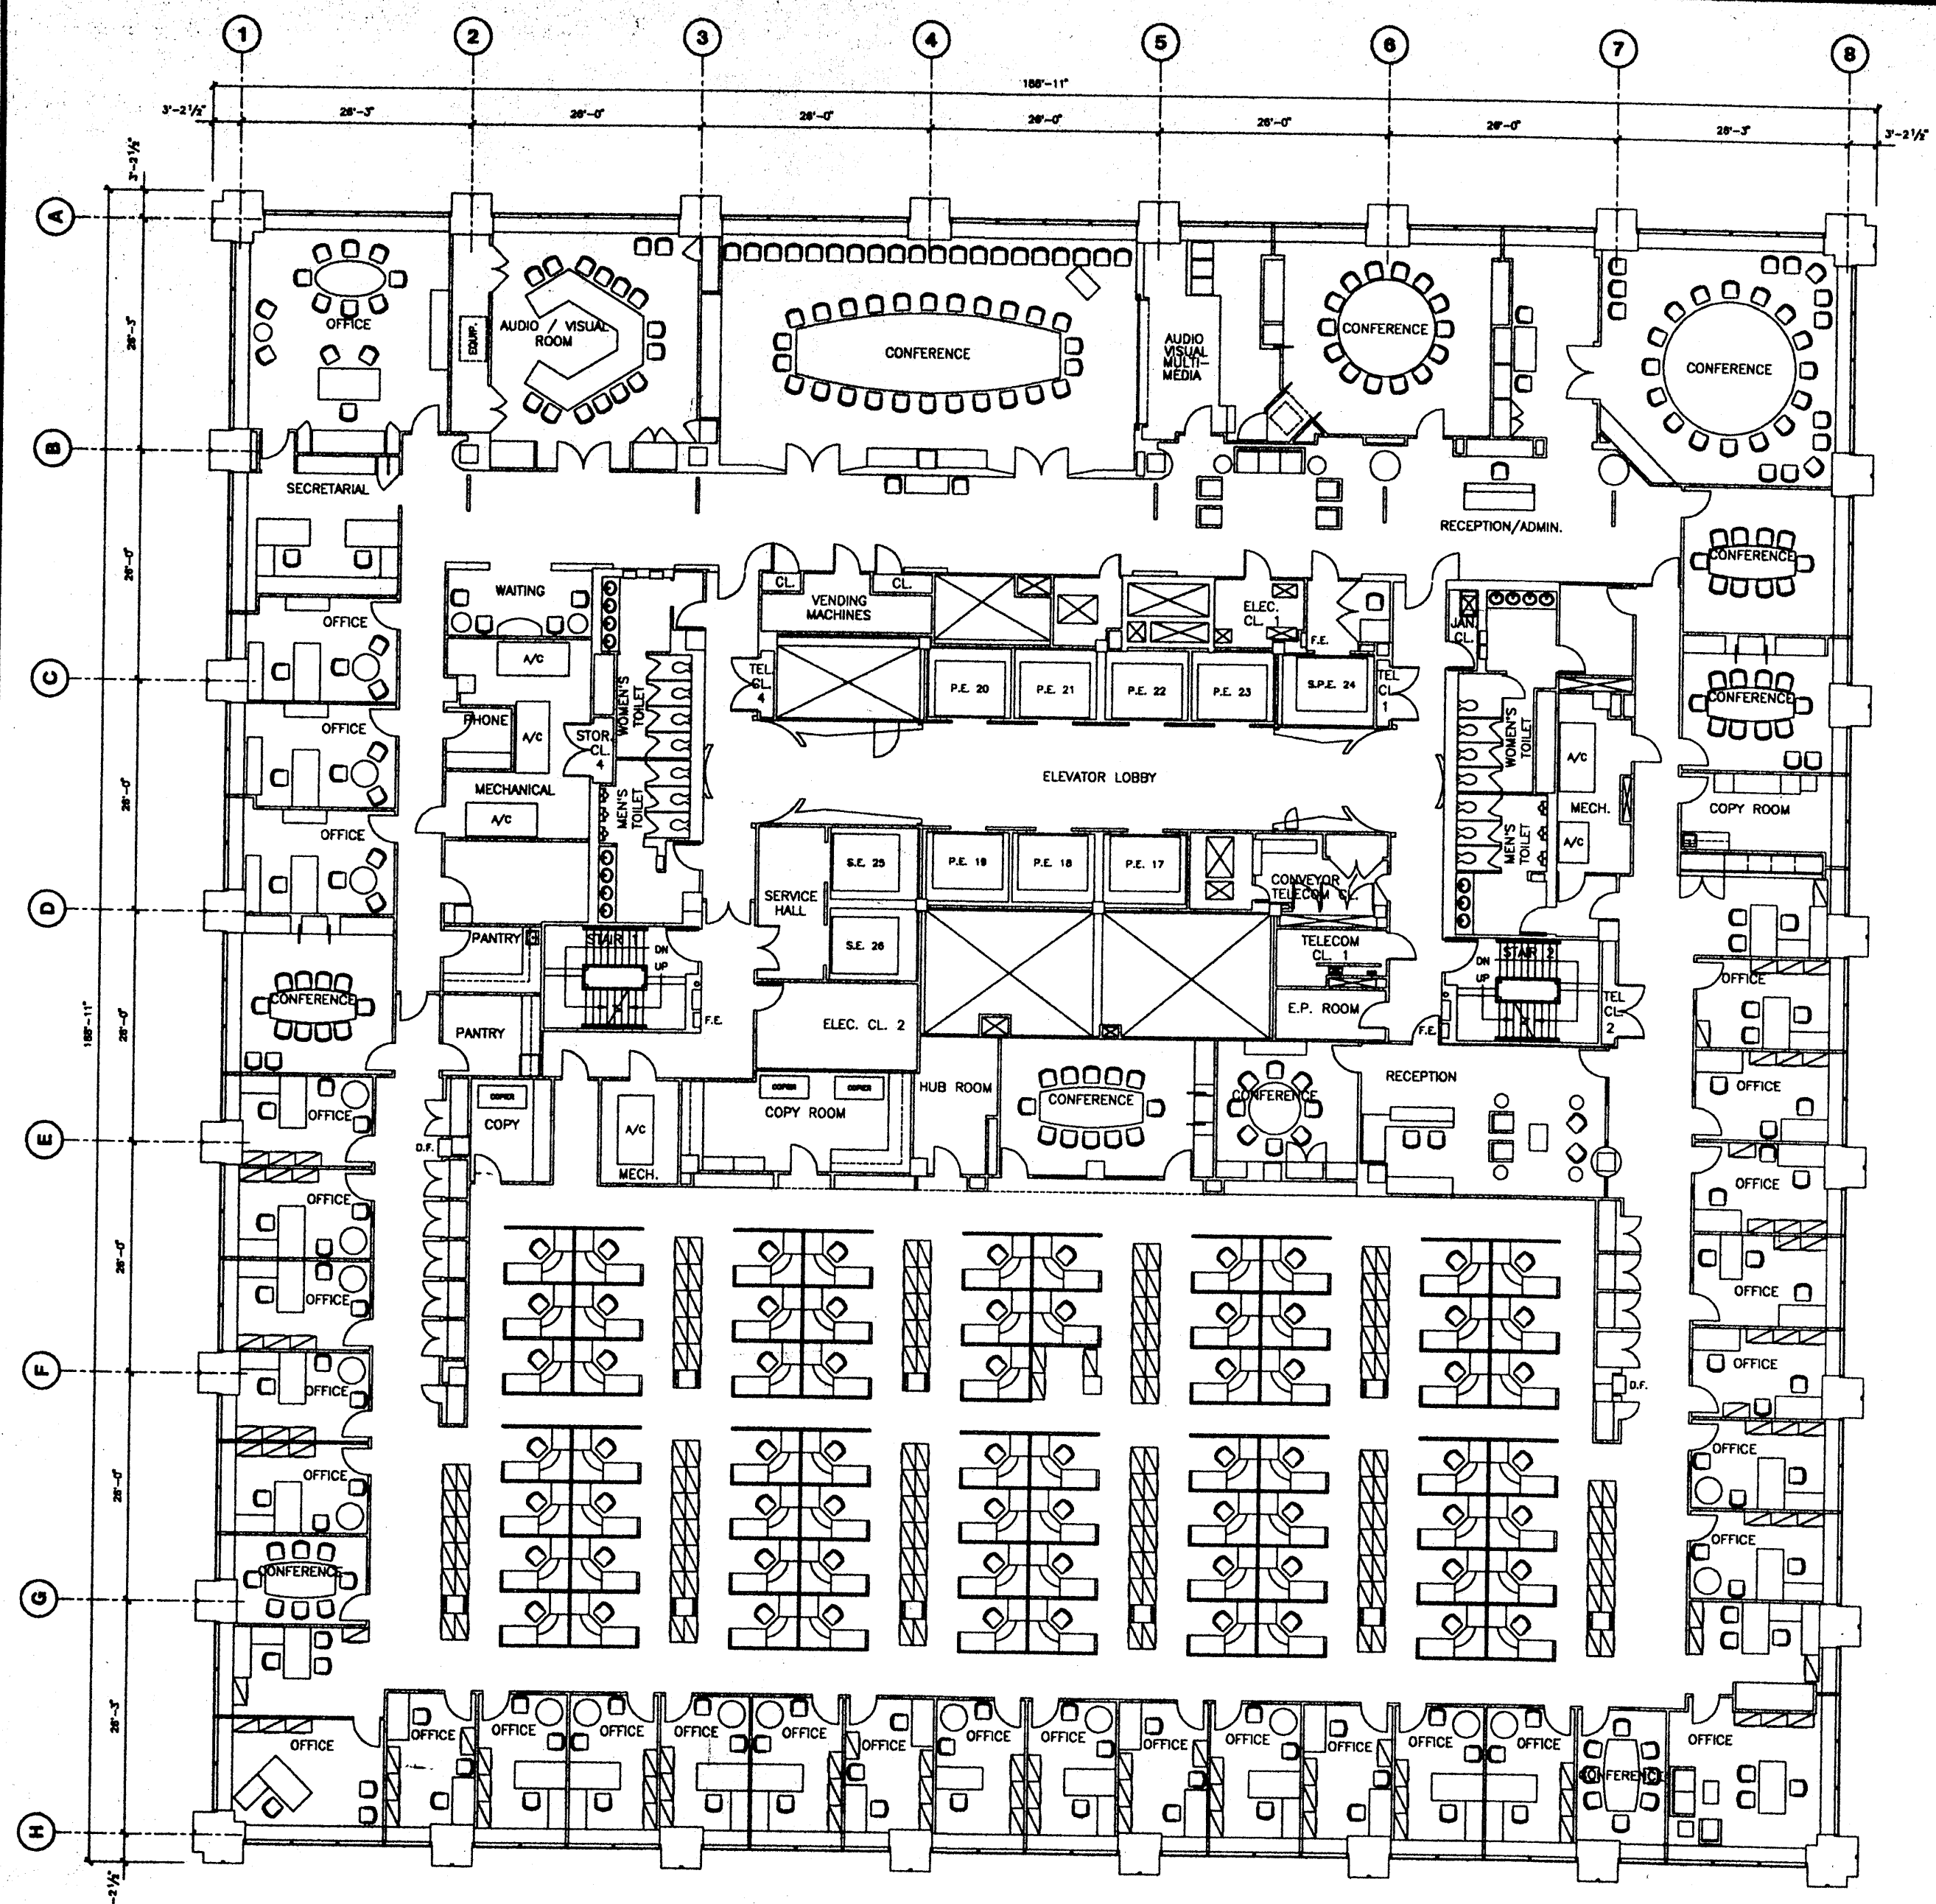

Deutsche Bank


No.	Date	Description
1	5/1/93	Project 02000700 Existing Floor Plan
2	12/20/94	Project 02000700 New Bank Building
3	11/1/98	Project 02000700 / 02000700 New Building / New Floor New Building / New Floor
4	7/15/98	Updated for Existing Glass System
5	8/1/01	Project 130700 New 34th Floor

No.	Date	Issued To

130 LIBERTY STREET
34th FLOOR



Drawn by	
Checked by	
Date	5/1/01
Scale	
Project No.	

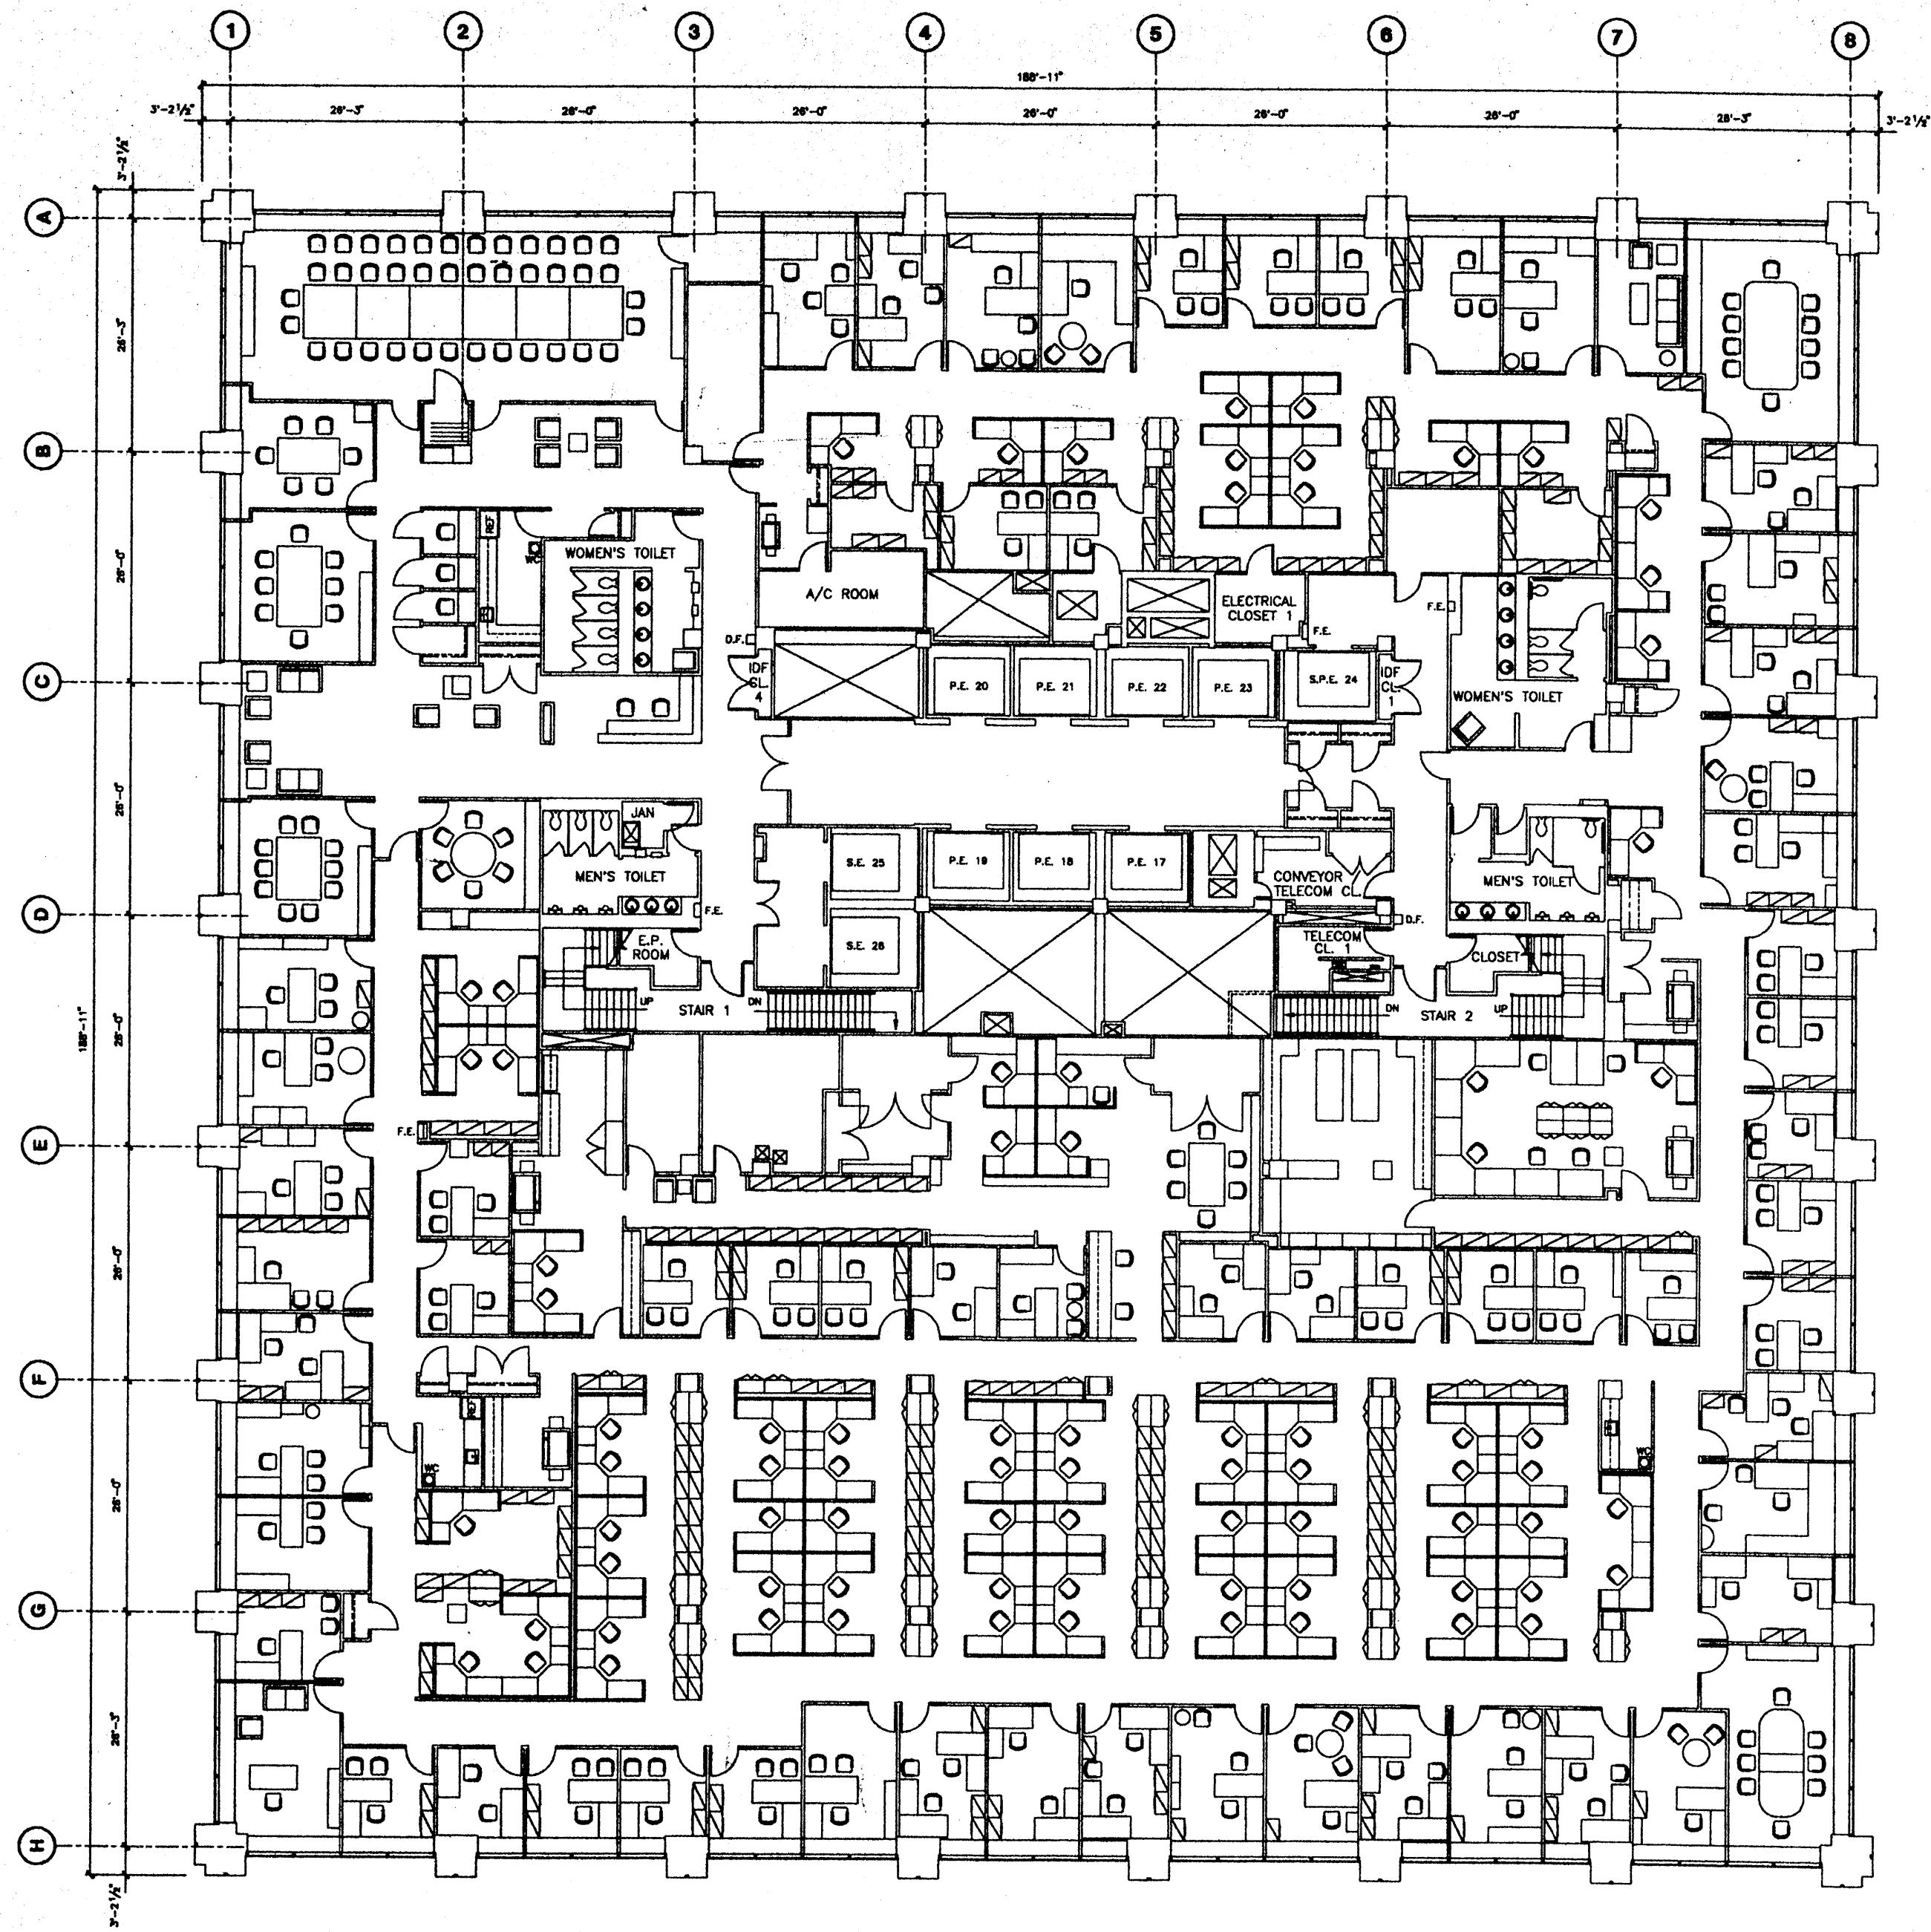

Deutsche Bank


No.	Date	Revised To
1	2/16/93	Project #00001346 Revised: Typical Office
2	2/1/94	Updated: Trading Desk Layout (By: Troy Johnson)
3	4/18/96	Project #00002775 15 Finance Dept. 12 Corner
4	2/1/97	Revised: Interior Elevator Lobby
5	5/20/97	Project #00002885 Submittal
6	7/16/98	Updated for Elevator Client Meeting
7	2/1/99	Added Library Office
8	9/1/01	Updated for Existing Conditions

No.	Date	Revised To

130 LIBERTY STREET
33rd FLOOR

Project No.	
Revision No.	
Date	9/1/01
Scale	
Drawn By	



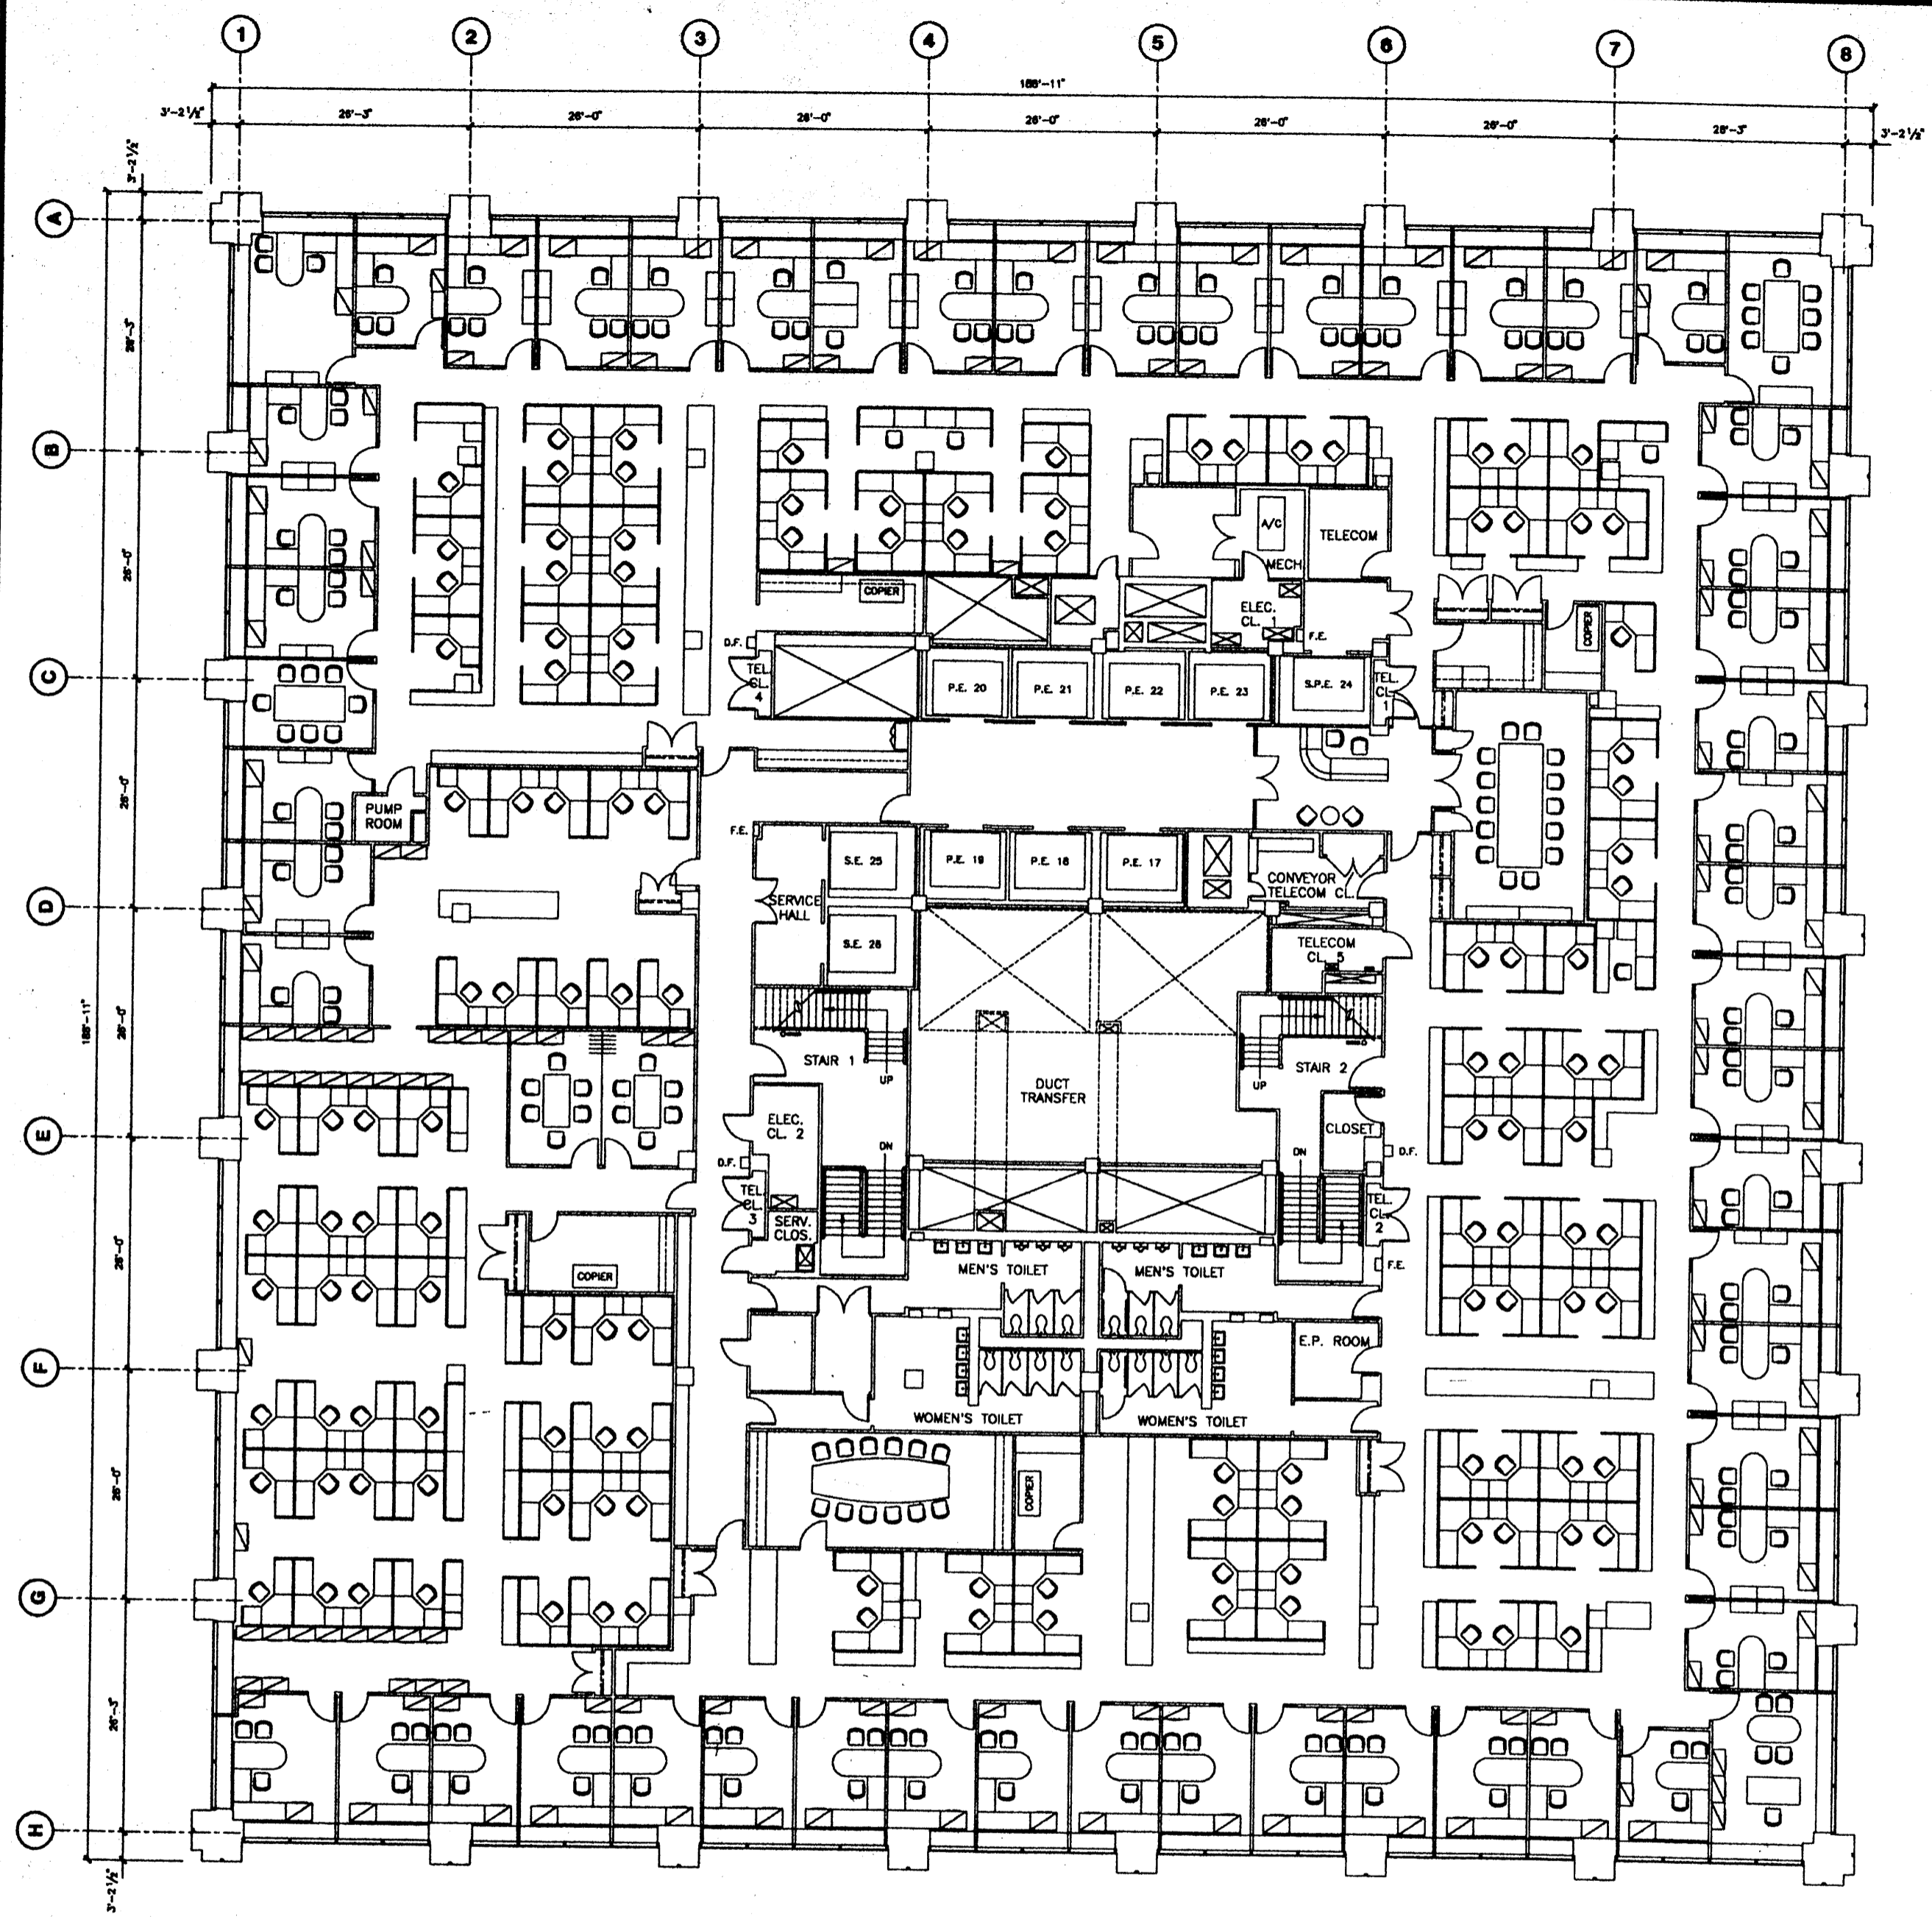

Deutsche Bank

No.	Date	Description
1	5/1/97	Initial Schematic Design
2	7/28/98	Project SCHEDULE Development of IT Card Room
3	7/15/98	Updated for Shared Client Service
4	1/18/99	Project SCHEDULE - Initial Architectural Plans
5	5/19/99	Project SCHEDULE - Initial Architectural Plans
6	3/25/01	Updated for Building Code/Reg.


No.	Date	Revised To

130 LIBERTY STREET

32nd FLOOR

Drawn By	
Checked By	
Date	5/25/01
Scale	
Project No.	



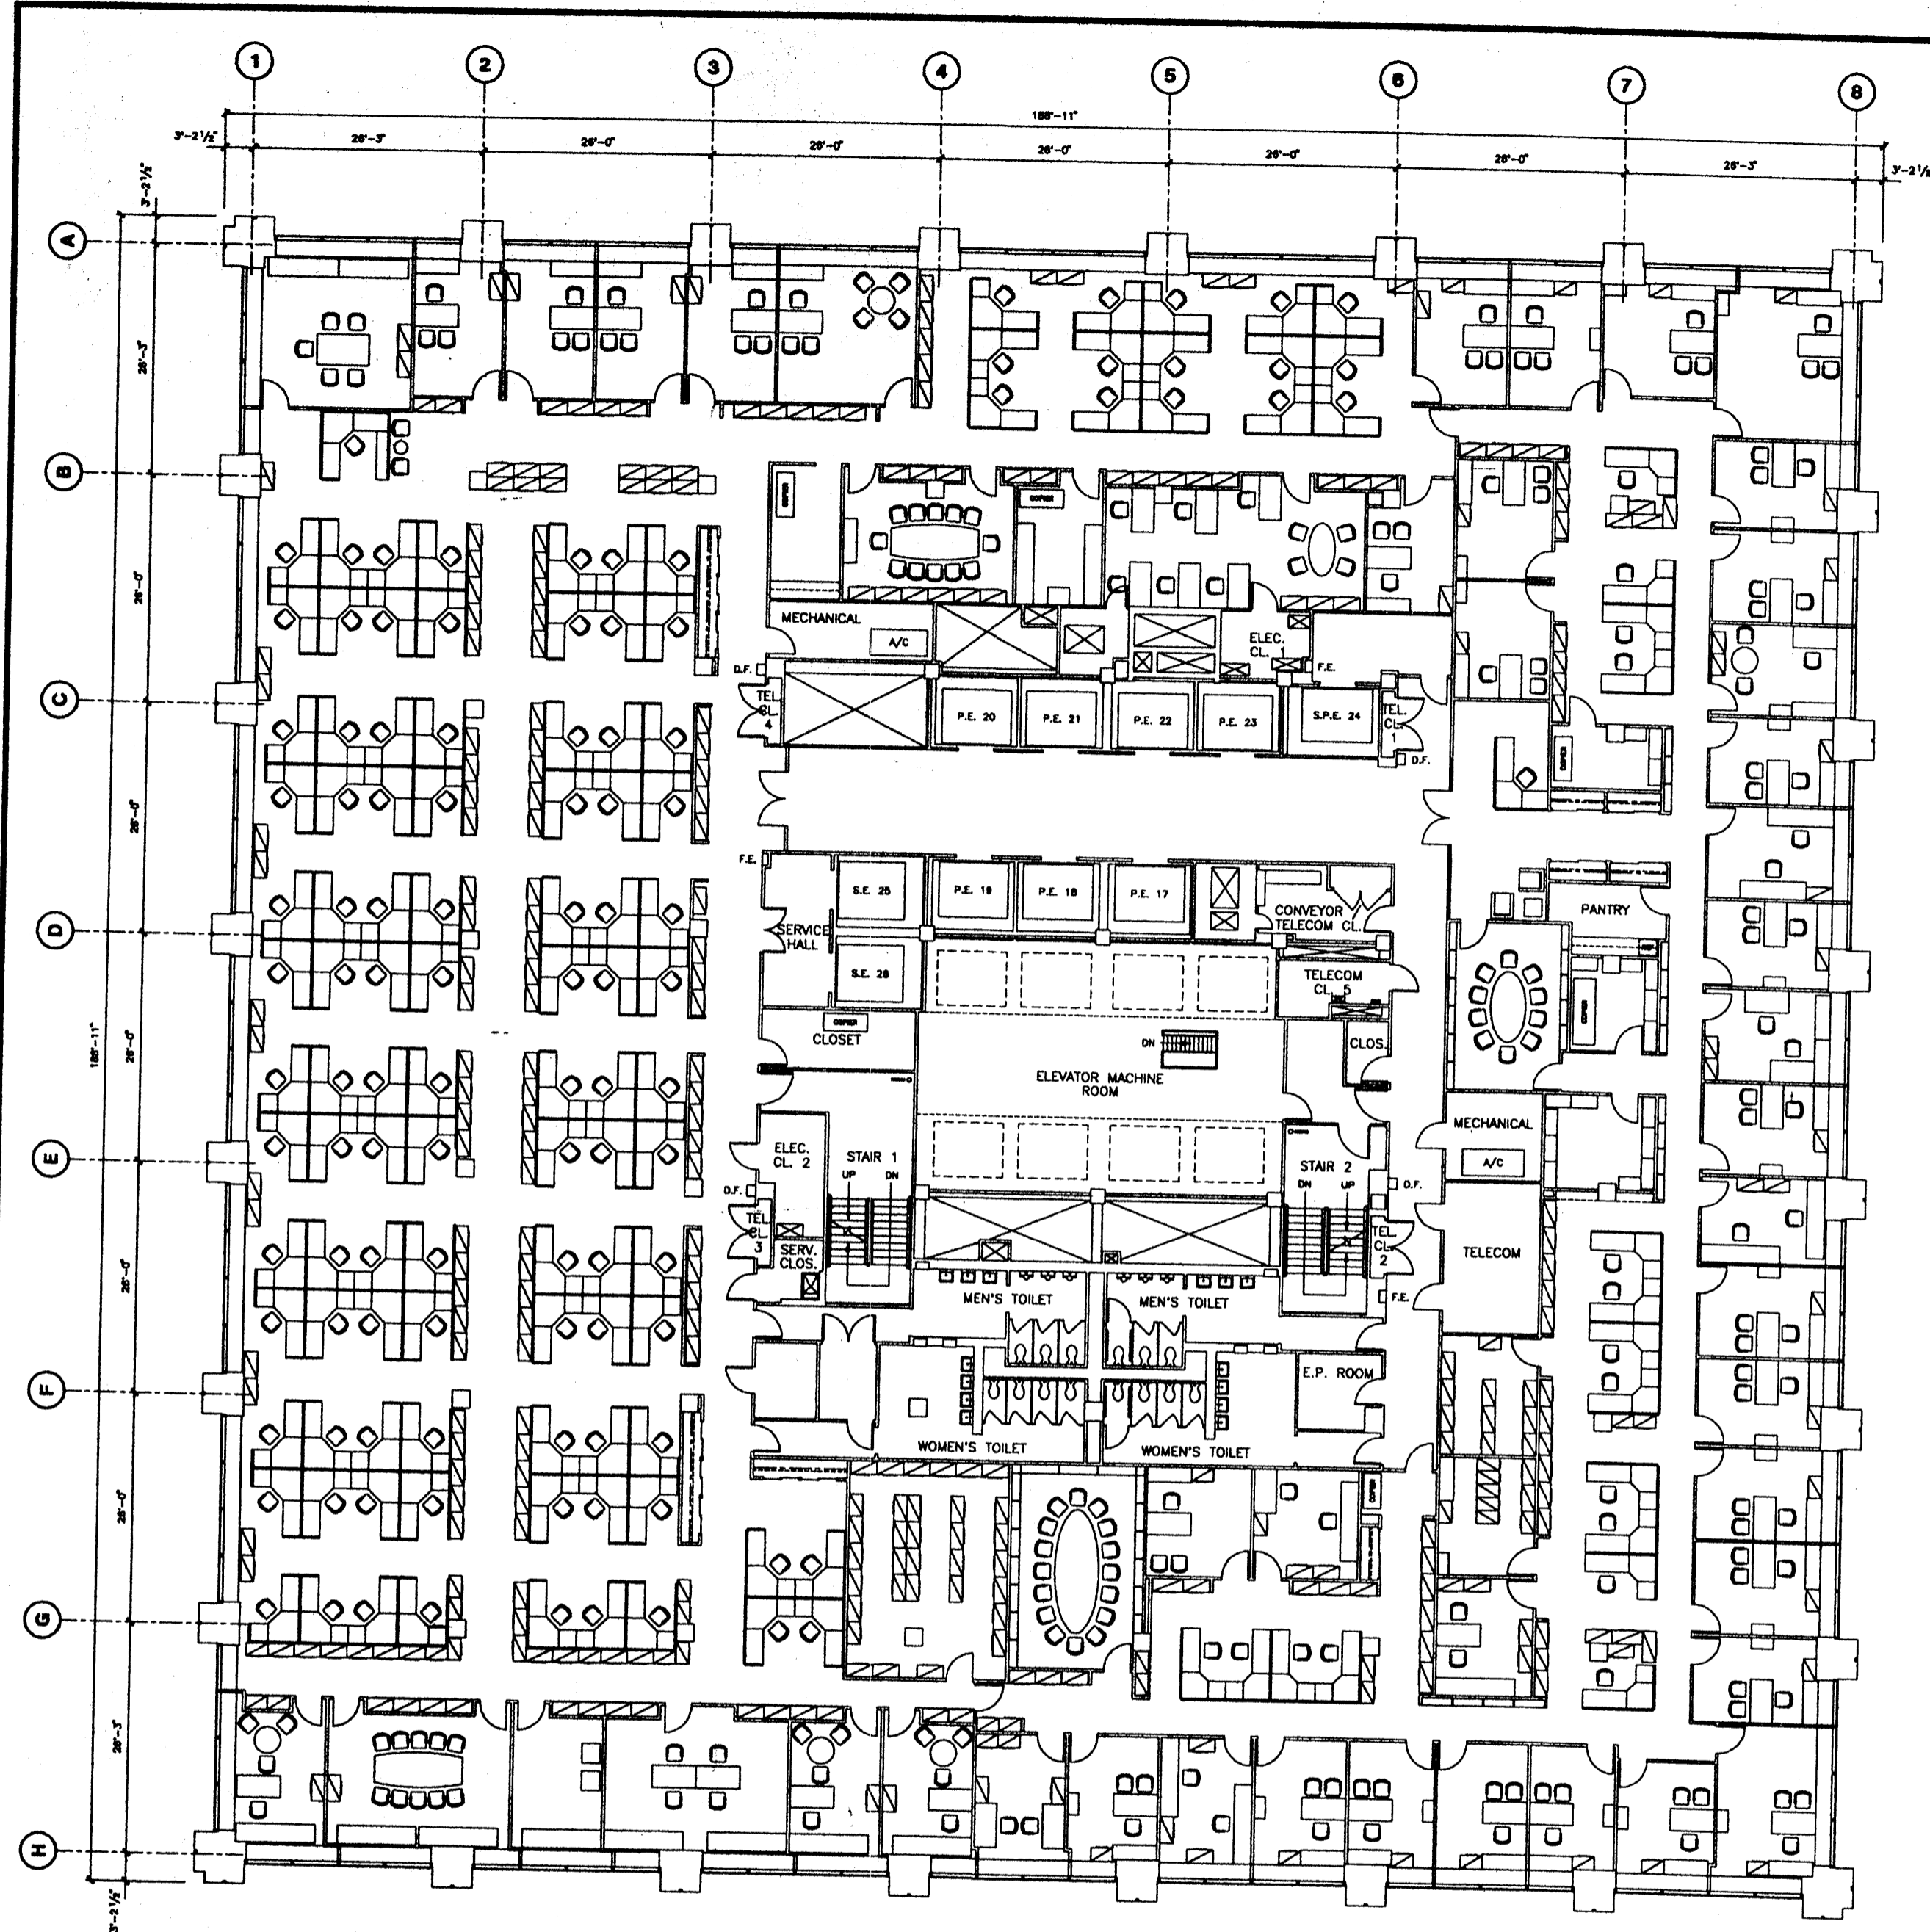

Deutsche Bank

No.	Date	Description
1	7/10/98	Project REVISION - Legal Representation
2	12/1/98	Project REVISION - Legal Representation
3	5/26/97	Updated for Existing Conditions
4	7/15/98	Updated for Existing Check Survey
5	5/25/01	Updated for Existing Conditions


No.	Date	Revised By	Checked

PROJECT
130 LIBERTY STREET

FLOOR
31st FLOOR

Drawn By	
Checked By	
Date	5/28/01
Scale	
Project No.	



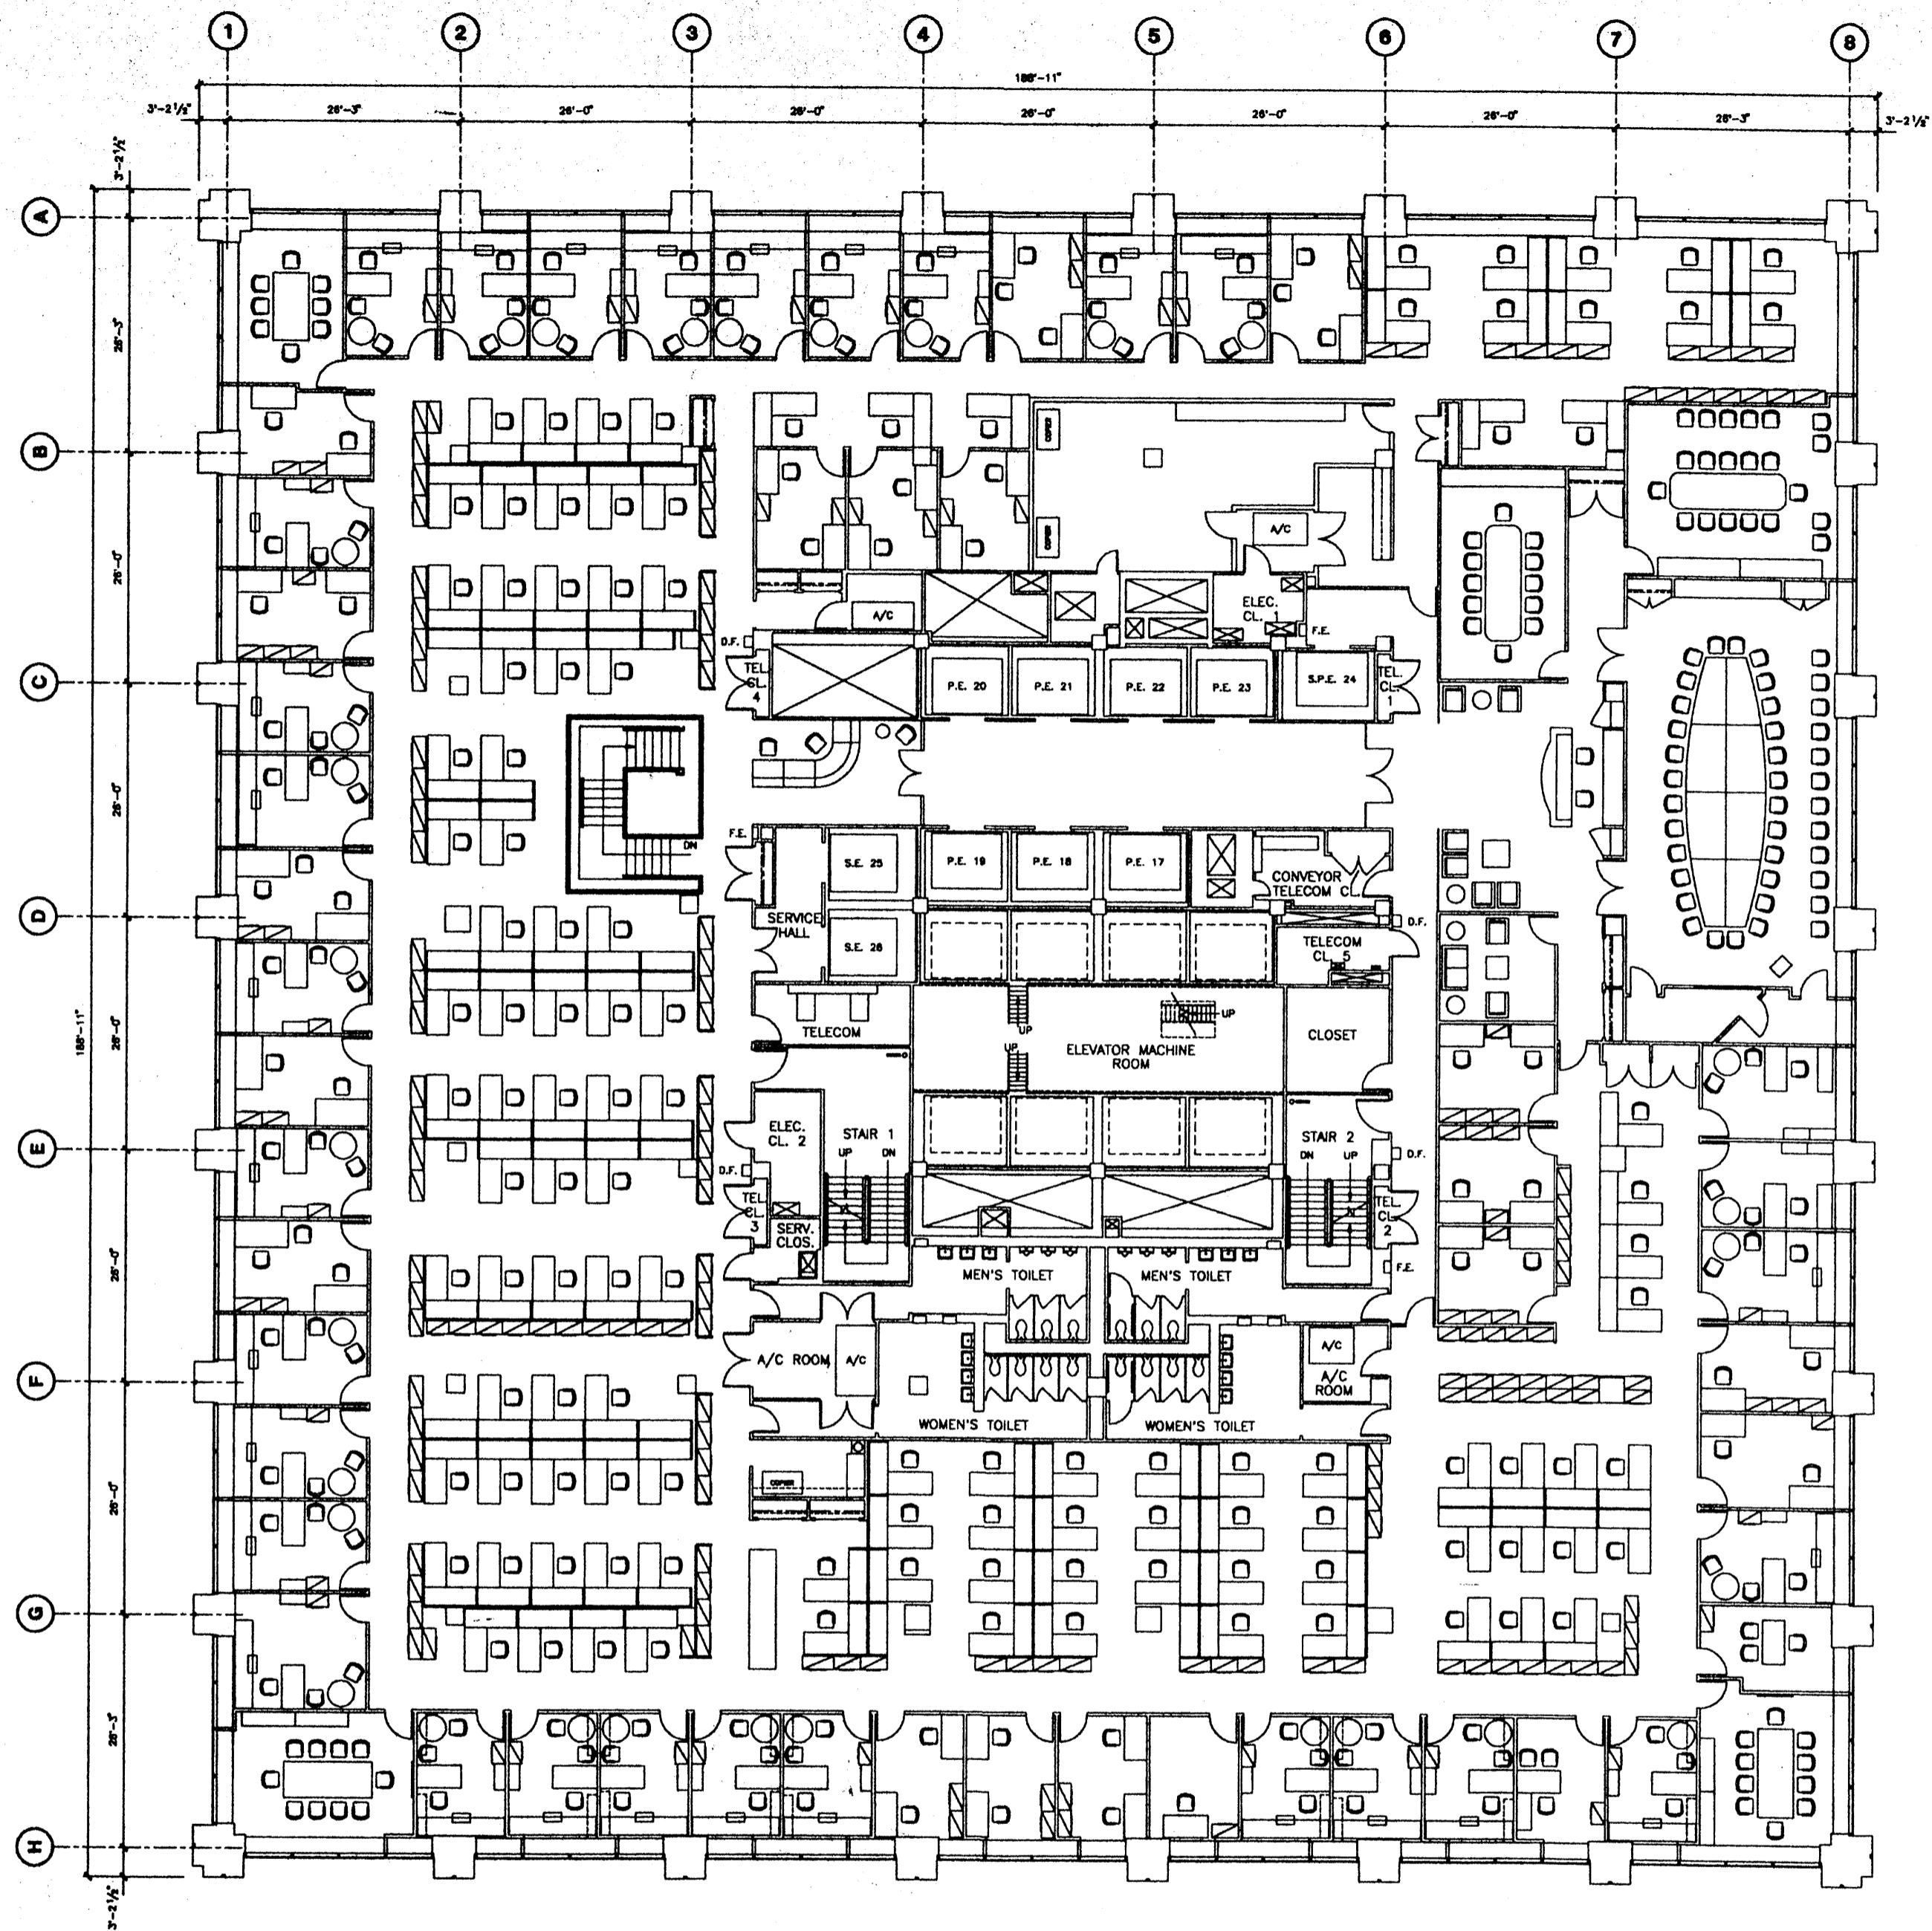

Deutsche Bank


No.	Date	Description
1	12/1/00	Project 00000112 - 1st Floor Renovation
2	12/1/00	Project 00000120 - 2nd Floor Renovation
3	6/2/01	Project 00000130 - 3rd Floor Renovation
4	3/1/01	Project 00000140 - 4th Floor Renovation
5	5/1/01	Added Sup. to 20th Floor
6	7/15/01	Updated for Deutsche Credit Service
7	1/1/01	Project 00000140 - Renovation
8	5/1/01	Updated for Existing Conditions

No.	Date	Issued To

PROJECT
130 LIBERTY STREET
30th FLOOR

Drawn By	
Checked By	
Date	9/1/01
Scale	
Project No.	



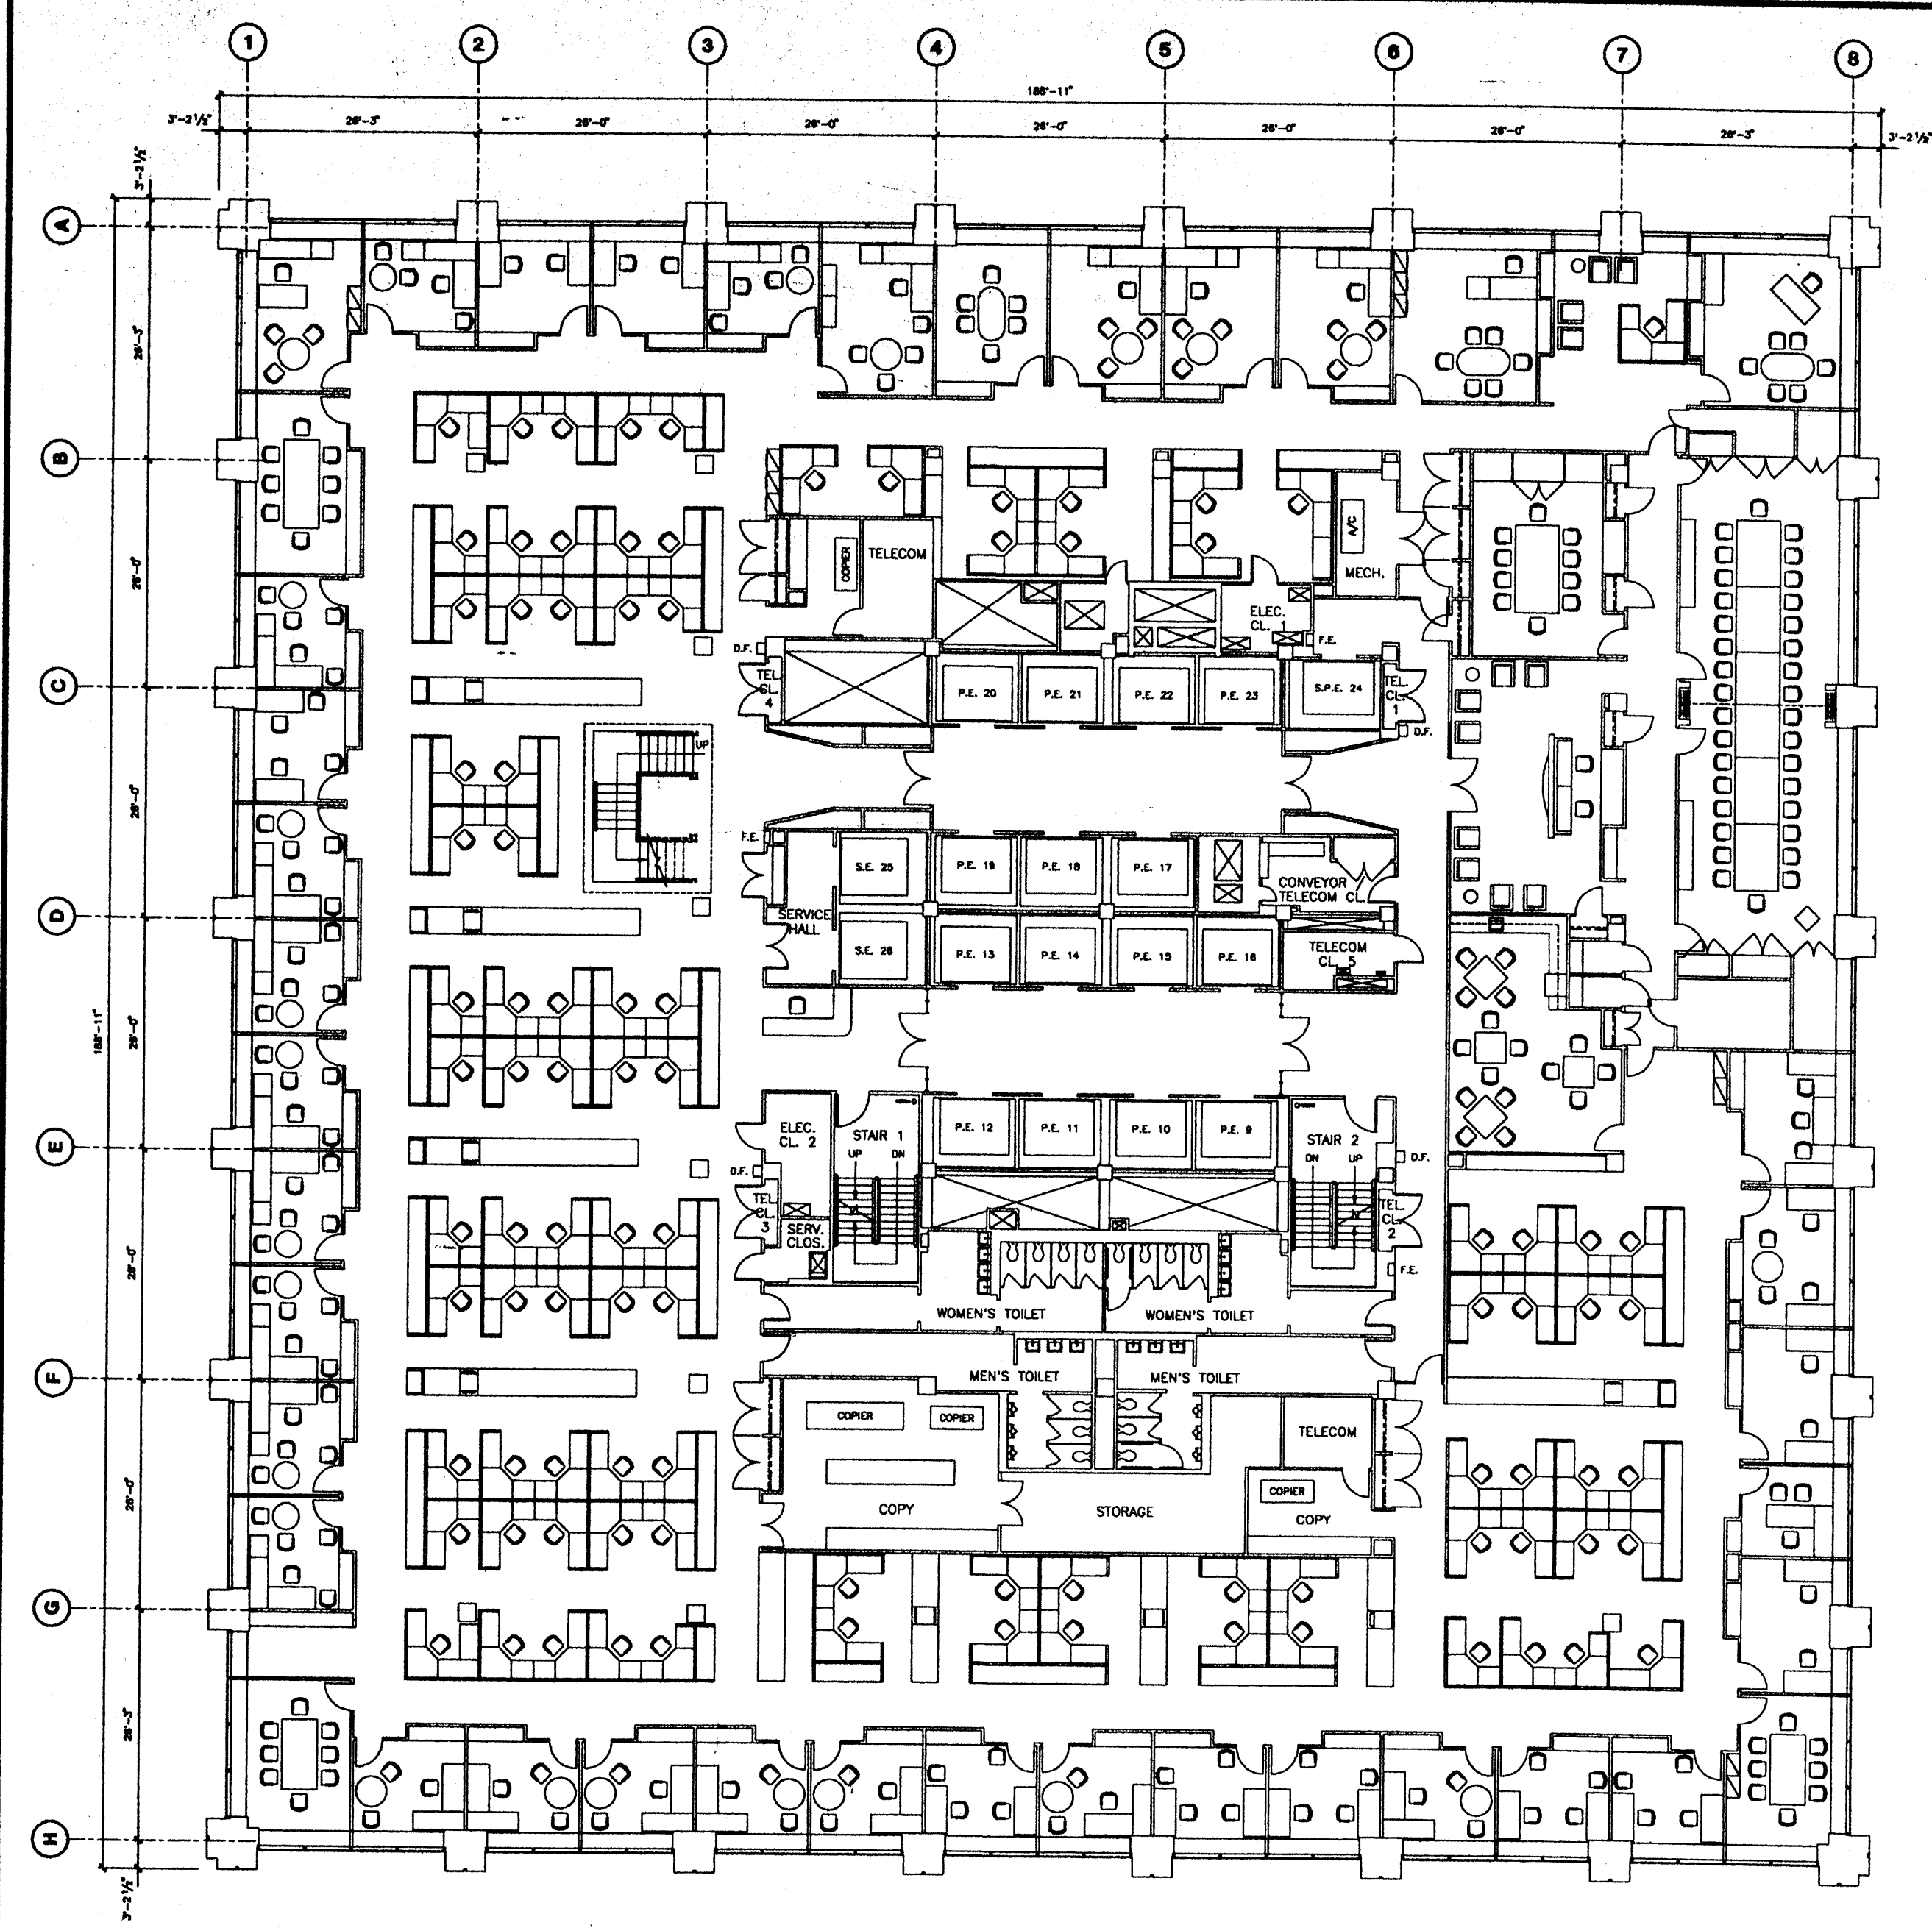

Deutsche Bank

No.	Date	Description
1	6/1/98	Original, 100001200, 10/1/98, 10/1/98
2	7/15/98	Updated for Deutsche Bank, 10/1/98
3	5/25/01	Updated for existing conditions


No.	Date	Revised To

130 LIBERTY STREET

29th FLOOR



Drawn by	
Checked by	
Date	5/25/01
Project No.	

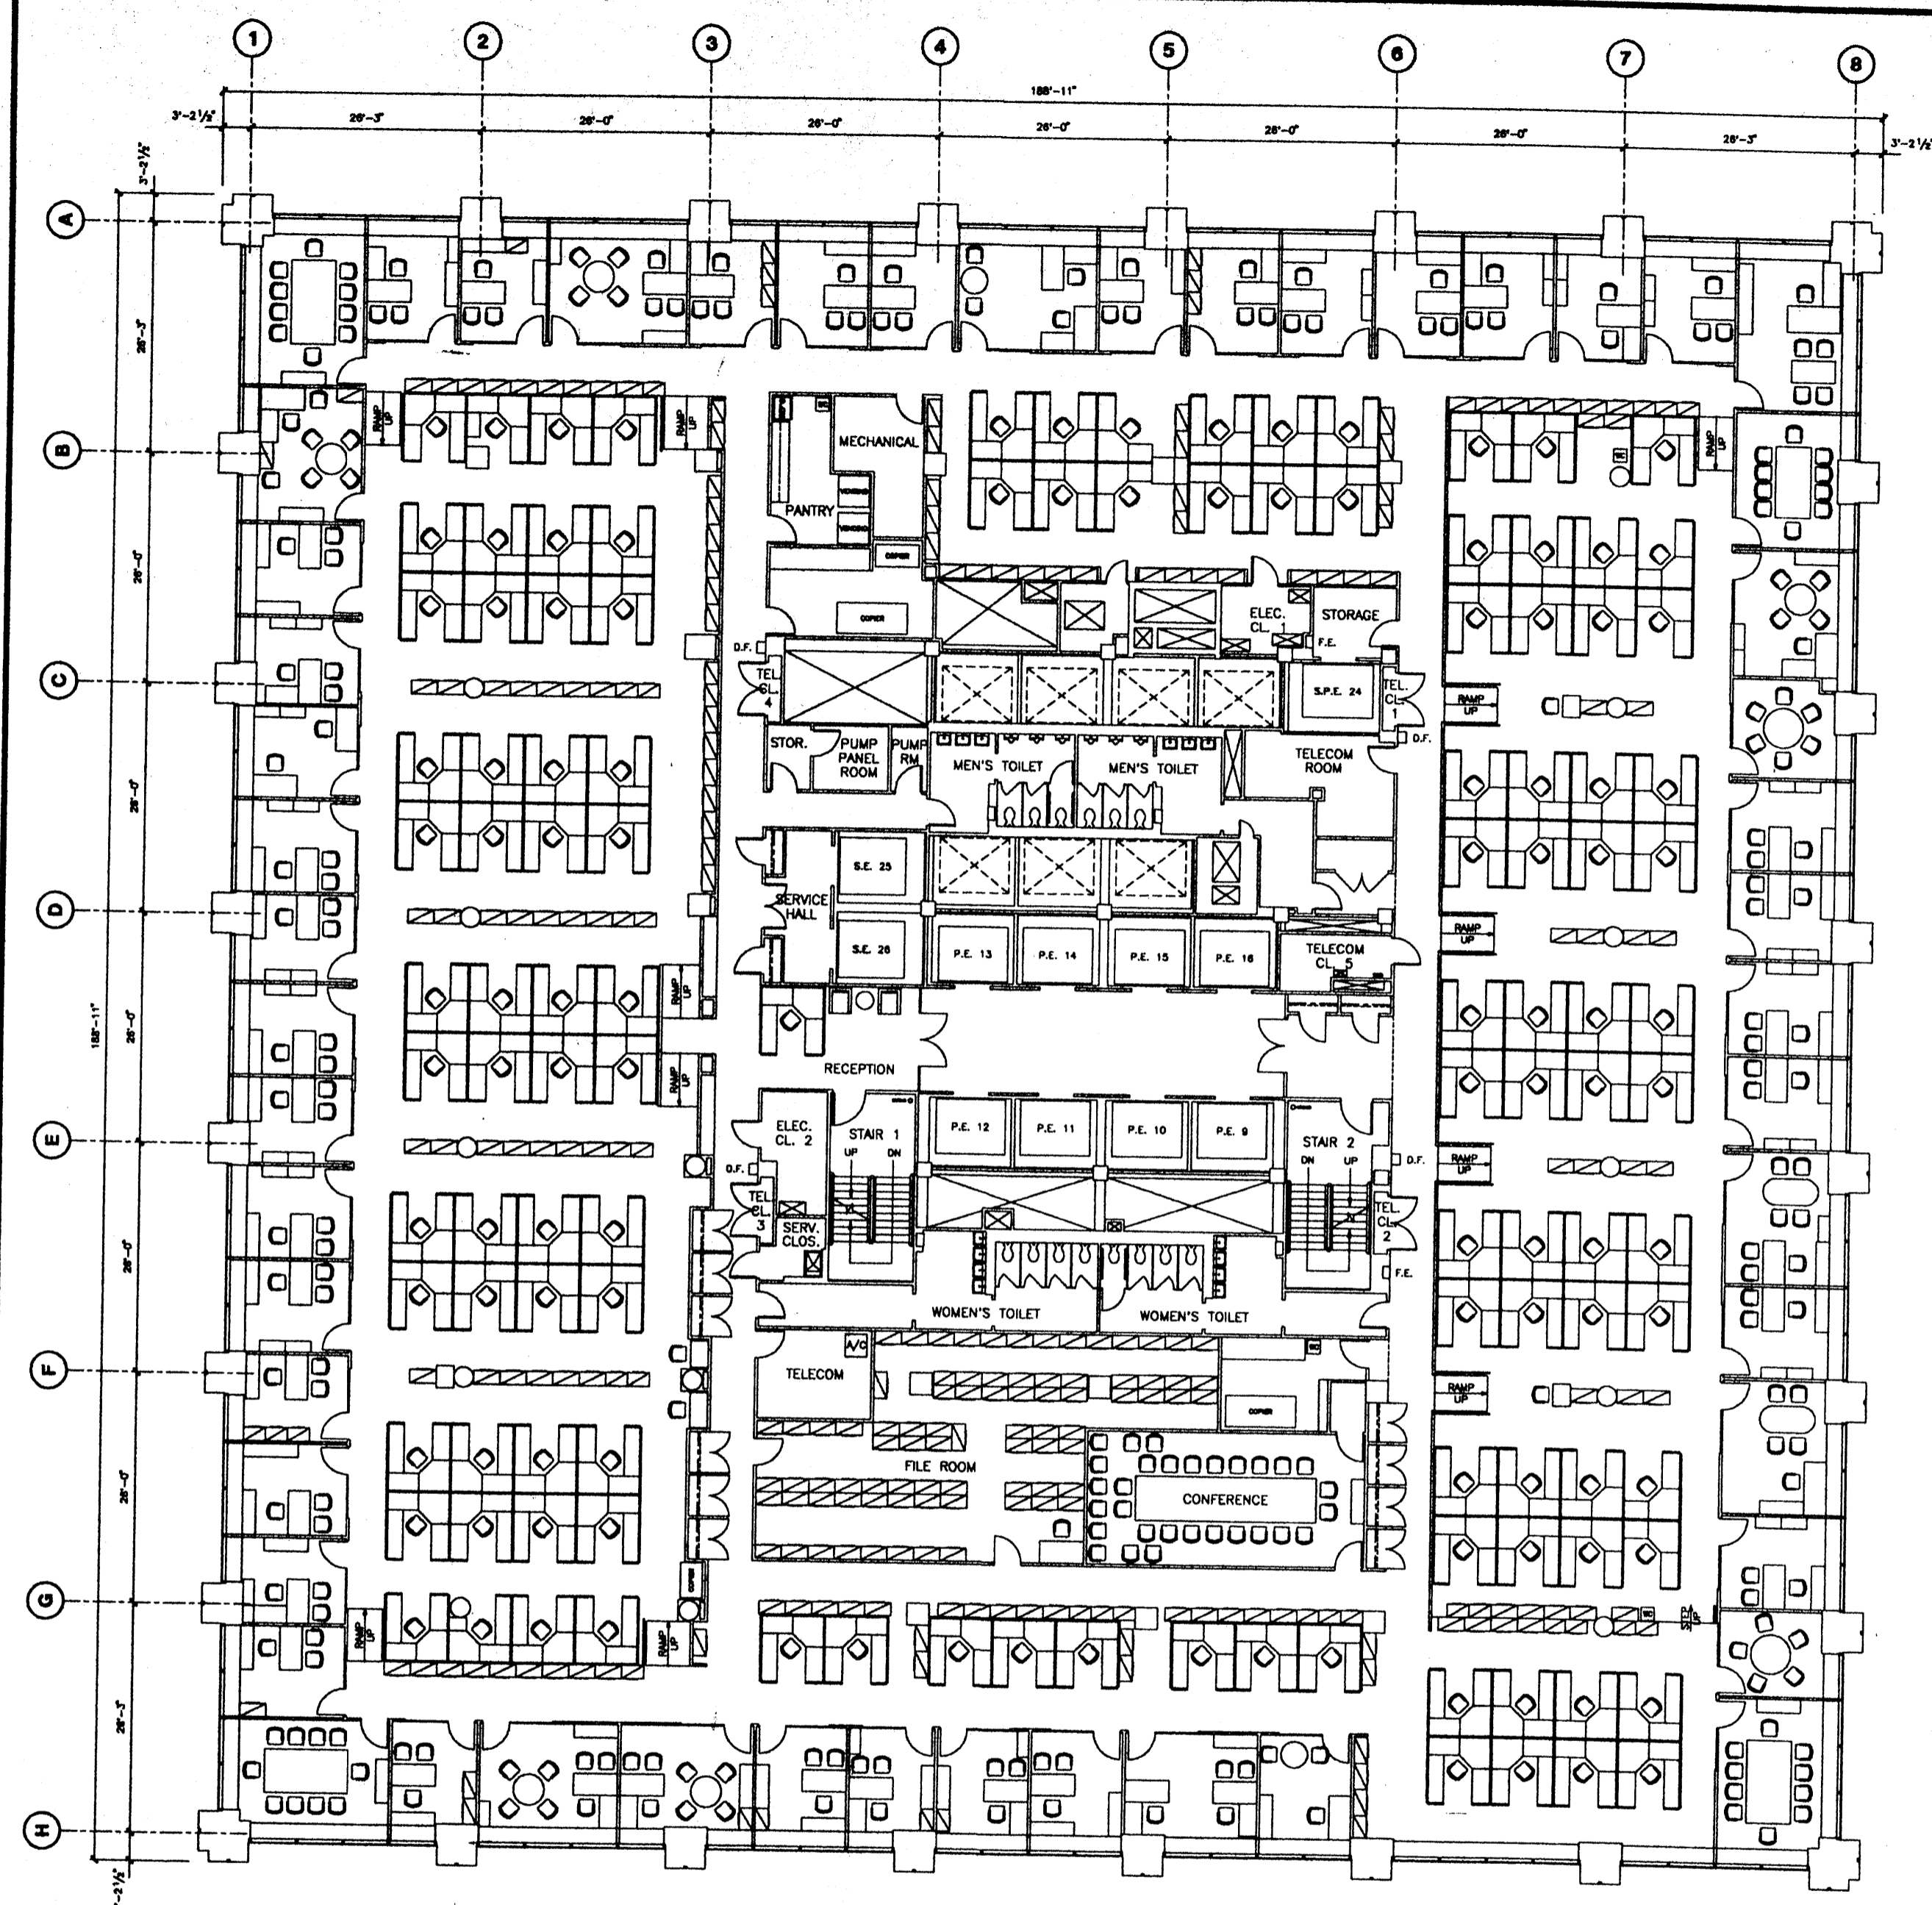

Deutsche Bank


No.	Date	Description
1.	4/10/98	Project 00000107 Red & Green Submittal
2.	7/18/98	Updated for Electric Change Order
3.	1/18/01	Project 10207001100 North & South Side Offices
4.	8/1/01	Updated for Existing Conditions

No.	Date	Issued To

PROJECT
130 LIBERTY STREET
DRAWING
28th FLOOR

Drawn By	Checked By
Date	9/1/01
Project No.	



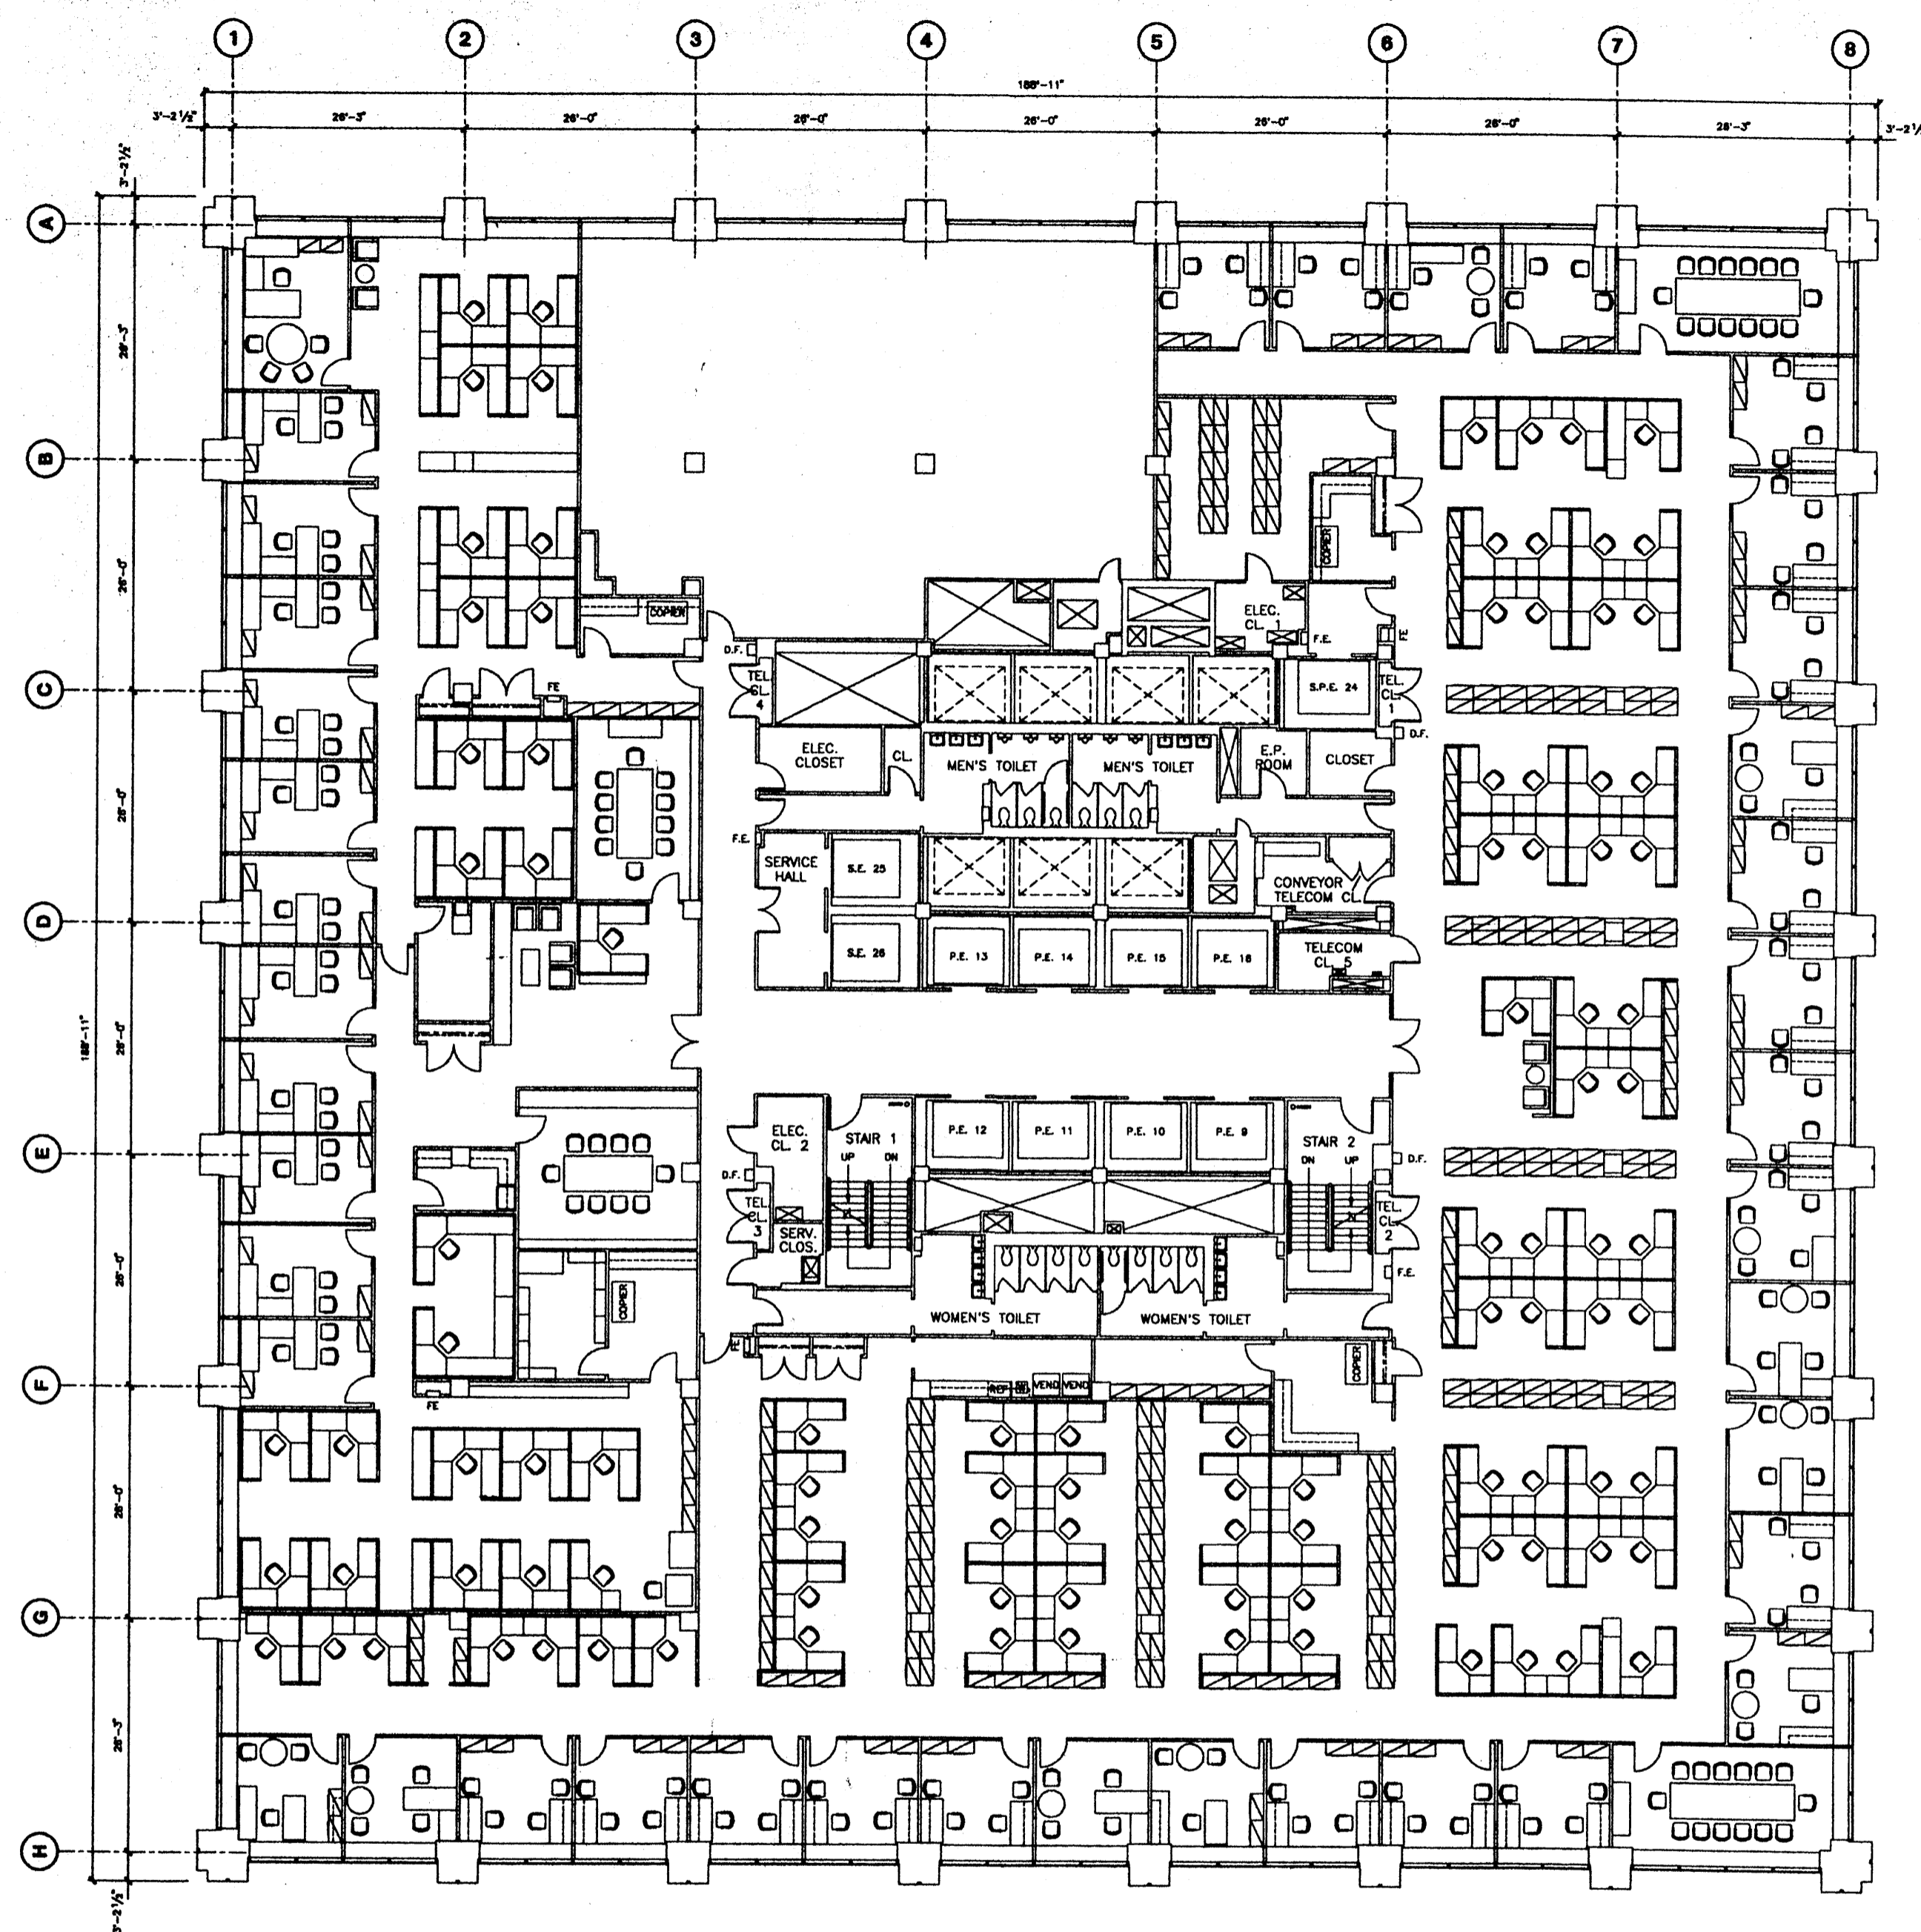

Deutsche Bank


No.	Date	Description
1	7/15/92	Update / Supplement Initial Conditions for Client File
2	1/28/94	Update for Building Conditions
3	4/15/97	Update for Building Conditions
4	3/7/98	Project #70001450 - Data Structure Study Final
5	7/15/98	Update for Security Check Stamp
6	10/7/98	Project #70001450 - Complete Alpha Renovation
7	3/7/99	Project #70001450 - Complete Alpha Renovation
8	5/25/01	Update for Existing Conditions

Scale: 1/8" = 1'-0"

130 LIBERTY STREET

27th FLOOR

Drawn By	Checked By
Date	5/25/01
Scale	
Project No.	

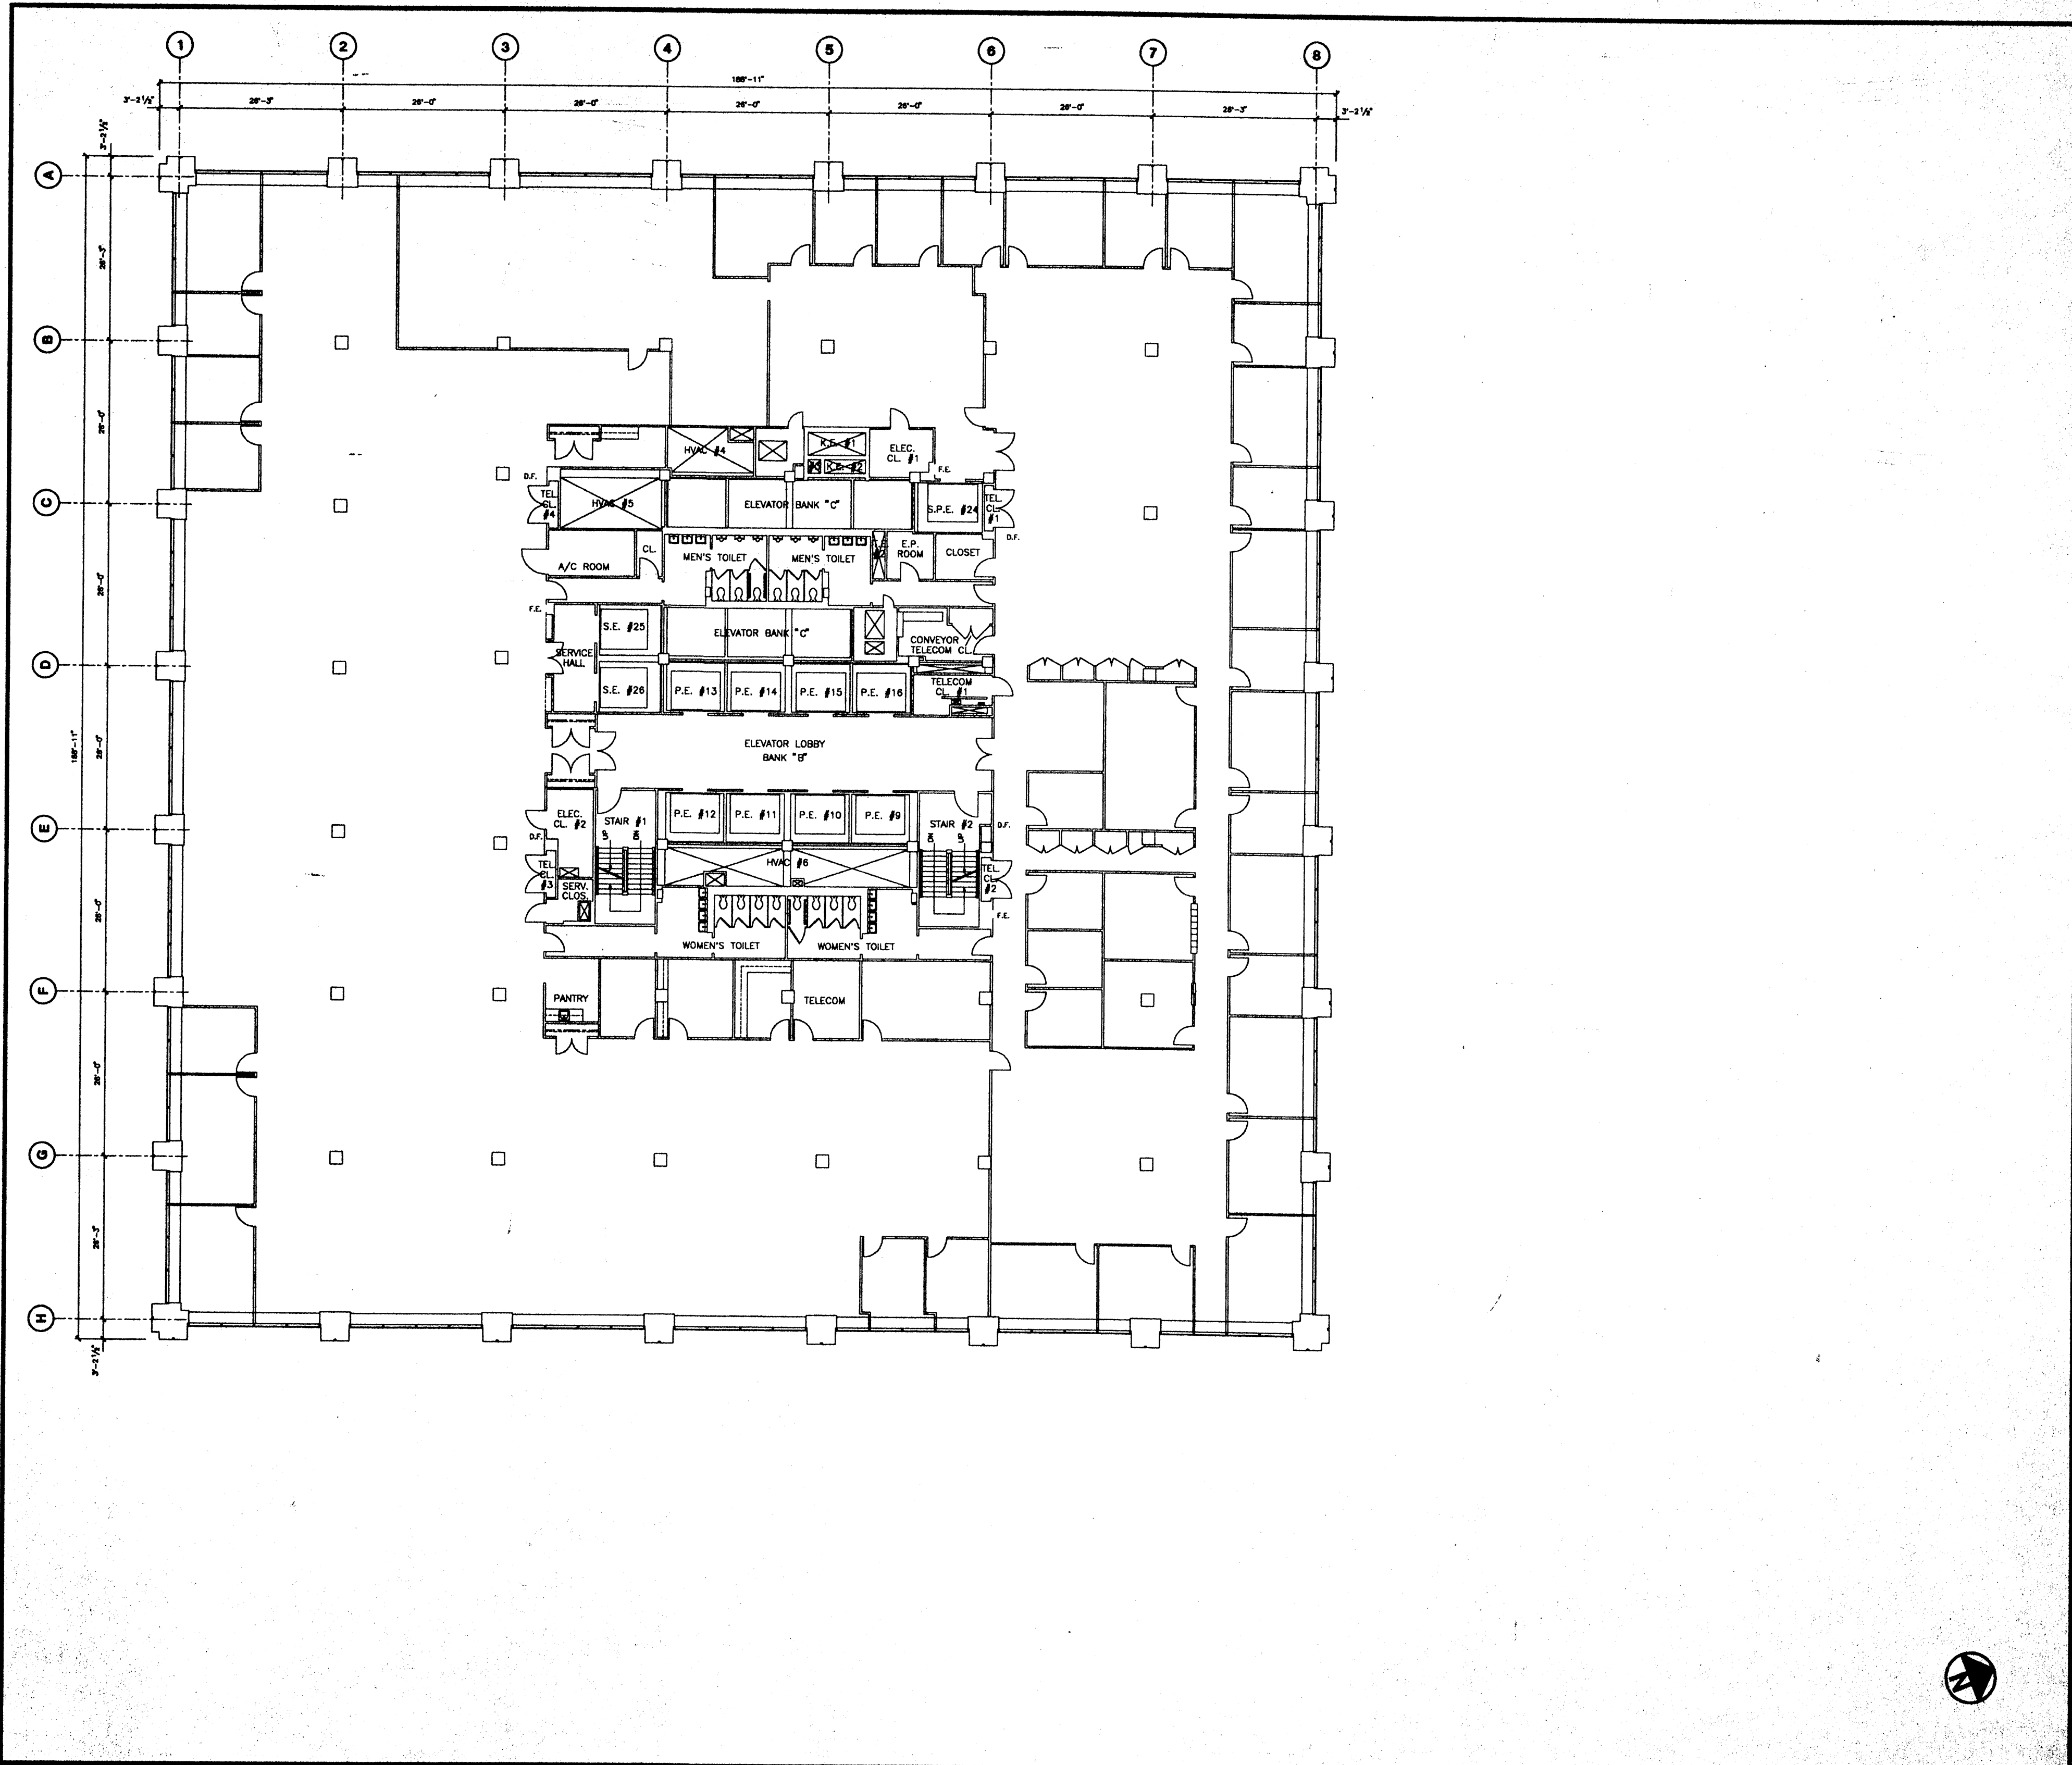

Deutsche Bank

No.	Date	Description
1	9/1/93	Original Erection
2	3/1/97	Project RECONSTRUCTION of Elevator Lobby
3	7/15/98	Updated for Electric Control System


No.	Date	Issued To

PROJECT
130 LIBERTY STREET

FLOOR
26th FLOOR

Drawn by	Checked by
Date	7/15/98
Scale	
Project No.	



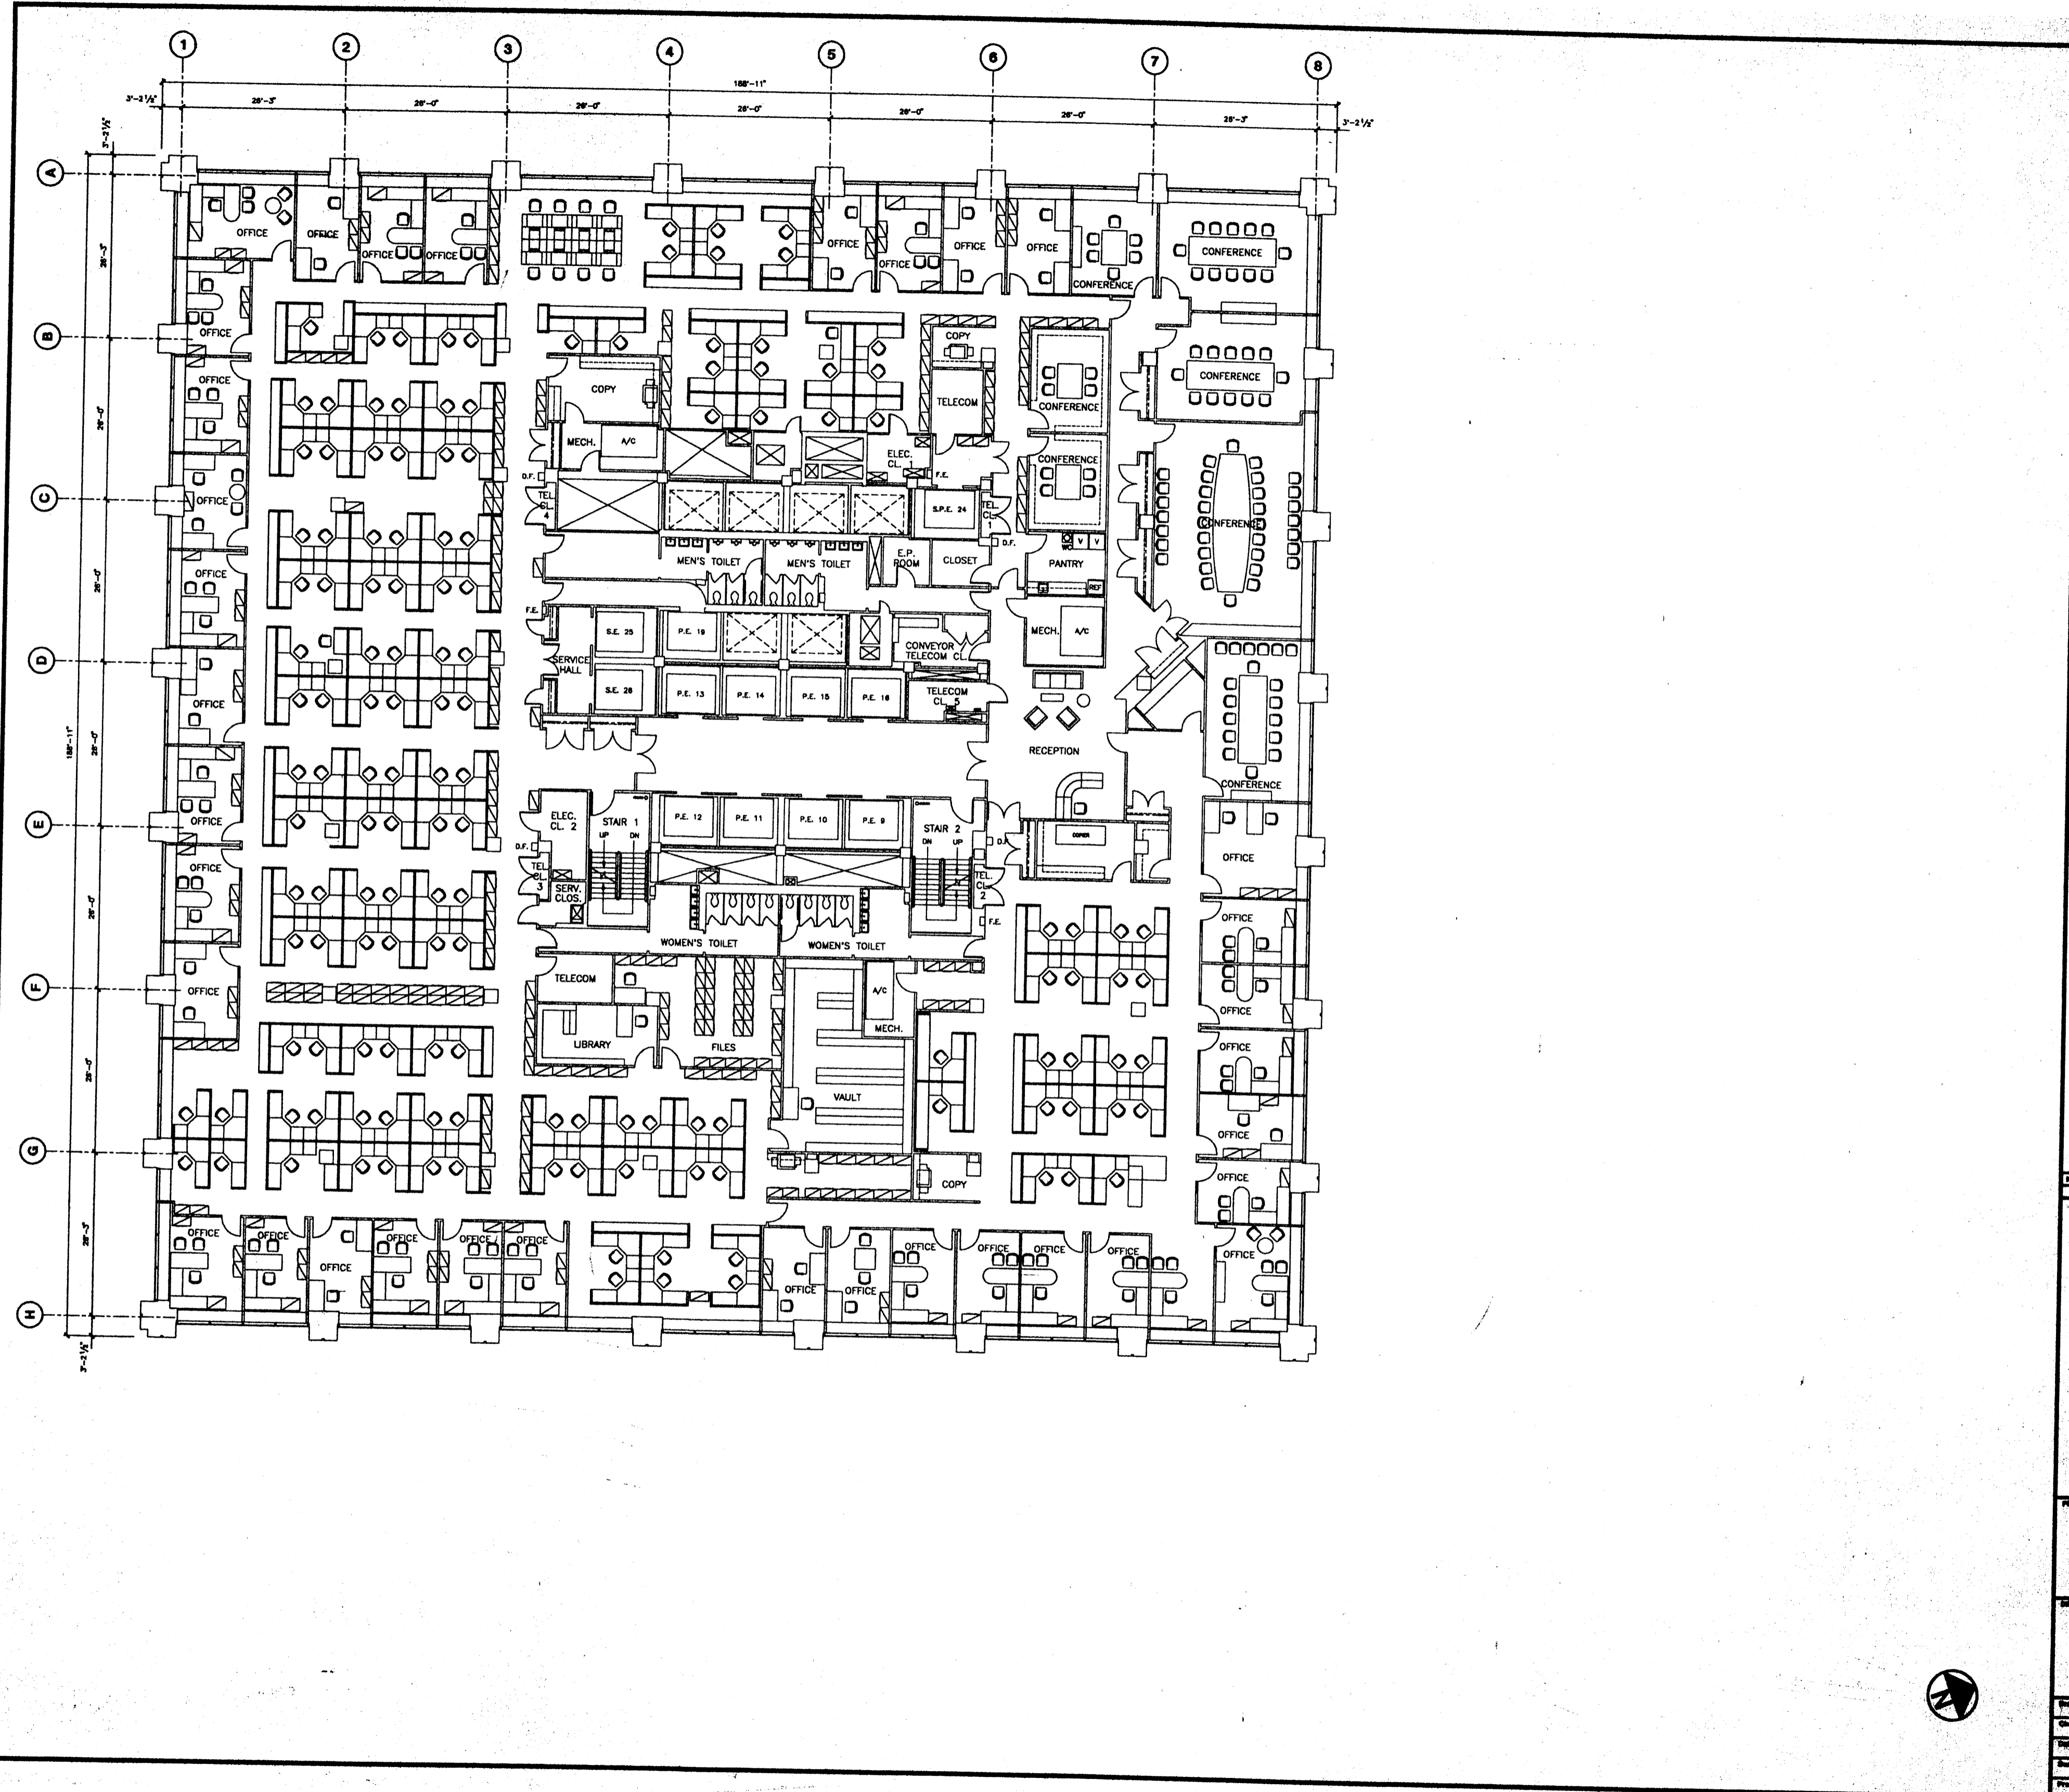


Deutsche Bank


No.	Date	Description
1	7/15/97	Project 000000001 - NEW Private Equity Building
2	7/15/98	Updated for Deutsche Global Building
3	5/28/01	Updated for Building Conditions

No.	Date	Issued To

130 LIBERTY STREET
25th FLOOR

Drawn By:	
Checked By:	
Date:	5/25/01
Project No.:	

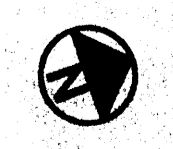

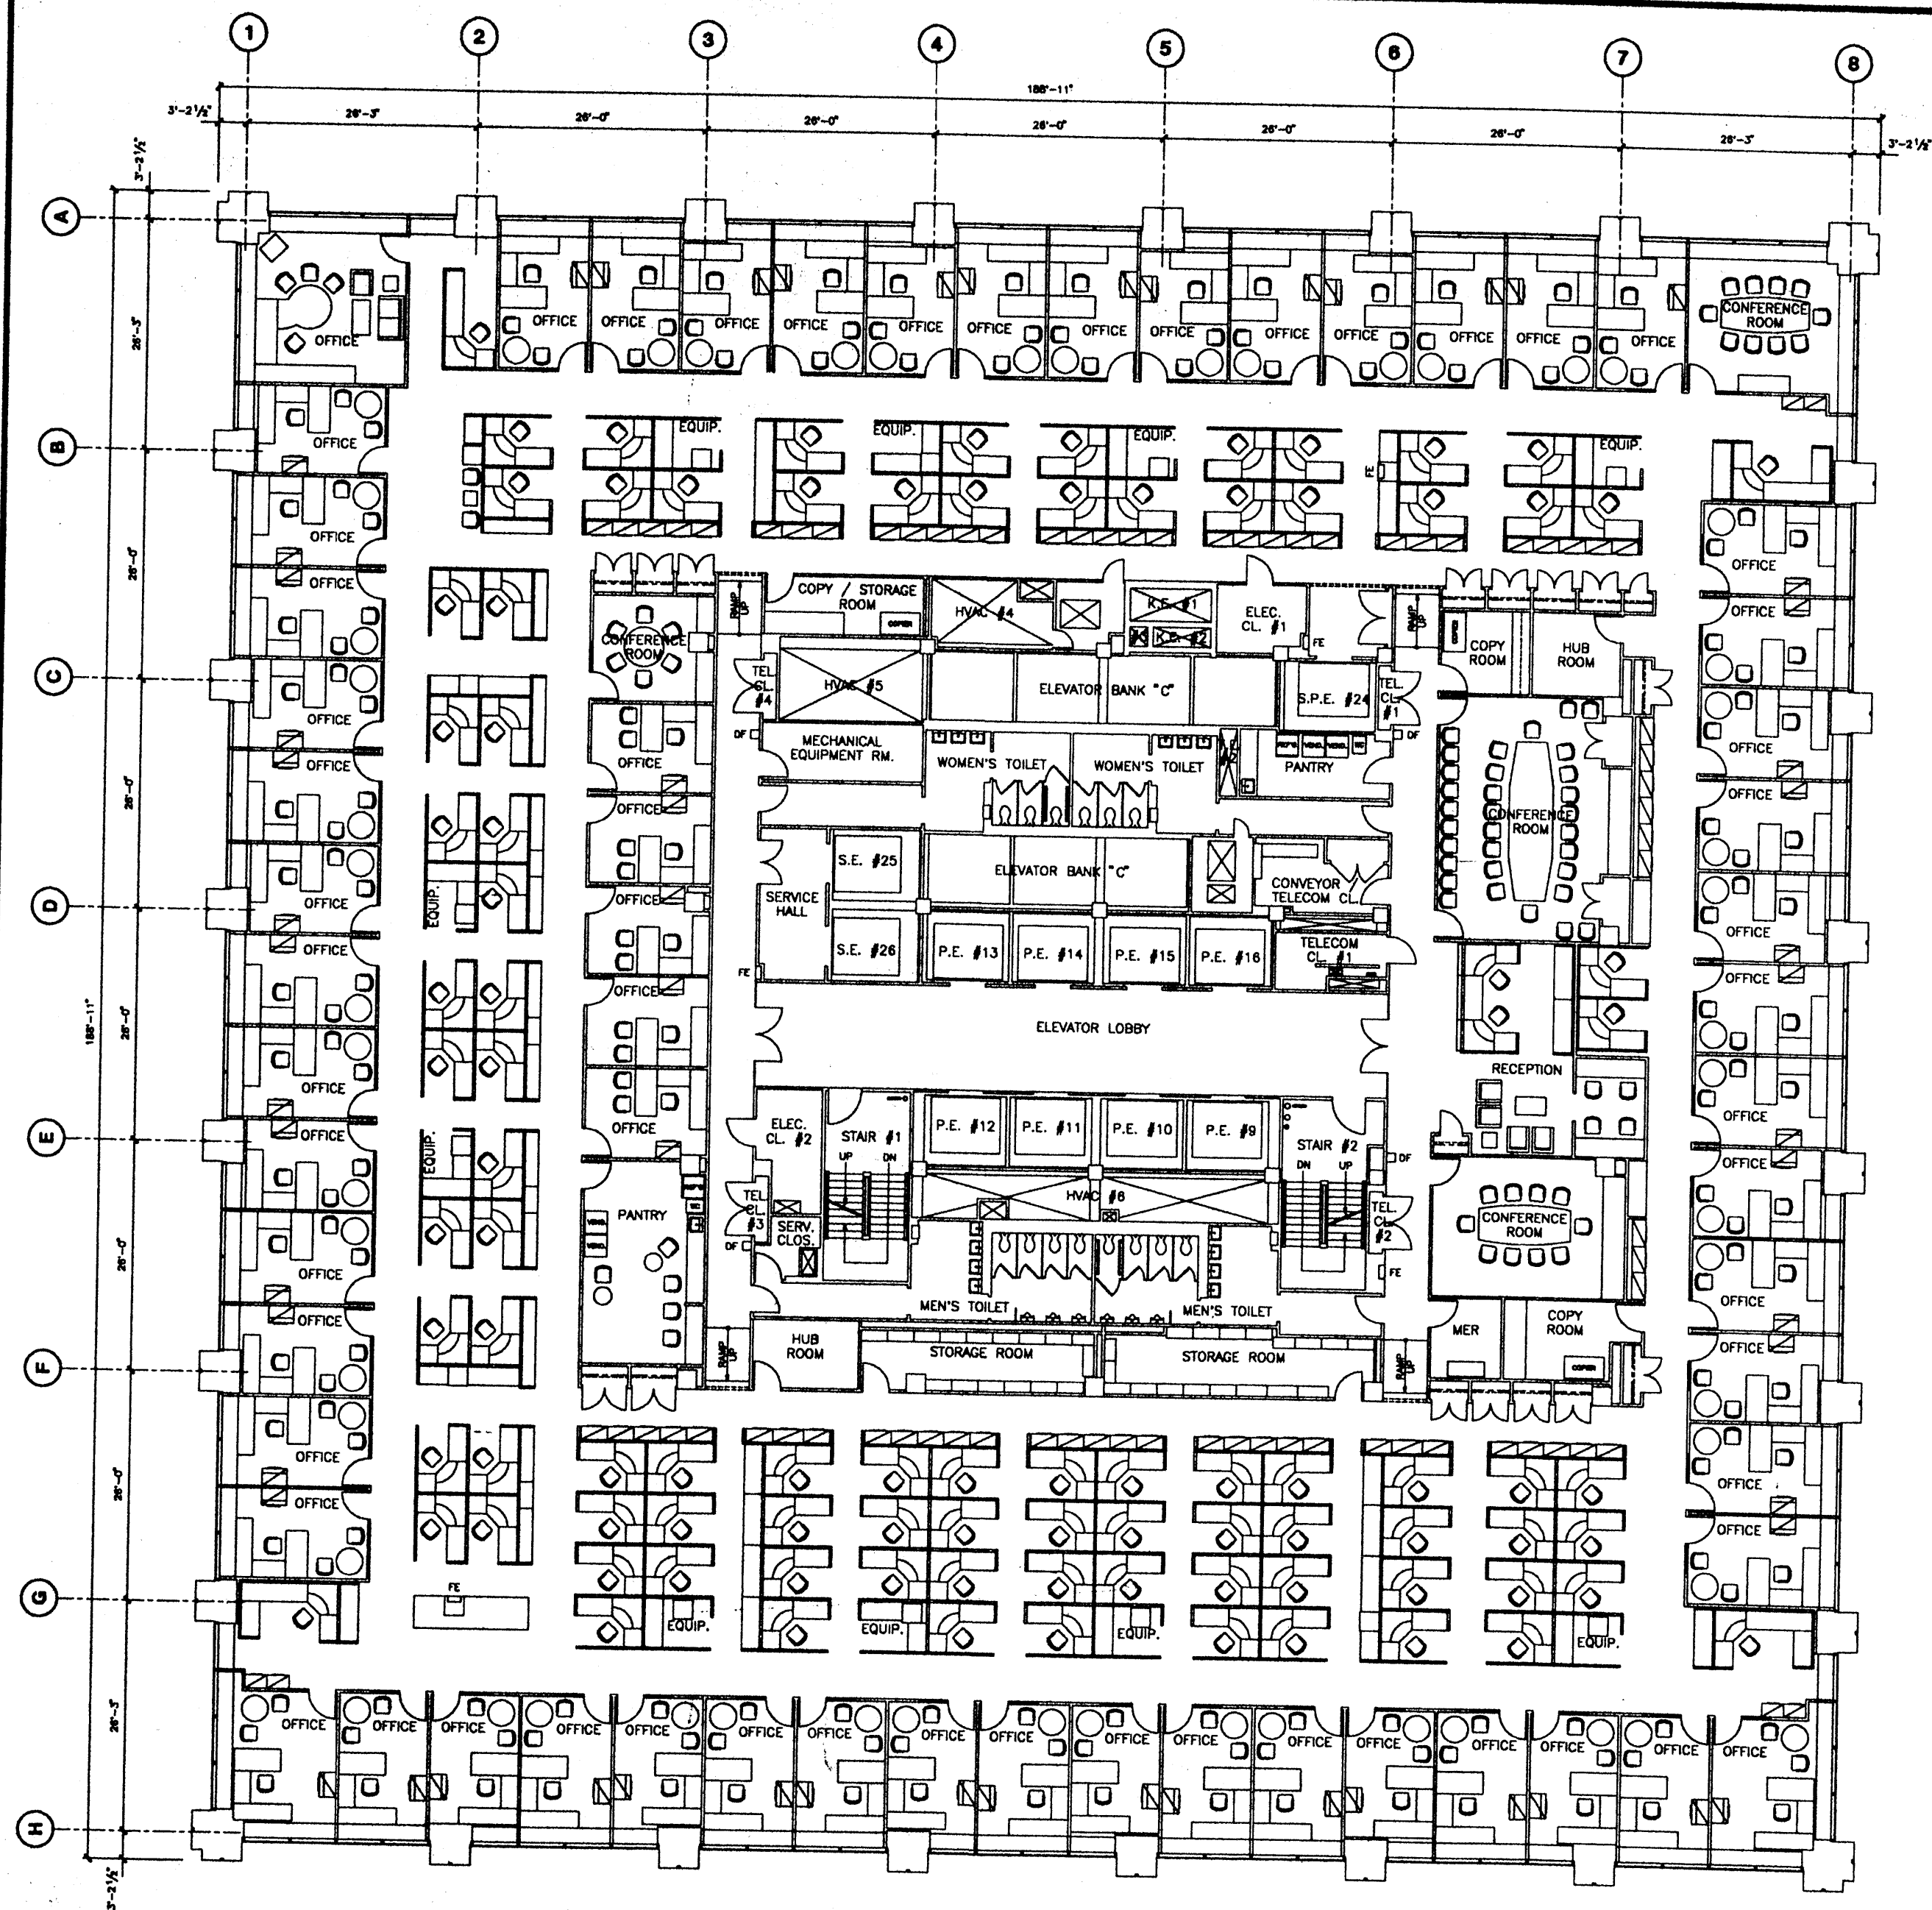


Deutsche Bank

No.	Date	Description
1	12/29/94	Original RECORDS - International Group
2	7/18/98	Updated for Liberty Street Survey
3	8/1/2000	Project RECORDS

130 LIBERTY STREET

24th FLOOR

Drawn By:	Checked By:
Date:	9/1/2000
Scale:	
Project No.:	

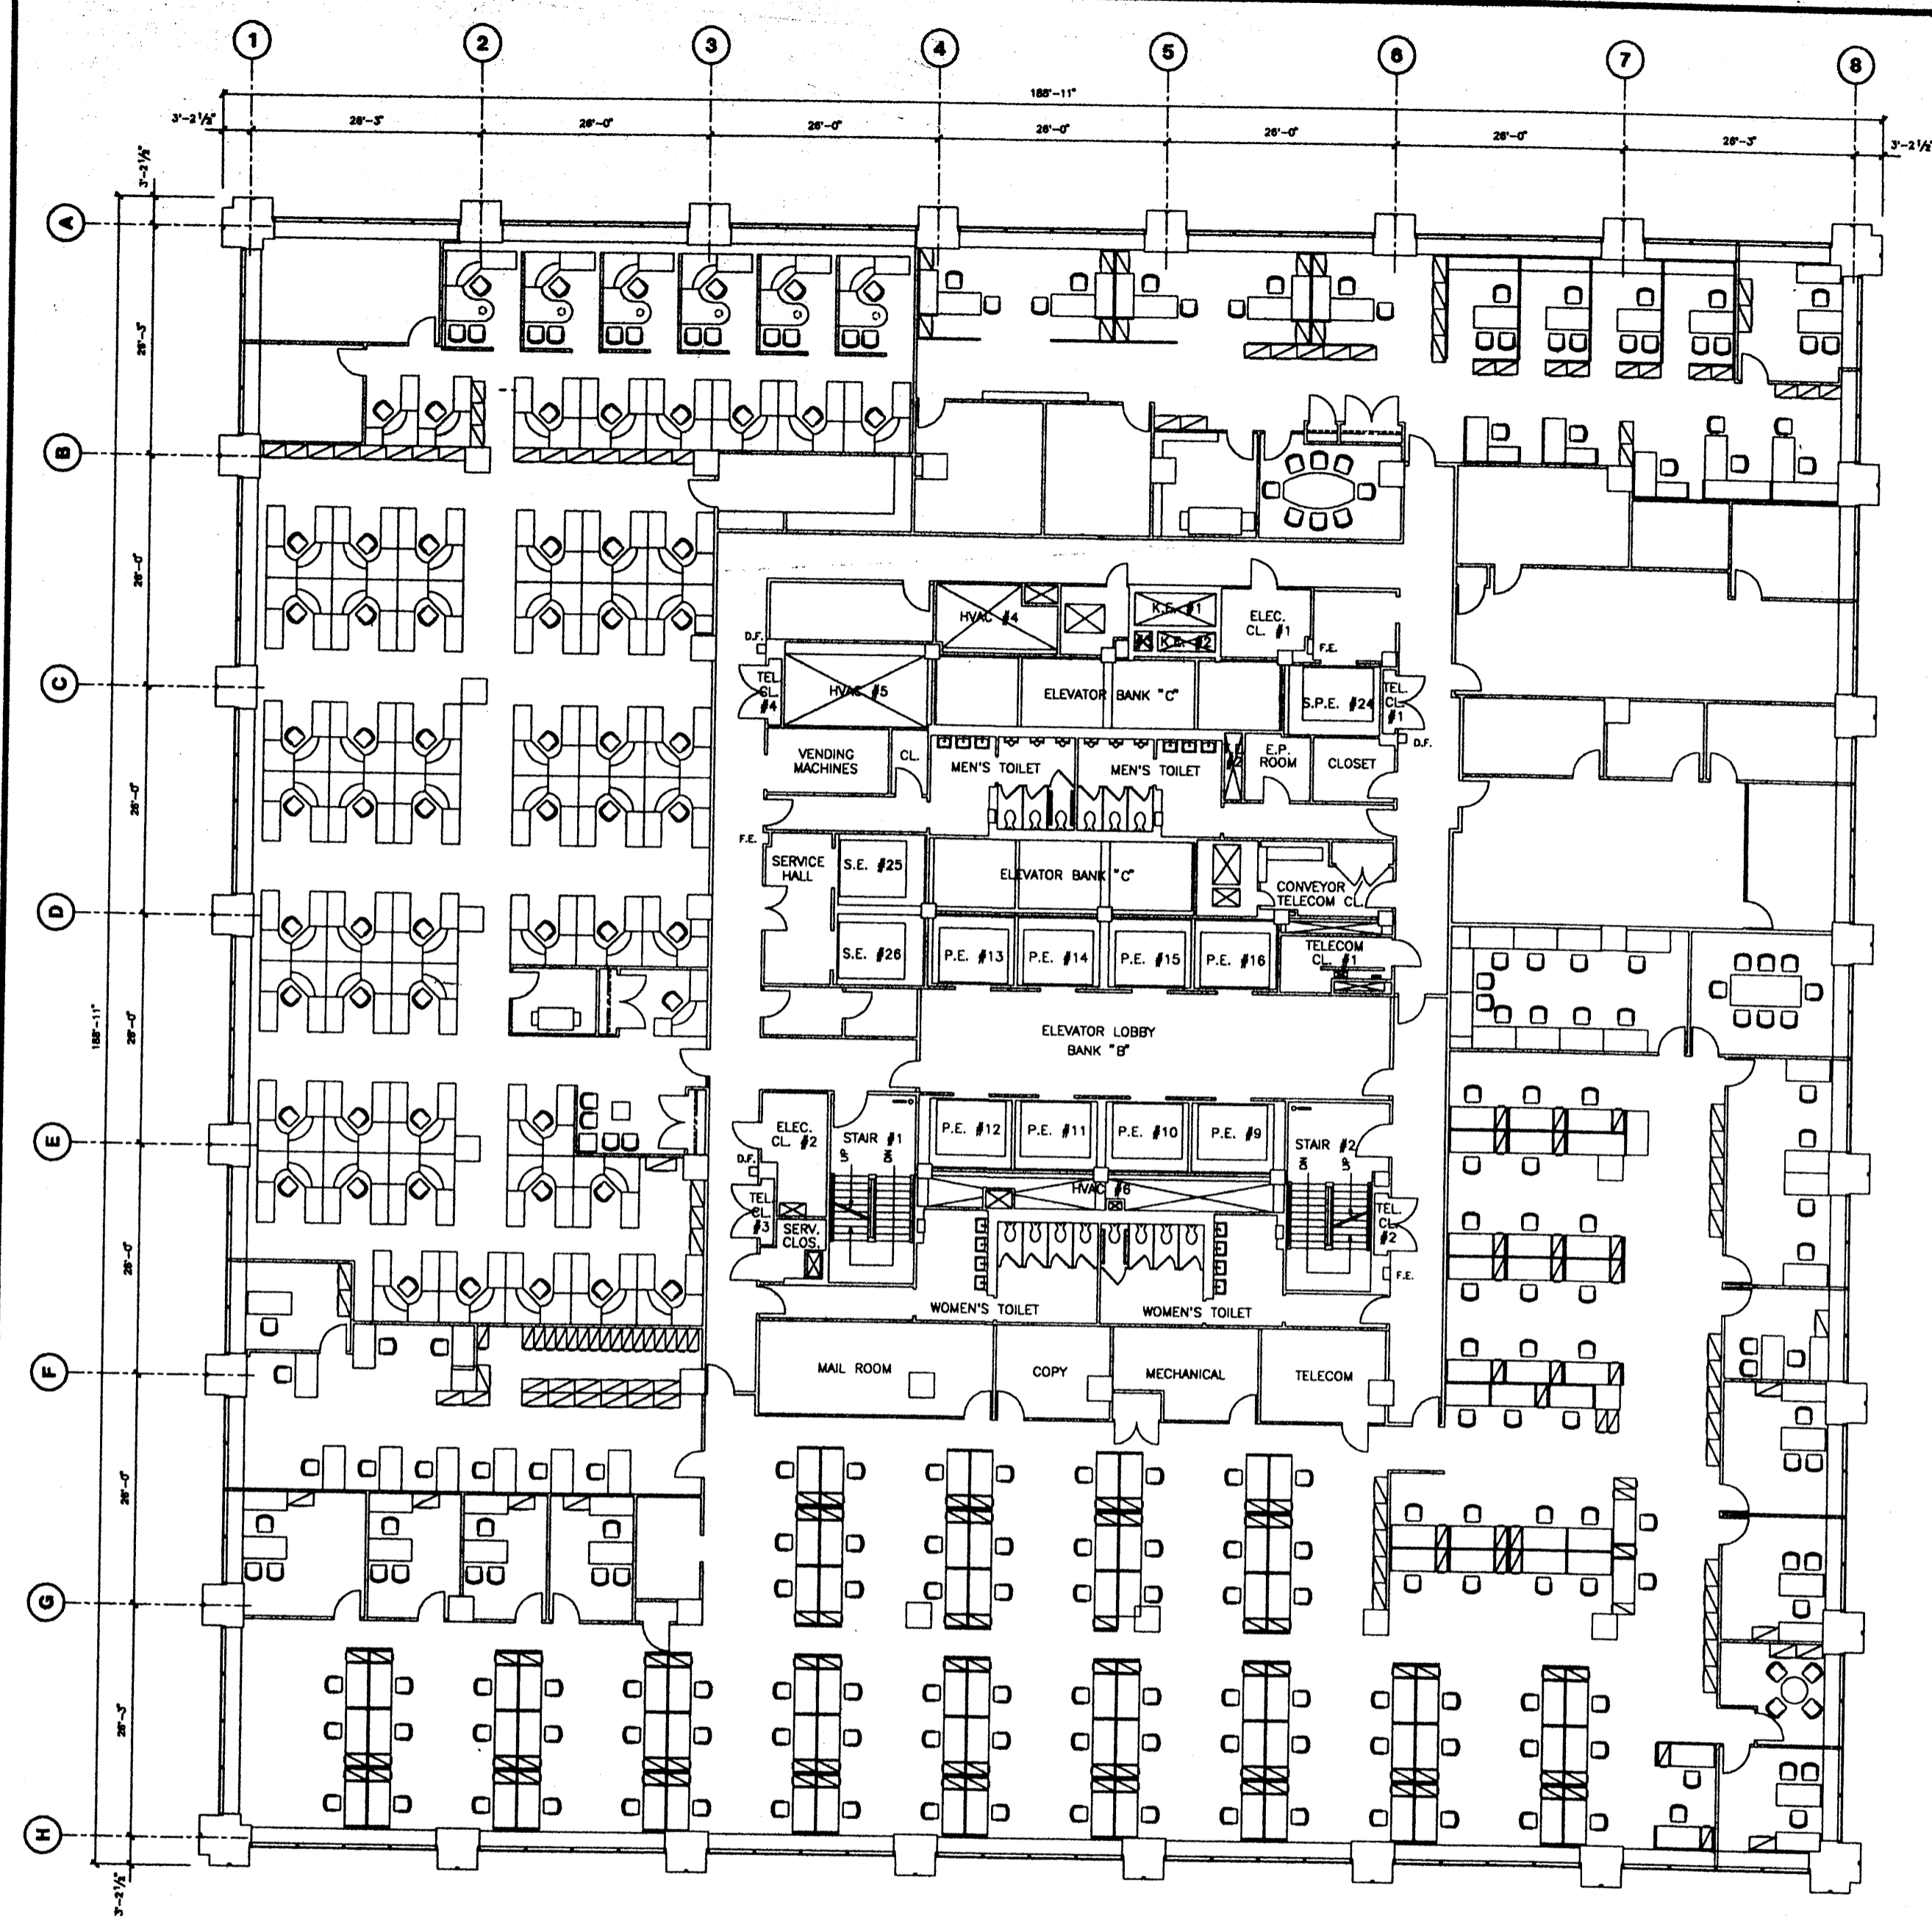

Deutsche Bank


No.	Date	Revised To
1	11/21/94	Project #0000000000 Project #0000000000 Project #0000000000 Project #0000000000
2	3/9/96	Project #0000000000 Project #0000000000 Project #0000000000
3	5/21/96	Project #0000000000 Project #0000000000 Project #0000000000
4	3/25/97	Updated for Existing Conditions
5	7/15/98	Updated for Electric Check Survey

No.	Date	Revised To

PROJECT
130 LIBERTY STREET
23rd FLOOR

Drawn By	Checked By
Date	7/15/98
Scale	
Project No.	



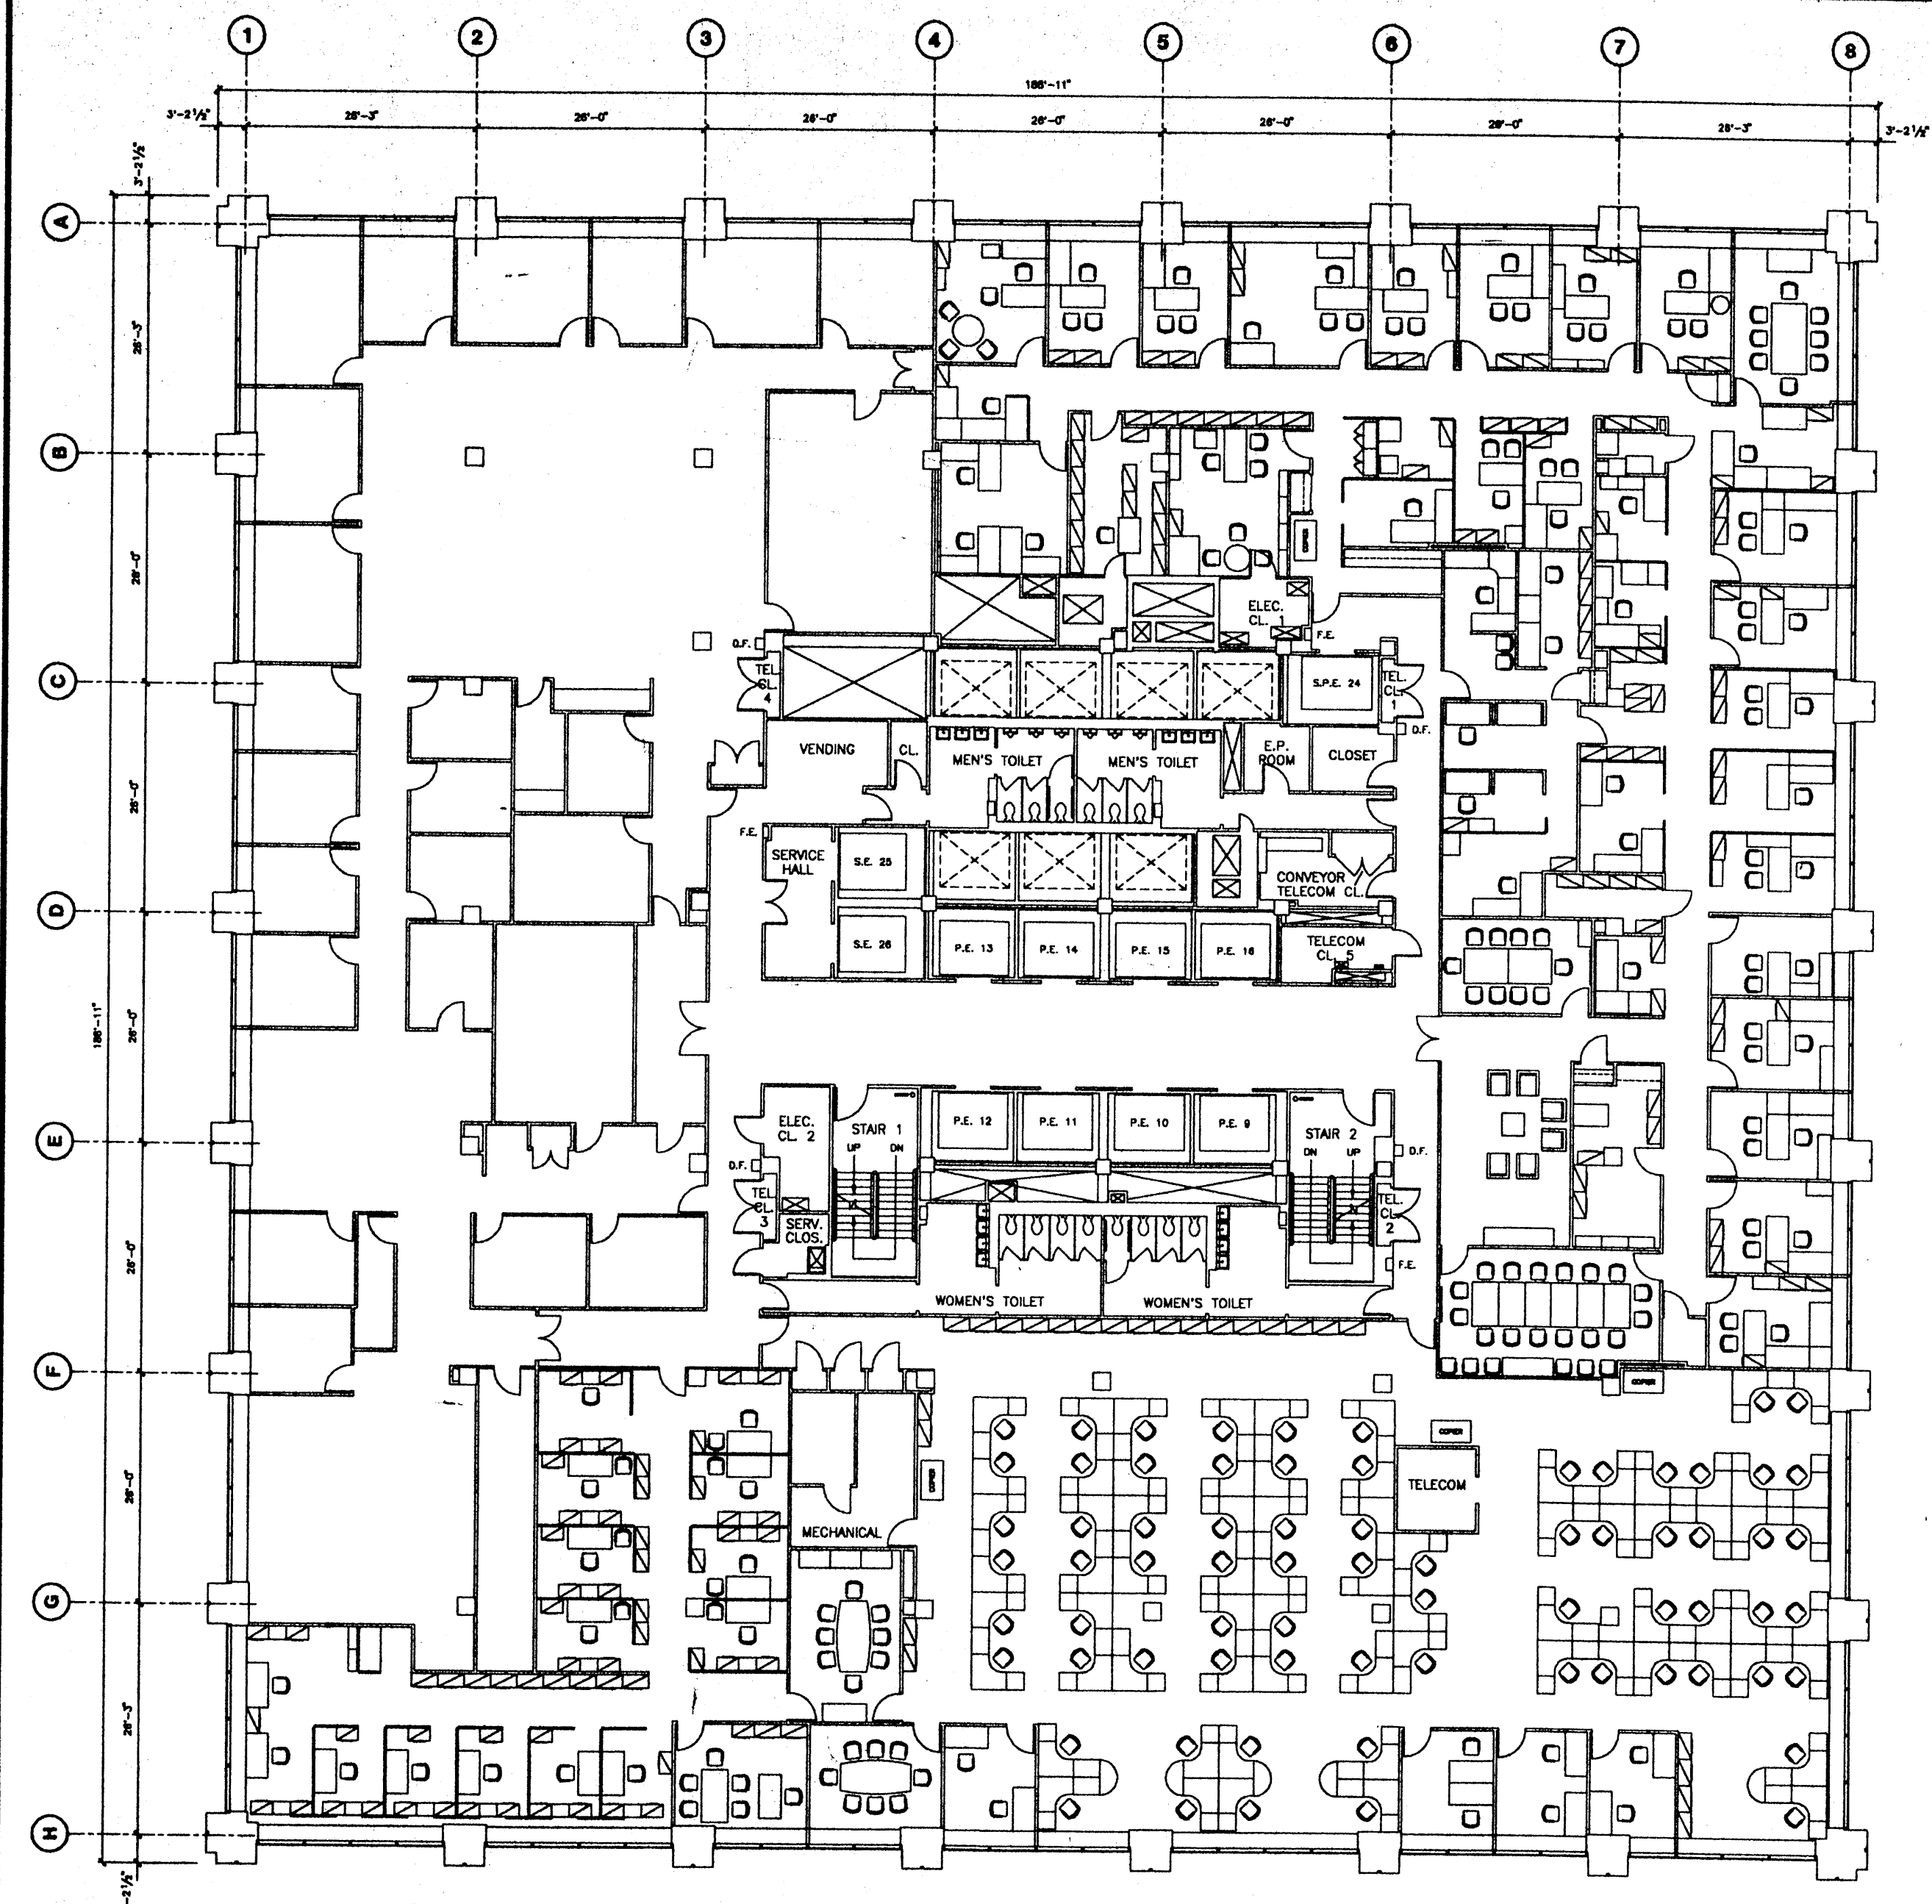

Deutsche Bank

No.	Date	Revised By
1	1/2/94	Project Architect DB Technology Services
2	5/2/95	Project Architect DB Technology Services
3	5/1/97	Project Architect DB Technology Services
4	7/15/98	Updater for Deutsche Bank
5	5/1/01	Updater for Building Conditions


No.	Date	Revised By

130 LIBERTY STREET

22nd FLOOR



Author	Checked
Date	5/1/01

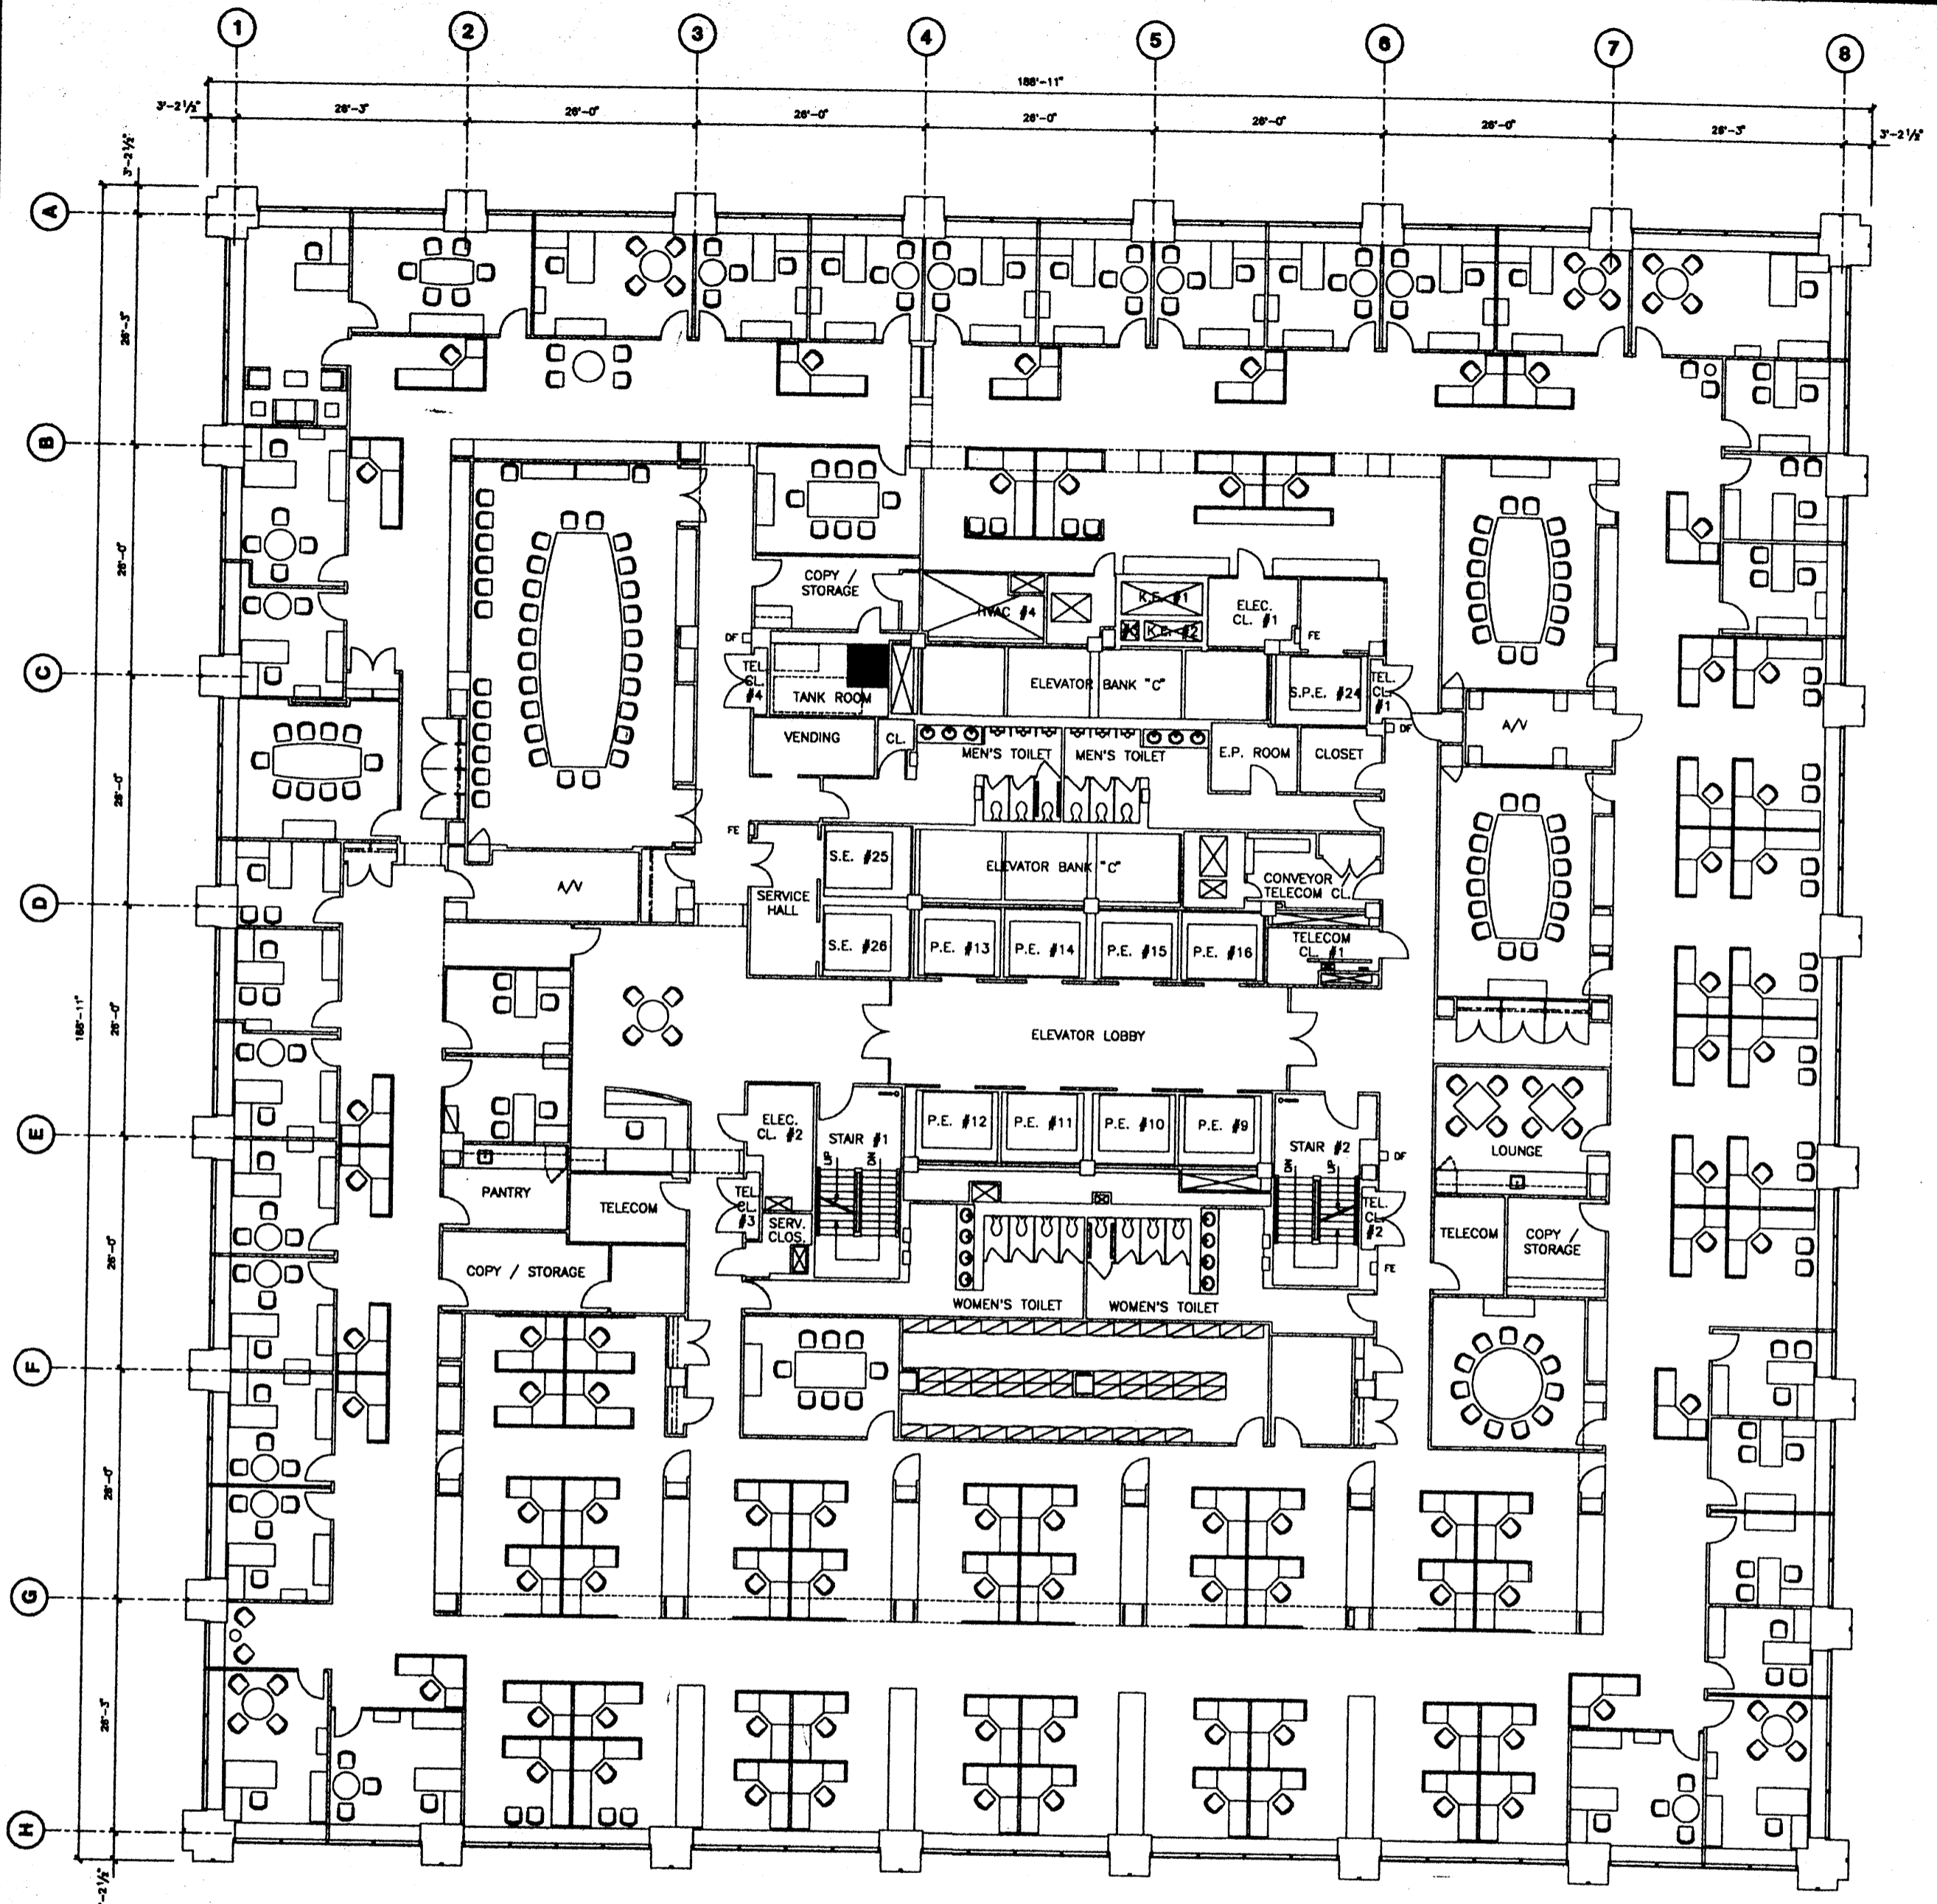

Deutsche Bank

No.	Date	Description
1	4/1/99	Update Furniture and Plan Details
2	4/1/99	Project No. 88000214 - Update Lighting System
3	7/15/98	Updated for Deutsche Bank Review
4	4/21/99	Project No. 87000144 - Full Floor Renovation

No.	Date	Revised To

130 LIBERTY STREET

21st FLOOR

Drawn by	
Checked by	
Date	4/21/99
Project No.	





No.	Date	Description
1	6/7/95	Original 20th Floor Lighting Schematic
2	6/1/97	Project #00000514 Lighting Layout
3	6/15/97	Project #00000523 Refinement Schematic
4	7/15/98	Updated for Electric Board Utility

By	Date	Issued To

PROJECT
130 LIBERTY STREET
20th FLOOR

Drawn By	Checked By
Date	7/15/98
Scale	
Project No.	

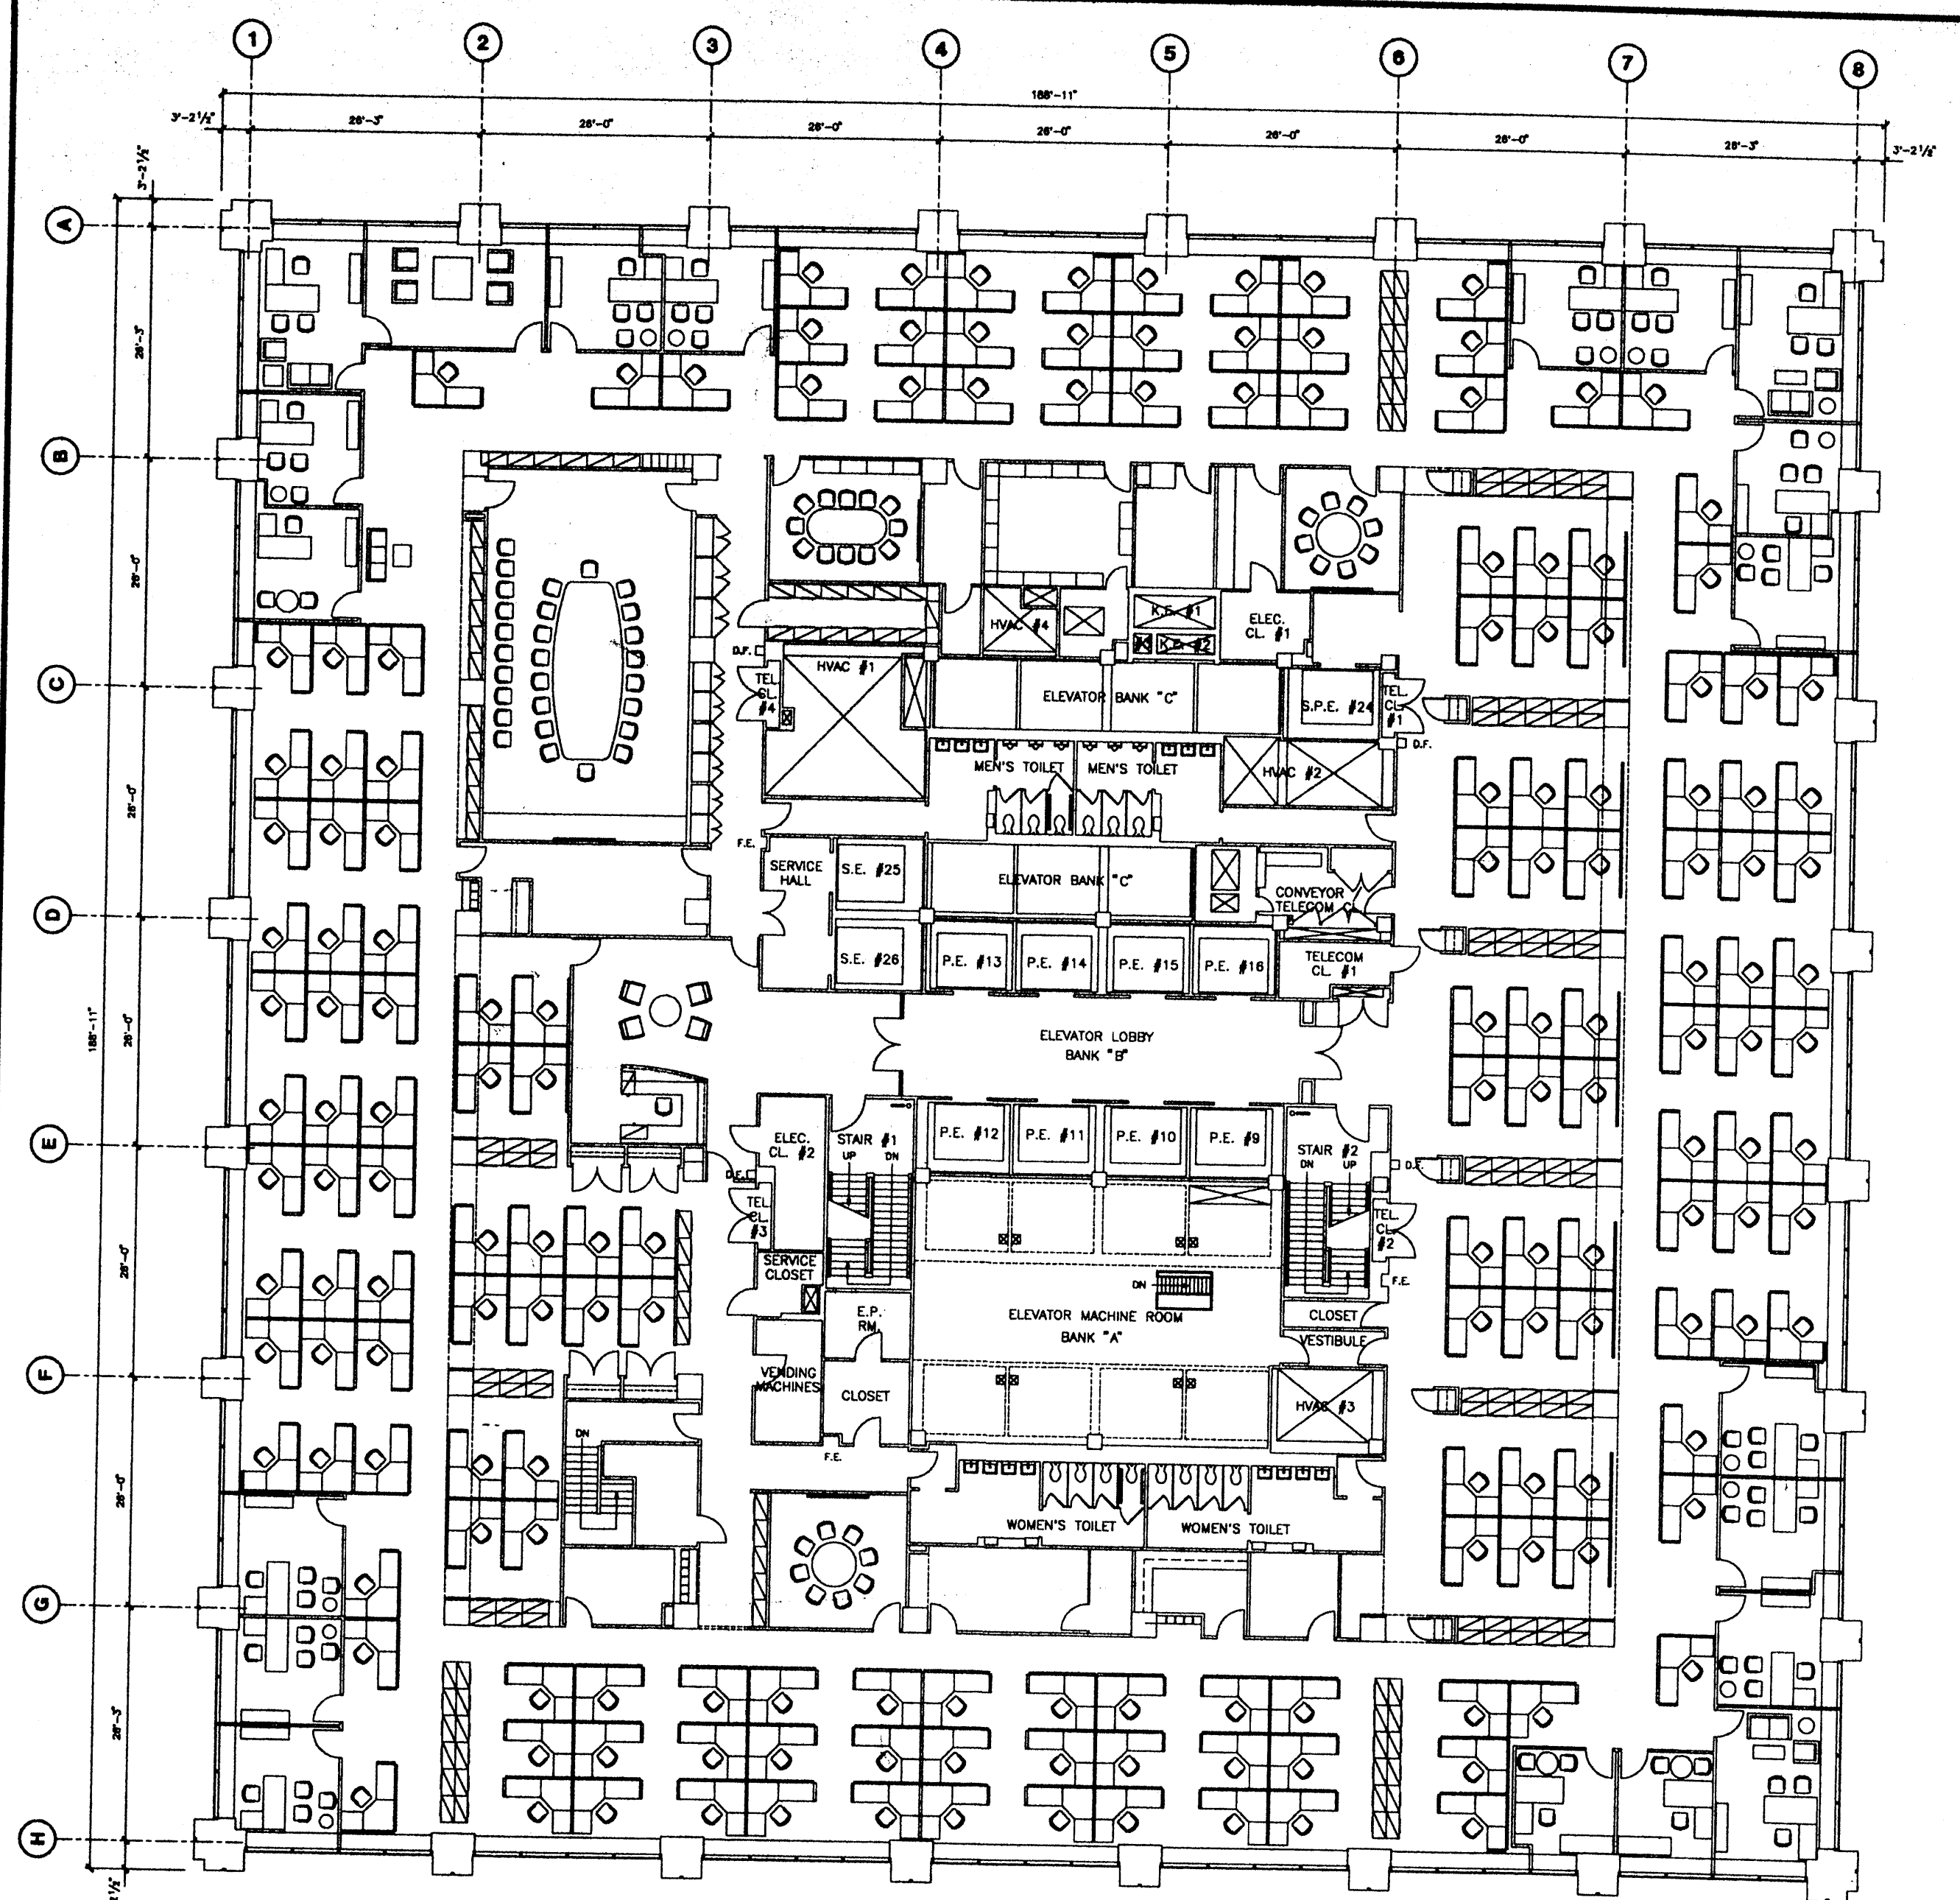

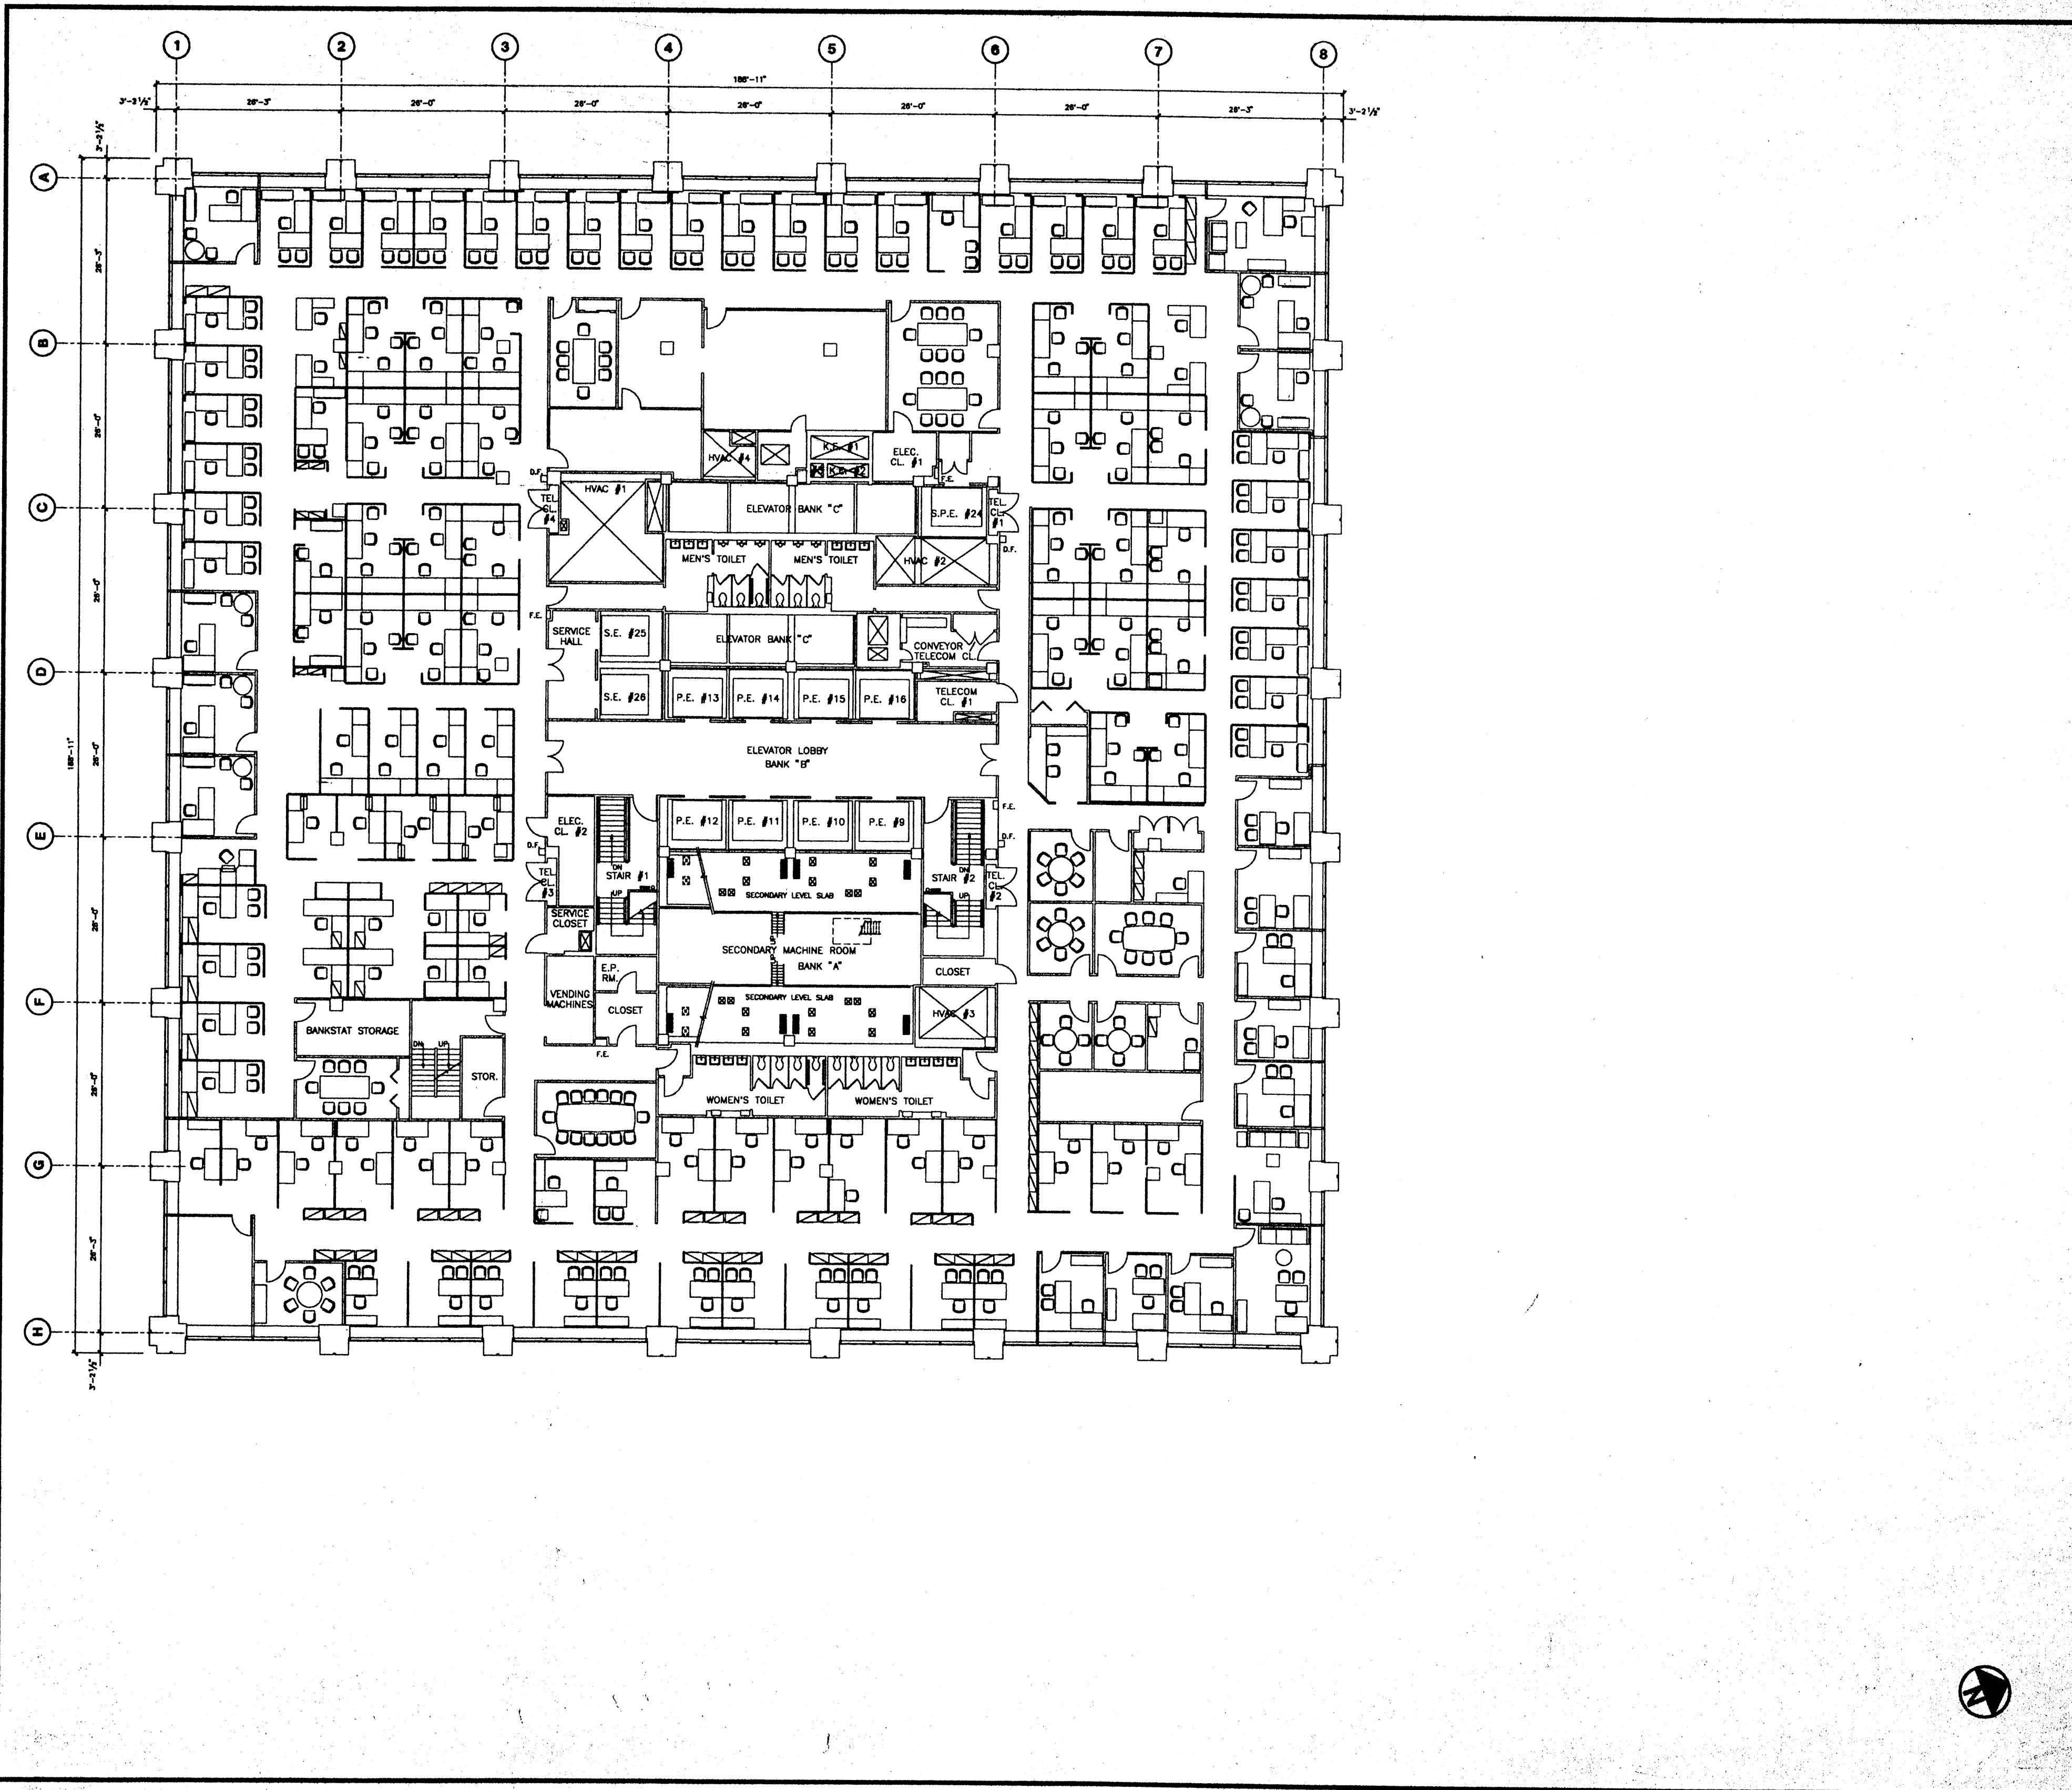

Deutsche Bank


No.	Date	Description
1	12/1/82	Initial floor plan - 19th Floor, New York
2	5/1/83	Update: Furniture per latest program
3	5/1/87	Update: Furniture per latest program - Update Lighting Layout
4	7/15/88	Updated for Electric Plant System
5	8/15/89	Updated for Conference Room

130 LIBERTY STREET

19th FLOOR

Drawn By	Checked By
Scale	Date
Project No.	Sheet No.



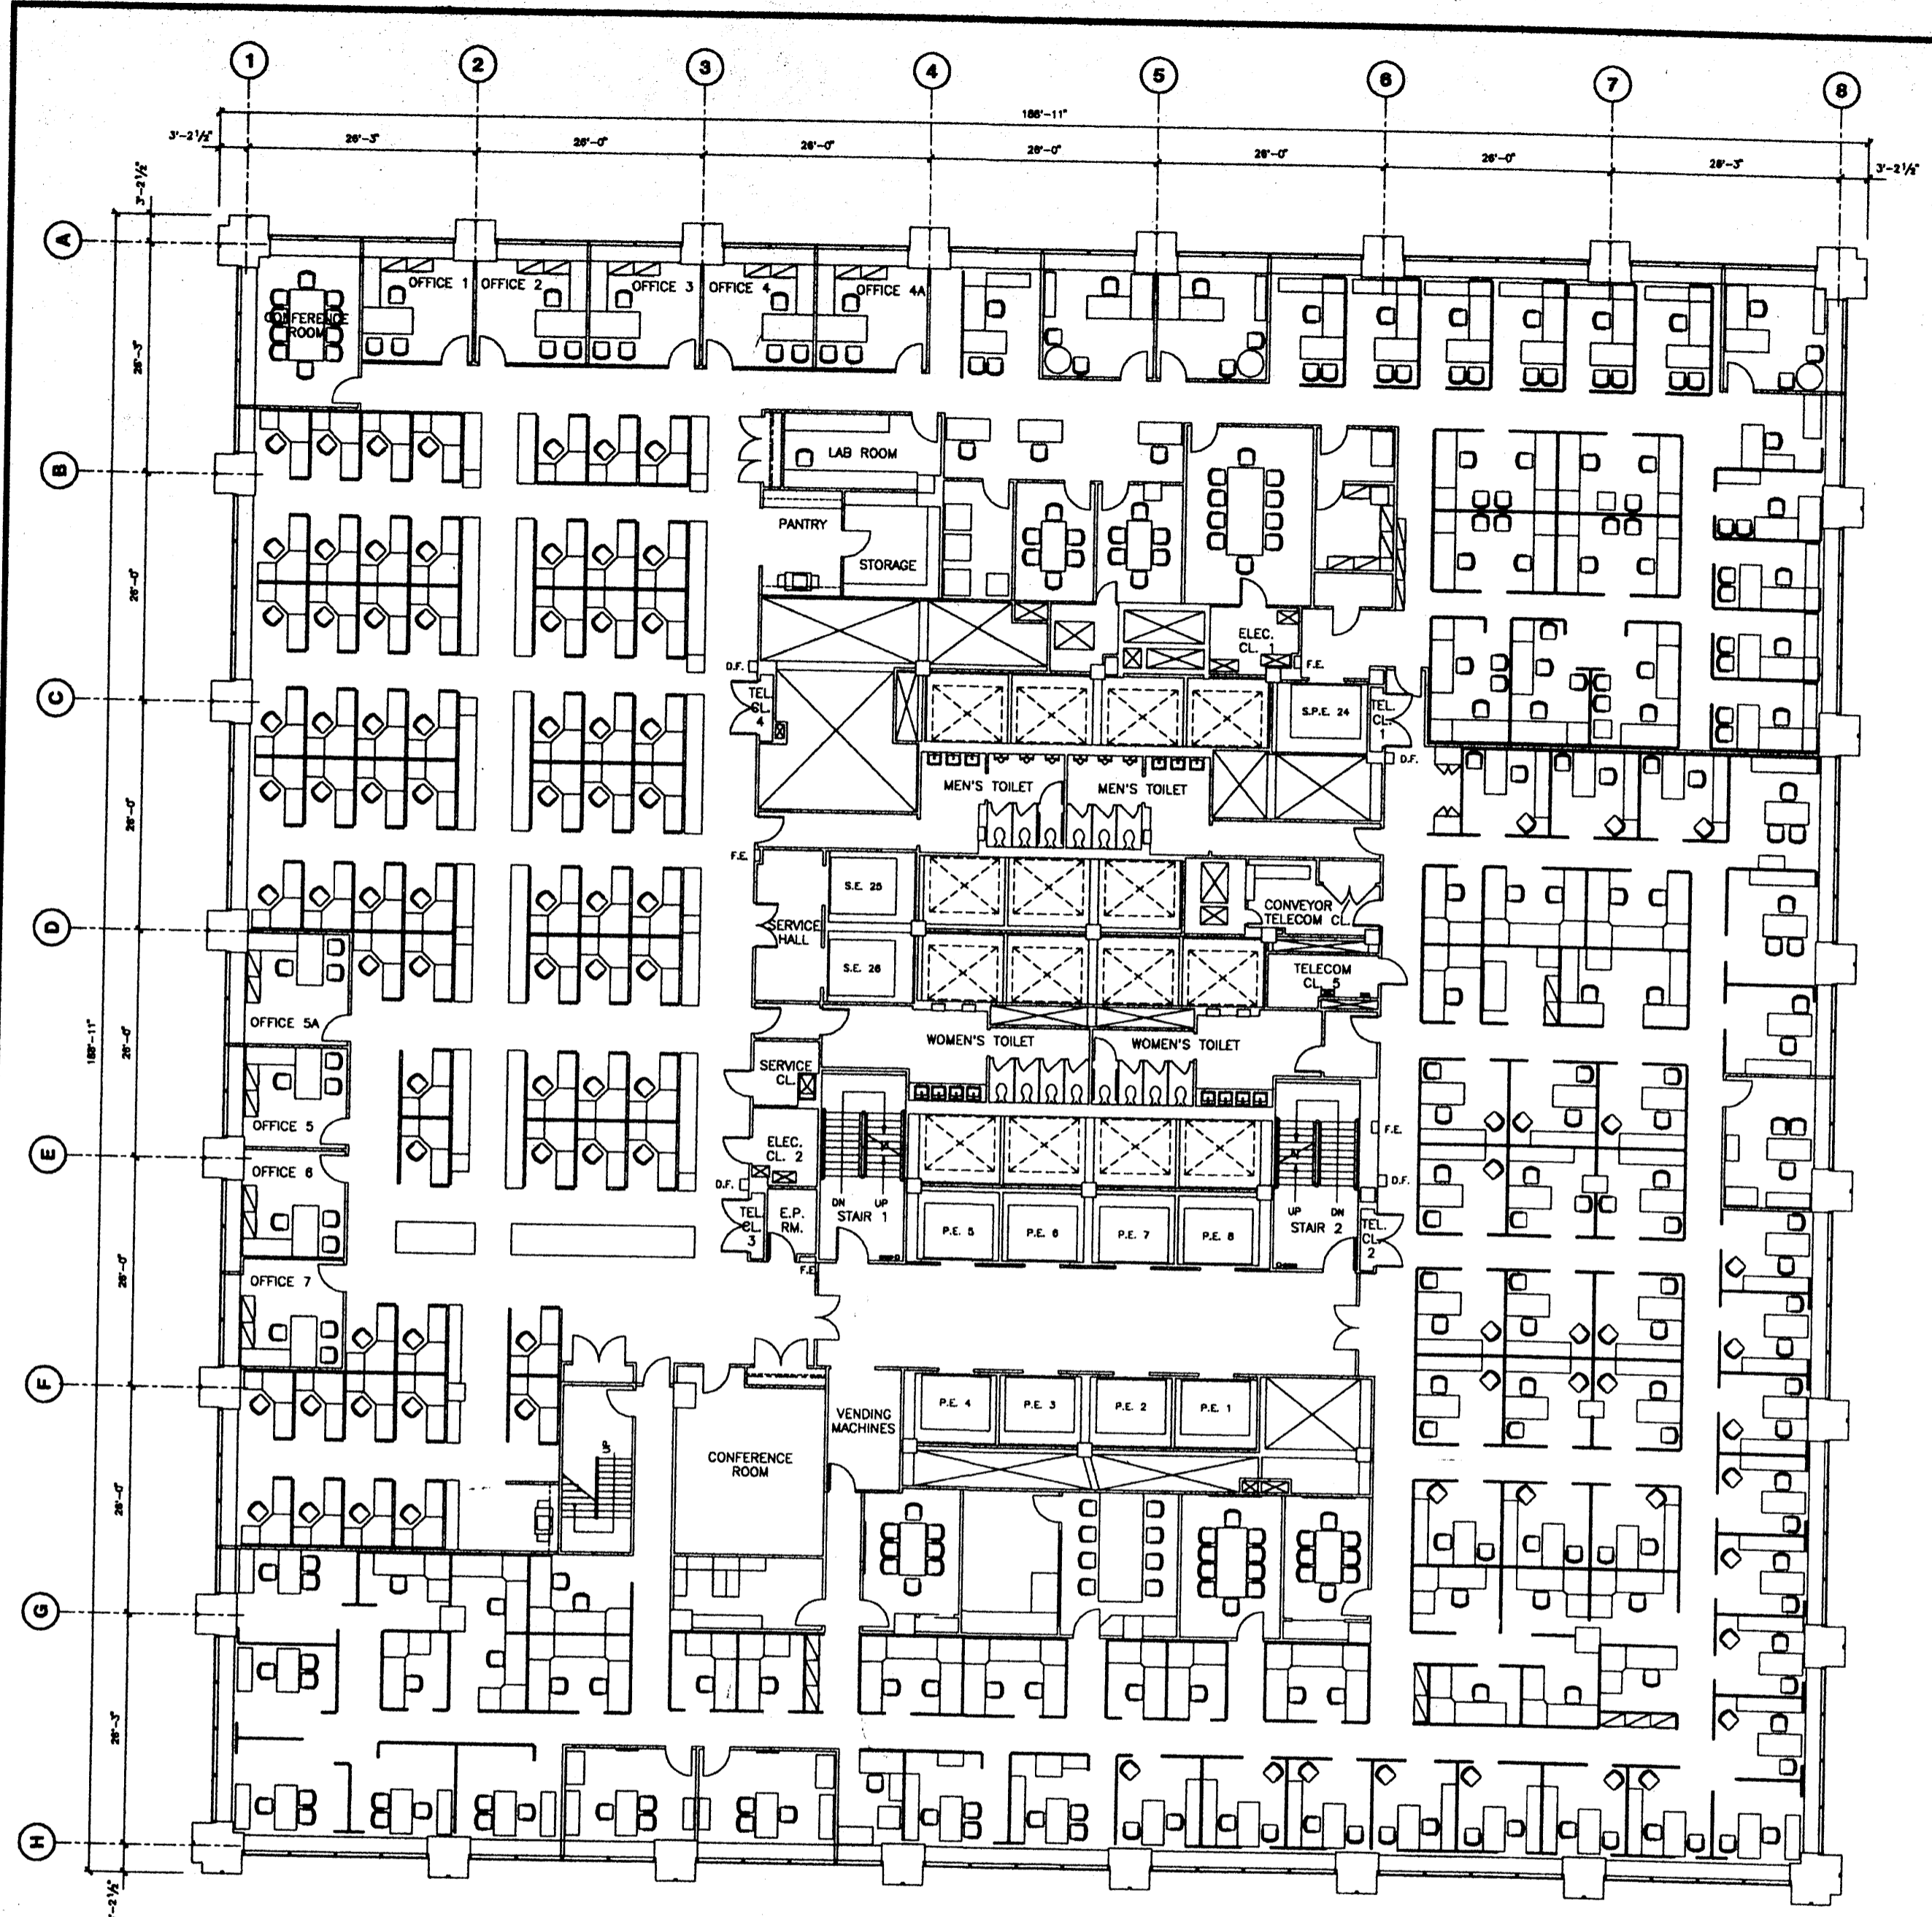

Deutsche Bank


No.	Date	Description
1	1/1/97	Project No. 180000000 Original Working Layout
2	7/15/98	Updated for Deutsche Credit Service
3	8/15/98	Revised Ruledroom Portals of Part

No.	Date	Revised To

130 LIBERTY STREET
18th FLOOR


Drawn By		Checked By	
Date	8/15/98		
Project No.			



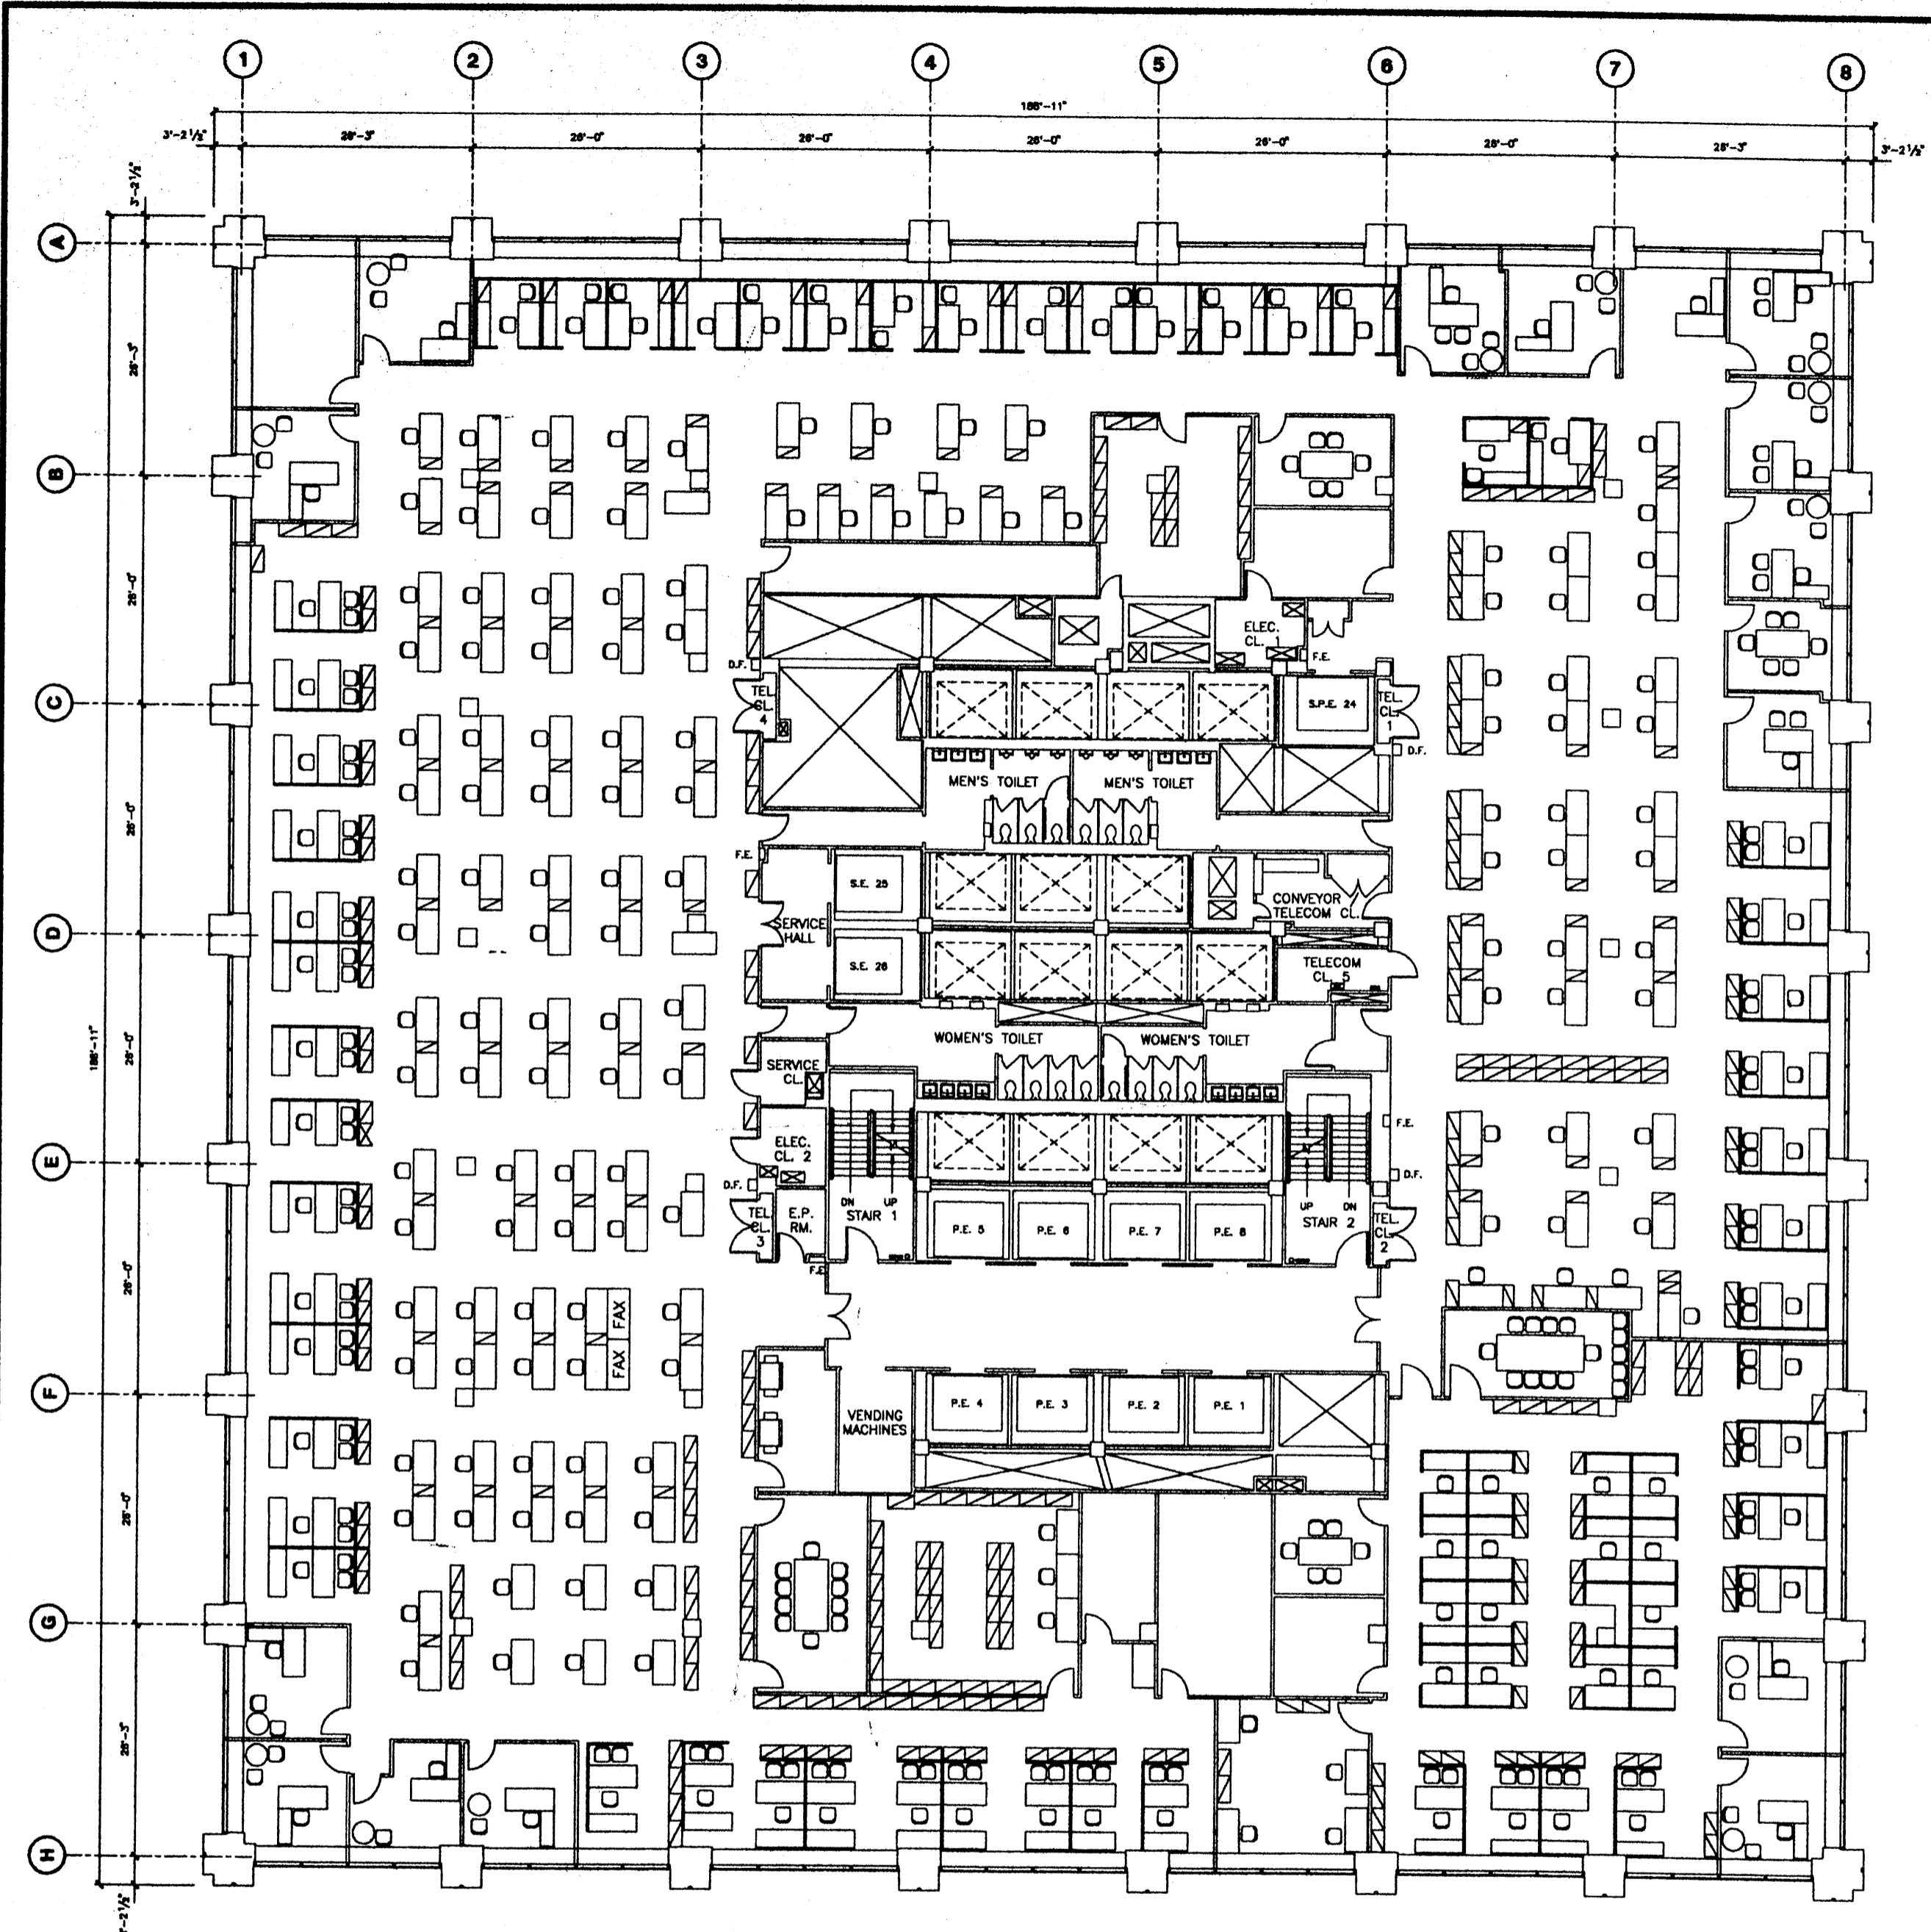

Deutsche Bank

Rev.	Date	Issued To
1	7/18/98	Updated for Opening Glass Balcony

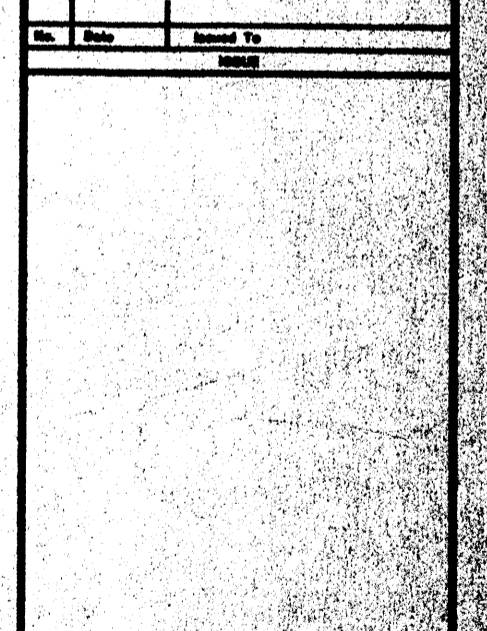


130 LIBERTY STREET

17th FLOOR



Drawn By	Checked By
Scale	Date
Project No.	

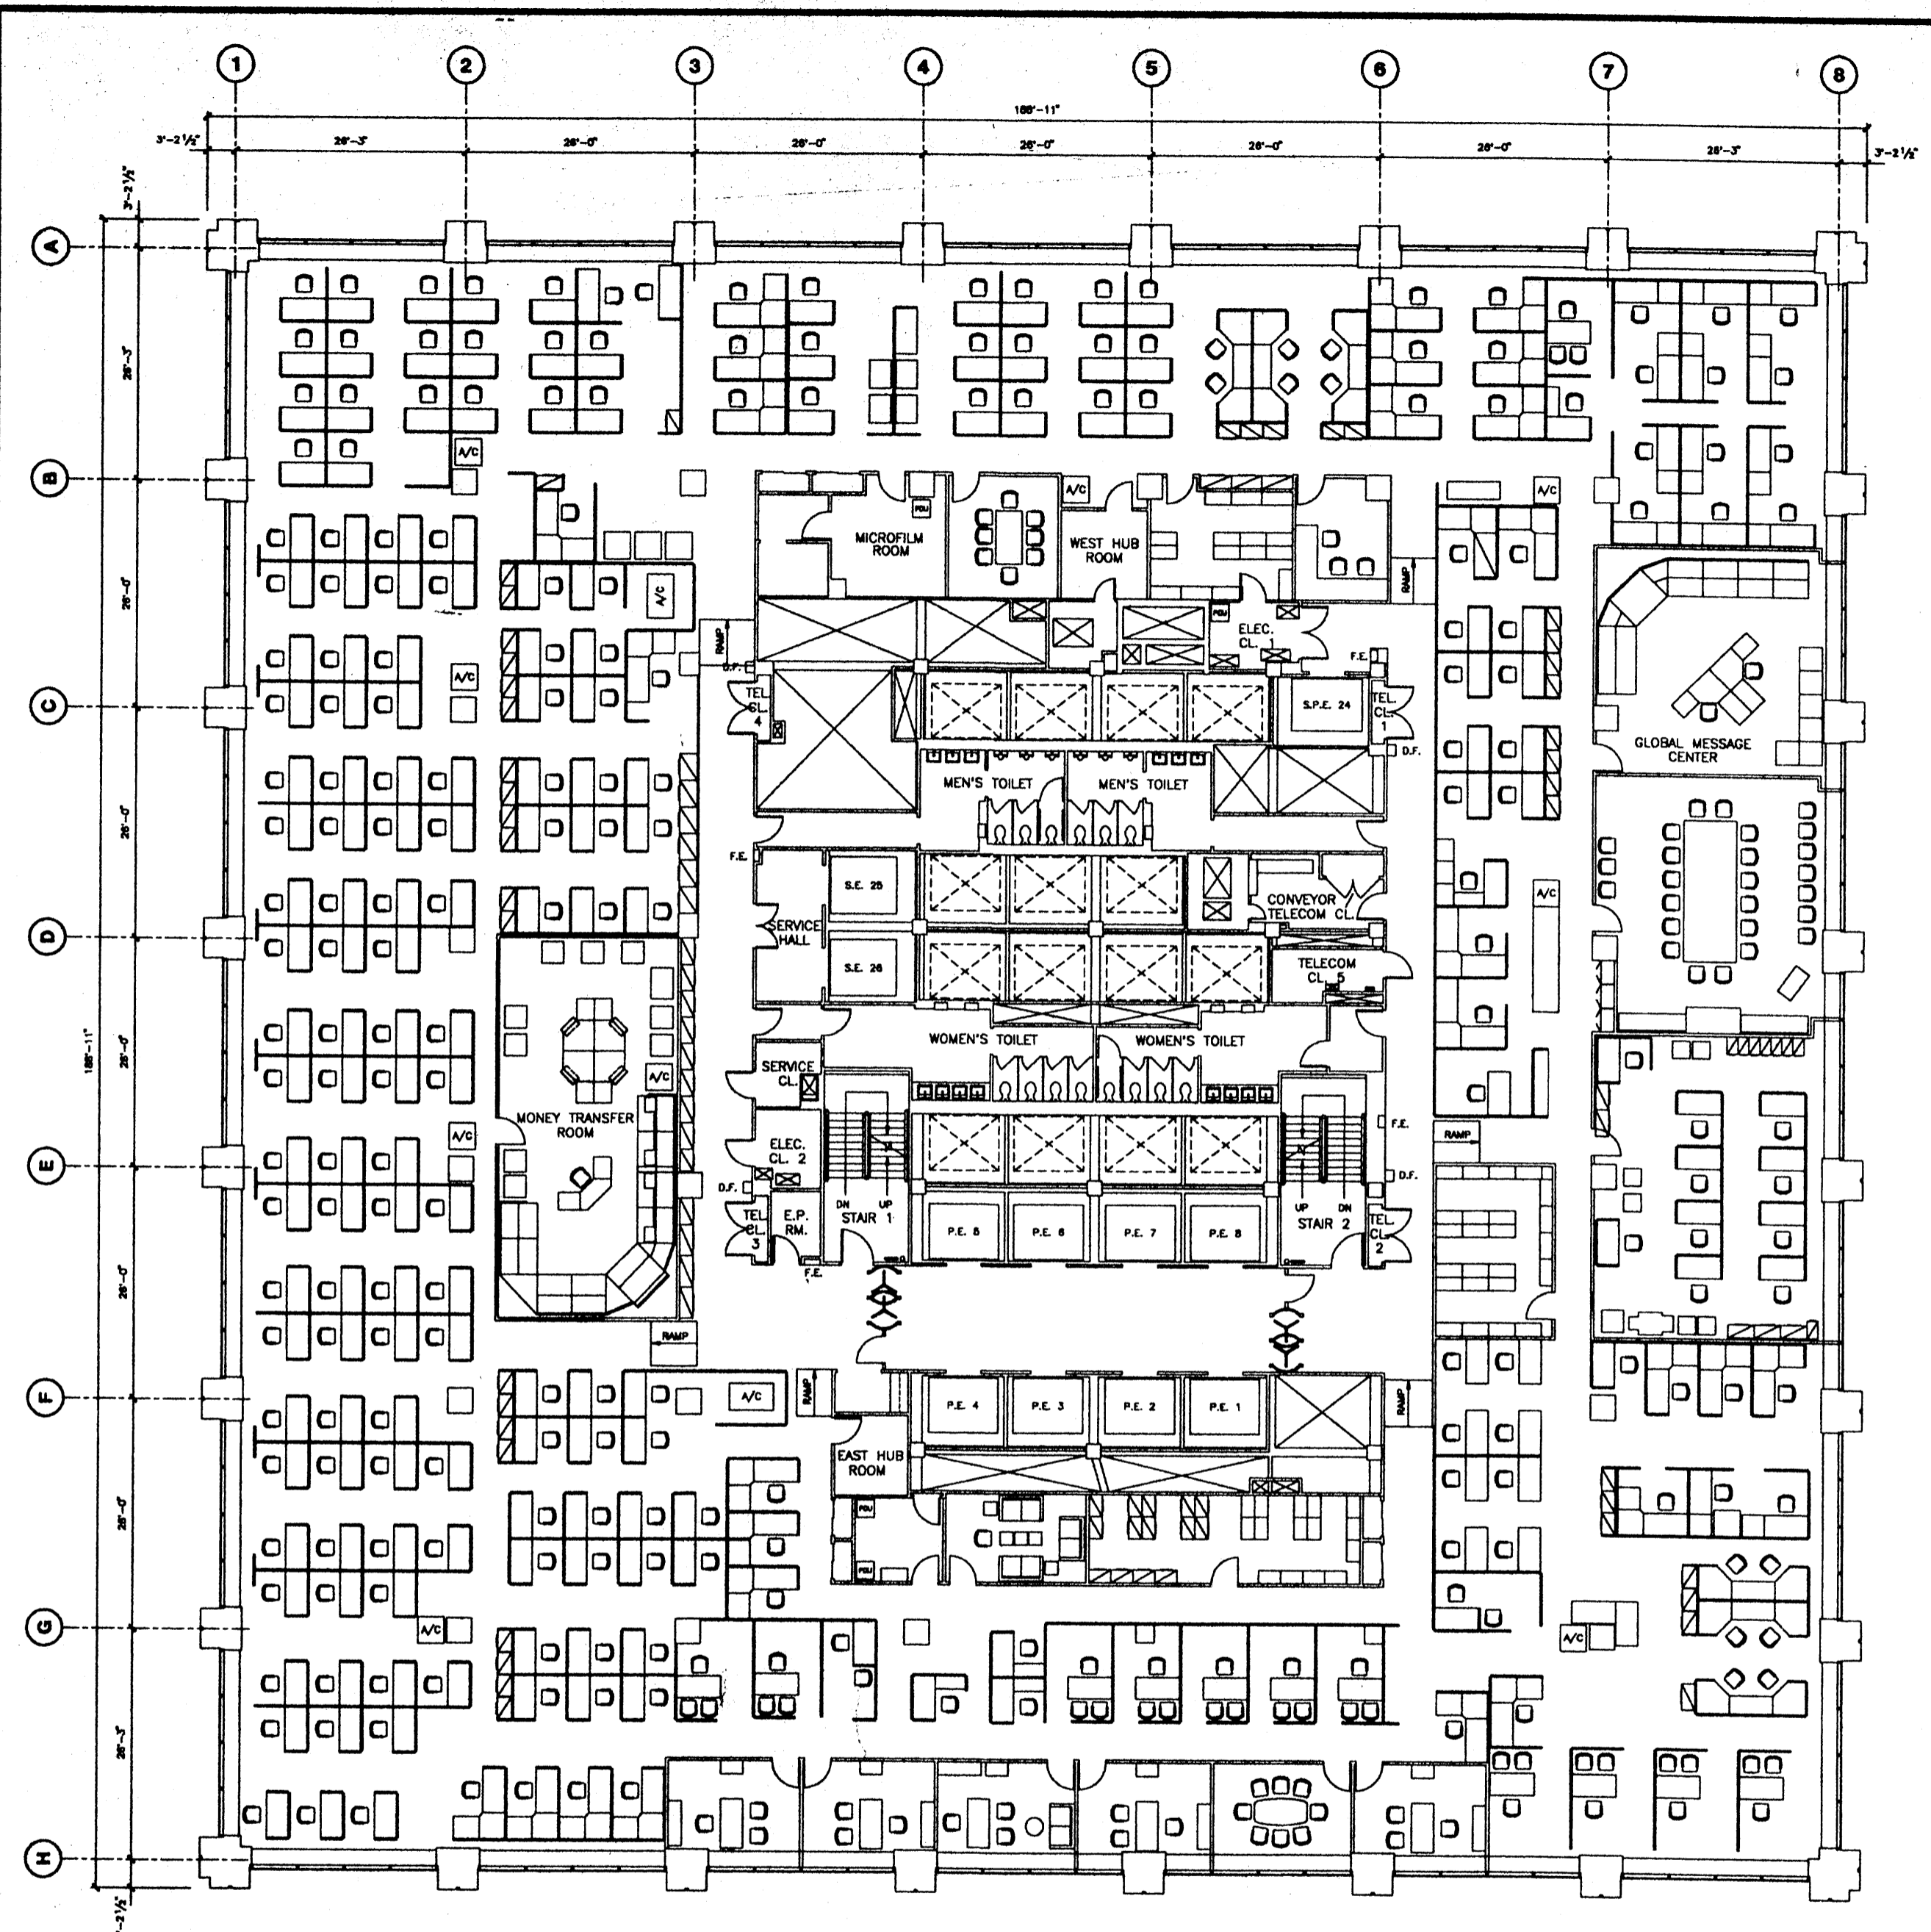

Deutsche Bank

No.	Date	Description
1	8/18/94	Furniture Layout and Area Number
2	8/1/97	Project No. 870002334 Update: Update Layout
3	7/15/98	Update for Deutsche Credit Center
4	1/20/99	Project No. 870002343 L. Update: Furniture Reorganization


No.	Date	Issued To

130 LIBERTY STREET

16th FLOOR

Drawn By	
Checked By	
Date	1/20/99
Scale	
Project No.	



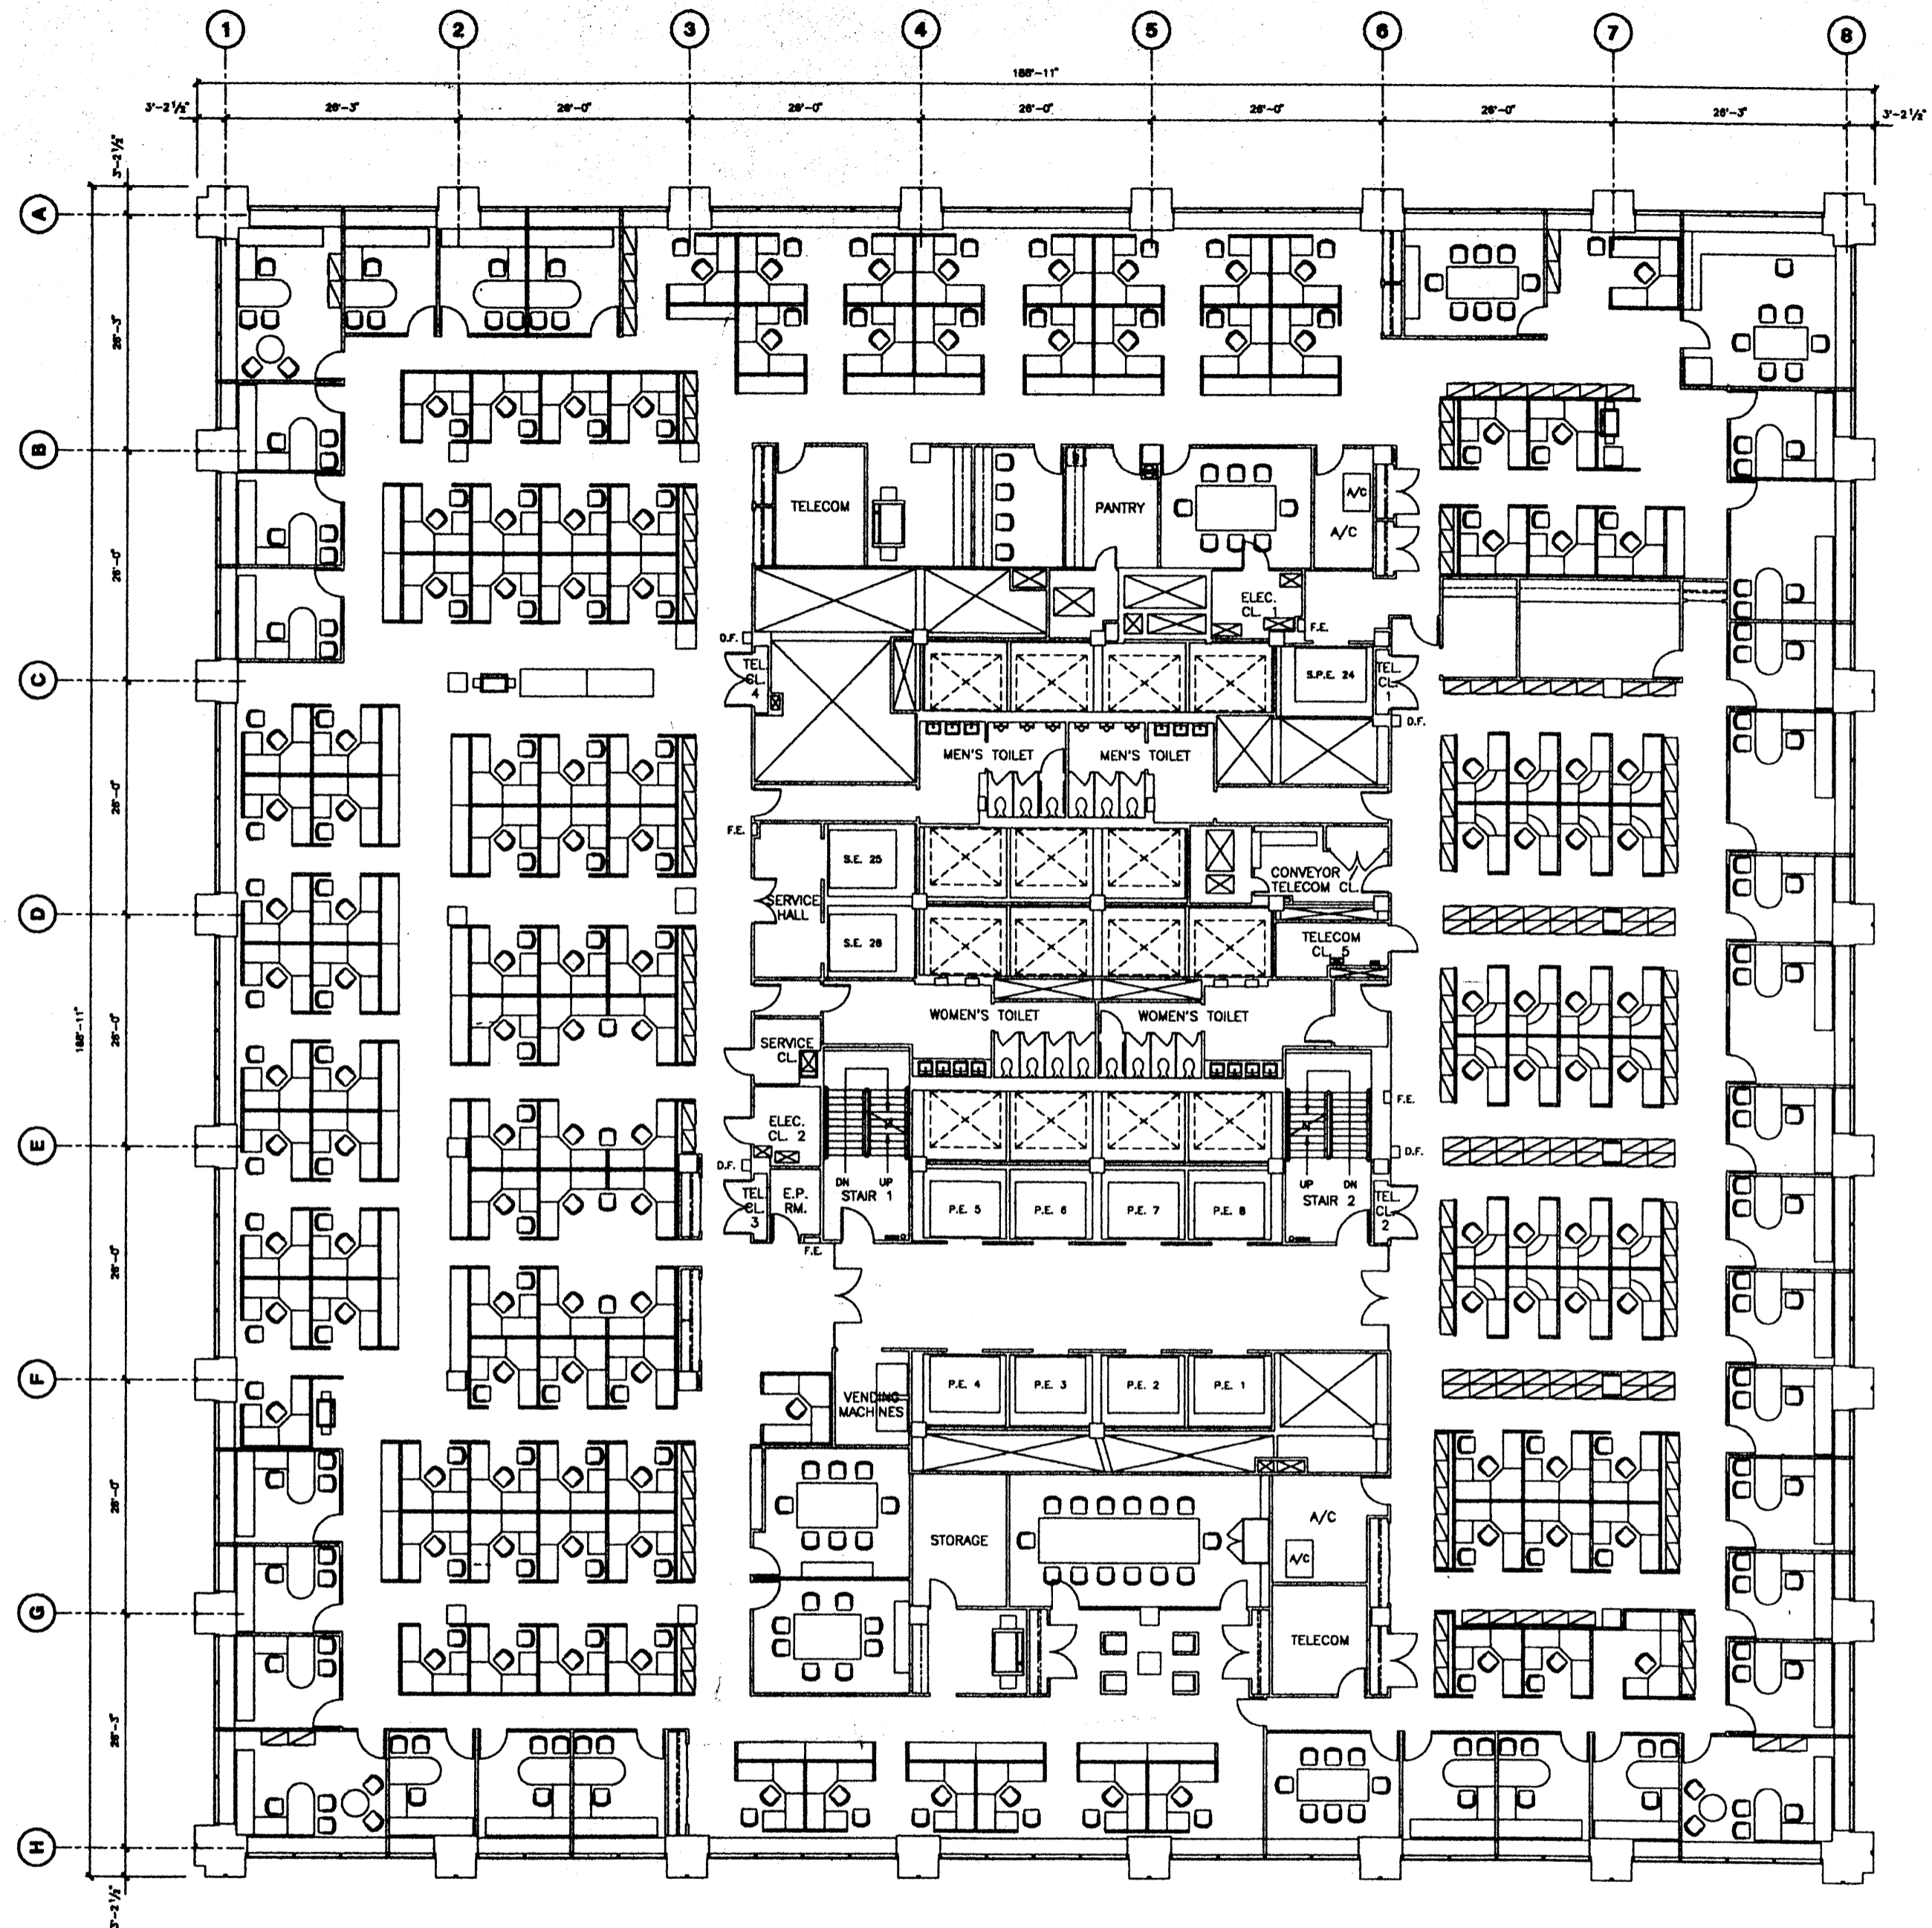

Deutsche Bank

No.	Date	Revised To
1	1/1/82	Original Construction
2	12/1/82	Update for Electrical and Mechanical
3	6/7/84	Update for Electrical and Mechanical
4	6/1/87	Update for Electrical and Mechanical
5	1/7/88	Update for Electrical and Mechanical
6	7/15/88	Update for Electrical and Mechanical
7	6/1/91	Update for Electrical and Mechanical


No.	Date	Revised To

130 LIBERTY STREET

15th FLOOR

Drawn By	Checked By
Date	8/1/01
Scale	
Project No.	



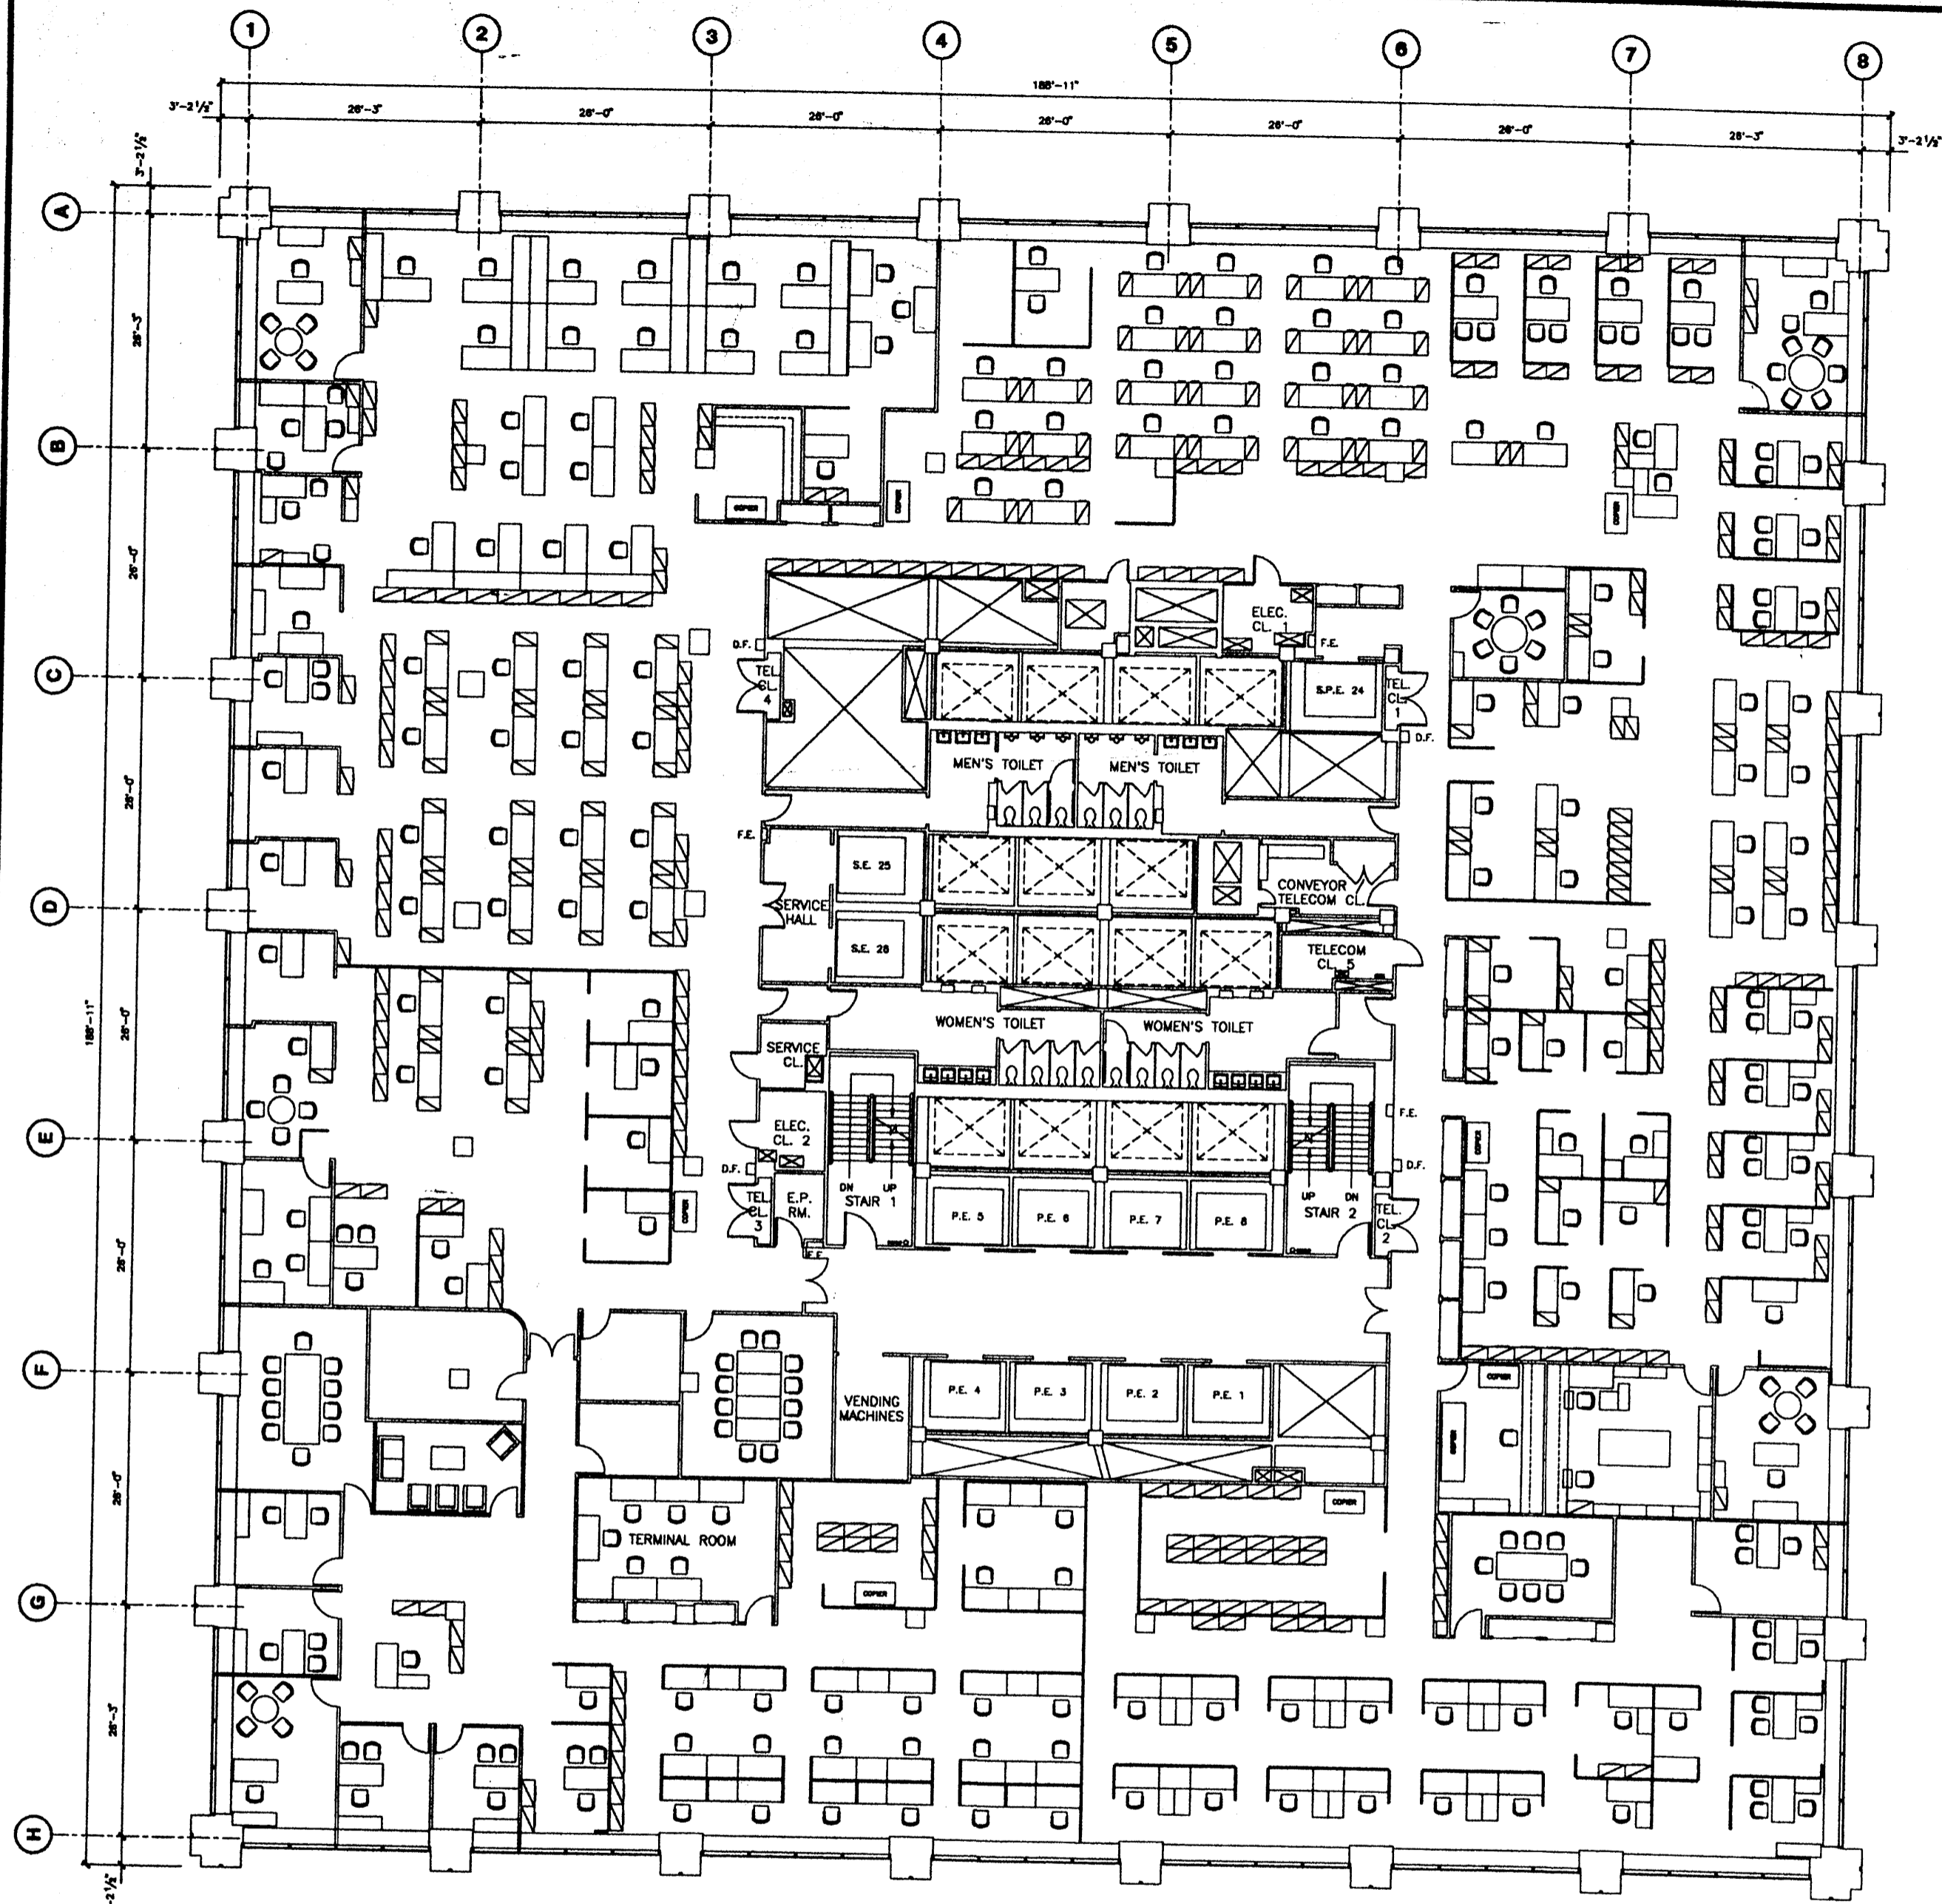

Deutsche Bank


No.	Date	Description
1	8/1/93	Original 802021821 - Old Layout Generation
2	5/15/96	Project 802020228 - Post Renovation
3	8/1/97	Project 802020214 - Update Lighting Layout
4	7/15/98	Update for Electric Sheet Review
5	5/25/01	Updated for Building Conditions

No.	Date	Issued To	By

130 LIBERTY STREET
14th FLOOR

Drawn By	
Checked By	
Date	5/25/01
Scale	
Project No.	



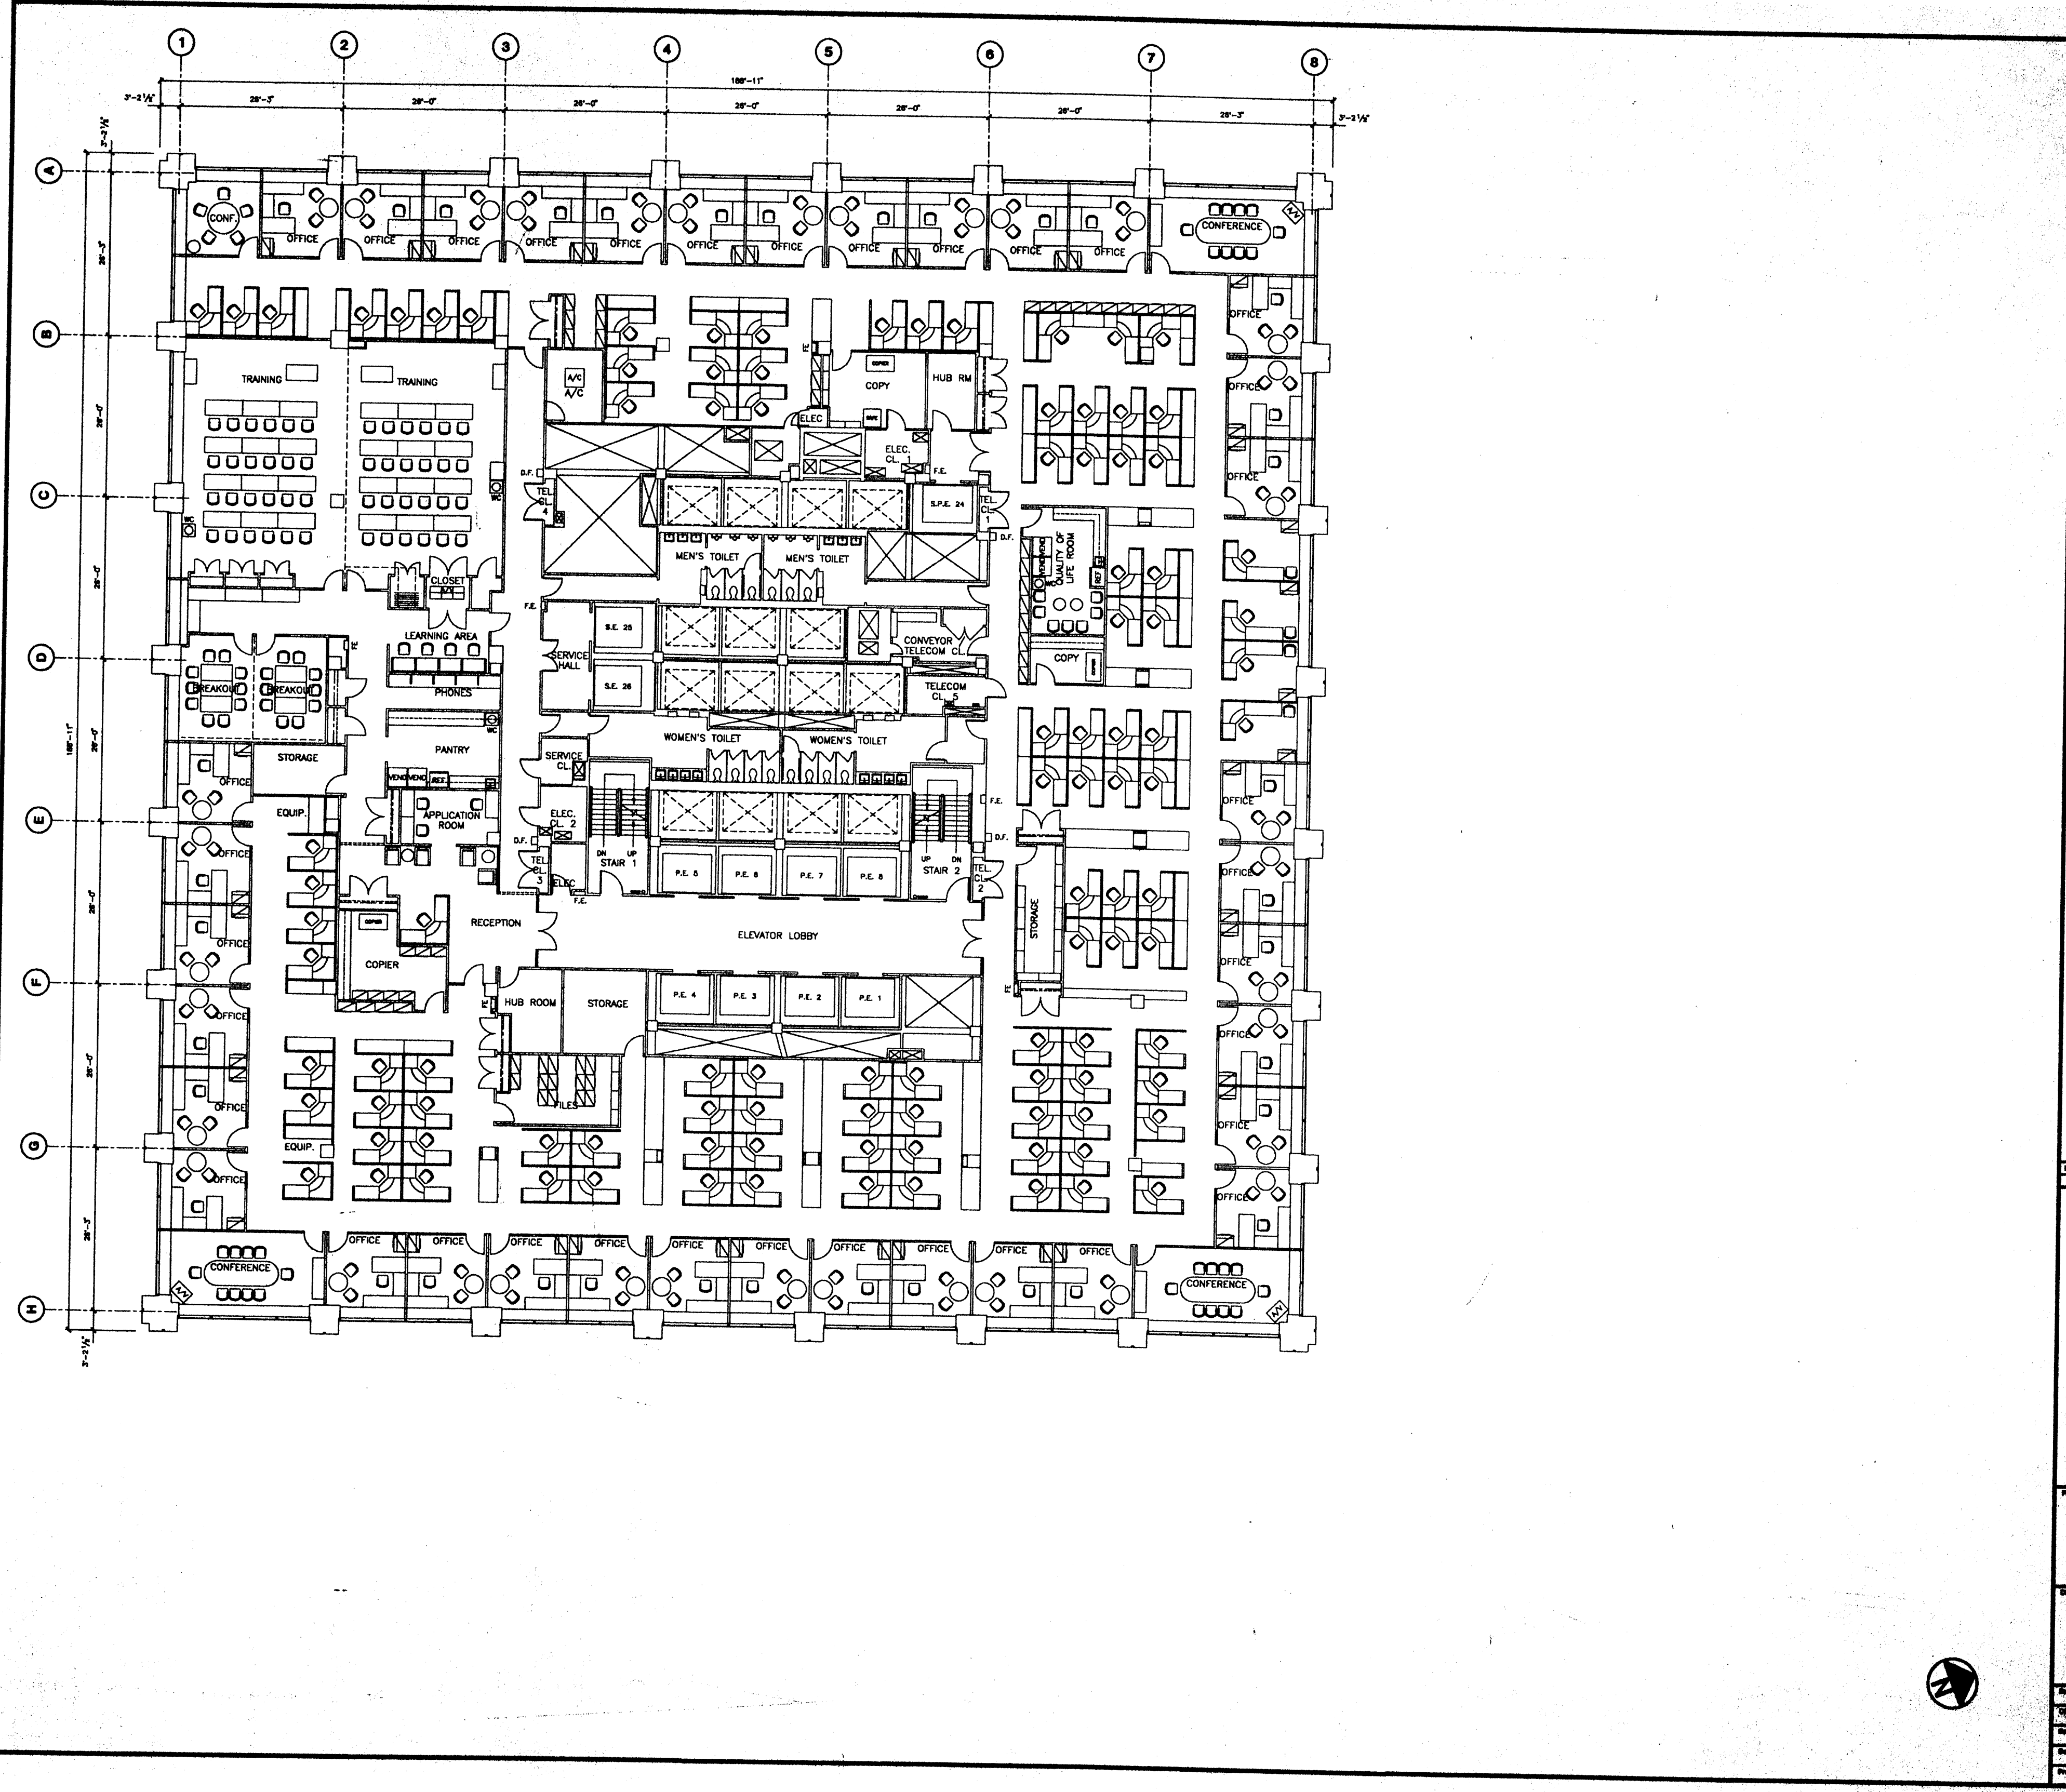

Deutsche Bank

No.	Date	Revised By
1	12/1/83	Project 8200000000 130 Liberty Street New York, NY 10046
2	8/18/84	Project 8200000000 130 Liberty Street New York, NY 10046
3	10/25/86	Updated for Building Commission
4	5/1/87	Project 8200000000 130 Liberty Street New York, NY 10046
5	7/18/88	Updated for Bank's Client System
6	1/18/91	Project 1200000000


No.	Date	Revised By

130 LIBERTY STREET

12th FLOOR

Project No.	
Revised By	
Date	6/18/91
Scale	
Project No.	



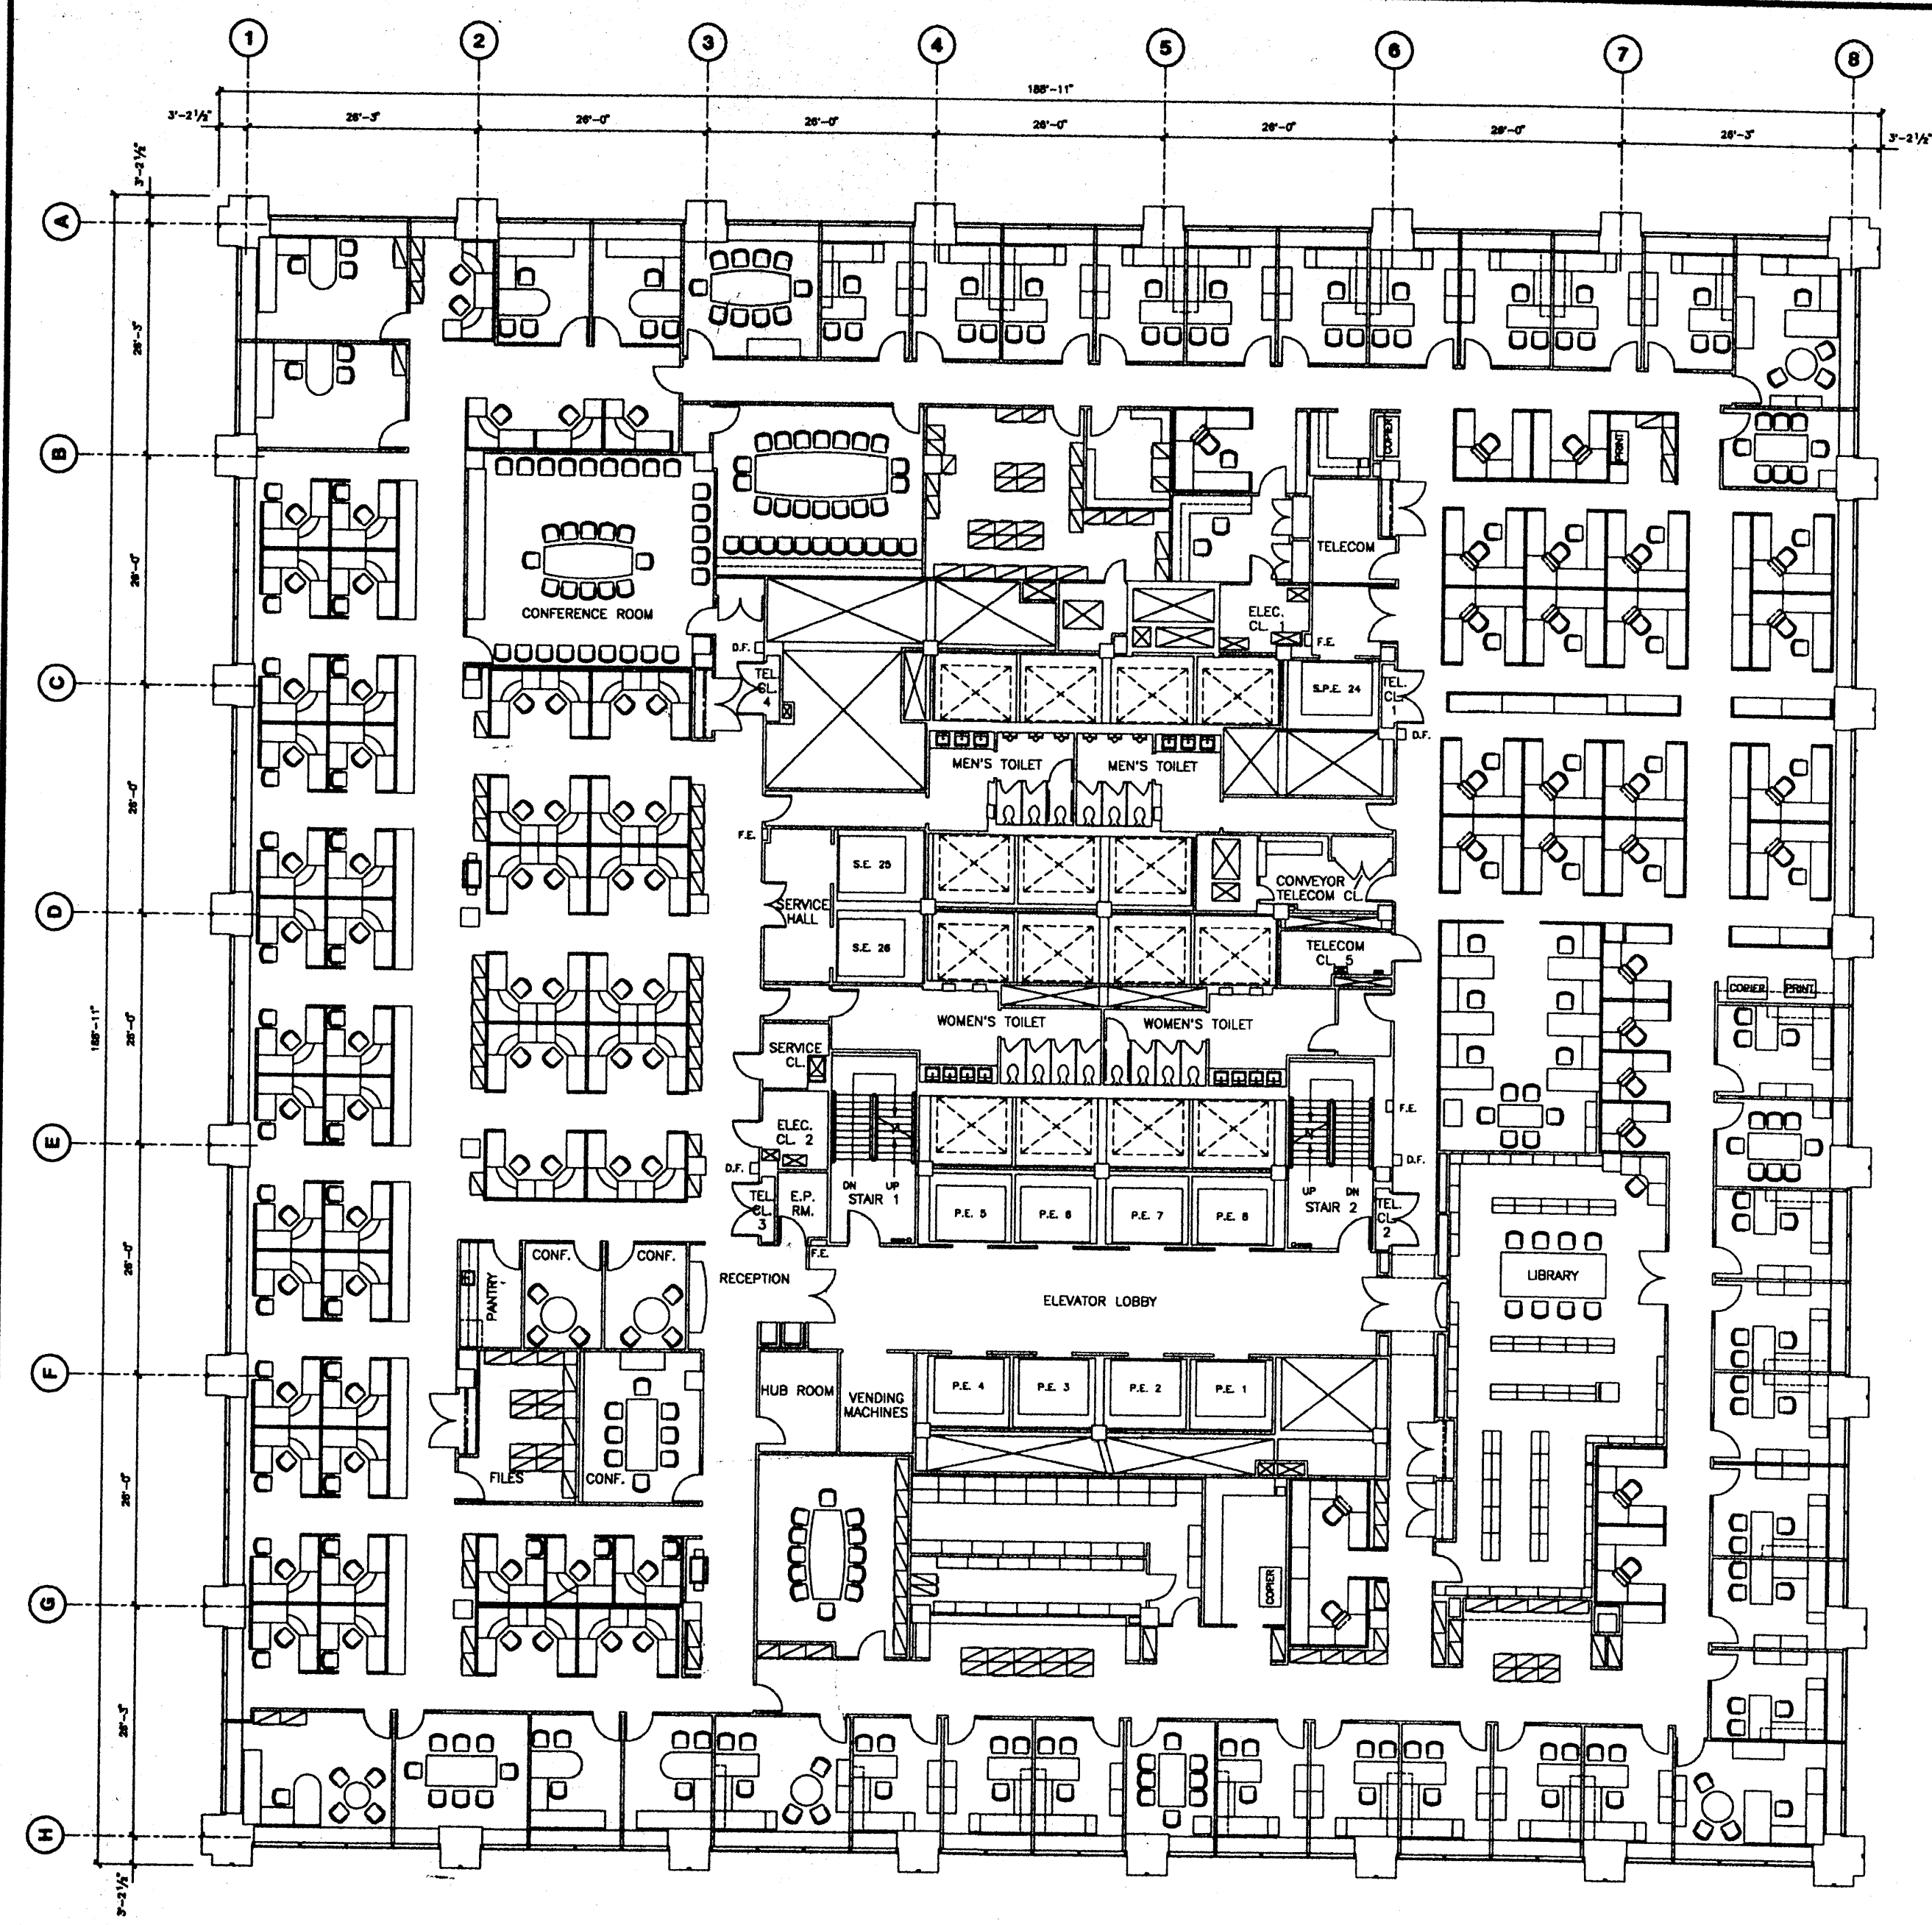

Deutsche Bank

No.	Date	Description
1	8/5/97	Furniture Update
2	7/15/98	Updated for Deutsche Credit Building
3	8/15/98	Project #70001333 Corporate Tel. Allocation
4	1/15/99	Project #70001333 Corporate Tel. Allocation
5	5/15/01	Project #87000000 Corporate Furniture


No.	Date	Issued To

130 LIBERTY STREET

11th FLOOR

Drawn By	
Checked By	
Date	6/15/01
Project No.	



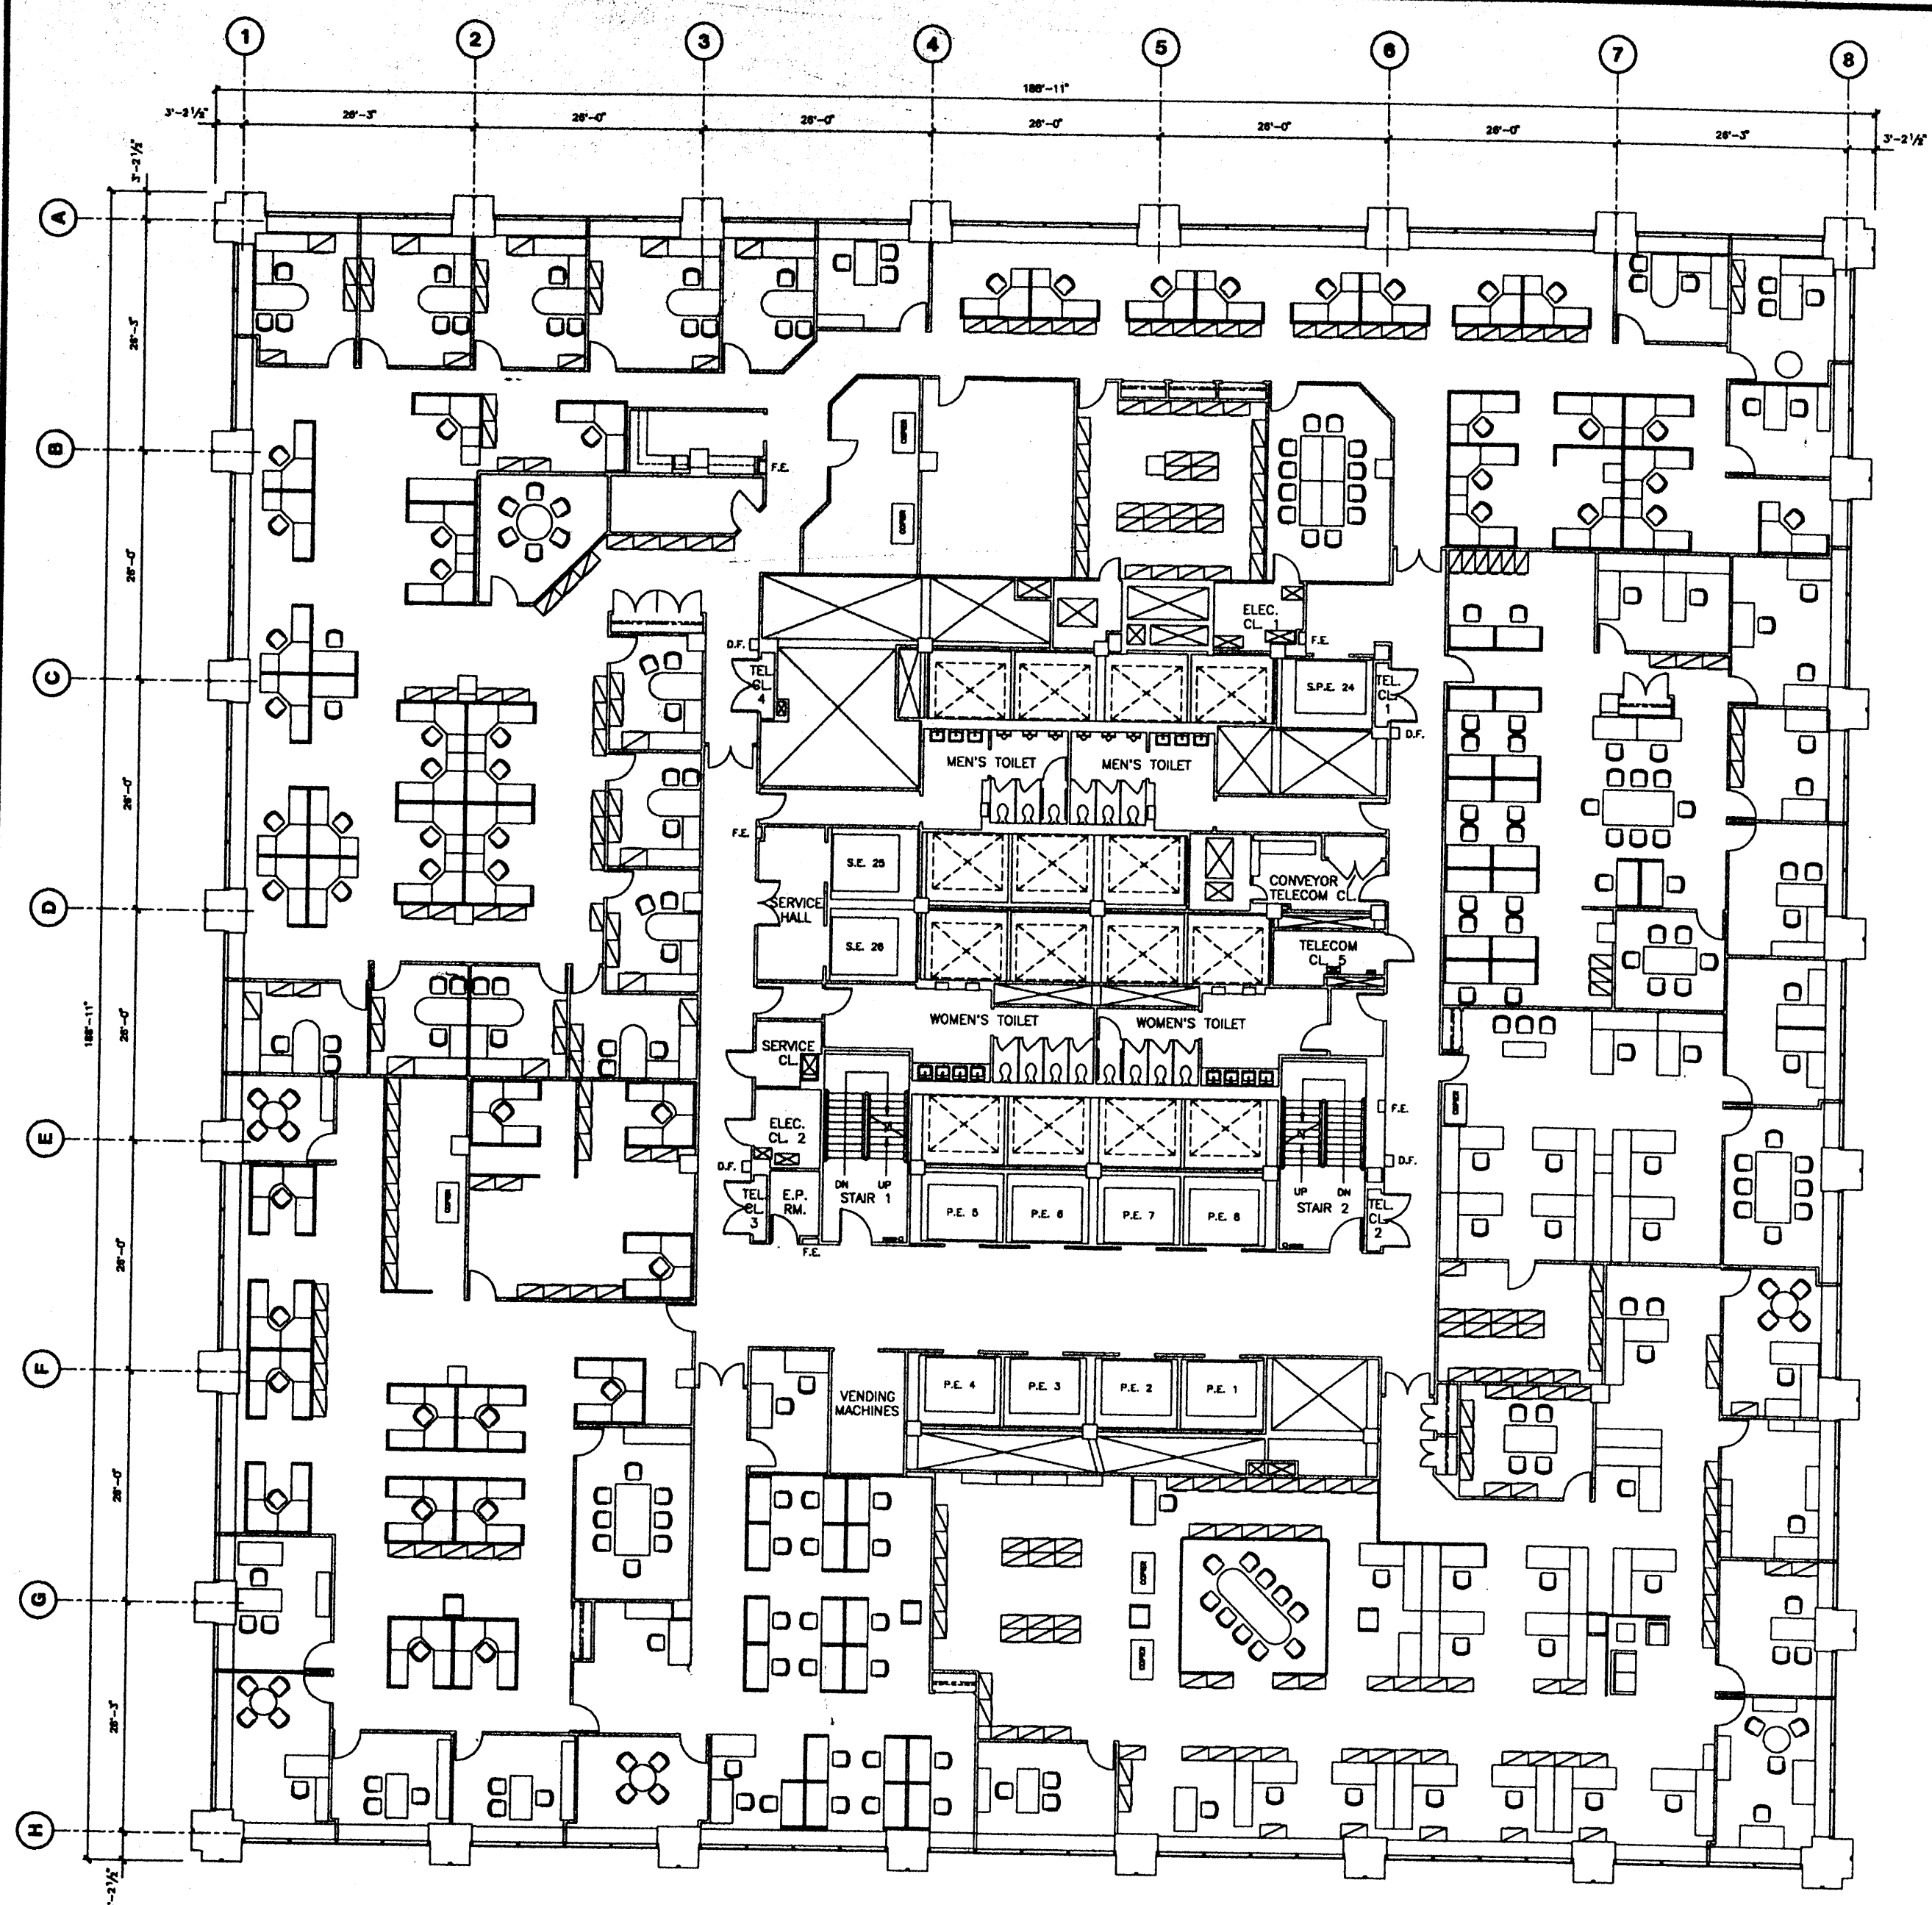


Deutsche Bank

No.	Date	Revised To
1	1/1/95	Project 800000000 - 10th Floor Renovation
2	3/1/96	Update on per New Floor
3	5/15/97	Project 80001230 - Operation / System Scale
4	7/15/98	Update for Client, Client Bank
5	1/1/99	Project 80002190 - 10th Floor Renovation
6	5/25/01	Update for Safety Conditions

130 LIBERTY STREET
10th FLOOR



Drawn By	Checked By
Date	6/15/01
Project No.	

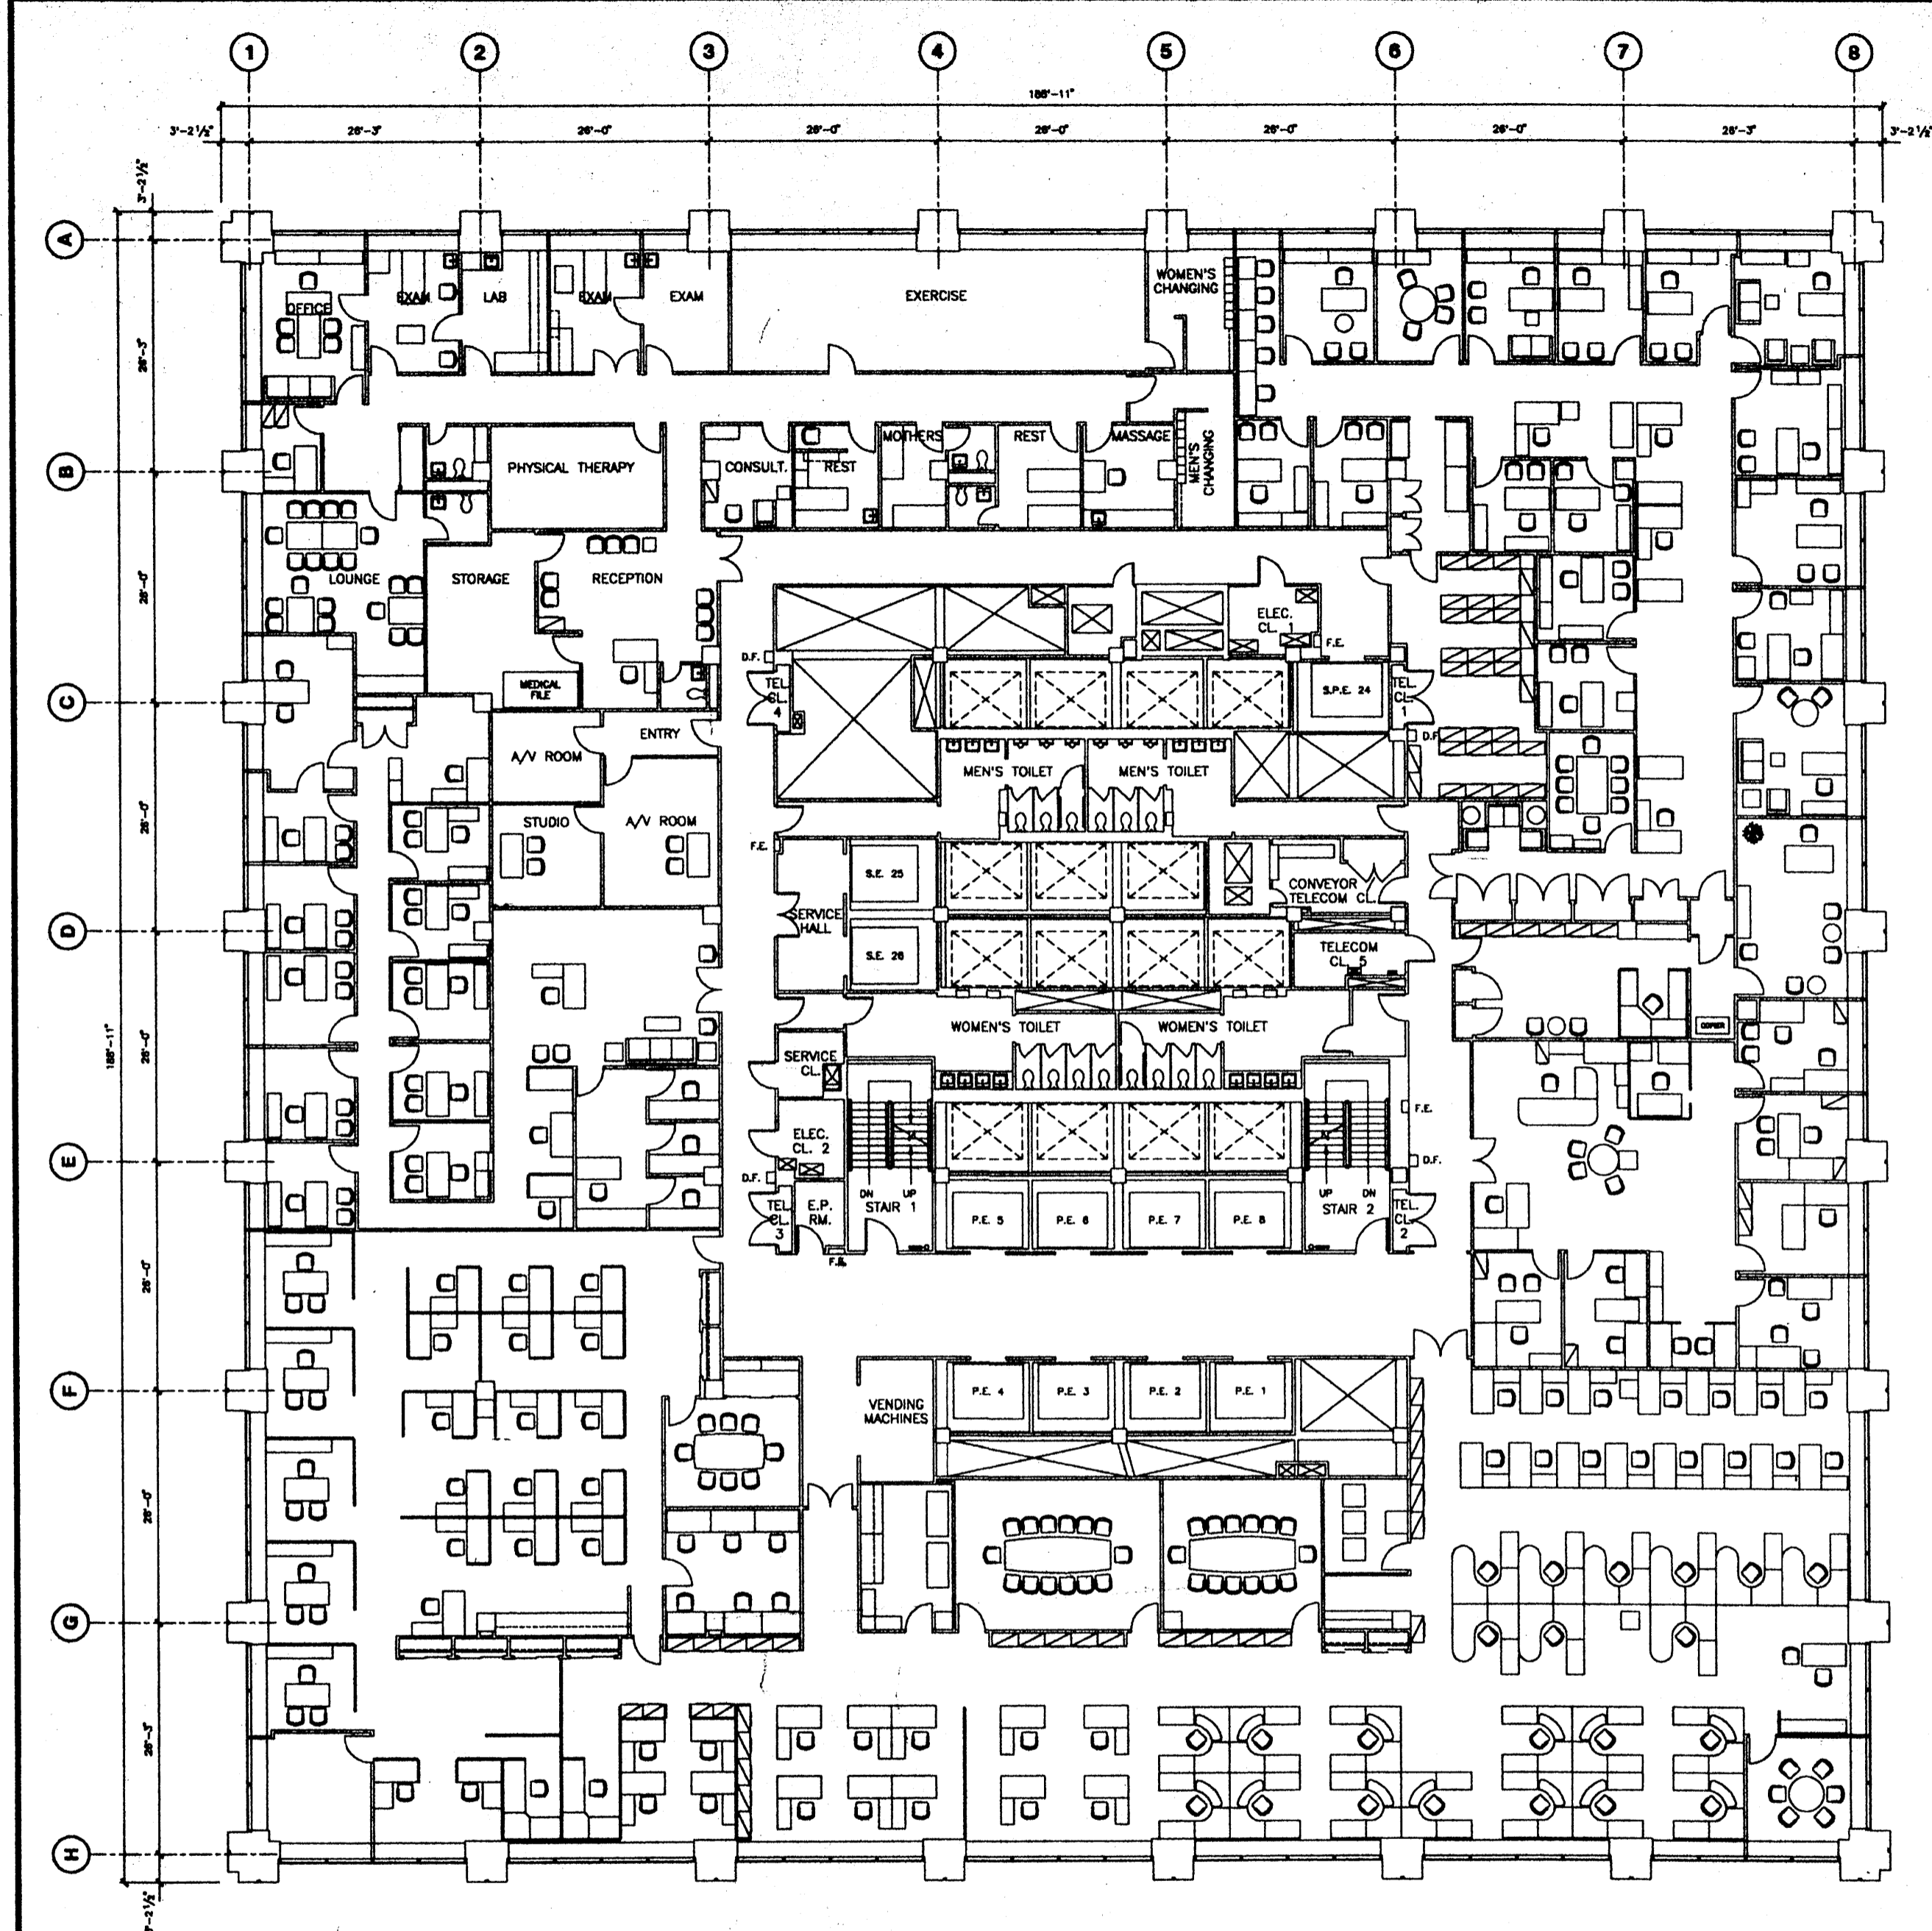

Deutsche Bank

No.	Date	Description
1	8/1/98	Initial Planning and Design
2	8/1/98	Update Plans for 4th Flr
3	8/1/98	Update Plans for 5th Flr
4	8/1/98	Update Plans for 6th Flr
5	8/1/98	Update Plans for 7th Flr
6	8/1/98	Update Plans for 8th Flr
7	8/1/98	Update Plans for 9th Flr
8	8/1/98	Update Plans for 10th Flr
9	8/1/98	Update Plans for 11th Flr
10	8/1/98	Update Plans for 12th Flr


Scale: 1/8" = 1'-0"

130 LIBERTY STREET

9th FLOOR

Drawn By: _____
 Checked By: _____
 Date: 5/15/01
 Scale: _____
 Project No: _____



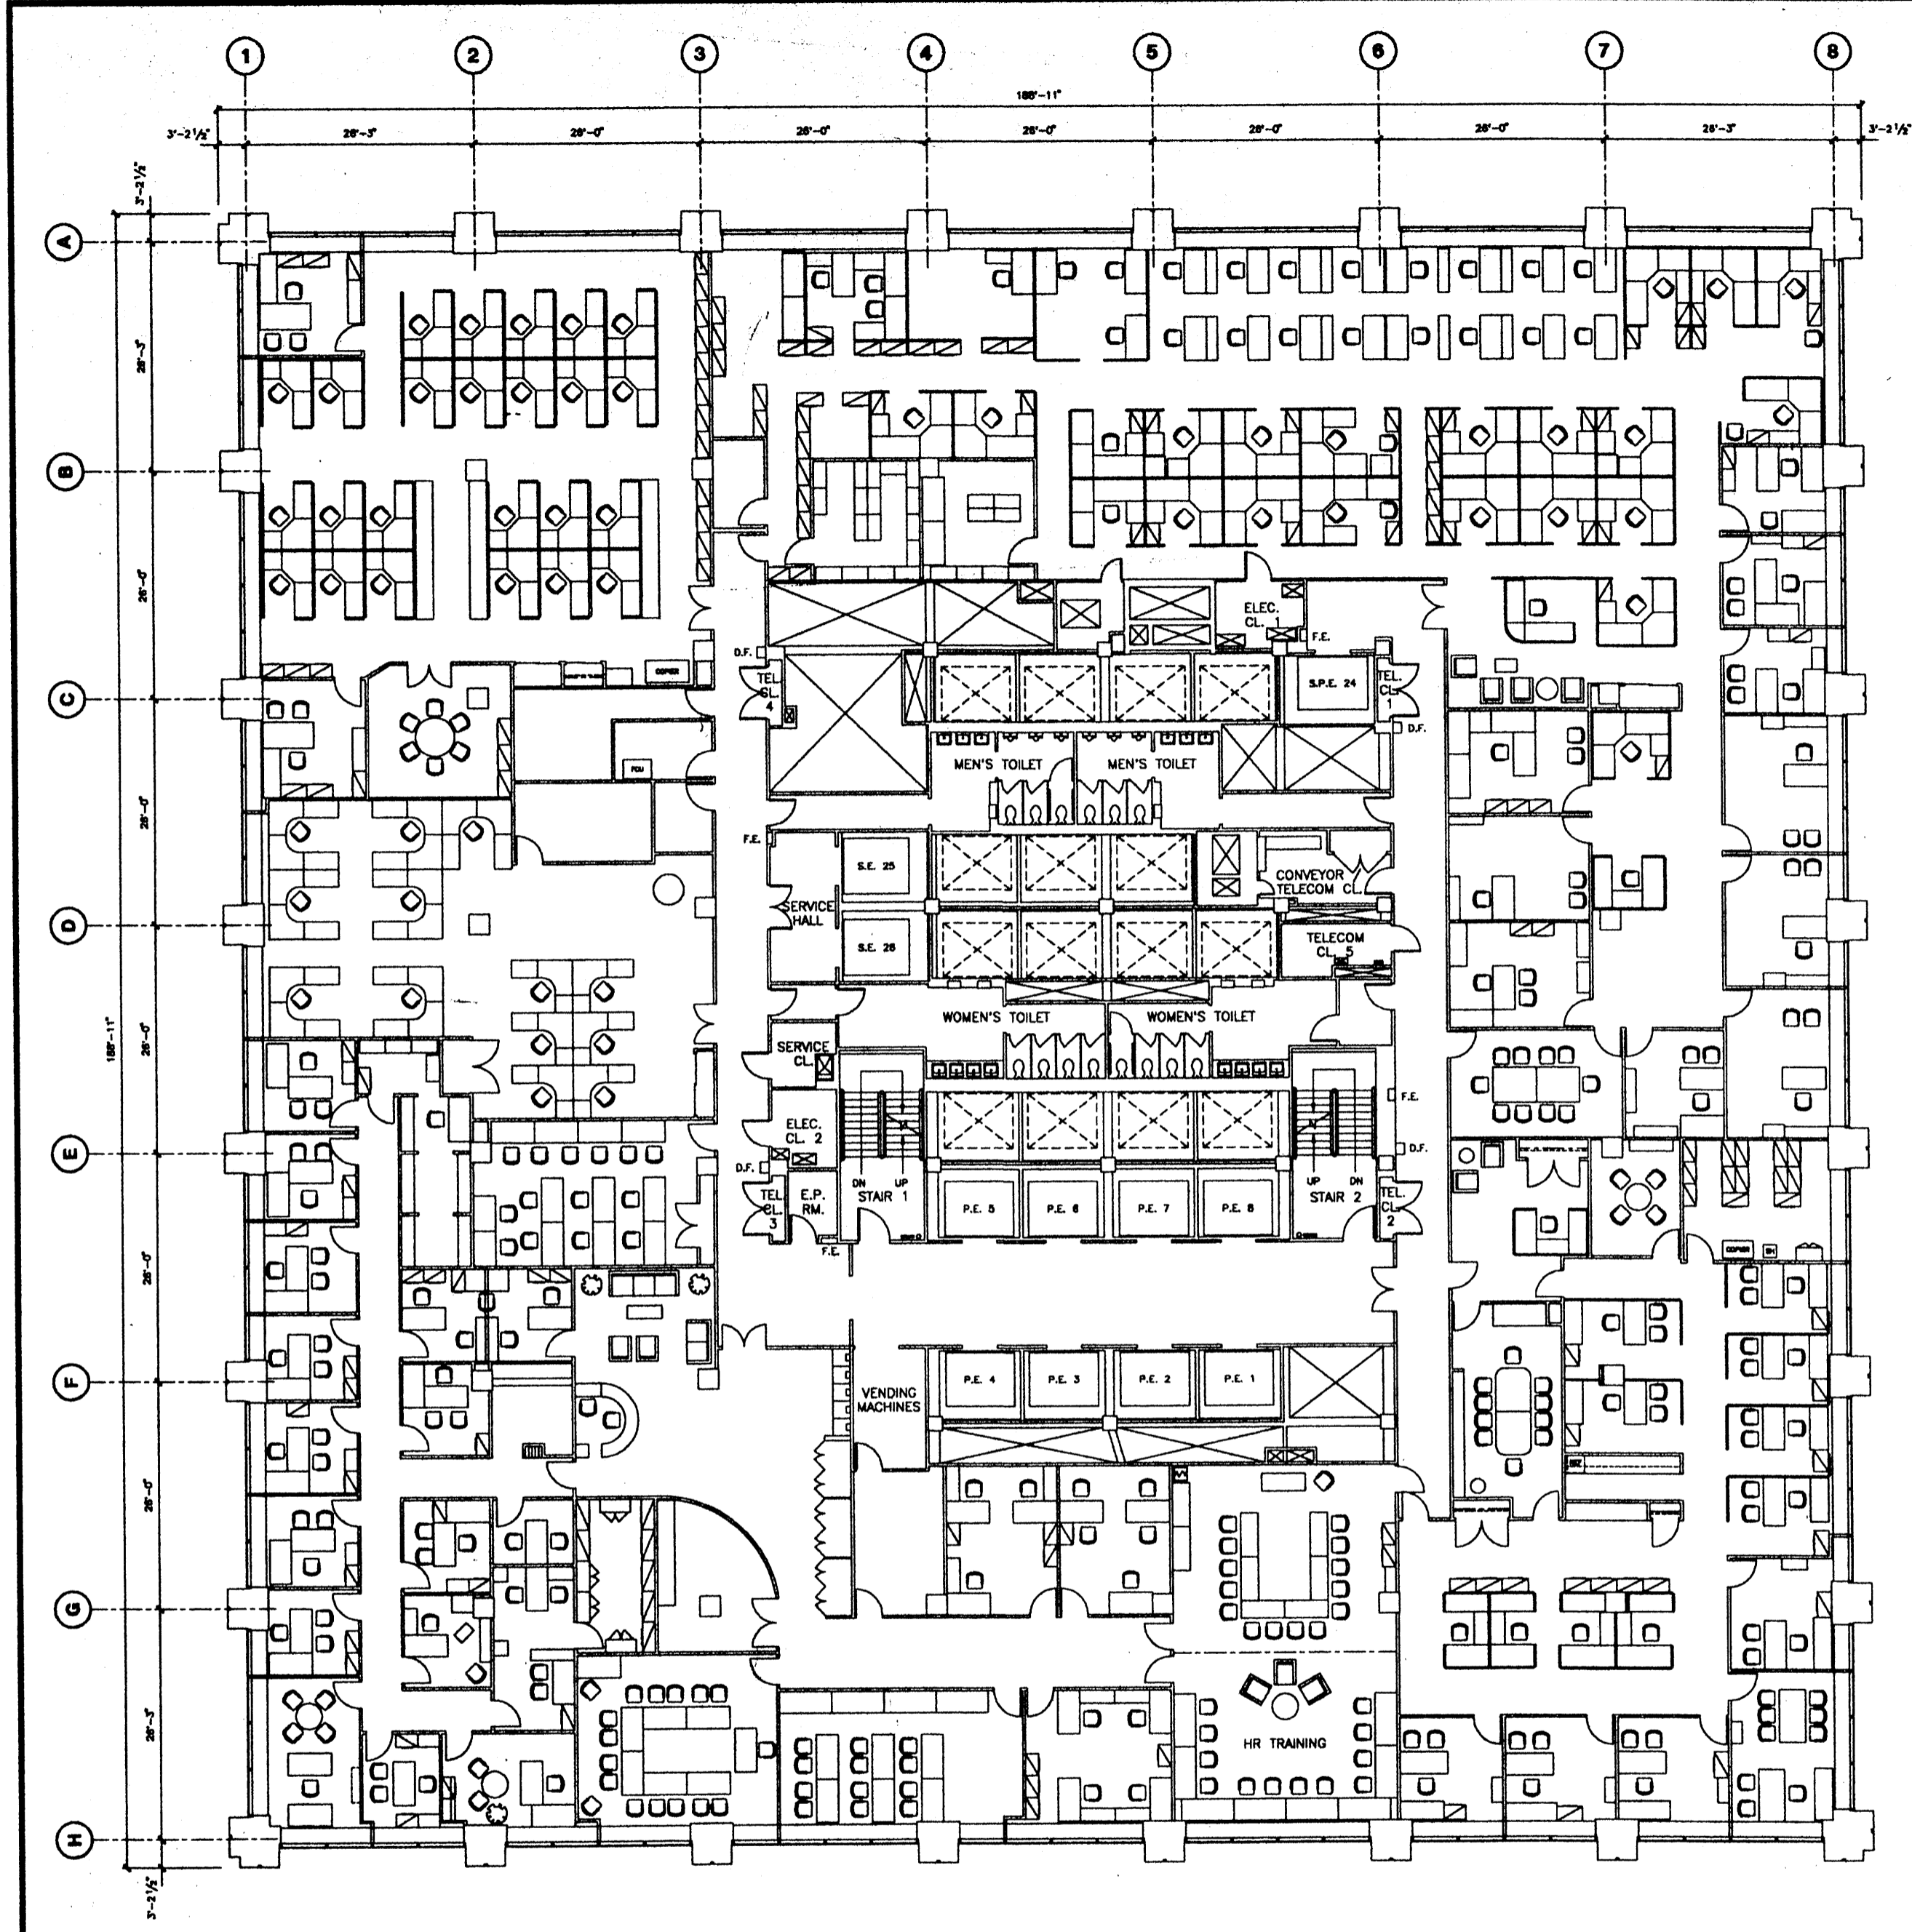

Deutsche Bank


No.	Date	Description
1	8/14/93	Added Entrance Door to Porch
2	10/7/94	Project No. 900003184 - 7th / 8th Project No. 900003373 7th / 8th CDB Tracing
3	11/23/94	Project No. 000011820 Correction: Compartment, Restroom
4	5/21/96	Project No. 971 - Redesign to Small Size
5	4/1/97	Project No. 900003314 Detailed Lighting Layout
6	7/15/98	Updated for Electric Circuit Survey
7	8/18/99	Revised Southwest Portion of Floor

No.	Date	Issued To

130 LIBERTY STREET

8th FLOOR

Revision No.	
Checked By	
Date	8/15/99
Drawn	
Project No.	

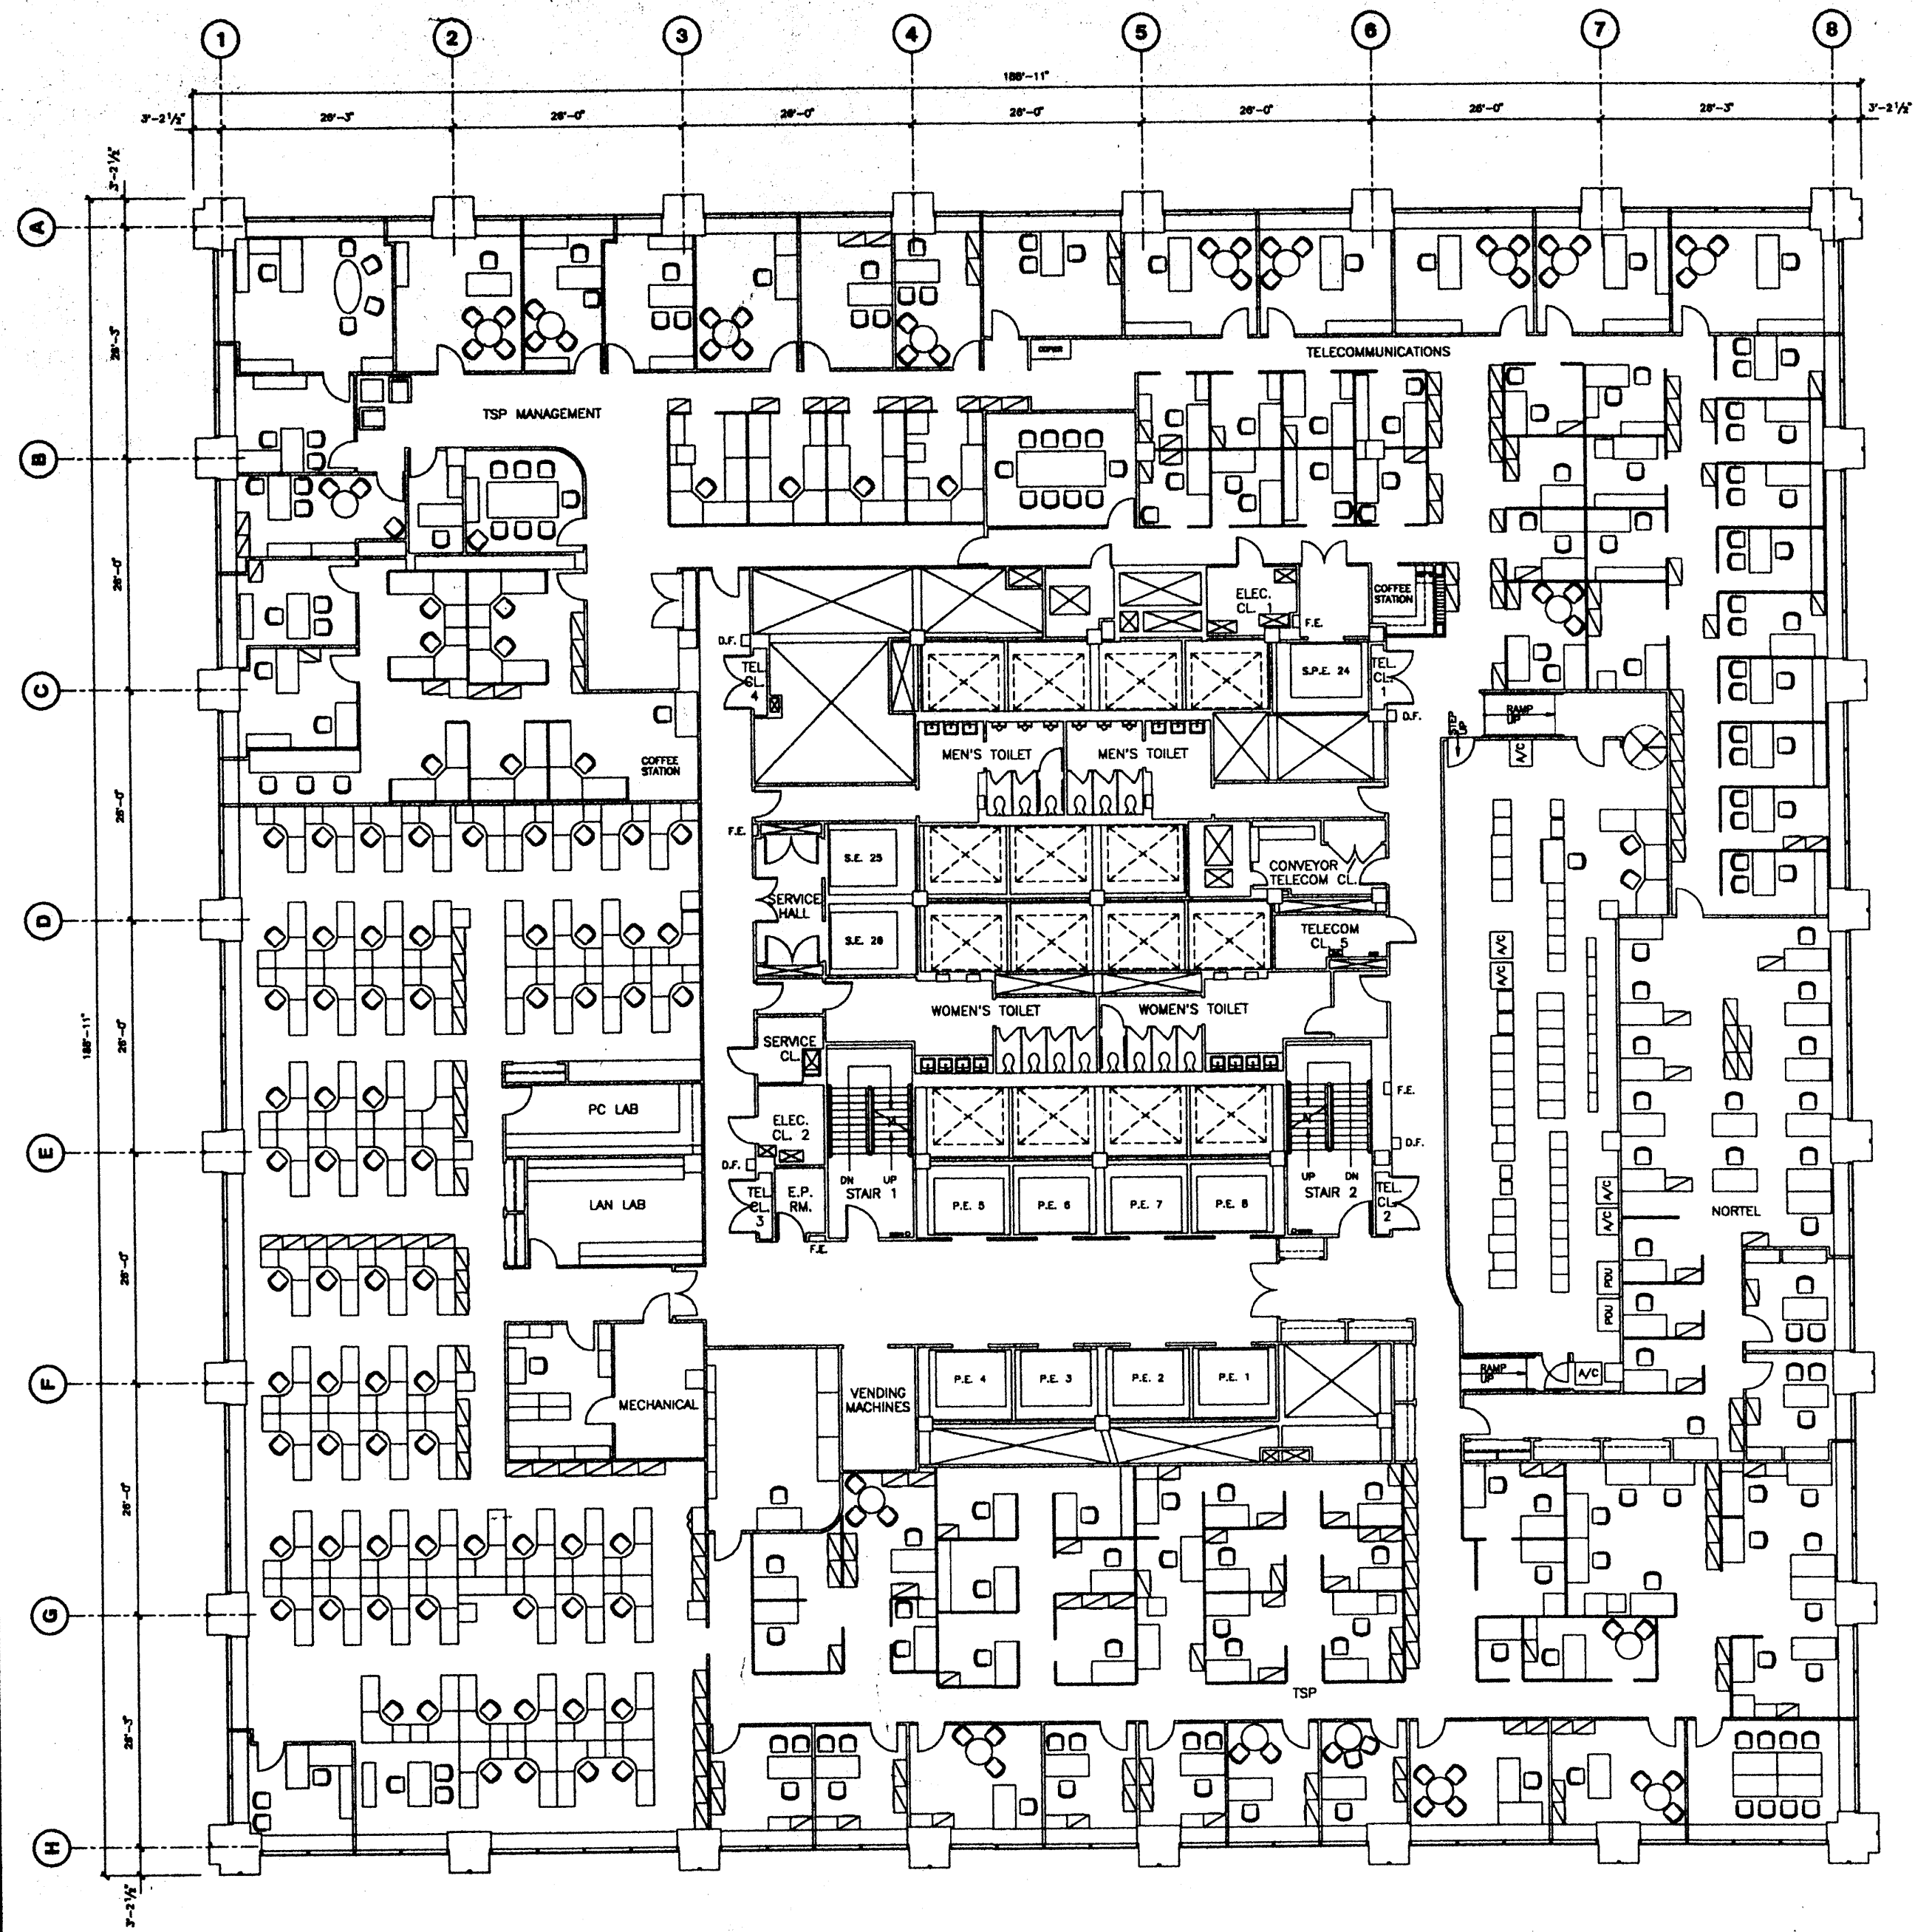

Deutsche Bank

No.	Date	Revised To
1	12/1/92	Project RE2001447 7th Floor Mechanical Area S.P. RE2001441 S.P. RE2001442
2	1/1/93	Update Furniture for Work Rooms Project RE2001447 S.P. RE2001441 S.P. RE2001442
3	3/15/95	Project RE2001384 Telecom/PC Support Relocation
4	1/9/97	Project RE2001385 Telecom Support Relocation
5	4/1/99	Project RE2002011 Update Lighting Layout
6	7/15/99	Updated for Electric Grid Survey
7	5/15/01	Updated for Existing Conditions


No.	Date	Issued To	By

130 LIBERTY STREET

7th FLOOR

Drawn By	
Checked By	
Date	5/15/01
Scale	
Project No.	



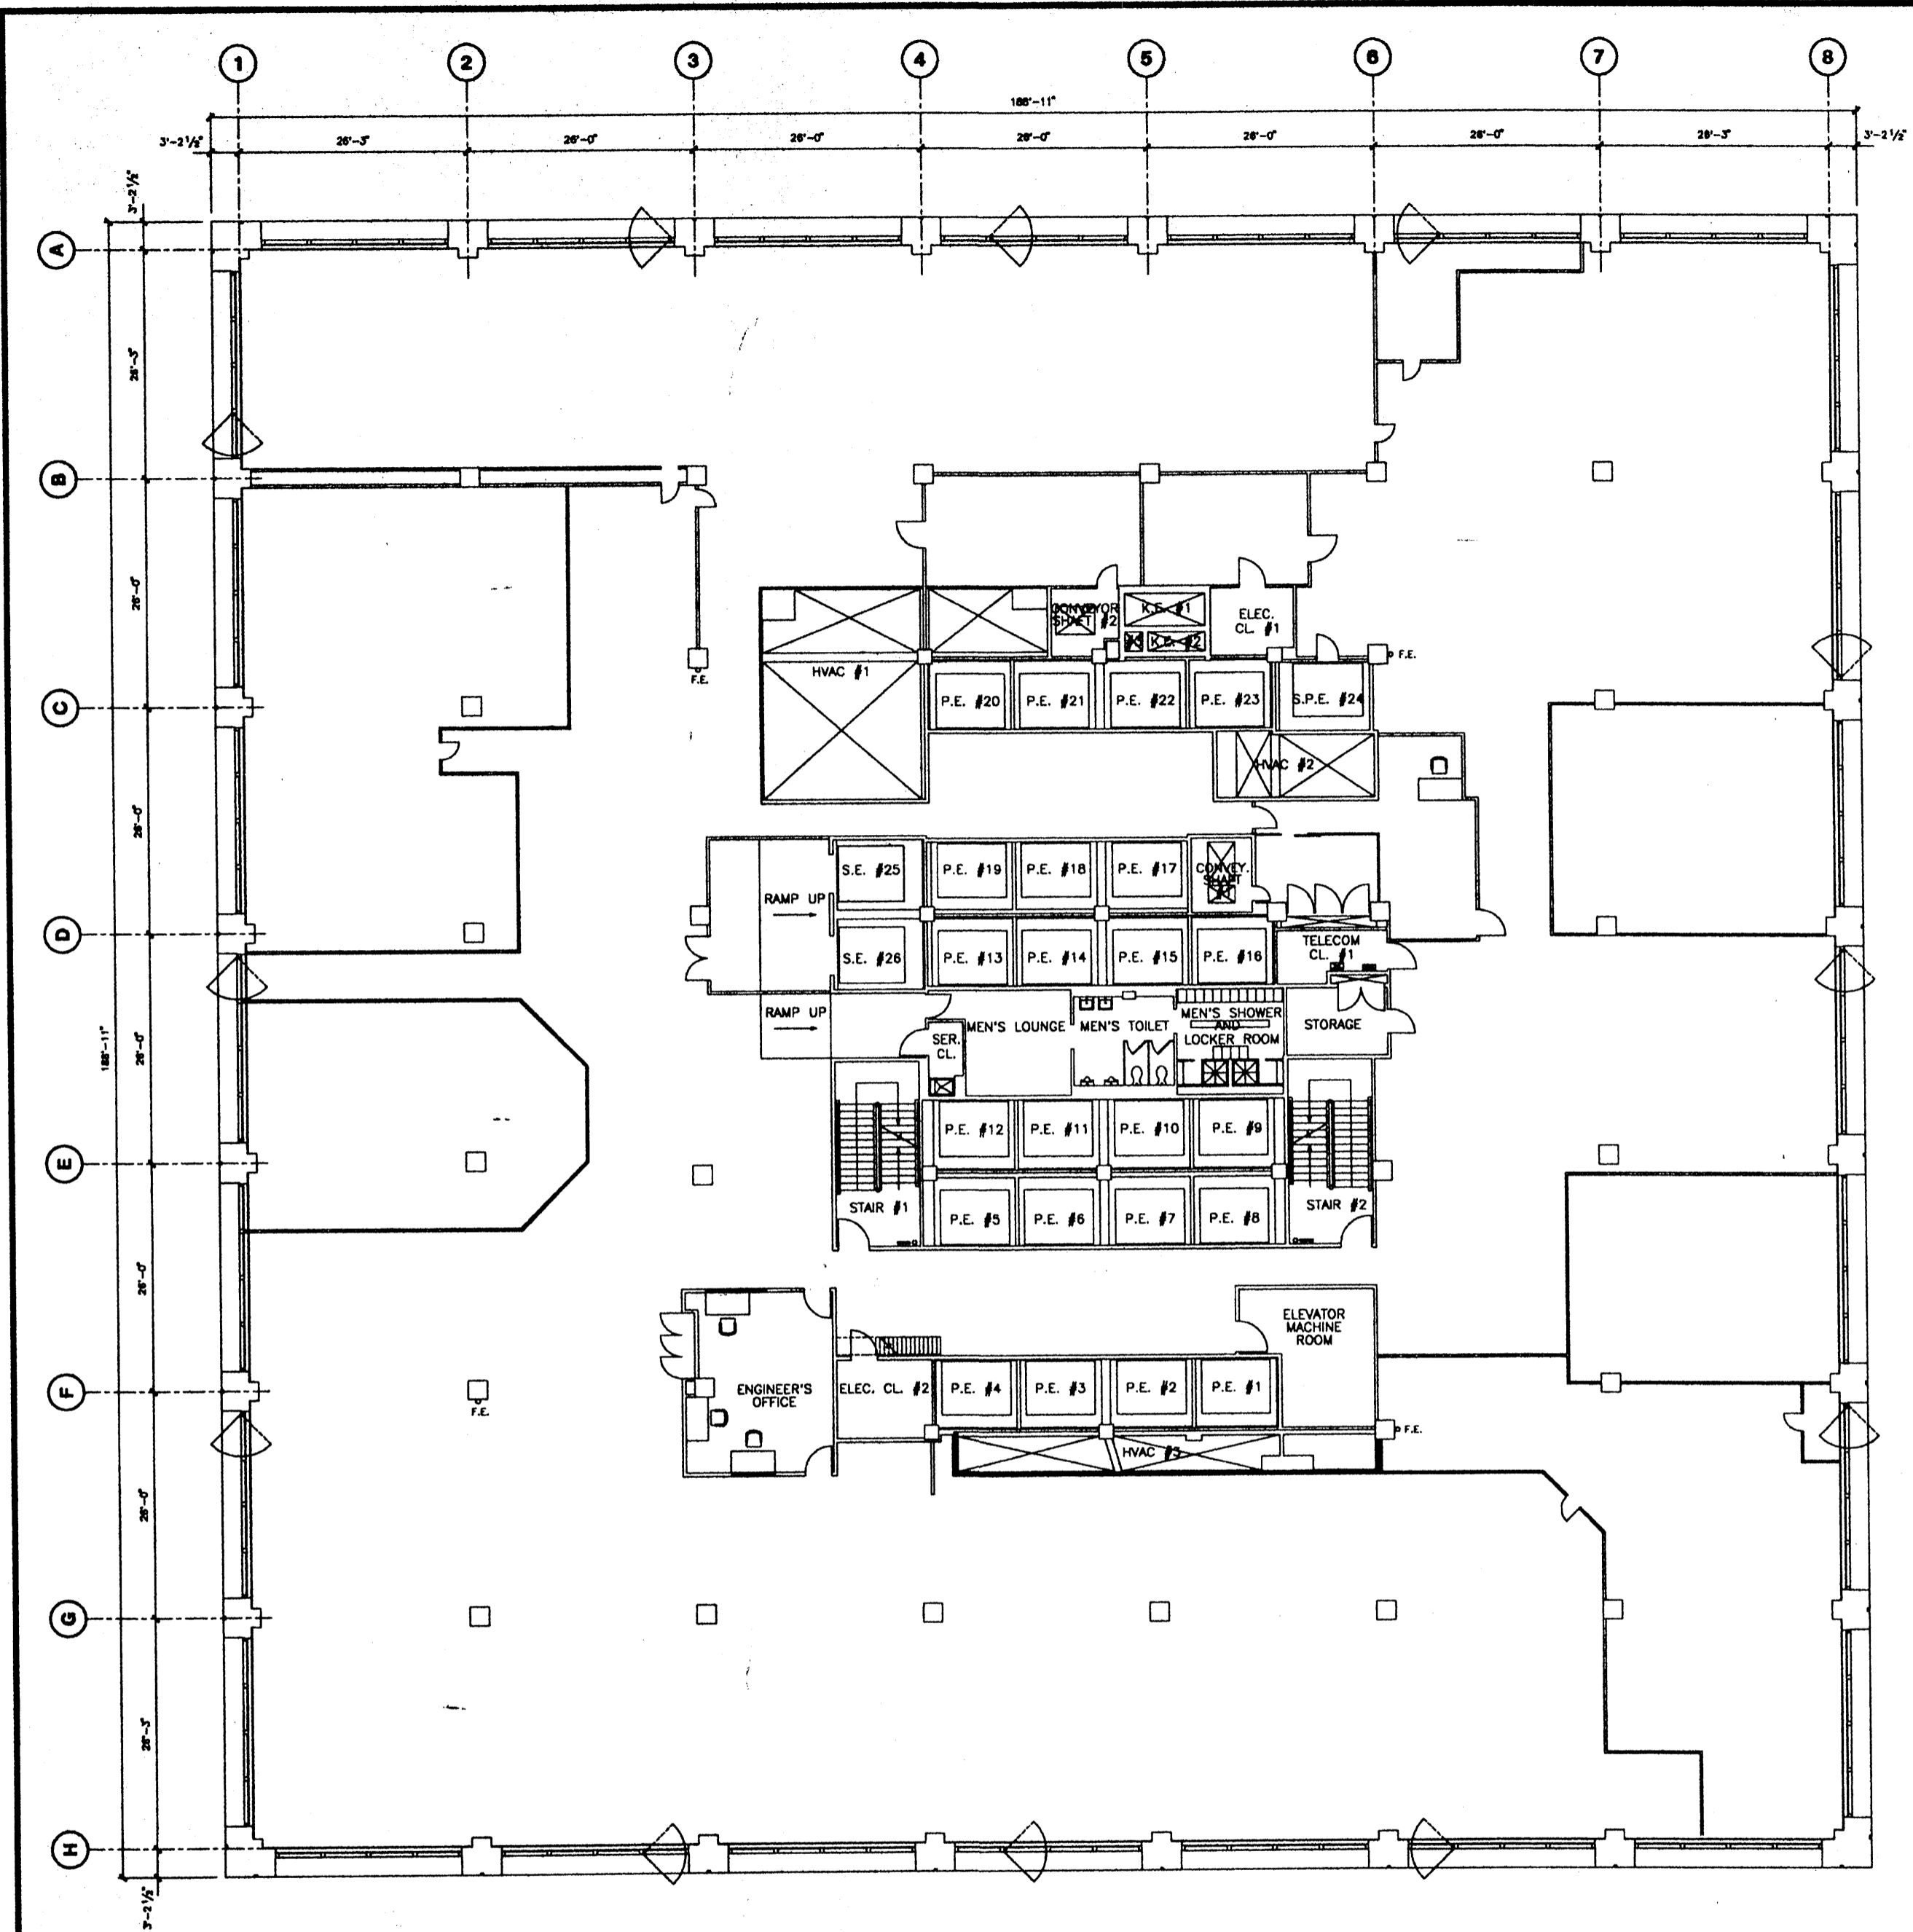

Deutsche Bank

No.	Date	Description
1	7/16/98	Updated for Deutsche Credit Rating


No.	Date	Revised To

130 LIBERTY STREET

5th FLOOR

Drawn By	
Checked By	
Date	7/16/98
Scale	
Project No.	



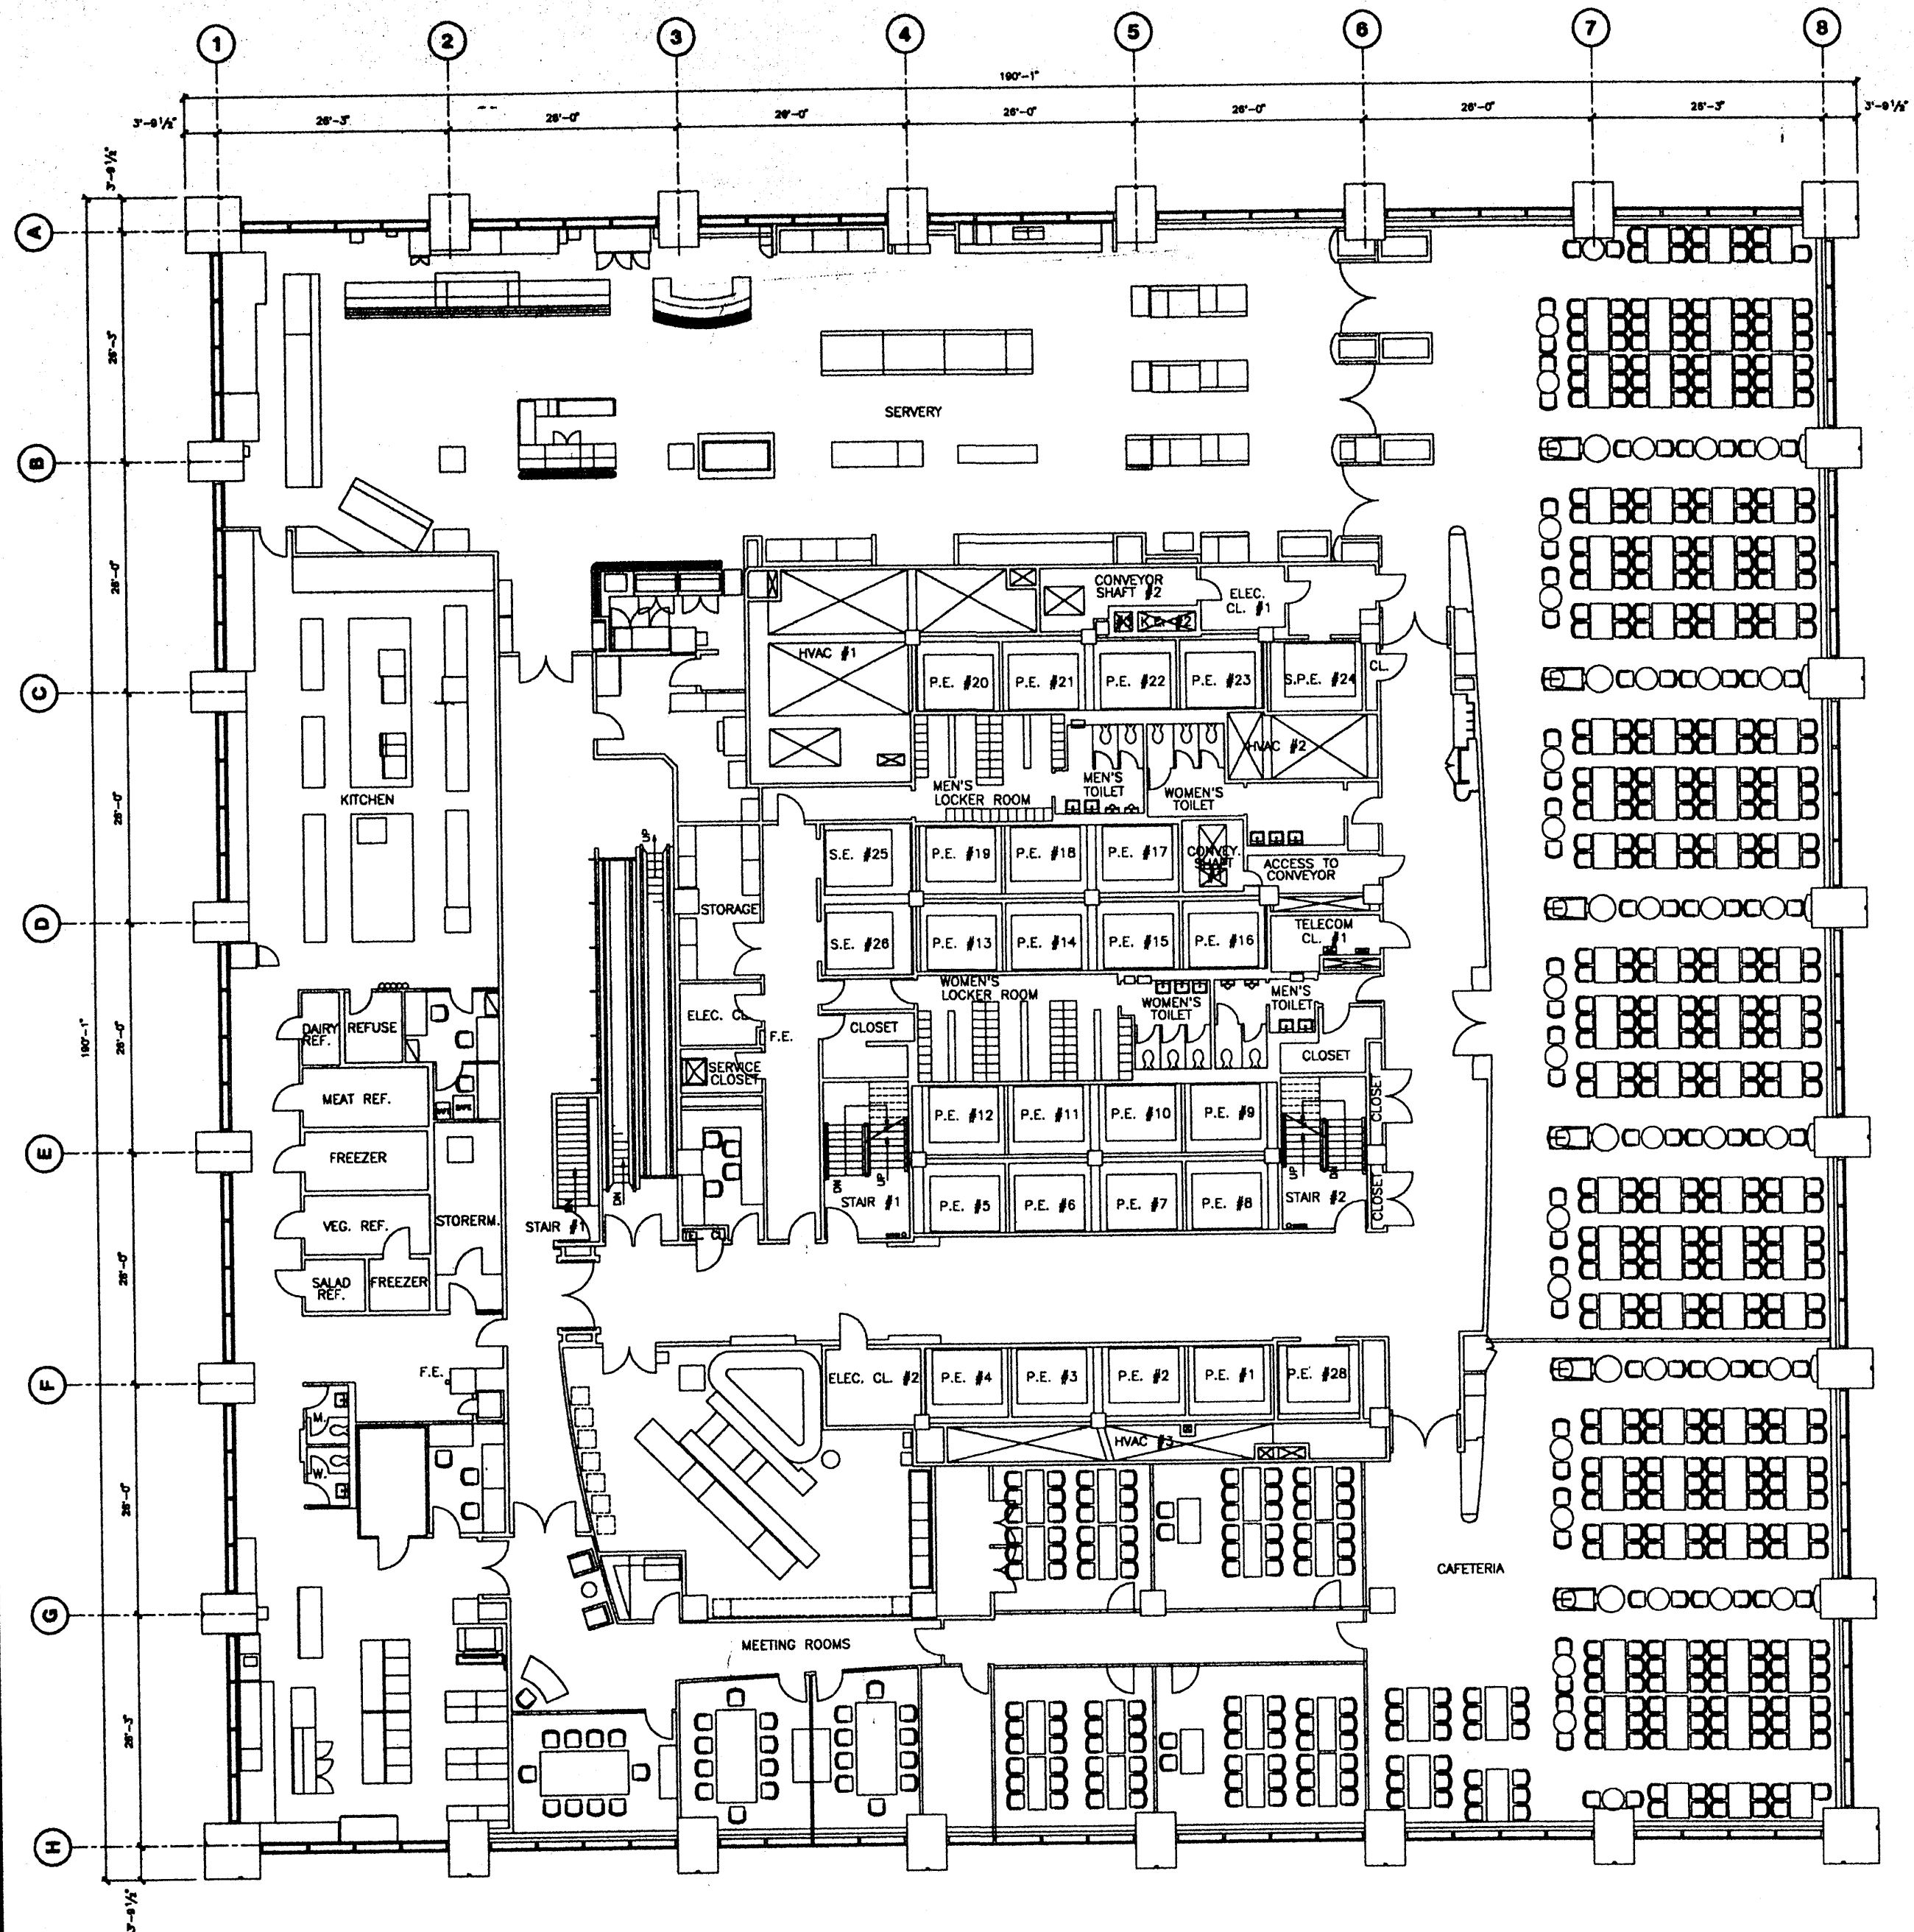

Deutsche Bank


No.	Date	Description
1	12/1/93	Project #0000019 Deutsche Bank Building
2	6/16/96	Project #0000000 Floor & Wall / A/E/C
3	7/18/98	Update for 2000000000 General Construction
4	6/1/99	Revised Plan

130 LIBERTY STREET

4th FLOOR



Drawn By	Checked By
Date	Date
Scale	Project No.

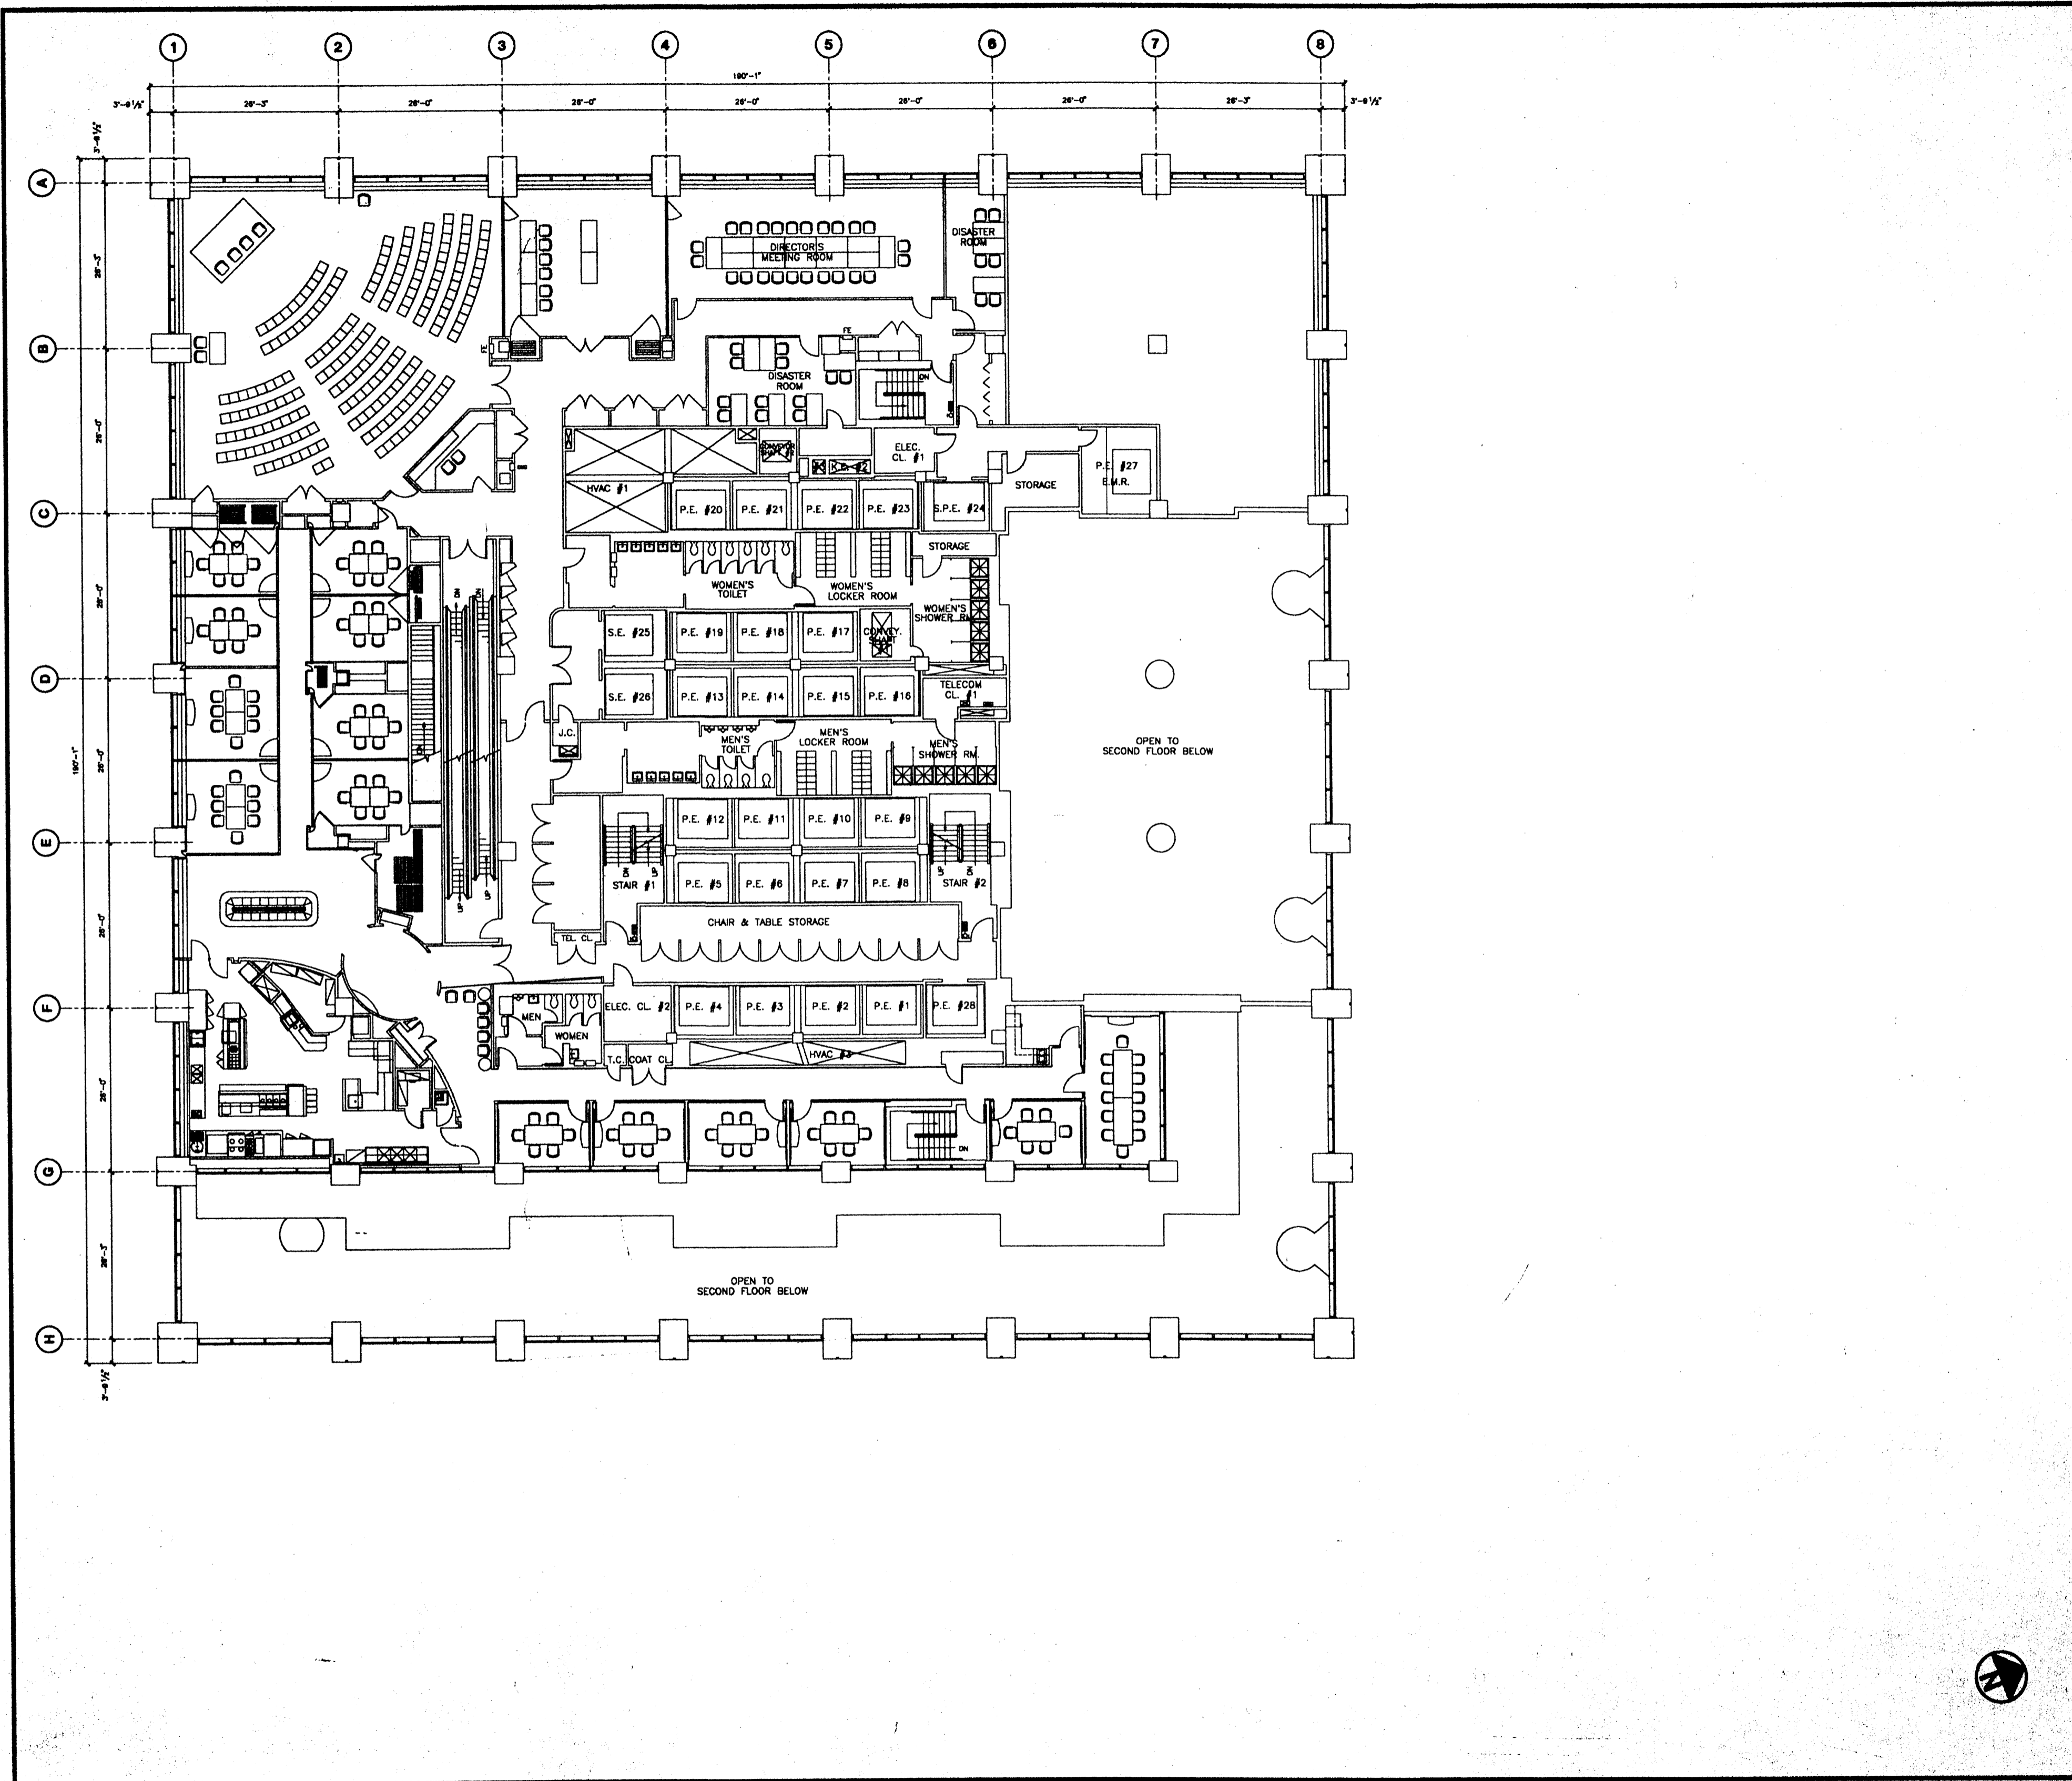

Deutsche Bank

No.	Date	Description
1	11/15/93	Original CD0001/REV. CD0001/1993 CD0002/1993 Arch. Code: 100-100-100
2	10/25/94	Added Director's Meeting Room
3	7/15/98	Updated for Double Check Survey


No.	Date	Revised By

130 LIBERTY STREET

3rd FLOOR

Drawn By	
Checked By	
Date	7/15/98
Scale	
Project No.	



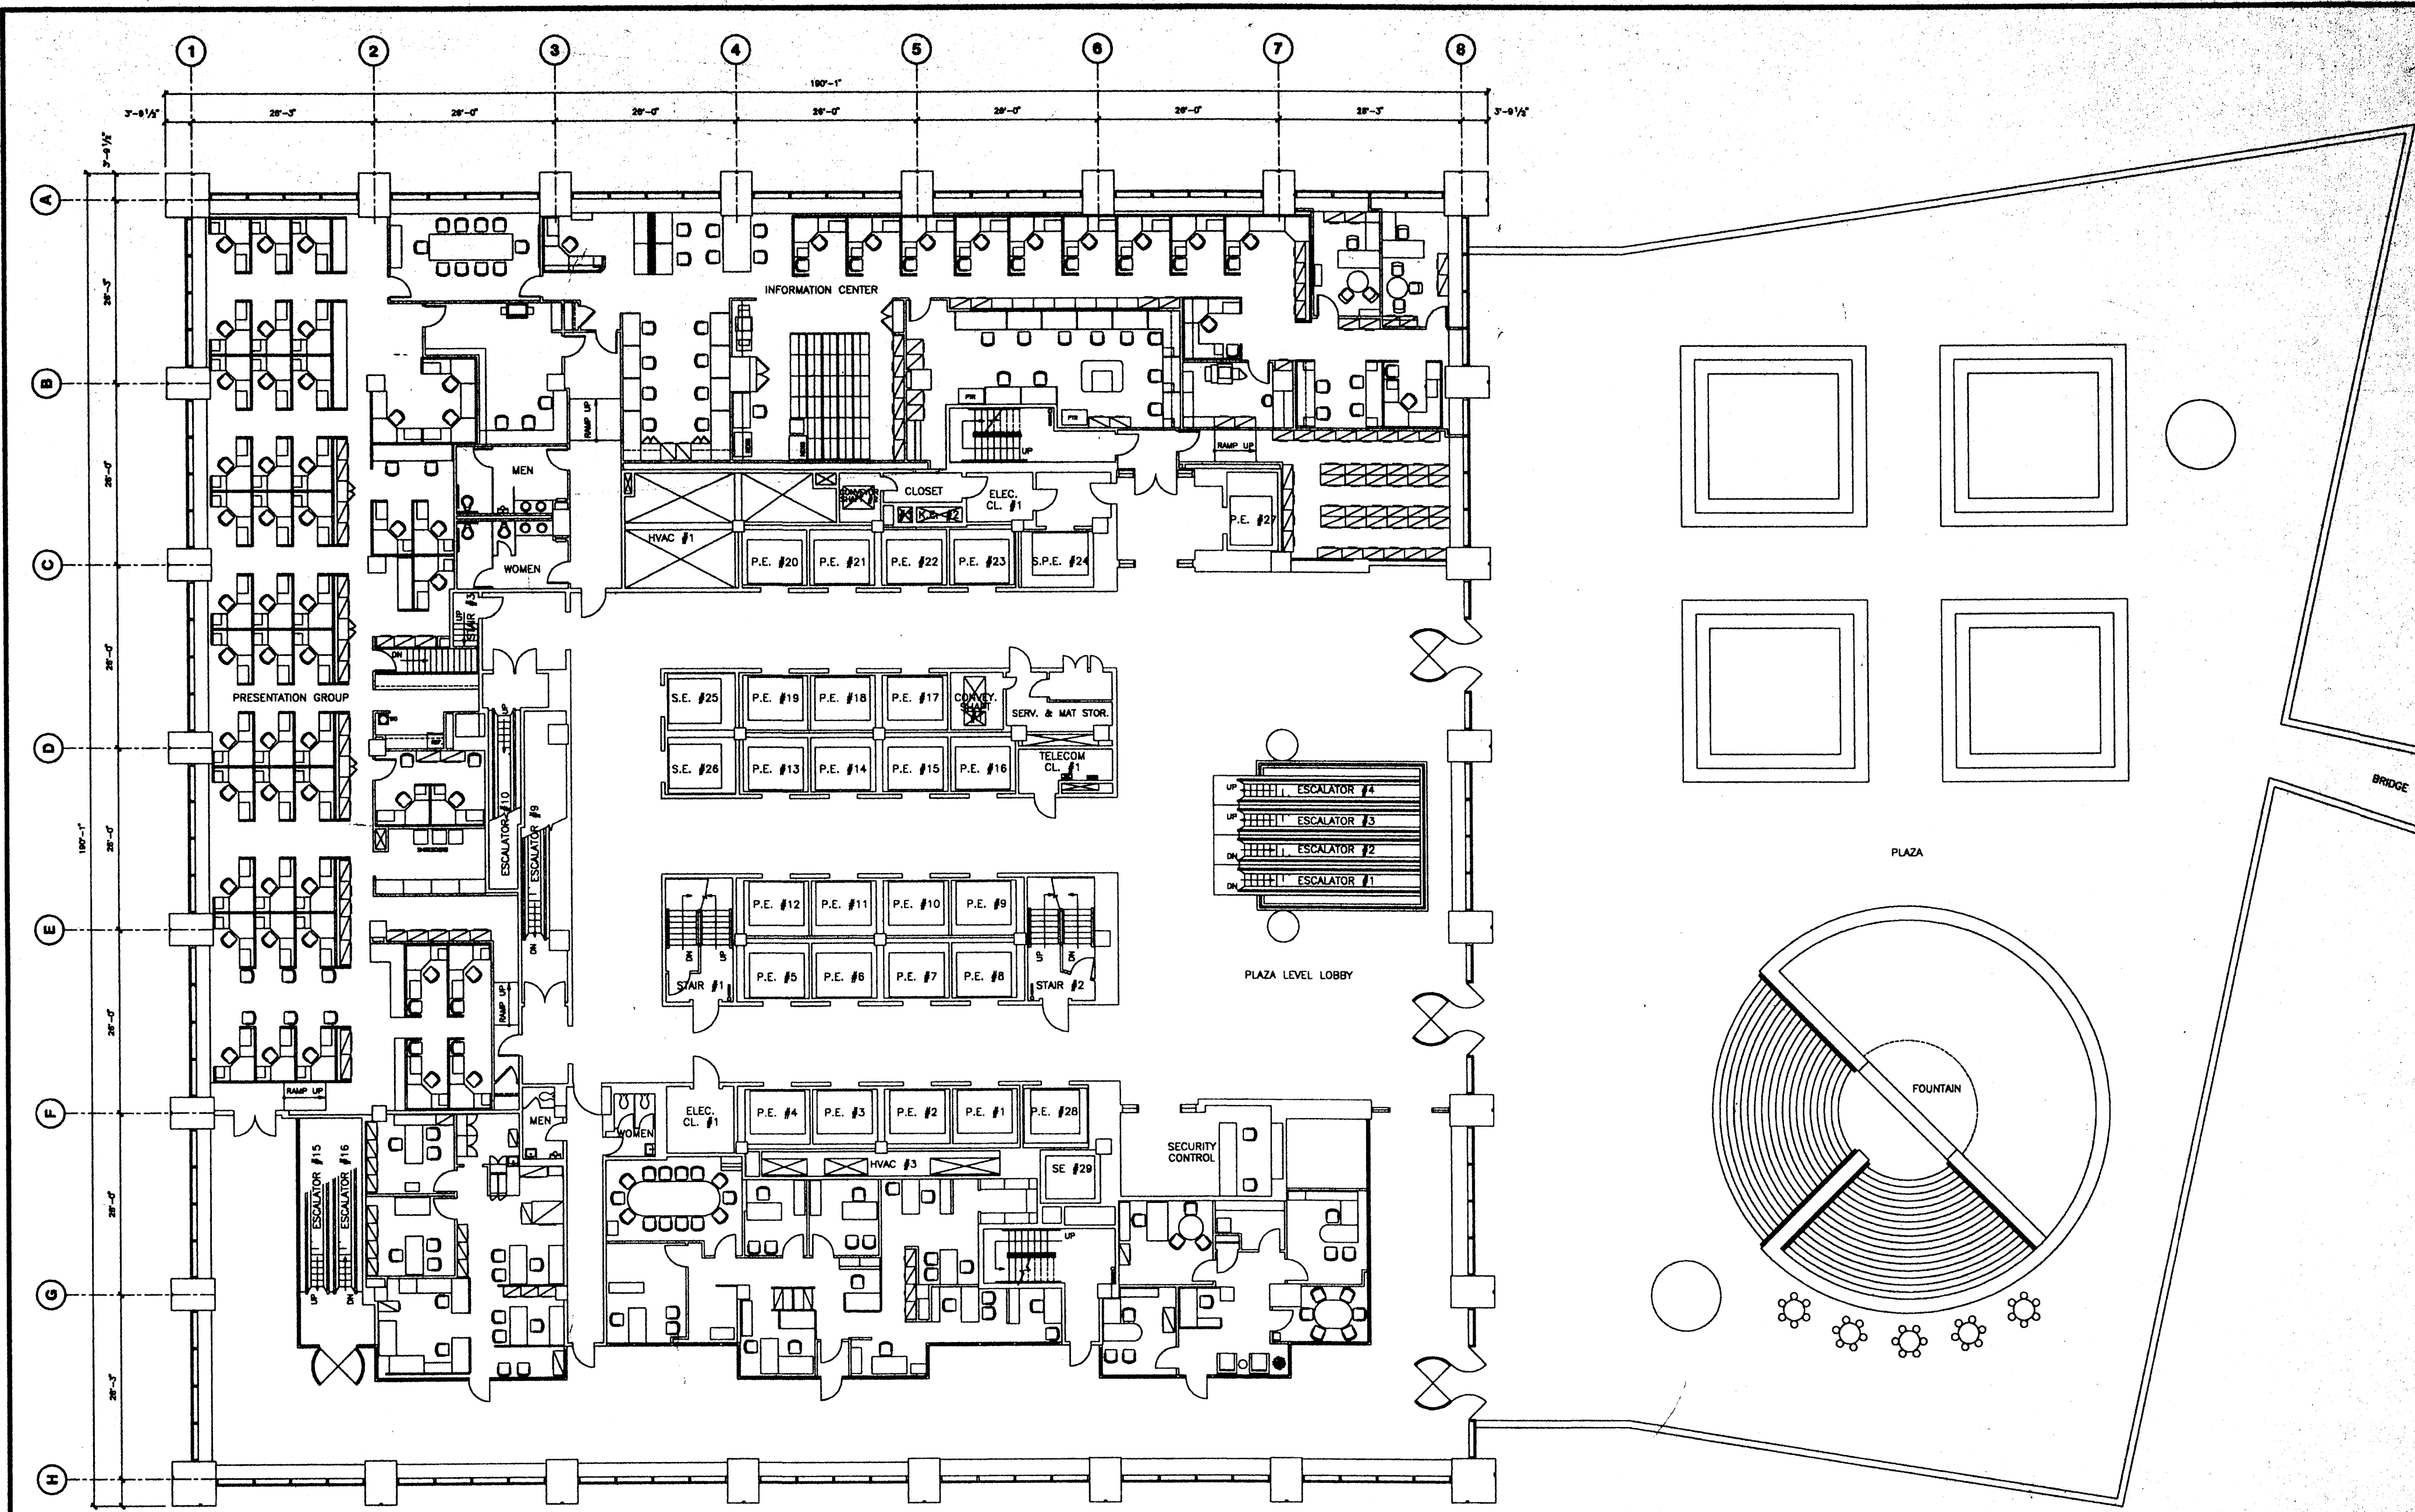

Deutsche Bank
130 LIBERTY STREET
2nd FLOOR

3	7/15/98	Updated for Electric Count Survey	Checked By:
2	8/29/97	Buildout - Project #90000782	Date: 7/15/98
1	11/18/93	Add Stairs to Third Floor	Author:
			Project No.:

